


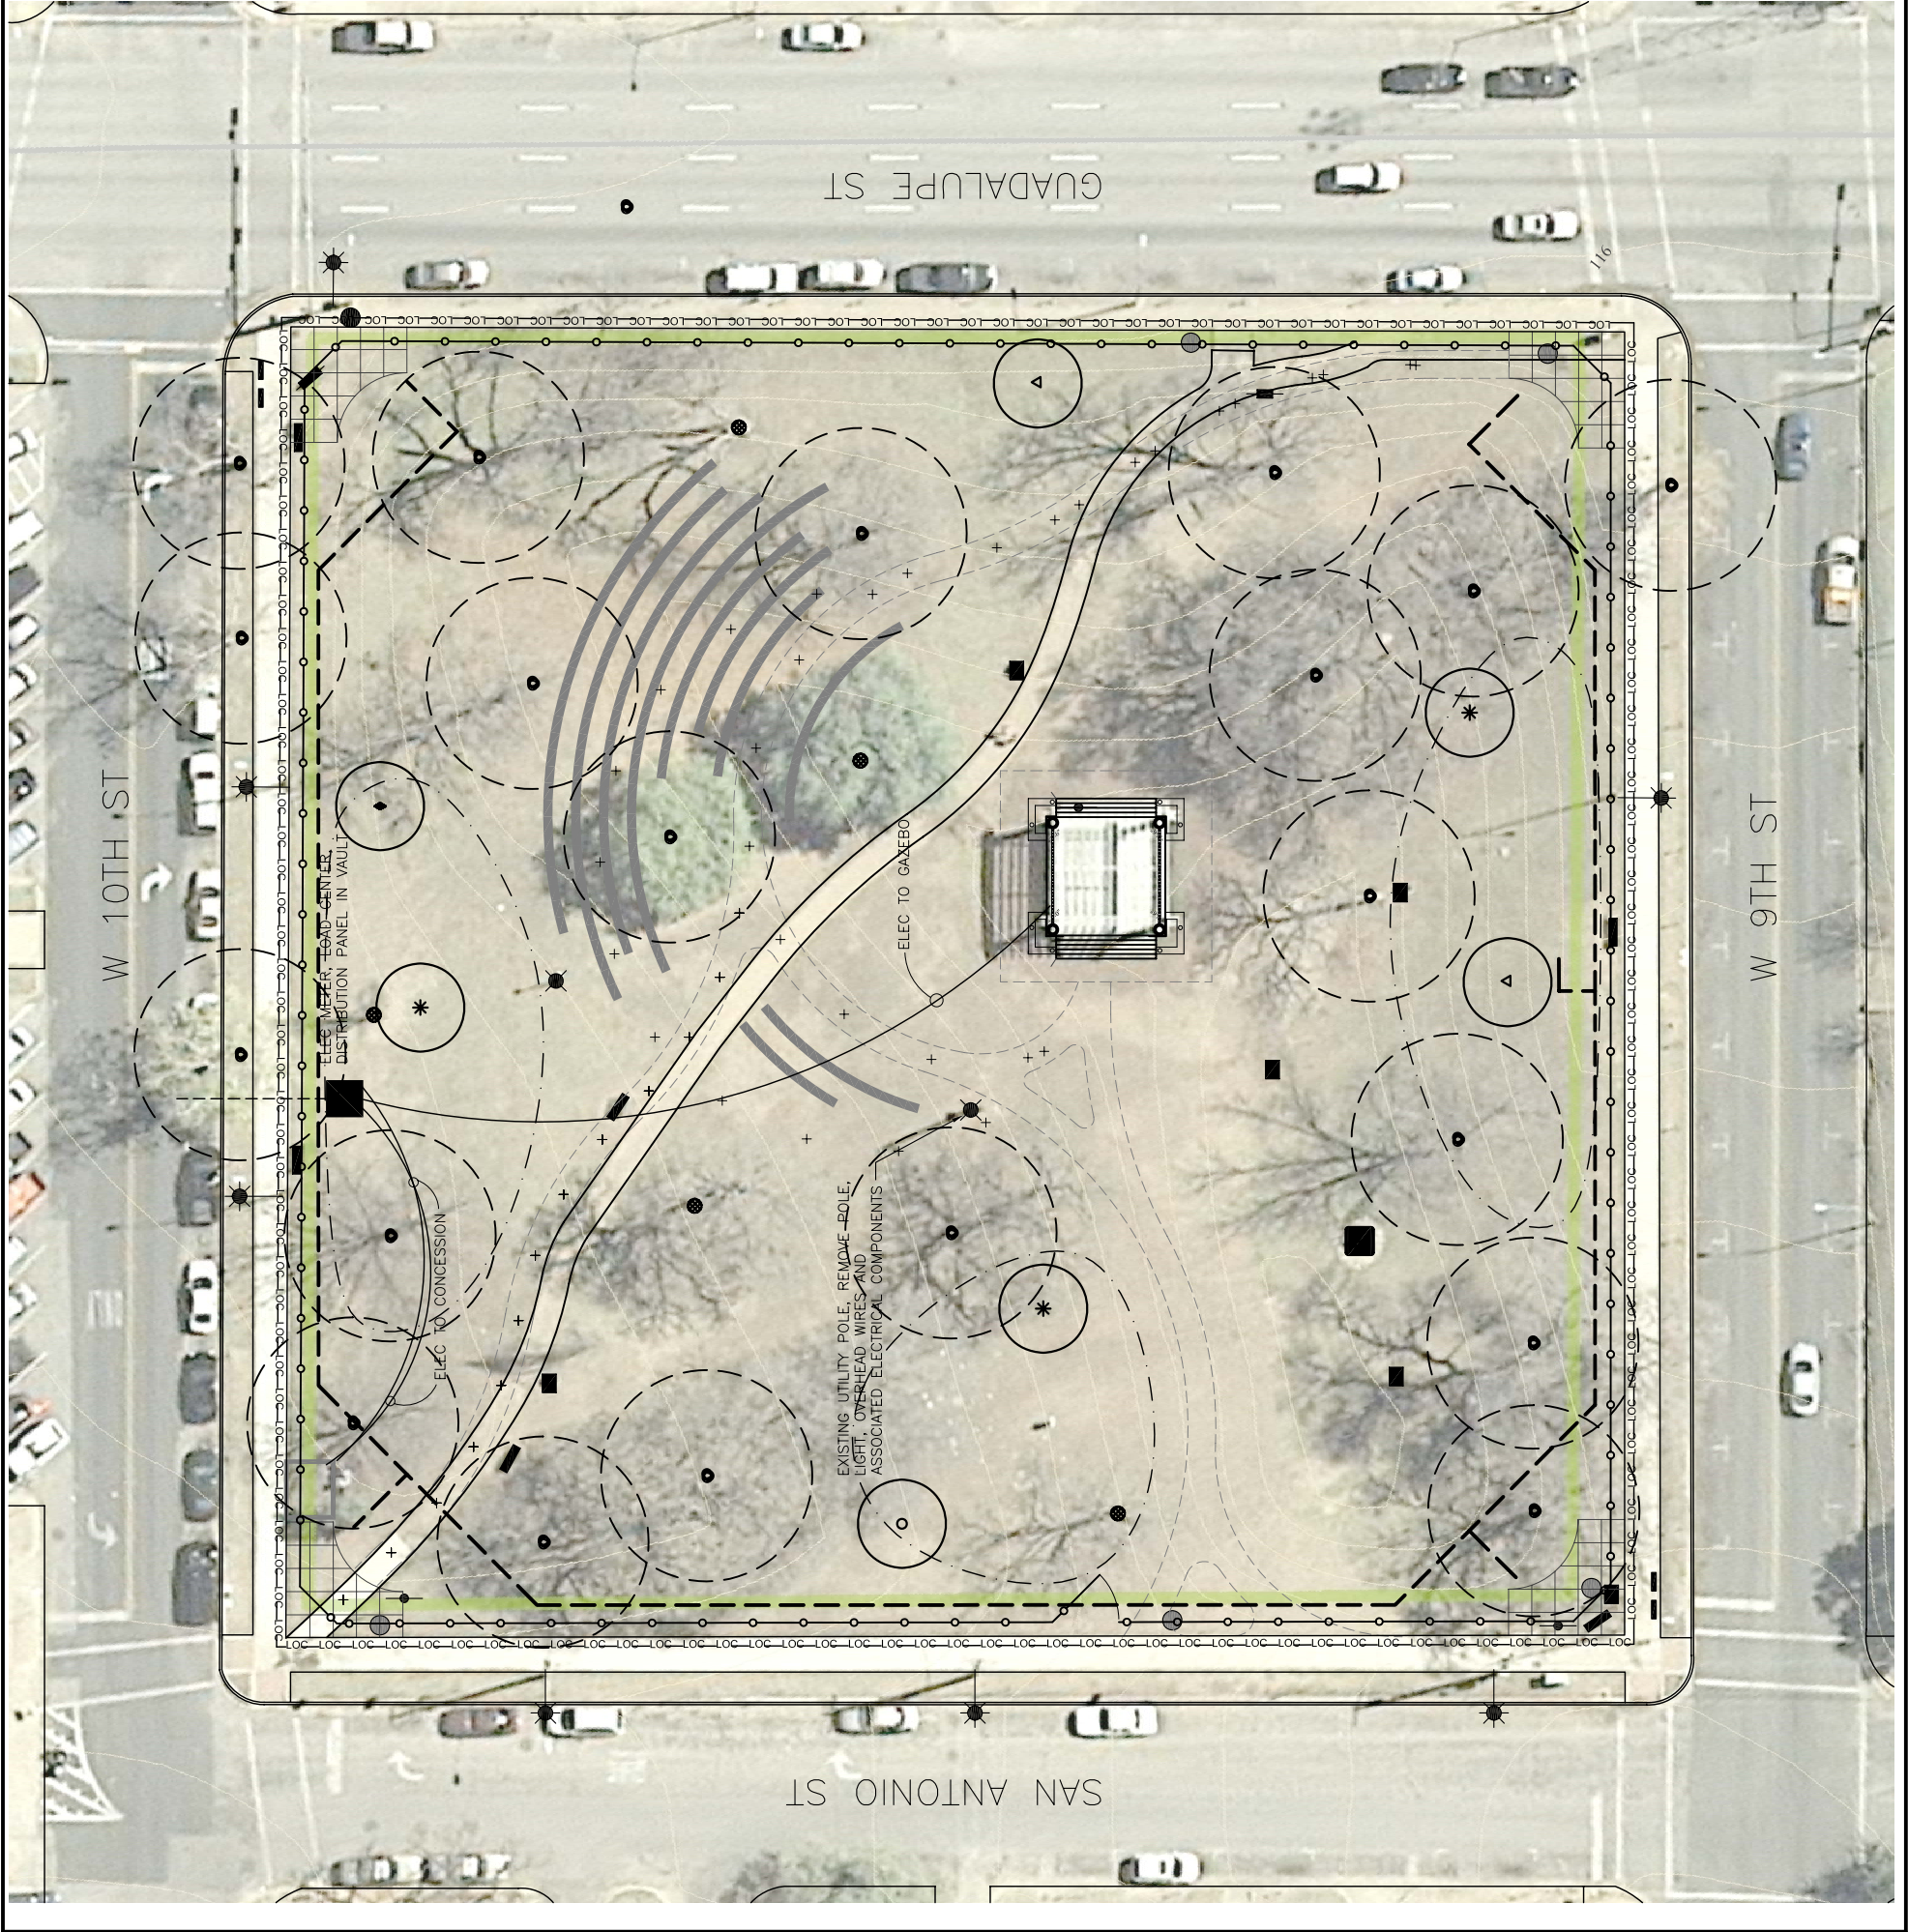

EXISTING SITE EQUIPMENT

- EXISTING TRASH COFFIN (REMOVE)
- EXISTING TRASH CAN (GREAT STREETS)
- EXISTING BENCH (REPLACE/RE-INSTALL)
- EXISTING STREET LIGHT
- EXISTING POLE LIGHT
- EXISTING BICYCLE RACK
- EXISTING PARK SIGN
- EXISTING CURFEW SIGN
- EXISTING HISTORIC MARKER
- DRINKING FOUNTAIN (PARTIAL REMNANT)

ELECTRICAL IMPROVEMENTS (PROPOSED)

- NEW ELECTRICAL SERVICE ENTRY AT NORTH OF SITE, UNDERGROUND, CONNECTING TO EXISTING DISTRIBUTION GRID. DESIGN OF SERVICE BY AUSTIN ENERGY.
- NEW ELECTRIC SERVICE AND LOAD CENTER TO BE NEATLY CONCEALED IN ABOVE GROUND, LOCKING STEEL VAULT.
- SERVICE TO BE OF AMPLE VOLTAGE, PHASE AND AMPERAGE, DESIGNED BY AUSTIN ENERGY TO GENERALLY PROVIDE POWER TO SITE IMPROVEMENTS, INCLUDING BUT NOT LIMITED TO:
 - ACCESSORY ELECTRIC (PLUGS) AT PERGOLA
 - LIGHTING AT PERGOLA (EXISTING AND IMPROVED)
 - LIMITED PARK LIGHTING (ORNAMENTAL PATH LIGHTING -IRRIGATION CONTROLLER
 - ELEC SUPPLY TO VENDOR/CONCESSION LOCATION
 - POWER SUPPLY FOR SPECIAL EVENTS
 - POWER TO DRINKING FOUNTAINS (CHILLERS)
 - POSSIBLE FUTURE POWER SUPPLY FOR IMPROVEMENTS IN R.O.W. (GREAT STREETS, CAP. METRO SHELTERS, ETC)



REVISIONS	DIRECTOR Sara Hensley	DIVISION MANAGER Ricardo Soliz	PARK DEVELOPMENT COORDINATOR Marty Stump	LANDSCAPE ARCHITECT Marty Stump	DRAWN BY DW
APPROVED					
SCALE	AS NOTED	DATE	03/20/12	SHEET	1.1
WOOLBRIDGE SQUARE					2 of 4
SITE UTILITY PLAN					

