


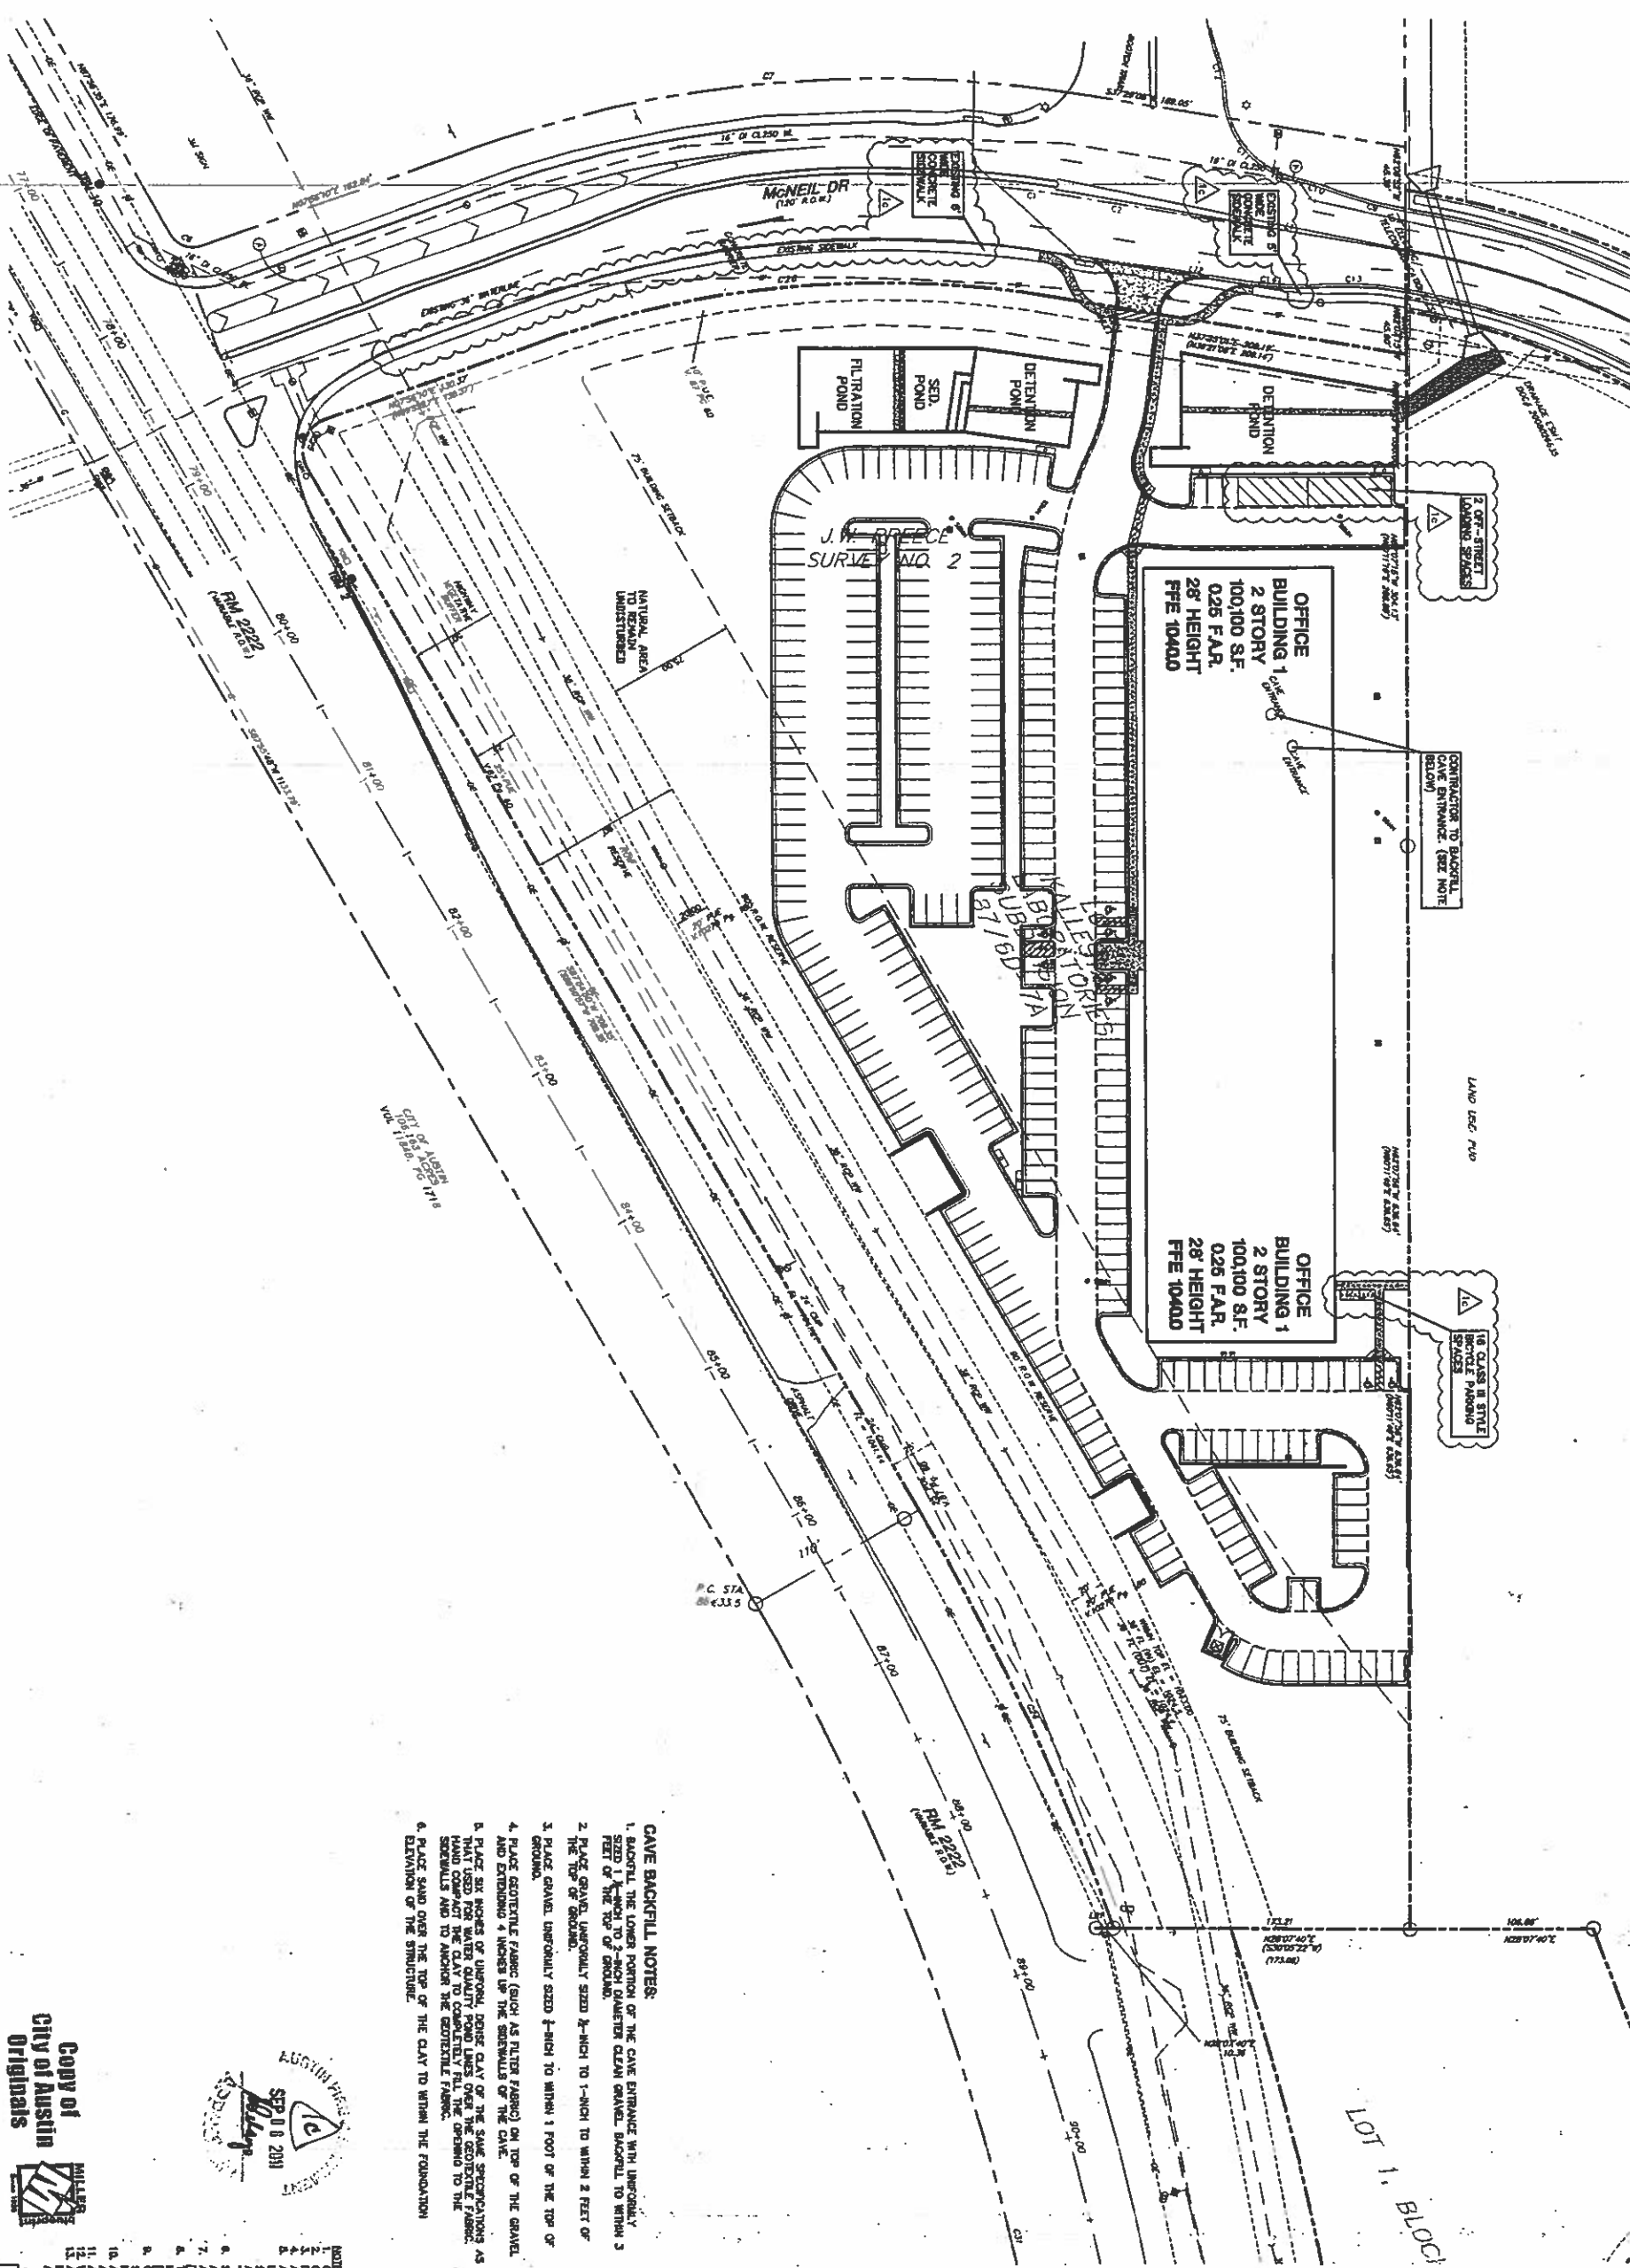

CAVE BACKFILL NOTES:

1. BACKFILL THE LOWER PORTION OF THE CAVE ENTRANCE WITH UNGRAVELLED FILL TO THE TOP OF ANCHOR PLATE. (DO NOT OVERFILL) BACKFILL TO WITHIN 2 FEET OF THE TOP OF ANCHOR.
2. PLACE GRAVEL, UNGRAVELLED, SIZED 2-INCH TO 1-INCH TO WITHIN 2 FEET OF THE TOP OF ANCHOR.
3. PLACE GRAVEL, UNGRAVELLED, SIZED 2-INCH TO WITHIN 1 FOOT OF THE TOP OF ANCHOR.
4. PLACE GEOTEXTILE FABRIC (SUCH AS FILTER FABRIC) ON TOP OF THE ANCHOR AND EXTENDING 4 INCHES ON THE SIDEWALLS OF THE CAVE.
5. PLACE SIX INCHES OF QUALITY, DENSE CLAY OF THE SAME SPECIFIC GRAVITY HAND COMPACTION THE CLAY TO COLLECTED FROM THE SAME SOURCE AS THE SIDEWALL AND TO ANCHOR THE GEOTEXTILE FABRIC.
6. PLACE SAND OVER THE TOP OF THE CLAY TO WITHIN THE FOUNDATION ELEVATION OF THE STRUCTURE.

**Copy of
City of Austin
Originals**

[illegible]

PROPERTY (I.O.U.) LINE	PROPOSED	EXISTING
RECEIPT OF INFORMATION	★	★
POWER POLE	□	□
DOOR GUY	+	+
TRANSFORMER (SIZE VARS)	◇	◇
FIRE HYDRANT	◇	◇
WATER VALVE	◇	◇
WATER METER	◇	◇
WATER METER VALVE	◇	◇
TELEPHONE CESS	◇	◇
CABLE TV RECES	◇	◇
ELECTRIC BOX	◇	◇
TELEPHONE METER	◇	◇
OLD VALVE	◇	◇
TRAFFIC CONTROL BOX	◇	◇
TELEPHONE METER	◇	◇
CRANE MOUNT (SIZE VARS)	◇	◇
CRANE MOUNT (SIZE VARS)	◇	◇
WOOD TRUCK	◇	◇
WOOD TRUCK	◇	◇
CHAIN LINK FENCE	◇	◇
OVERHEAD ELECTRIC	◇	◇
ELECTRIC MOUNT (SIZE VARS)	◇	◇
WATERVALVE MOUNT (SIZE VARS)	◇	◇
STREETLIGHT MOUNT (SIZE VARS)	◇	◇
TELEPHONE MOUNT (SIZE VARS)	◇	◇
DUMPSTER	◇	◇
TRASH COLLECTION	◇	◇
CURB & CUTTER	◇	◇
DOE OF PAVEMENT	◇	◇
ONE LANE DISRUPTION	◇	◇
WATERVALVE ACCESS ROUTE	◇	◇
CONCRETE SIGNALS	◇	◇
SENSE STOP	◇	◇
RELATED	◇	◇
PARKING COUNT (REGULAR SPACES)	◇	◇
PARKING COUNT (HANDICAP SPACES)	◇	◇
HANDICAP SPACE	◇	◇
HANDICAP ACCESSIBLE ROUTE	◇	◇
THEY TO BE REMOVED	◇	◇
THEY TO BE SAVED	◇	◇
THEY WANT	◇	◇

LEGEND

05-16-11	1c	REMOVED EXISTING SIDEWALK, REPLACED REGULAR PARKING SPACES WITH 2 OFF-STREET LOADING SPACES, ADDED BIKE PARKING	
DATE	NO.	REVISION	APPROVAL

S H E E T	PLOTTING SCALE: 1" = 1'
	DATE PLOTTED: 09/01/07
	FILE: c:\3356\03\301\PROJECT 1\3356-03.301.DWG
	DRAWN BY: AMI
	DESIGNED BY: DM
	REVIEWED BY: DM
PROJECT NO.: 1356-03.301	

**KALLESTAD LABORATORIES
-PRA SITE PLAN
10010 FM 2222
W2007 RBL RAL ESTATE, L.P.**

MASTER SITE PLAN



Bury+Partners
ENGINEERING SOLUTIONS
221 West Sixth Street, Suite 600
Austin, Texas 78701
Tel. (512)328-0011 Fax (512)328-0325
Bury+Partners, Inc. ©Copyright 2007

SHEE