


11/2/2013 H:\cadd\mcb\Mark Collins\MCB 0008\0008 Mansfield Dam\Plot Sheet\Grading and Drainage Plan.dwg 11/2/2013

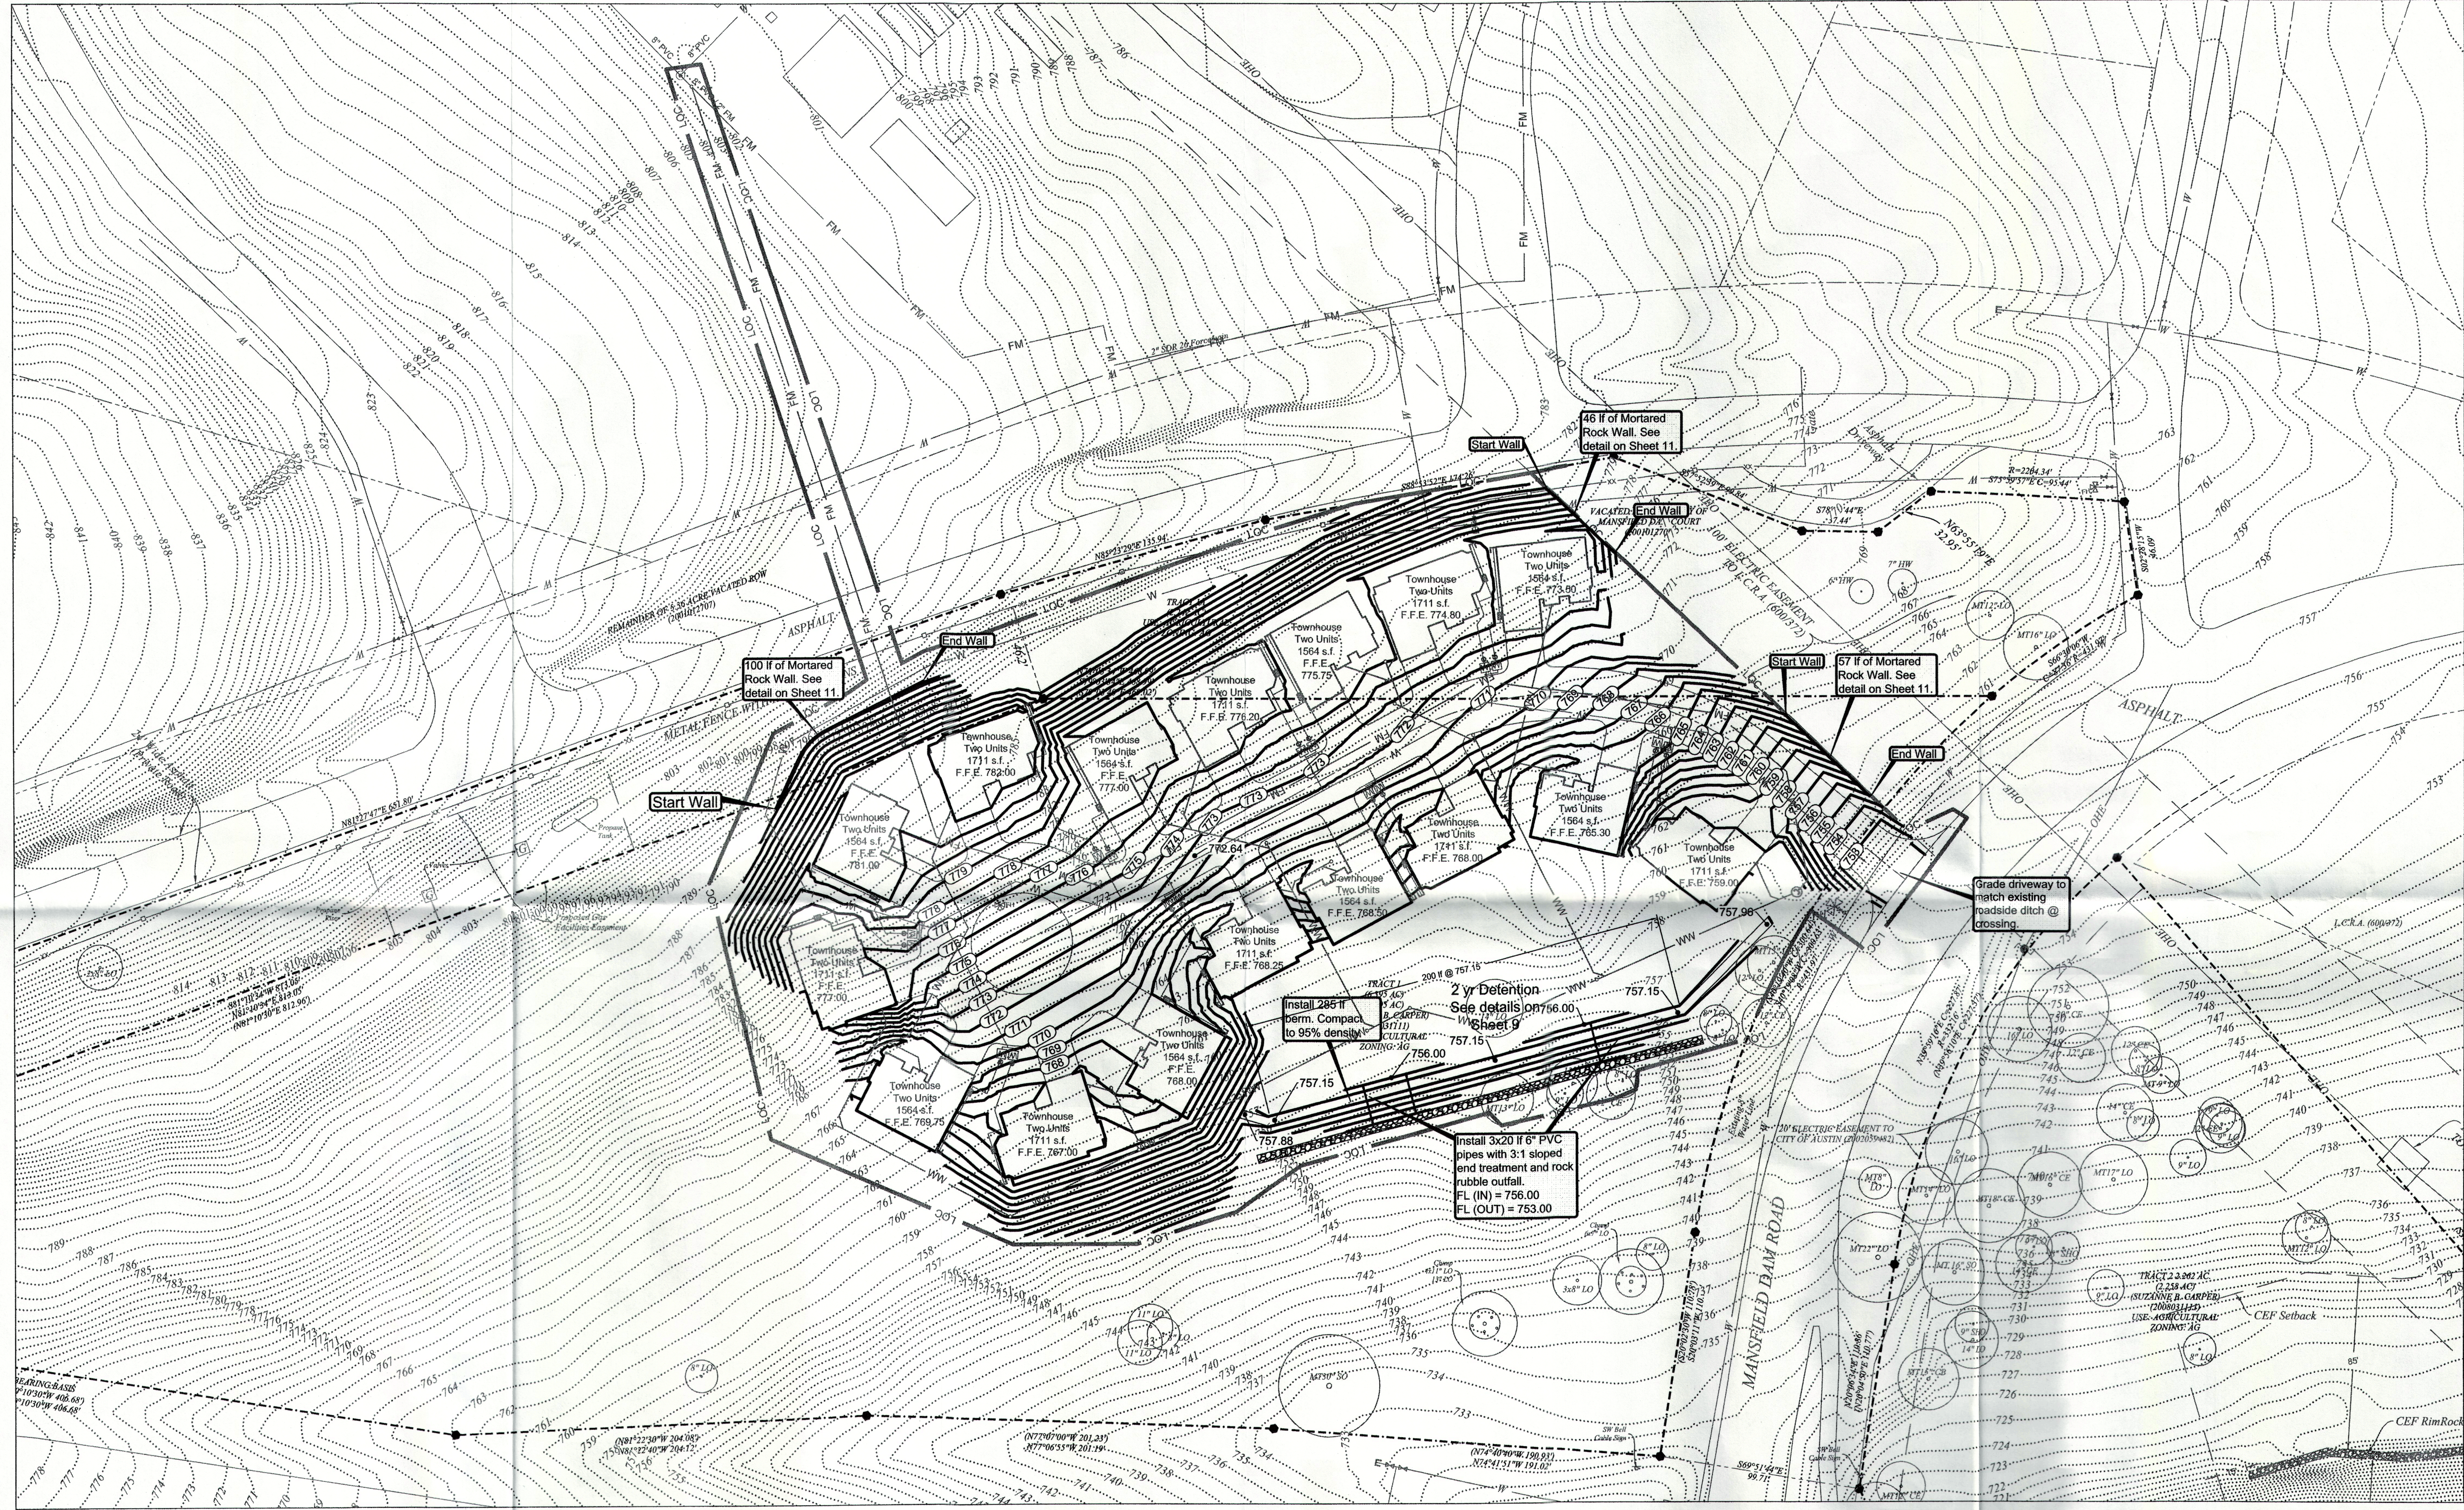

Legend

- 700 Existing Contour
- 700 ----- Proposed Contour
- 698.25 Proposed Spot Elevation
- 700.00 Top of Curb
- 699.50 Bottom of Curb
- LOC --- Proposed Limits of Construction
- ===== Proposed Storm Sewer Line

The location of all existing utilities shown on these plans has been based upon record information only and may not match locations as constructed. The contractor shall contact the Texas Excavation Safety System @ 1-800-344-8377 for assistance in determining existing utility locations prior to beginning construction. Contractor shall field verify locations of water and gas crossings prior to beginning construction.

Release of this application does not constitute a verification of all data, information and calculations supplied by the applicant. The engineer of record is solely responsible for the completeness, accuracy and adequacy of his/her submittal, whether or not the application is reviewed for Code compliance by City engineers.


Scale 1" = 40'

DATE:	March 2013
DESIGNED:	JP
DRAWN:	JP, Luf
CHECKED:	JKR
JOB NO:	MCB 12036

REVISIONS/CORRECTIONS	
NO.	DESCRIPTION

Lakeside Villas I
4300 Mansfield Dam Road
Austin, Texas 78734

GRADING AND DRAINAGE PLAN

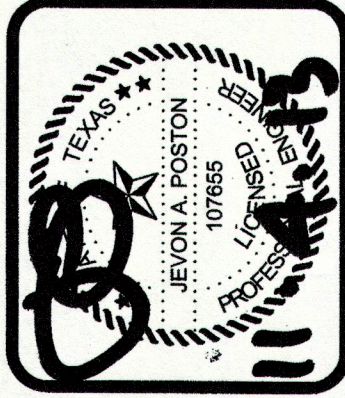

GARRETT-IHNNERS
CIVIL ENGINEERS
12007 TECHNOLOGY BLVD
SUITE 150
AUSTIN, TEXAS 78727
TELEPHONE: (512) 454-2400
FACSIMILE: (512) 454-2420
TBE FIRM NO. F-6590

SHEET NUMBER

7 of 11

SP-2013-0092D