




B2
71

 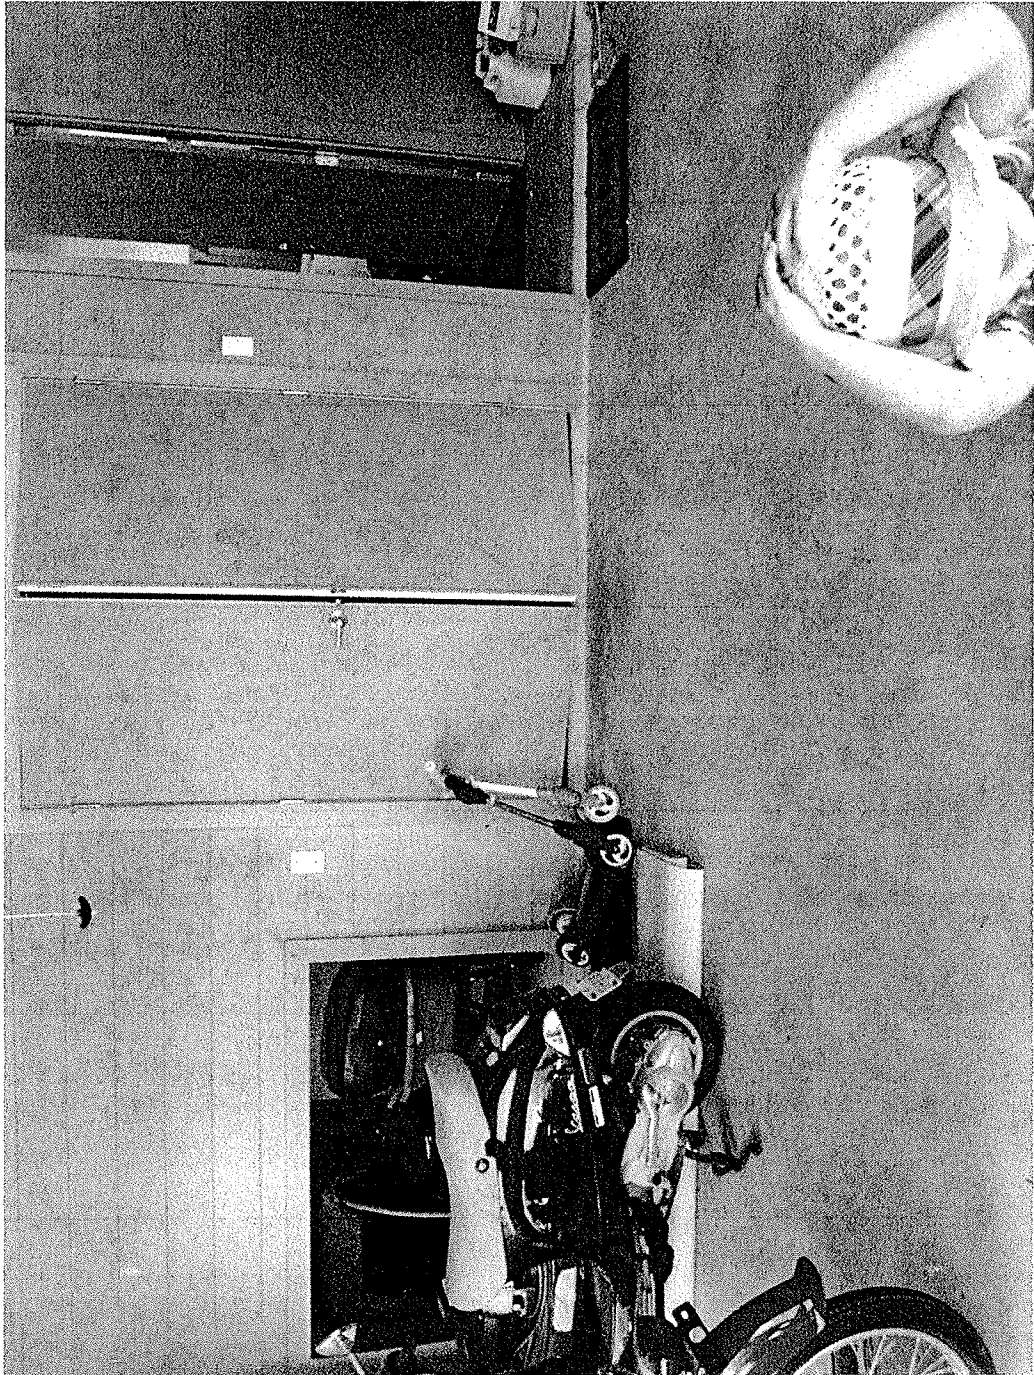


B2
7/2

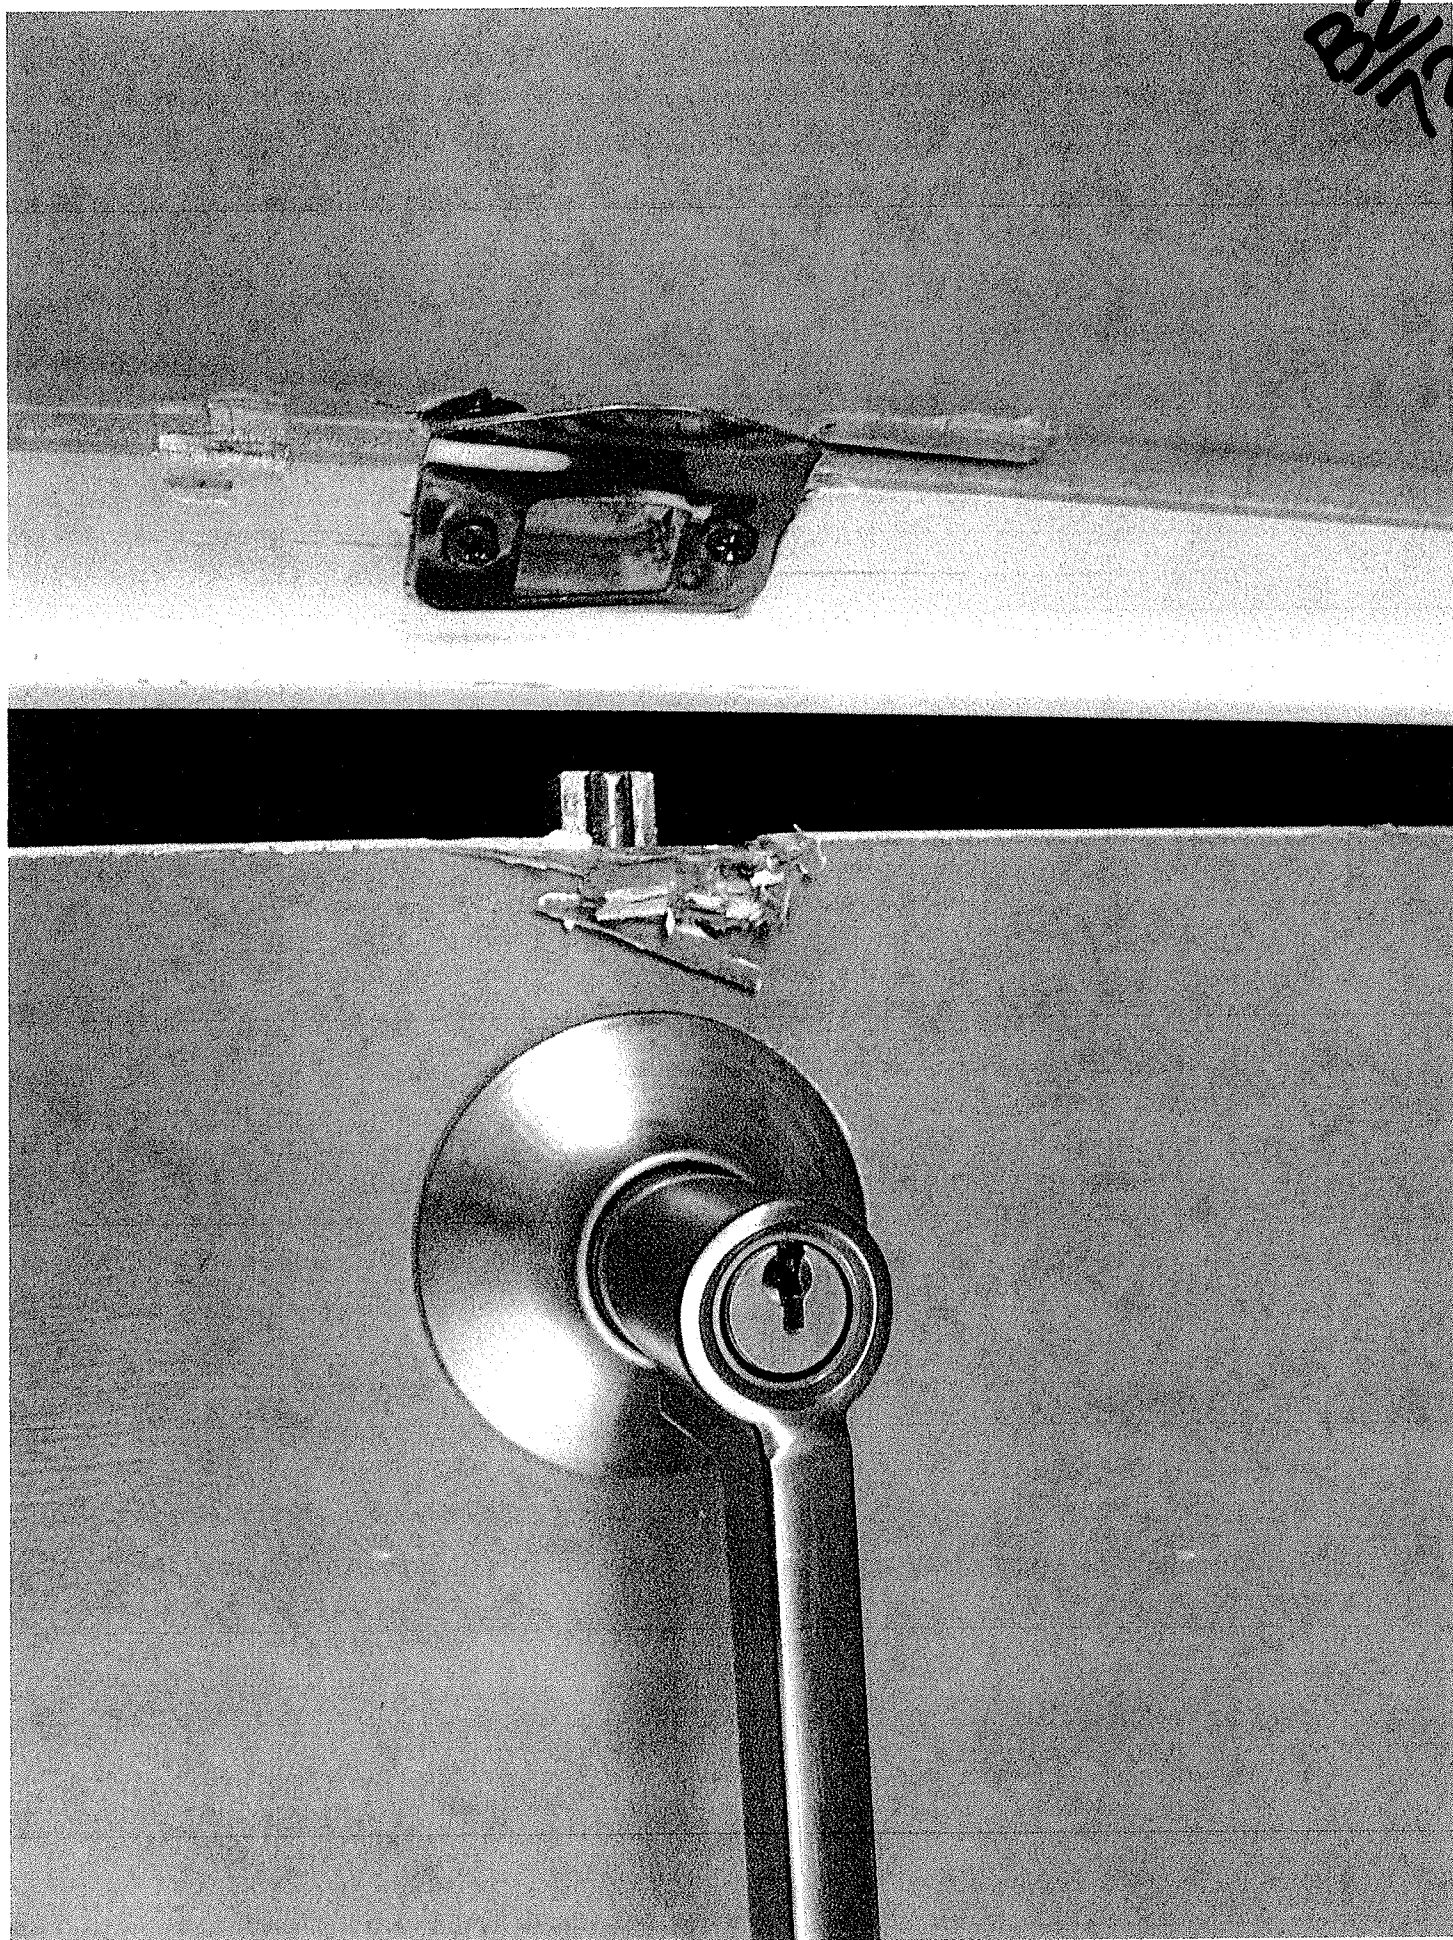

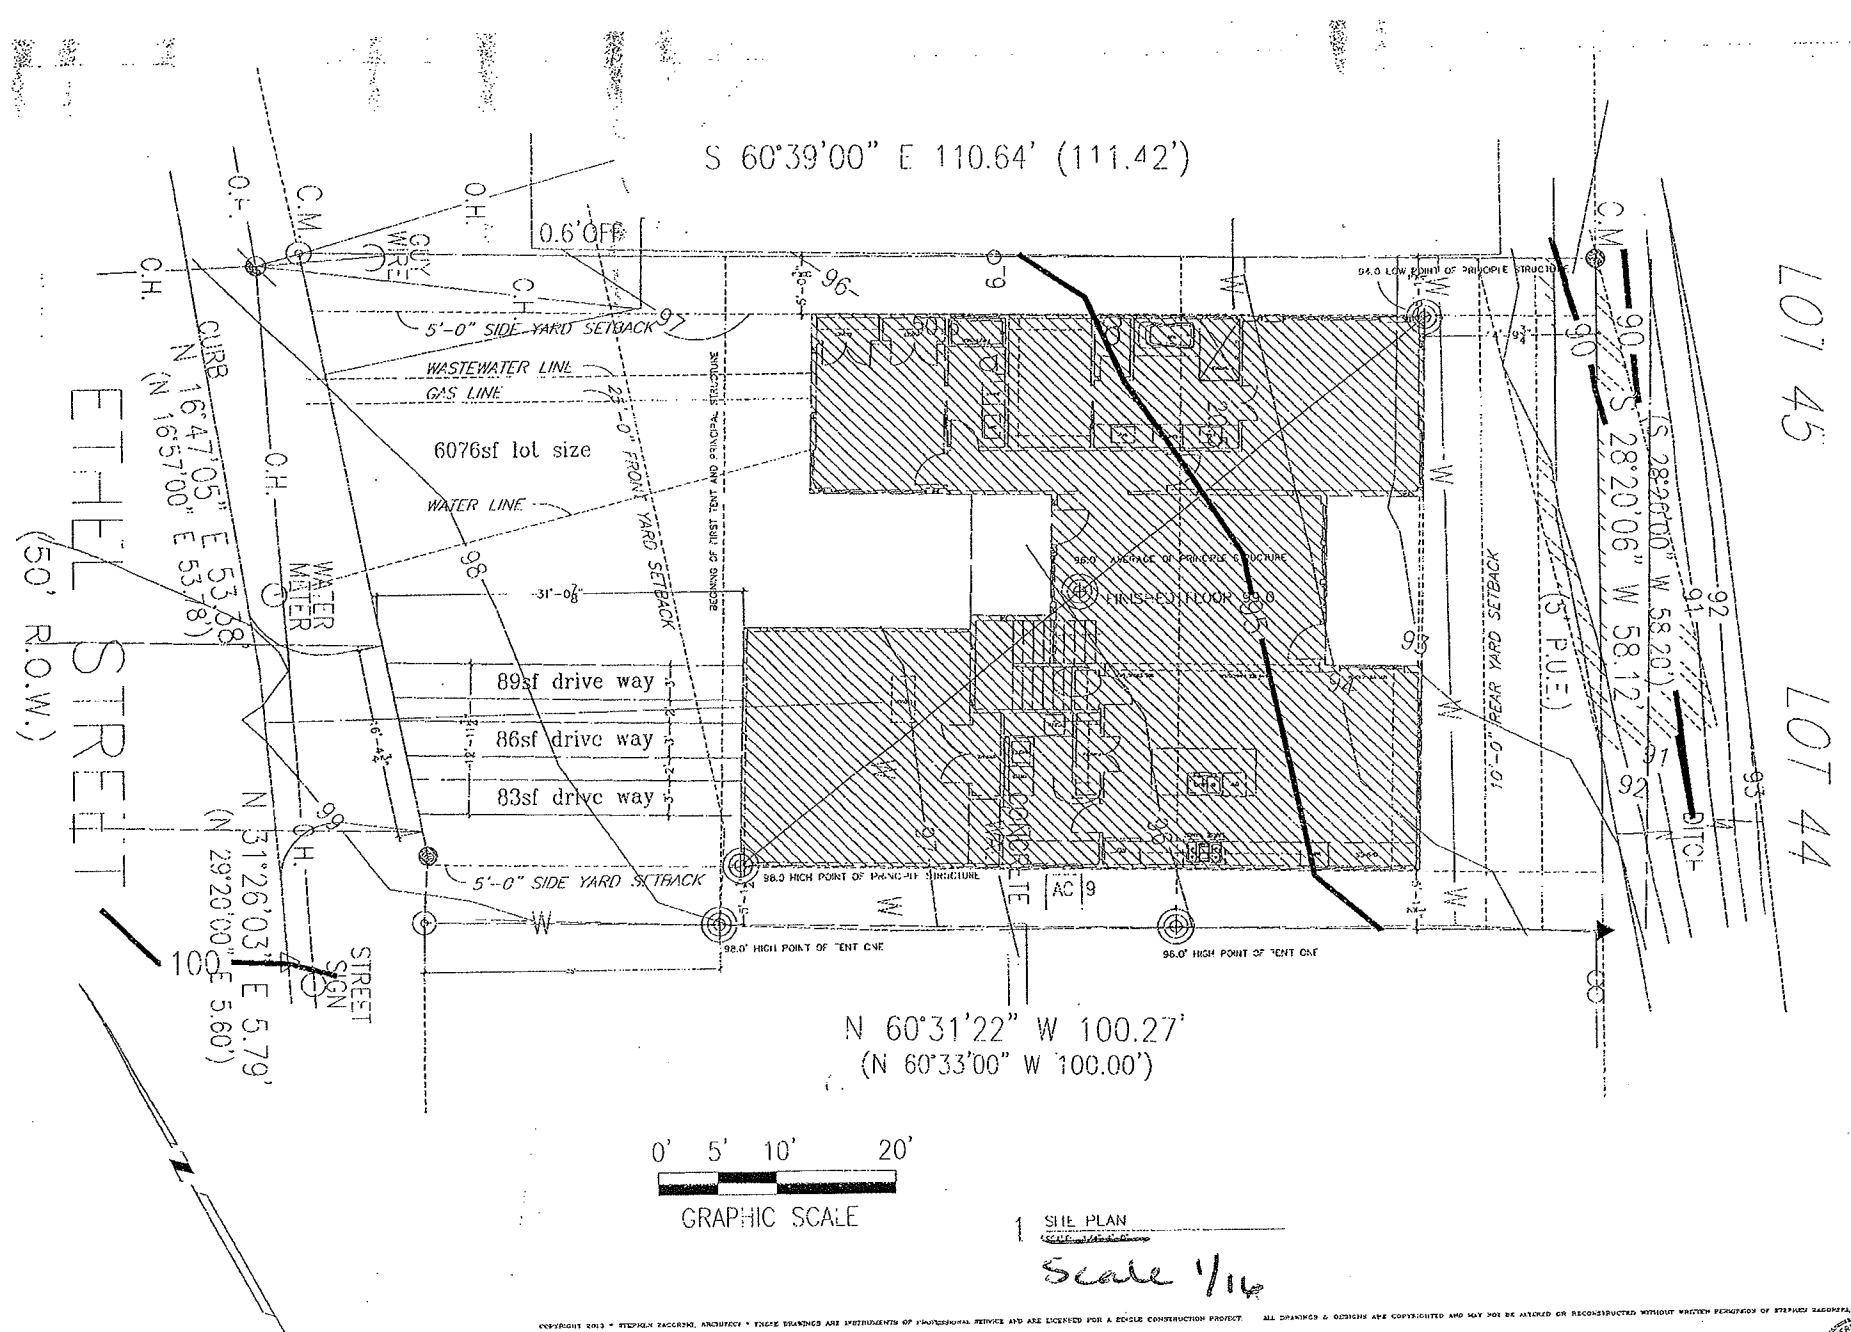

AE APPROVED
MAY 30 2014
150-306
DRB



1 SITE PLAN
~~Scale 1/16"~~
Scale 1/16"


JOB NO. 1216
 DATE 04-25 13
 DRAWN S.T.
 CHECKED S.T.
 SHEET NUMBER
 A-1.0
 OF

MOAZAMI HOMES CUSTOM
903 ETHEL STREET
AUSTIN, TEXAS

Stephen Zagorski, Architect AIA
P.O. Box 50196 Austin, Texas 78763 (512) 789-3259
swzagorski@gmail.com 512-789-3259



B2/15

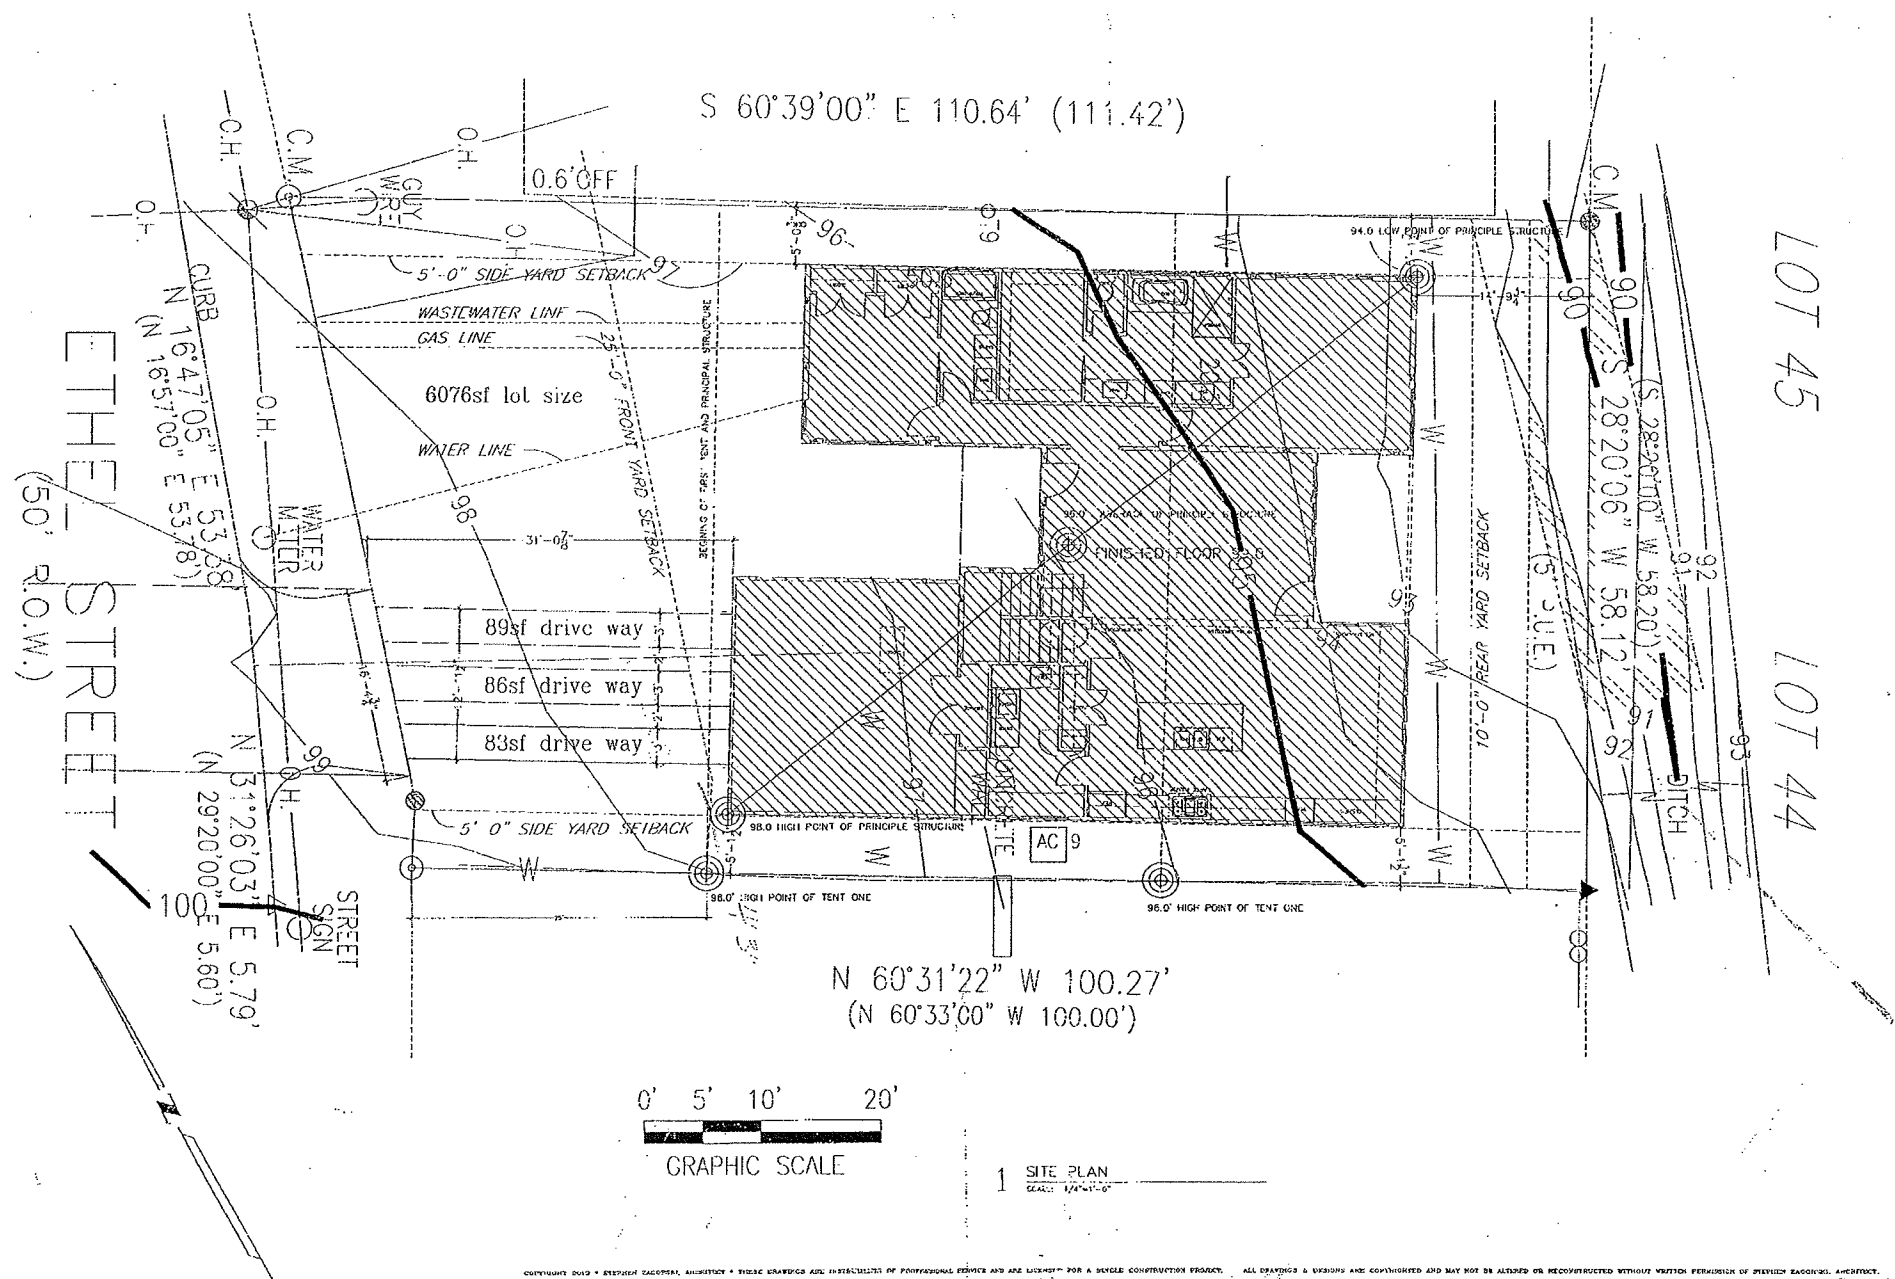

Copyright 2012 Stephen Zagorski, Architect. All rights reserved. This drawing is the property of Stephen Zagorski, Architect and is not to be reproduced or used in any way without the written permission of Stephen Zagorski, Architect. All drawings and designs are copyrighted and may not be altered or reconstructed without written permission of Stephen Zagorski, Architect.


DATE: 04-28-12
DRAWN: SZ
CHECKED: SZ
SCALE: 1/4"=1'-0"
SHEET: A-10

MOAZAMI HOMES CUSTOM
903 ETHEL STREET
AUSTIN, TEXAS

Stephen Zagorski, Architect AIA
P.O. Box 50196 Austin, Texas 78763 (512) 789-3259
szagorski@gmail.com 512-789-3259



B2
76

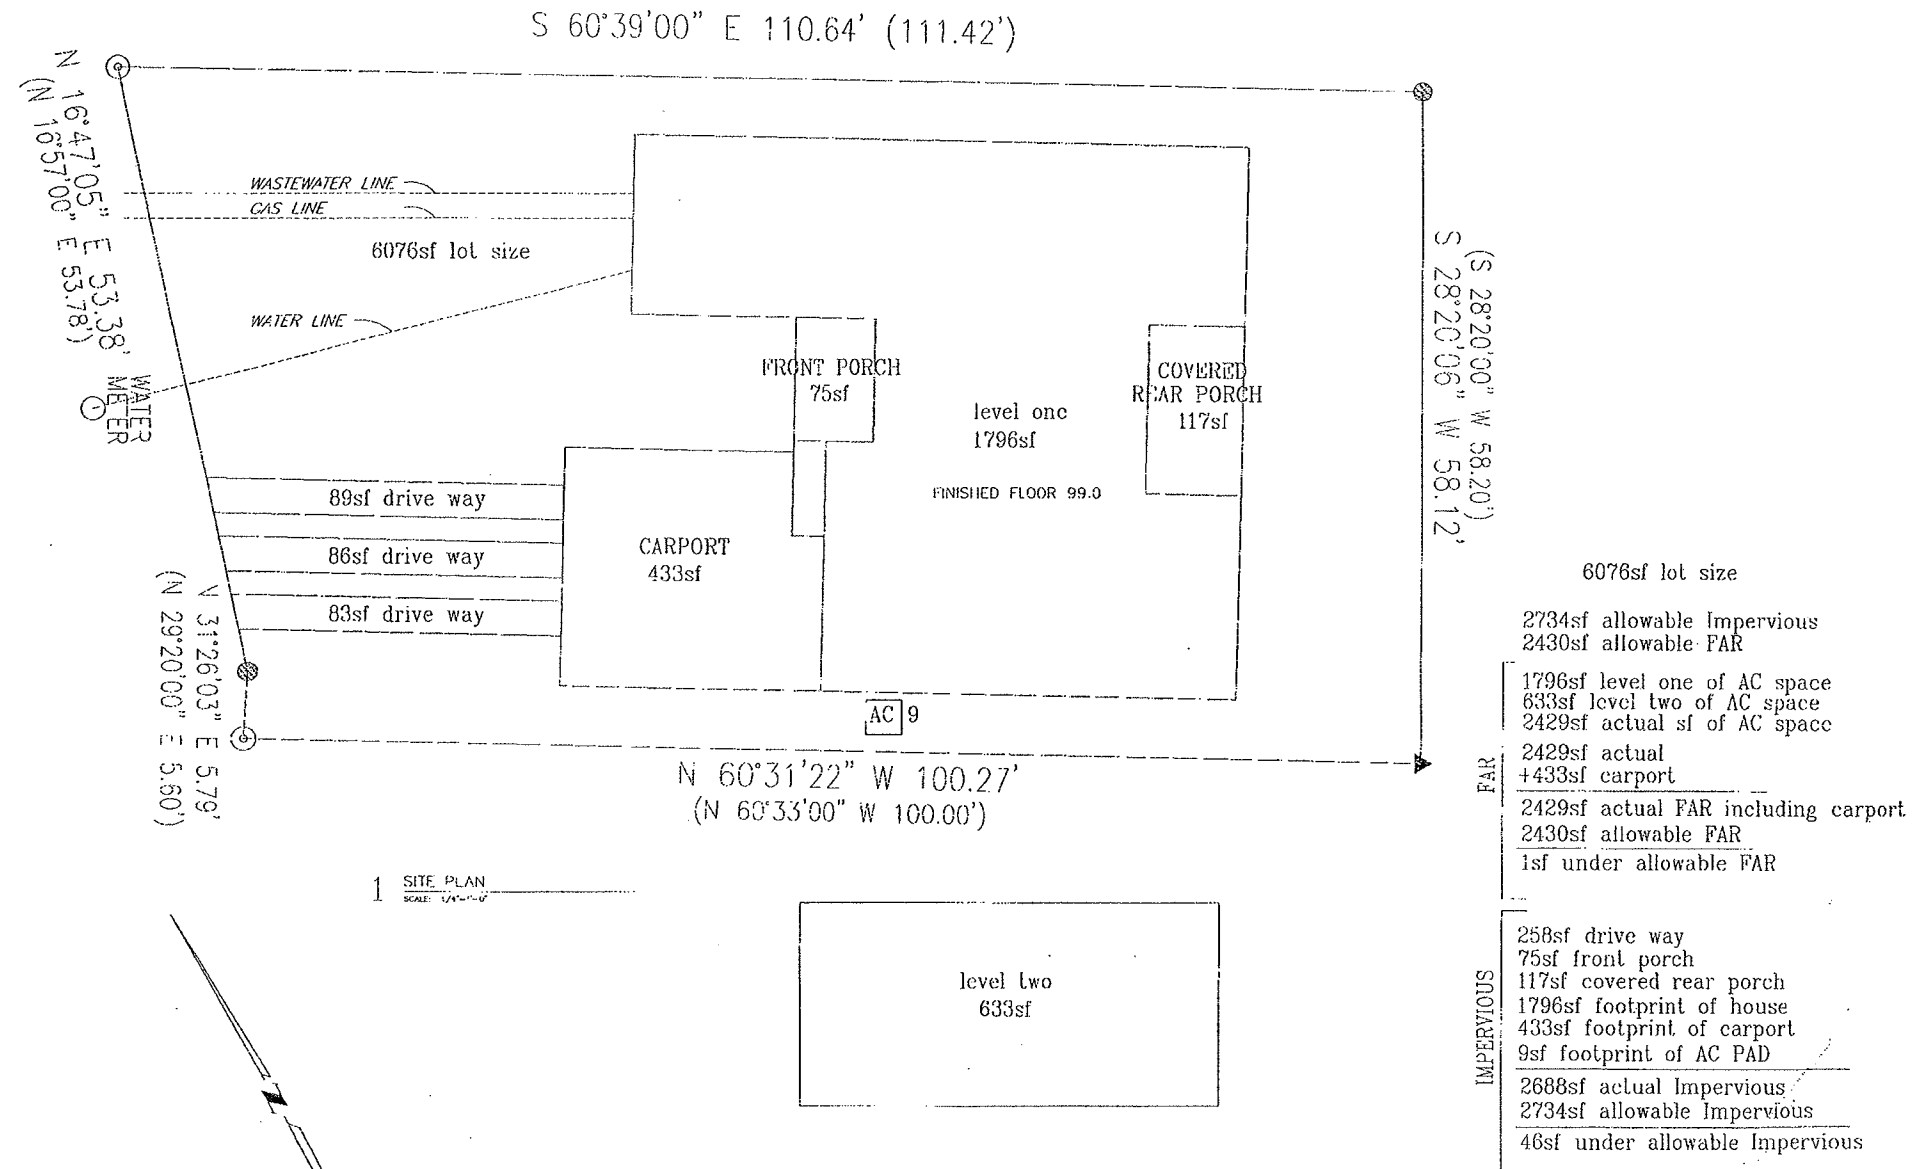

EXCEPT AS NOTED, THIS PLAN IS THE PROPERTY OF STEPHEN ZAGORSKI, ARCHITECT. IT IS TO BE USED ONLY FOR THE PROJECT AND SITE SPECIFICALLY IDENTIFIED HEREON. IT IS NOT TO BE REPRODUCED, COPIED, OR TRANSMITTED IN ANY FORM OR BY ANY MEANS, ELECTRONIC OR MECHANICAL, INCLUDING PHOTOCOPYING, RECORDING, OR BY ANY INFORMATION STORAGE AND RETRIEVAL SYSTEM, WITHOUT THE WRITTEN PERMISSION OF STEPHEN ZAGORSKI, ARCHITECT.

208 NO. 128
DATE: 04-25-10
DRAWN: S.S.
CHECKED: S.S.
REVISION: NONE
A-1.1


MOAZAMI HOMES CUSTOM
903 ETHEL STREET
AUSTIN, TEXAS

Stephen Zagorski, Architect AIA

P.O. Box 50196 Austin, Texas 78763 (512) 789-3259
szzagorski@gmail.com 512-789-3259




B2
T7

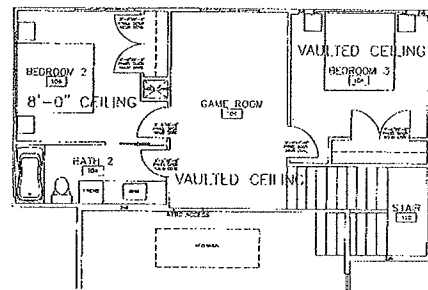


4 SYMBOLS PLAN LEVEL TWO
SCALE: 1/4"=1'-0"


ELECTRICAL LEGEND	
ELECTRICAL LIGHTING SYMBOLS	
1. DOWN LIGHT	10. DOWN LIGHT
2. DOWN LIGHT	11. DOWN LIGHT
3. DOWN LIGHT	12. DOWN LIGHT
4. DOWN LIGHT	13. DOWN LIGHT
5. DOWN LIGHT	14. DOWN LIGHT
6. DOWN LIGHT	15. DOWN LIGHT
7. DOWN LIGHT	16. DOWN LIGHT
8. DOWN LIGHT	17. DOWN LIGHT
9. DOWN LIGHT	18. DOWN LIGHT
19. DOWN LIGHT	20. DOWN LIGHT
21. DOWN LIGHT	22. DOWN LIGHT
23. DOWN LIGHT	24. DOWN LIGHT
25. DOWN LIGHT	26. DOWN LIGHT
27. DOWN LIGHT	28. DOWN LIGHT
29. DOWN LIGHT	30. DOWN LIGHT
31. DOWN LIGHT	32. DOWN LIGHT
33. DOWN LIGHT	34. DOWN LIGHT
35. DOWN LIGHT	36. DOWN LIGHT
37. DOWN LIGHT	38. DOWN LIGHT
39. DOWN LIGHT	40. DOWN LIGHT
41. DOWN LIGHT	42. DOWN LIGHT
43. DOWN LIGHT	44. DOWN LIGHT
45. DOWN LIGHT	46. DOWN LIGHT
47. DOWN LIGHT	48. DOWN LIGHT
49. DOWN LIGHT	50. DOWN LIGHT
51. DOWN LIGHT	52. DOWN LIGHT
53. DOWN LIGHT	54. DOWN LIGHT
55. DOWN LIGHT	56. DOWN LIGHT
57. DOWN LIGHT	58. DOWN LIGHT
59. DOWN LIGHT	60. DOWN LIGHT
61. DOWN LIGHT	62. DOWN LIGHT
63. DOWN LIGHT	64. DOWN LIGHT
65. DOWN LIGHT	66. DOWN LIGHT
67. DOWN LIGHT	68. DOWN LIGHT
69. DOWN LIGHT	70. DOWN LIGHT
71. DOWN LIGHT	72. DOWN LIGHT
73. DOWN LIGHT	74. DOWN LIGHT
75. DOWN LIGHT	76. DOWN LIGHT
77. DOWN LIGHT	78. DOWN LIGHT
79. DOWN LIGHT	80. DOWN LIGHT
81. DOWN LIGHT	82. DOWN LIGHT
83. DOWN LIGHT	84. DOWN LIGHT
85. DOWN LIGHT	86. DOWN LIGHT
87. DOWN LIGHT	88. DOWN LIGHT
89. DOWN LIGHT	90. DOWN LIGHT
91. DOWN LIGHT	92. DOWN LIGHT
93. DOWN LIGHT	94. DOWN LIGHT
95. DOWN LIGHT	96. DOWN LIGHT
97. DOWN LIGHT	98. DOWN LIGHT
99. DOWN LIGHT	100. DOWN LIGHT

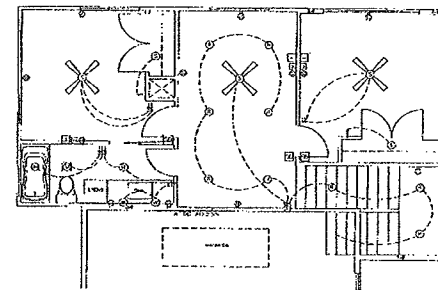

2 ELECTRICAL PLAN LEVEL TWO
SCALE: 1/4"=1'-0"

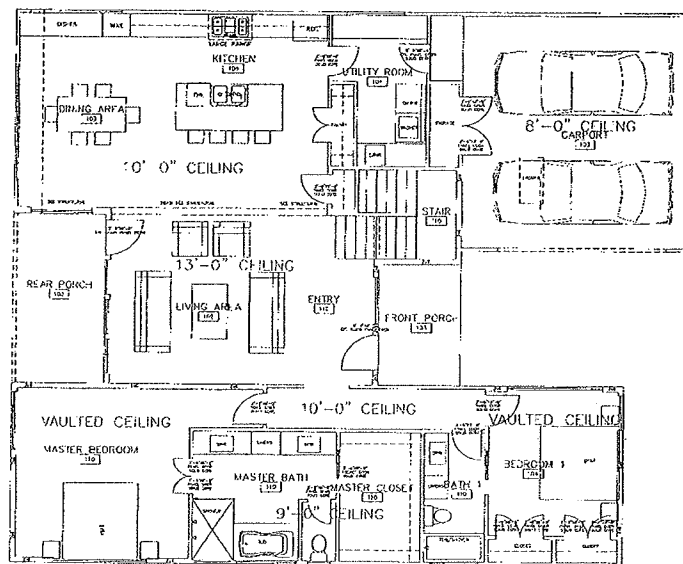

3 SYMBOLS PLAN LEVEL ONE
SCALE: 1/4"=1'-0"

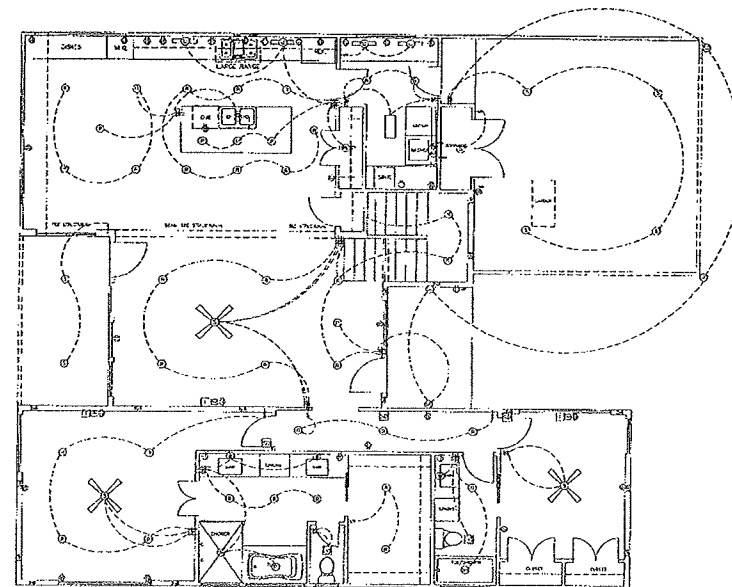

1 ELECTRICAL PLAN LEVEL ONE
SCALE: 1/4"=1'-0"




Stephen Zagorski, Architect AIA
P.O. Box 50186 Austin, Texas 78765 (512) 788-3239
szagorski@mail.com 512-788-3239



MOAZAMI HOMES CUSTOM
903 ETHEL STREET
AUSTIN, TEXAS

JOB NO. 1210
DATE 04-28-13
DRAWN: SZ
CHECKED: SZ
SHEET NUMBER
A-2.0

B2
18

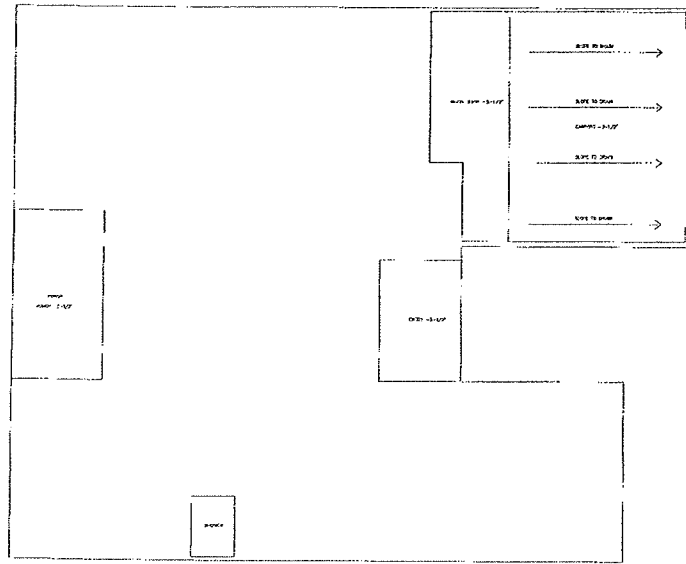

3 FOUNDATION LAYOUT
SCALE: 1/4"=1'-0"

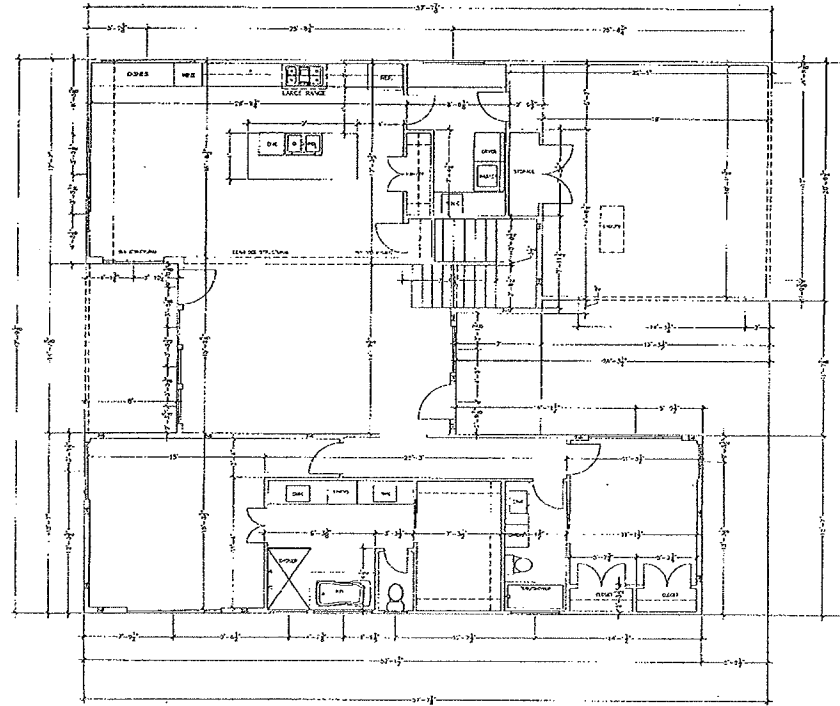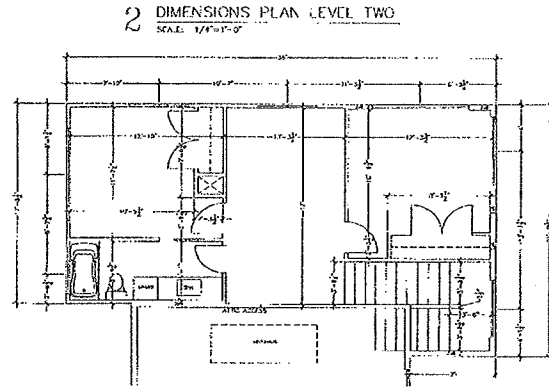

1 DIMENSIONS PLAN LEVEL ONE
SCALE: 1/4"=1'-0"

2 DIMENSIONS PLAN LEVEL TWO
SCALE: 1/4"=1'-0"



Stephen Zagorski, Architect AIA
P.O. Box 50196 Austin, Texas 78763 (512) 789-3259
szagorski@gmail.com 512-789-3259

MOAZAMI HOMES CUSTOM
903 ETHEL STREET
AUSTIN, TEXAS


JOB NO. 1250
DATE 04-28-13
DRAWN: S.J.
CHECKED: S.J.
SHEET NUMBER
A 3.0

CONTRACT NO. 1250 - STEPHEN ZAGORSKI, ARCHITECT - THESE DRAWINGS ARE INSTRUMENTS OF PROFESSIONAL SERVICE AND ARE LOANED TO YOU BY A SINGLE UNLIMITED PROJECT. ALL DRAWINGS & REVISIONS ARE CONSIDERED AND MAY BE AT ANY TIME OR WITHOUT NOTICE WITHOUT NOTICE FROM THE FIRM OF STEPHEN ZAGORSKI, ARCHITECT.


The image shows a technical drawing of a diamond-shaped structure, likely a crystal or a specialized component. The drawing is oriented vertically on the page. It features a central vertical line and horizontal lines extending from the sides, suggesting a symmetrical design. The drawing is enclosed in a rectangular frame, and there are additional lines and markings around it, possibly indicating dimensions or assembly details. The overall appearance is that of a schematic or a technical illustration.

3 FLOOR TRUSS PLAN
SCALE: 1/4"=1'-0"


B2
80

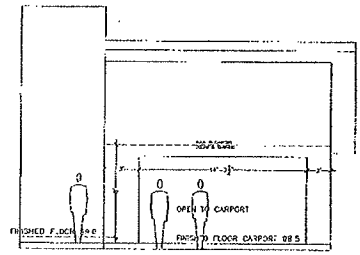

1 HIDDEN NORTH ELEVATION AT CARPORT
SCALE: 1/4"=1'-0"

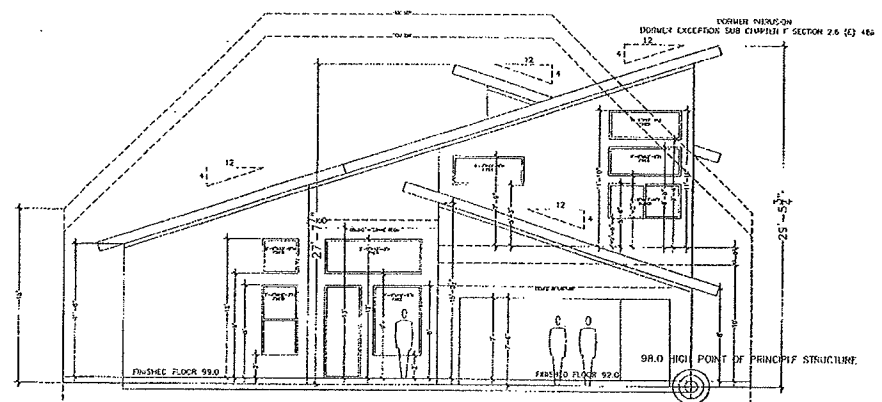

2 WEST ELEVATION
SCALE: 1/4"=1'-0"

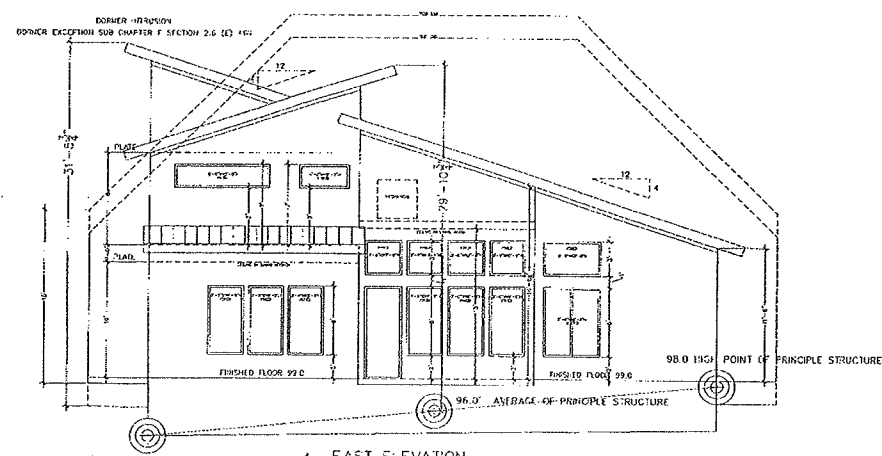

1 EAST ELEVATION
SCALE: 1/4"=1'-0"


ALL DRAWINGS & DETAILS ARE COPYRIGHTED AND MAY NOT BE REPRODUCED OR TRANSMITTED IN ANY FORM OR BY ANY MEANS, ELECTRONIC OR MECHANICAL, WITHOUT PERMISSION IN WRITING FROM STEPHEN ZAGORSKI ARCHITECT.

STEPHEN ZAGORSKI ARCHITECT
P.O. Box 50180 Austin, Texas 78753 (512) 789-3559
szagorski@gmail.com 512-789-3559

MOAZAMI HOMES CUSTOM
903 ETHEL STREET
AUSTIN, TEXAS

JOB NO. 1510
DATE 06-25-12
DRAWN: SZ
CHECKED: SZ
SHEET NUMBER
A-5.0
OF

B2
8/1

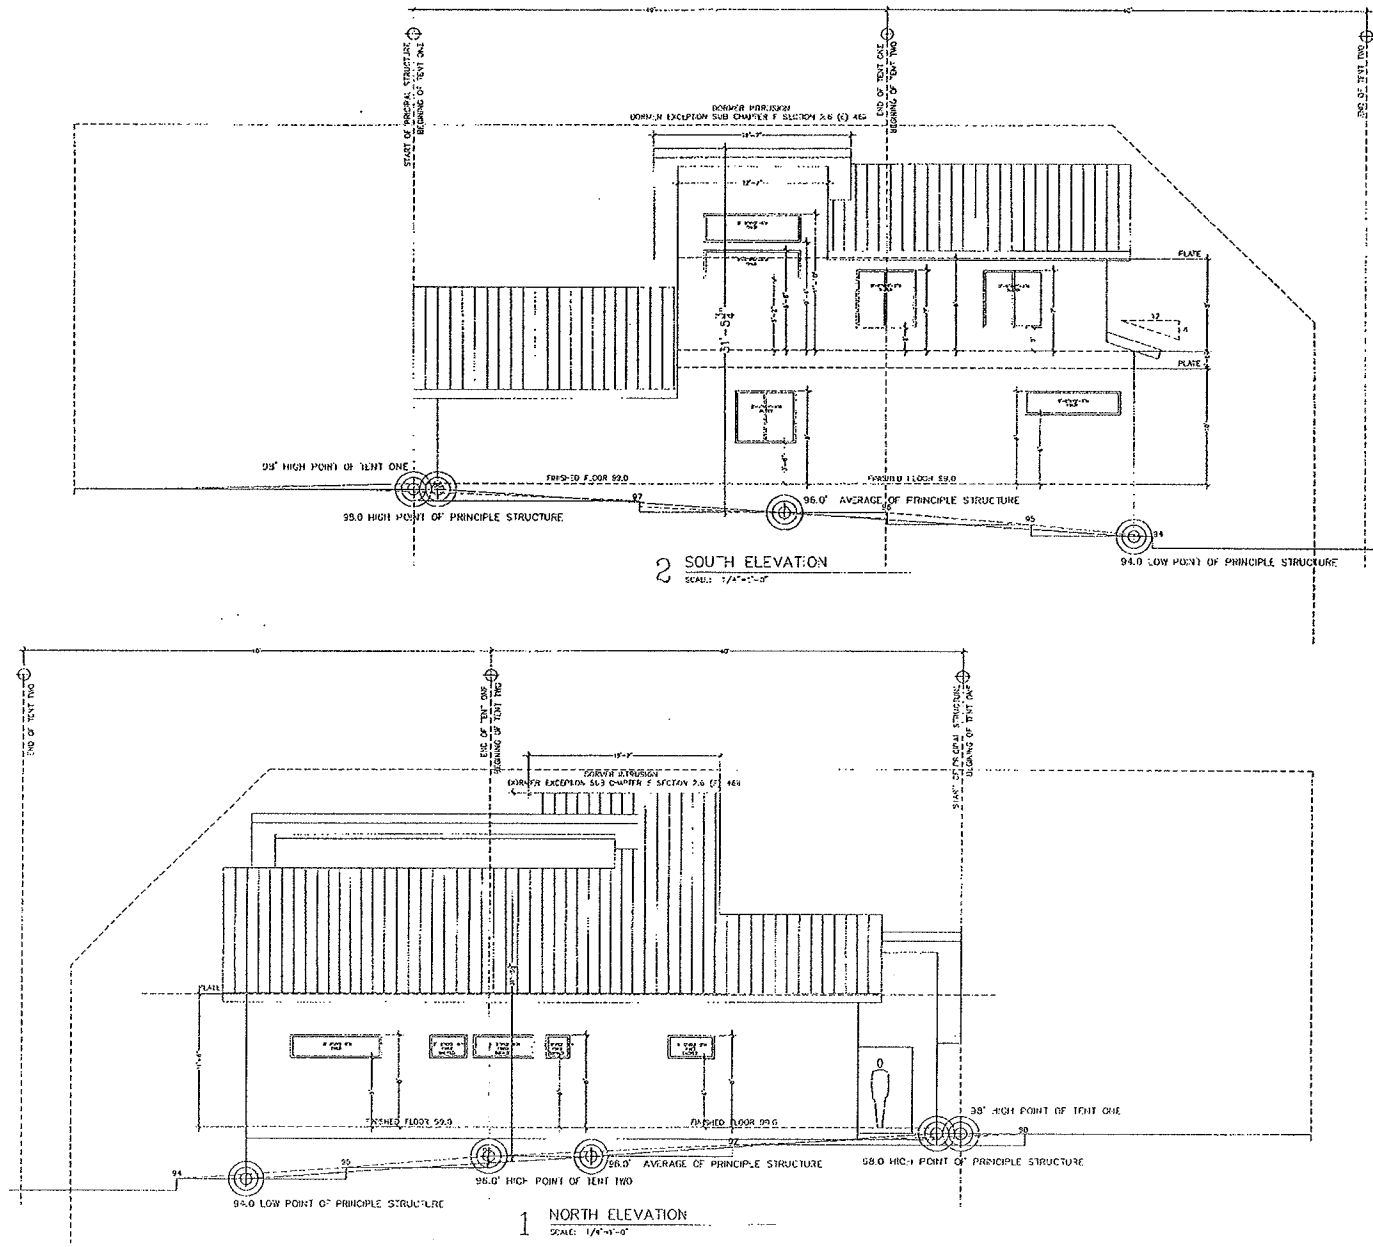

Stephen Zagorski, Architect AIA
P.O. Box 50166 Austin, Texas 78753 (512) 785 8256
szagorski@gmail.com 512-785-3259

MOAZAMI HOMES CUSTOM
903 ETHEL STREET
AUSTIN, TEXAS

JOB NO. 1210
DATE: 01-26-13
DRAWN: SZ
CHECKED: SZ
SHEET NUMBER
A-6.0
OF

Copyright 2013 by Stephen Zagorski, Architect. All rights reserved. No part of this drawing may be reproduced without written permission of Stephen Zagorski, Architect. All drawings are the property of Stephen Zagorski, Architect. All drawings are the property of Stephen Zagorski, Architect.

B2/82

Written comments must be submitted to the board or commission (or the contact person listed on the notice) before or at a public hearing. Your comments should include the board or commission's name, the scheduled date of the public hearing, and the Case Number and the contact person listed on the notice.

Case Number: 2014-056362 PR

ADDRESS: 903 Ethel Street

Contact: Daniel Word, 974-3341

Public Hearing: July 2, 2014

Residential Design and Compatibility Commission

☒ I am in favor
☐ I object

Hasseem Hajjaj
Your Name (please print)

714 Jessie Street
Your address(es) affected by this application

[Signature] 6/17/14
Signature Date

Comments: This is a very reasonable request that
has no adverse effect on anyone else in
the neighborhood.

I hope the commission sees the reasonableness
of this request and approves it. Having a
garage just shouldn't be a big deal.

If you use this form to comment, it may be returned to:
City of Austin
Daniel Word
P.O. Box 1088
Austin, TX 78767-8810