


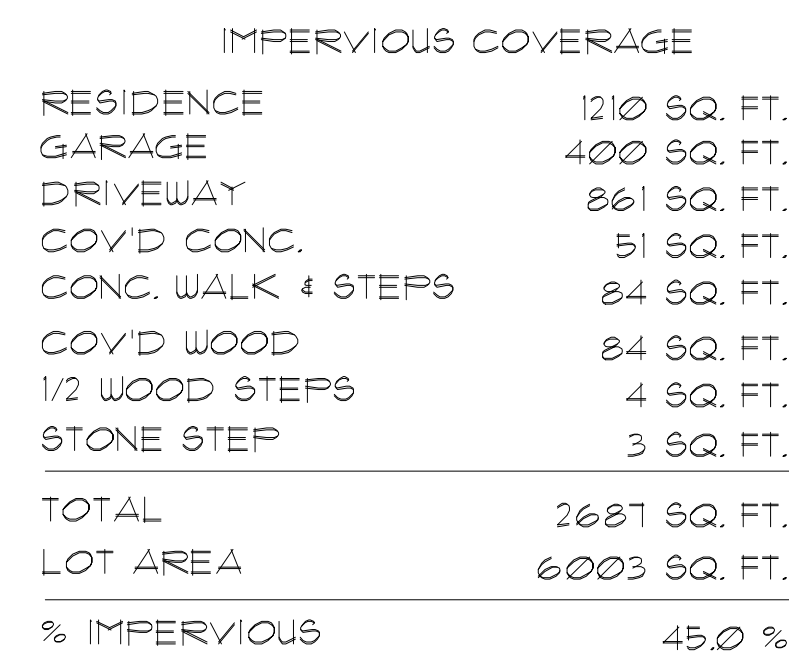
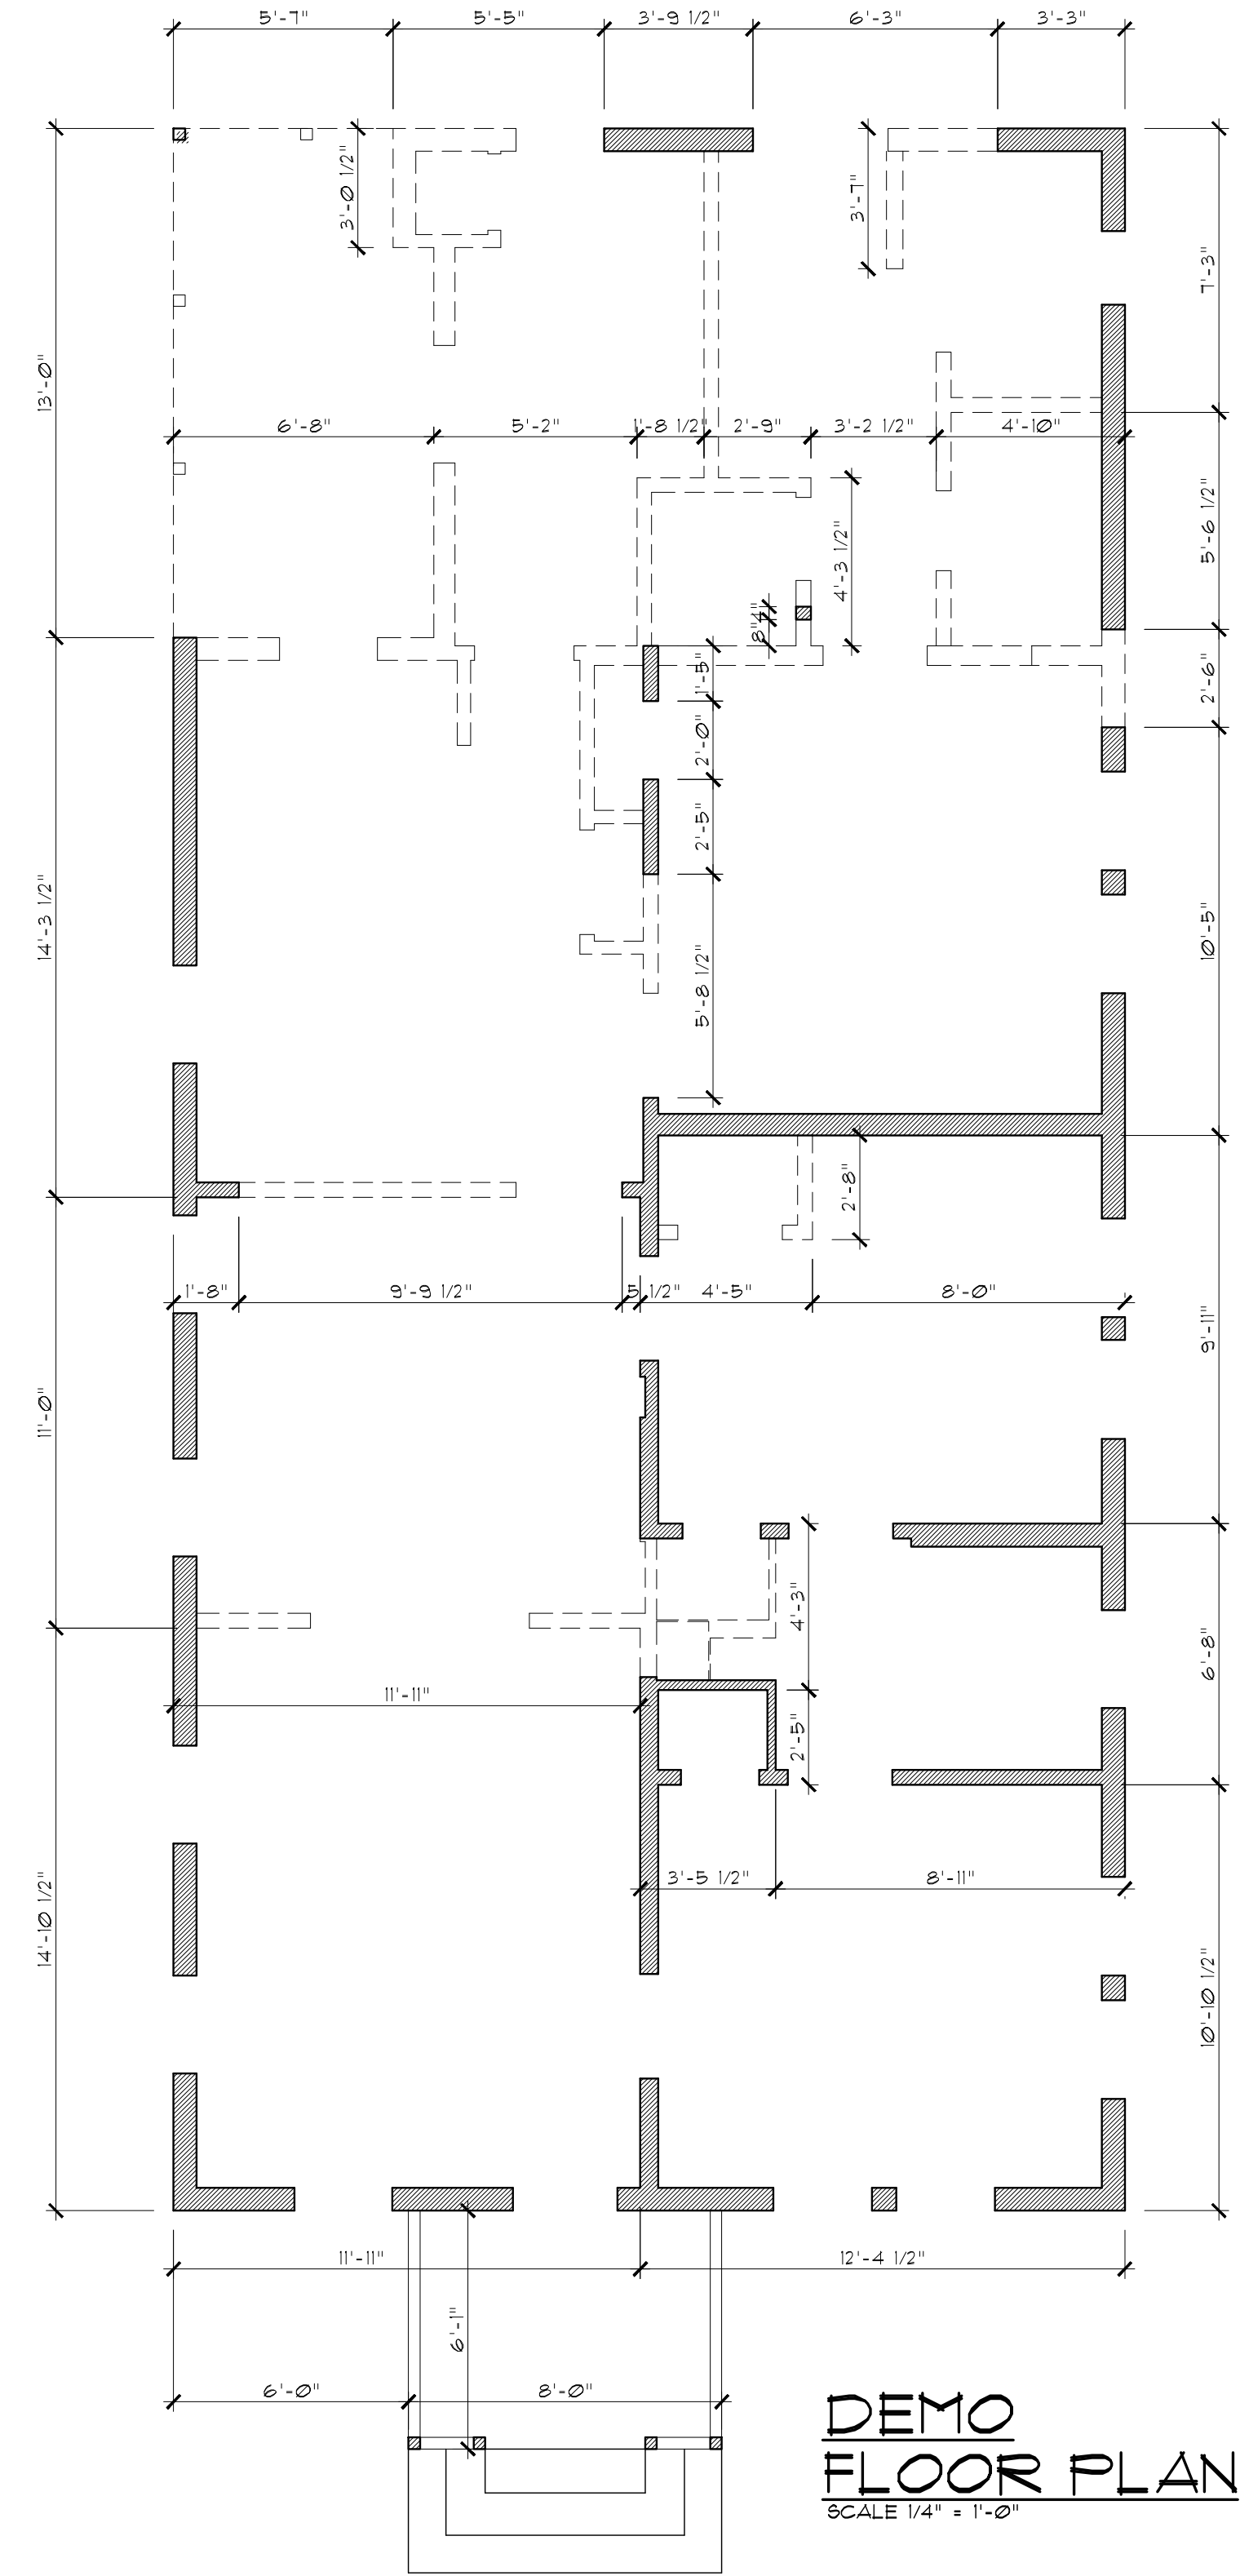


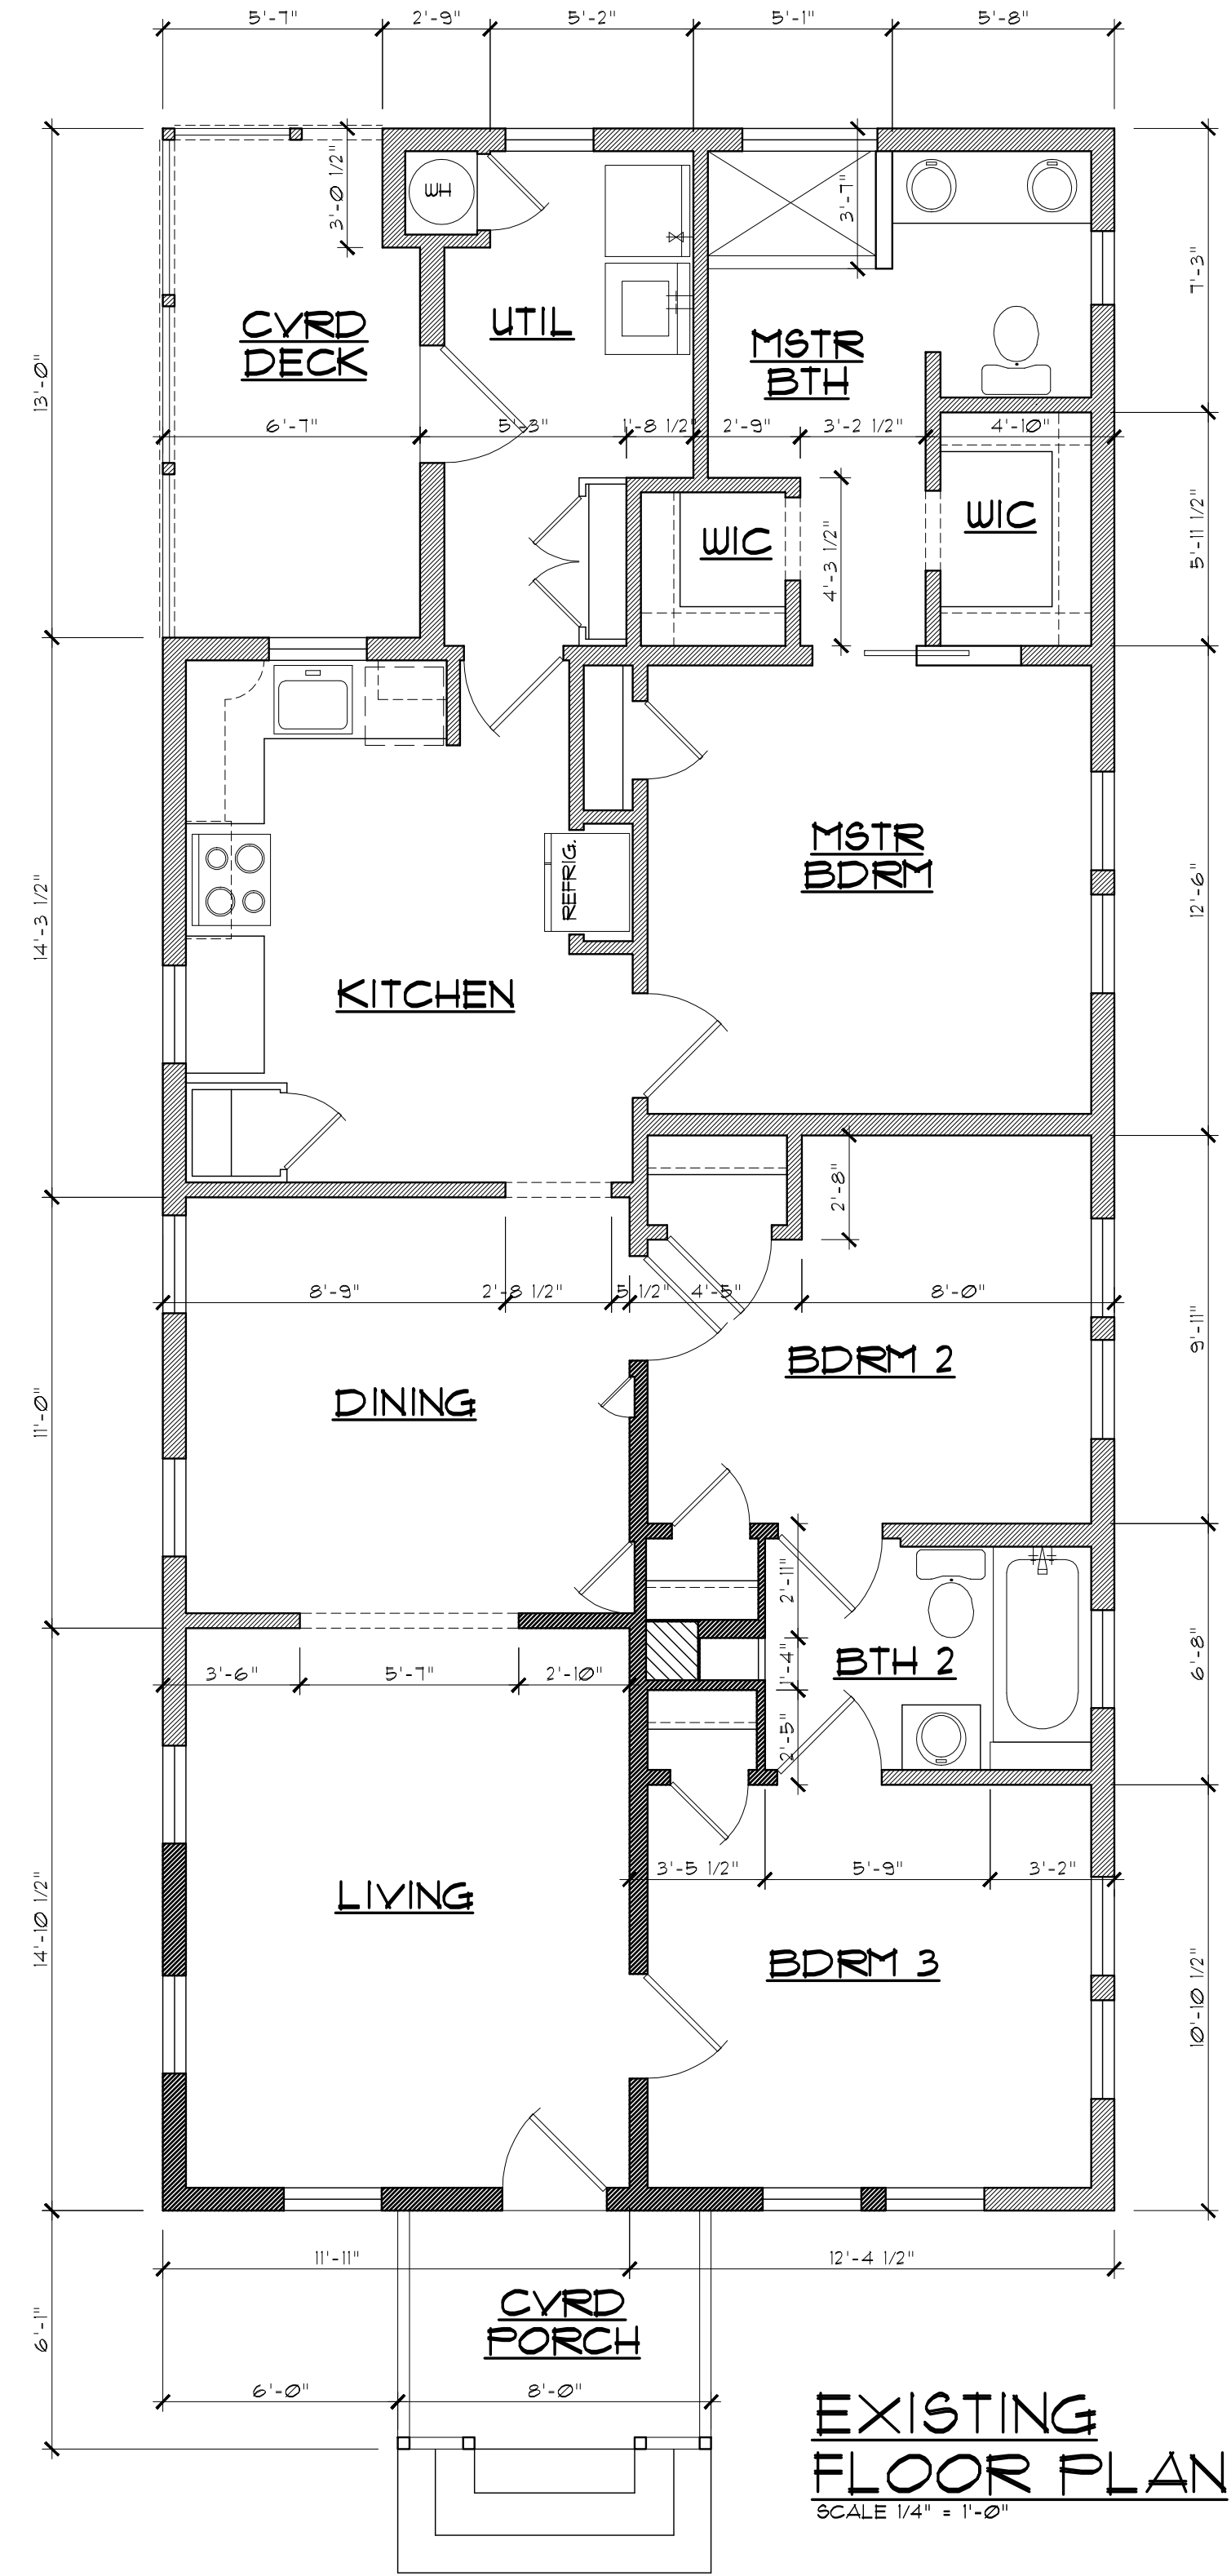

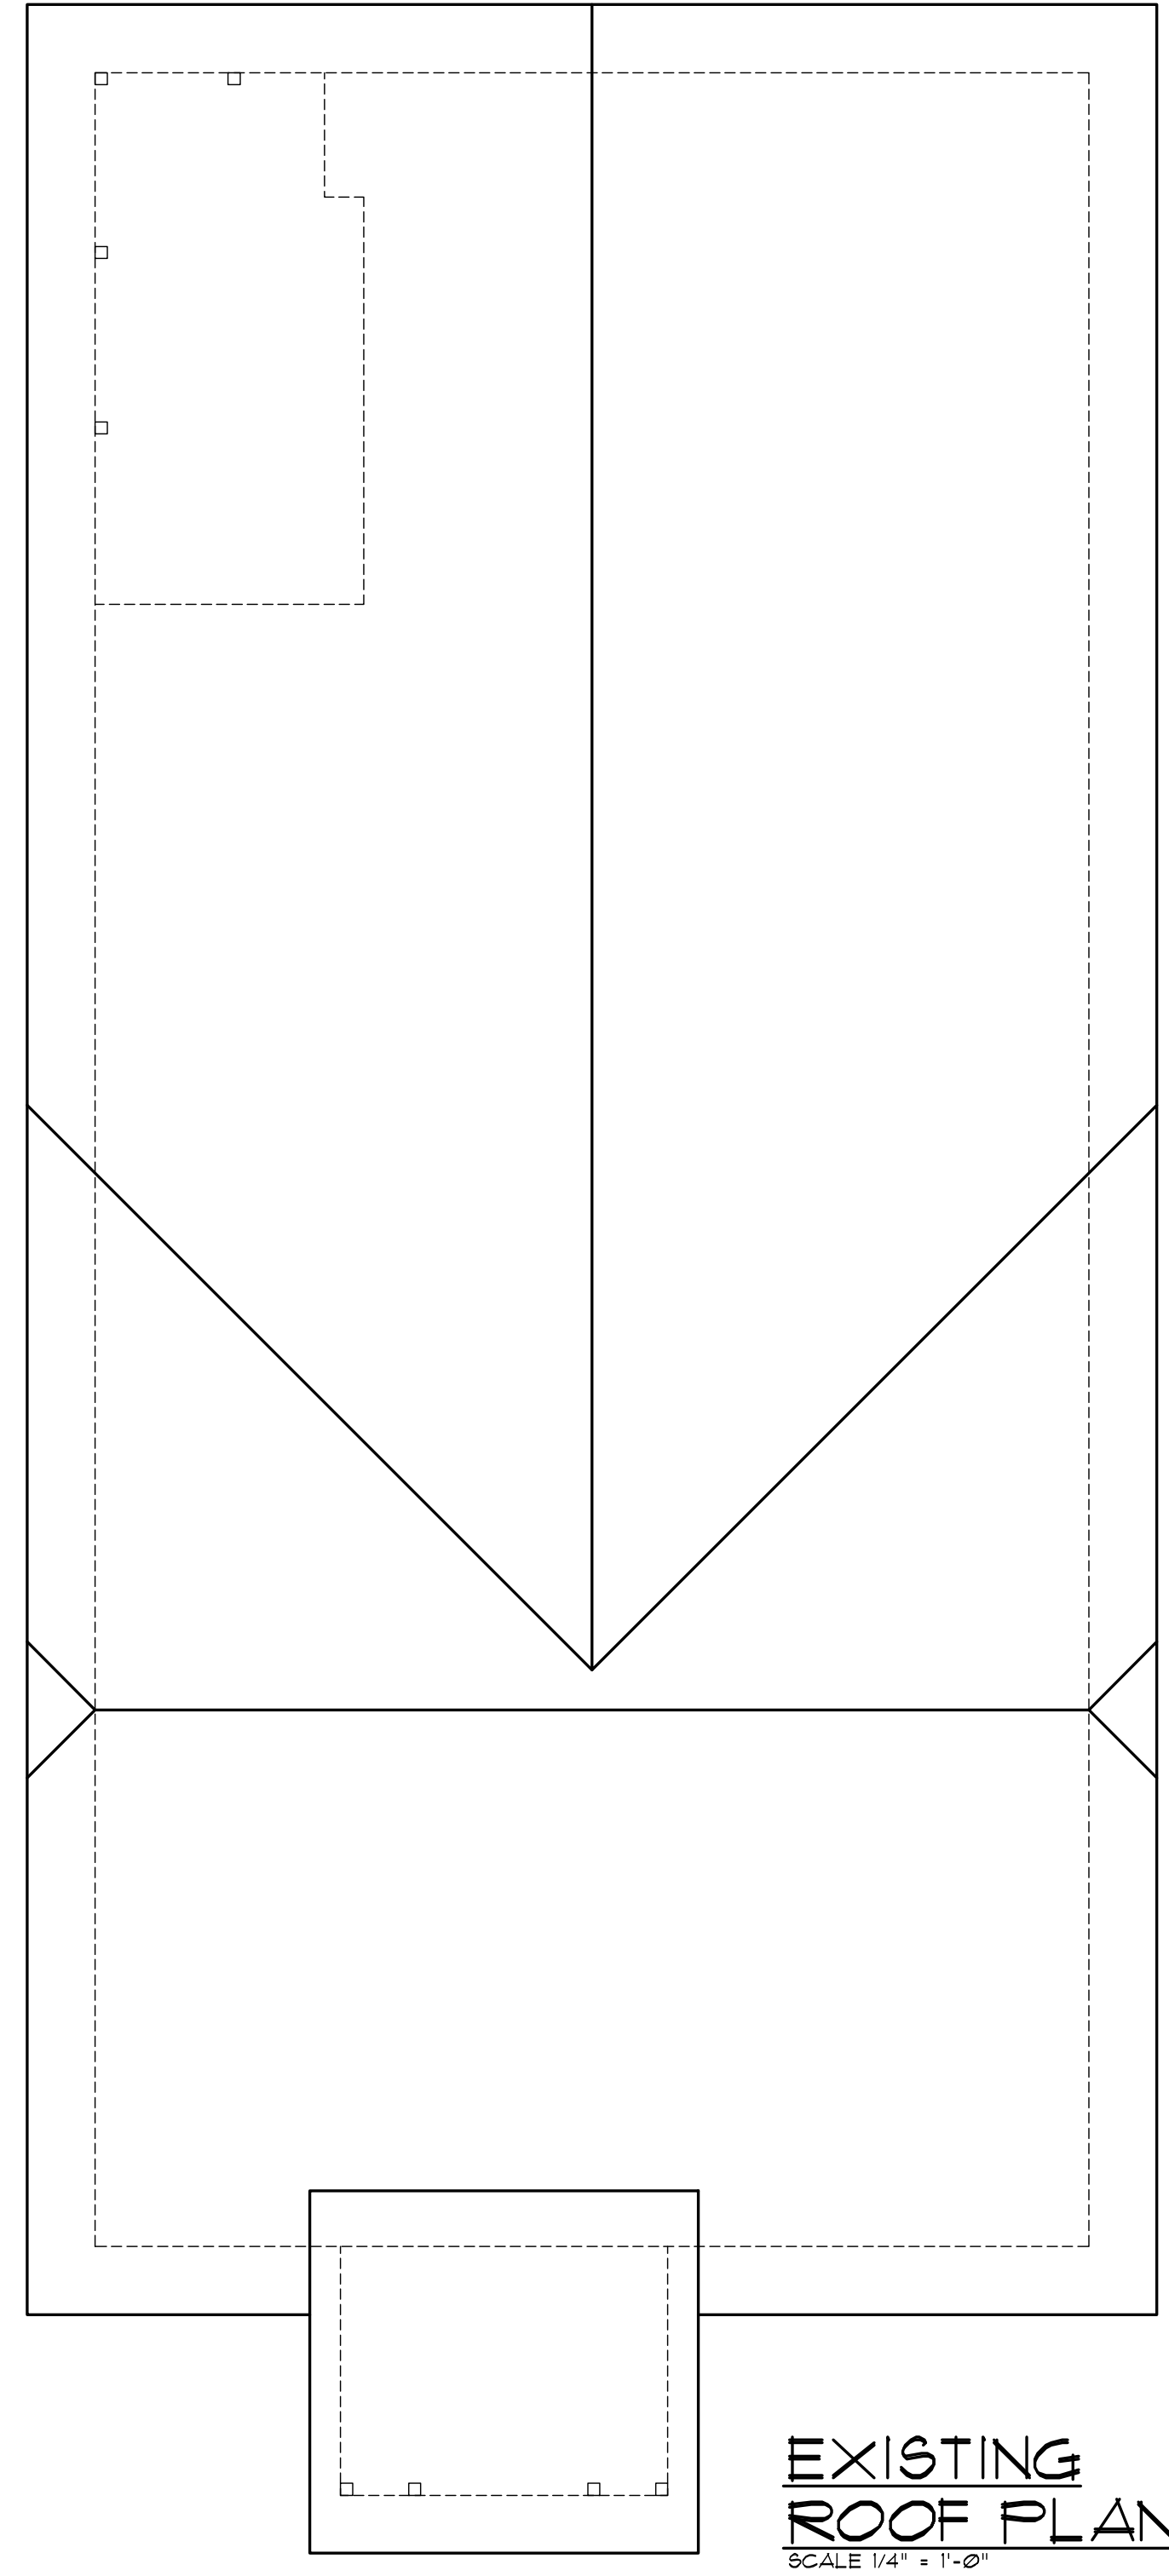

— DENOTES EXISTING WALLS TO REMAIN
- - - - - DENOTES WALLS TO BE REMOVED

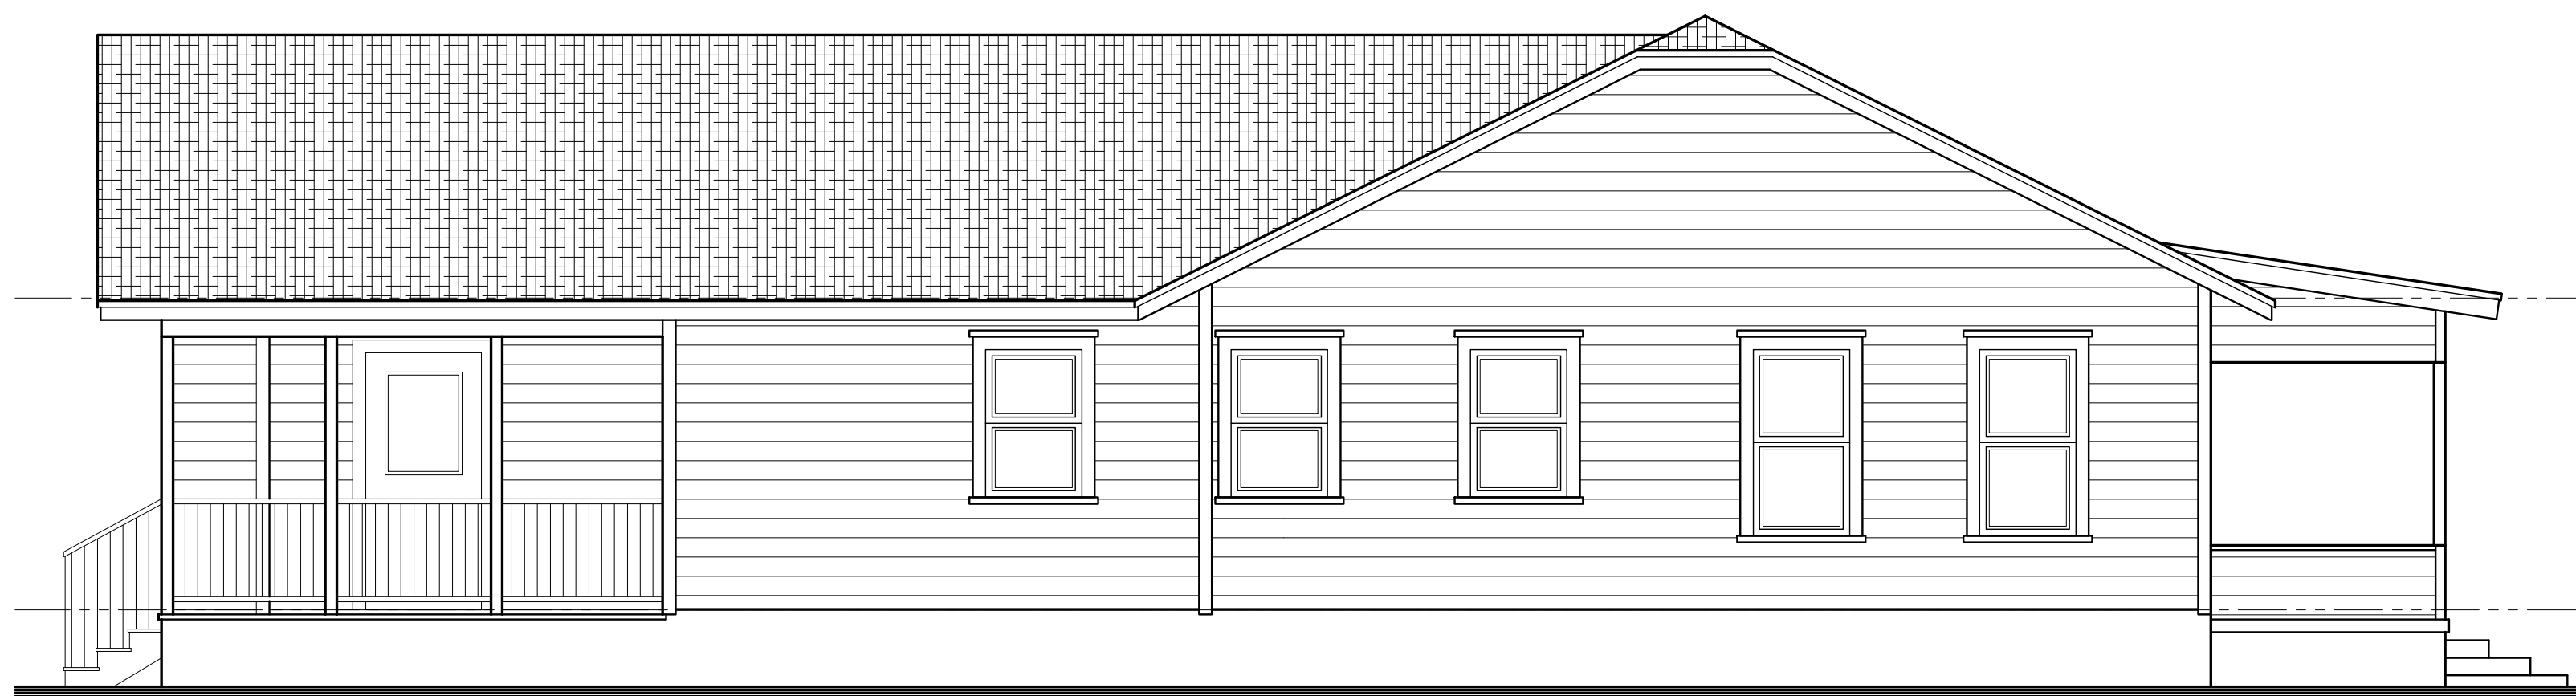

EXISTING LEFT SIDE ELEVATION
SCALE 1/4" = 1'-0"



EXISTING FRONT ELEVATION
SCALE 1/4" = 1'-0"



EXISTING RIGHT SIDE ELEVATION
SCALE 1/4" = 1'-0"




EXISTING REAR ELEVATION
SCALE 1/4" = 1'-0"

GENERAL PROJECT NOTES:

- 1.0 THESE CONSTRUCTION DOCUMENTS ARE INTENDED TO MEET ALL APPLICABLE CODES AND ORDINANCES. CONTRACTOR TO COMPLY WITH ALL LOCAL CODES, ORDINANCES AND DEED RESTRICTIONS. CONTRACTOR SHALL ALSO REQUIRE ALL SUBCONTRACTORS TO COMPLY WITH THESE REGULATIONS.
- 2.0 ANY DISCREPANCIES IN CONSTRUCTION DOCUMENTS OR NONCOMPLIANCE TO BE BROUGHT TO THE ATTENTION OF THE DESIGNER PRIOR TO ANY WORK BEING PERFORMED OR MATERIALS BEING ORDERED.
- 3.0 BUILDER ACCEPTS FULL RESPONSIBILITY FOR CHECKING PLANS TO ASSURE CONFORMITY TO CURRENT LOCAL BUILDING CODES. SHOULD ANY CHANGES BE MADE TO THESE PLANS BY BUILDER OR HIS REPRESENTATIVES WITHOUT CONTACTING THE DESIGNER, THE BUILDER WILL ACCEPT FULL LIABILITY FOR AMENDED PLANS.
- 4.0 THESE DRAWINGS ARE INSTRUMENTS OF SERVICE AND SHALL REMAIN THE PROPERTY OF THE DESIGNER WHETHER THE PROJECT IS EXECUTED OR NOT. THESE DRAWINGS SHALL NOT BE USED BY THE CLIENT FOR OTHER PROJECTS, FOR ADDITIONS TO THIS PROJECT, OR FOR COMPLETION OF THIS PROJECT BY OTHERS WITHOUT PERMISSION OF THIS DESIGNER. THESE DOCUMENTS DO NOT SHOW TYPICAL DETAILING 4/OR WATERPROOFING.
- 5.0 THESE DOCUMENTS DO NOT SPECIFY ACTUAL PRODUCTS OR MATERIAL SELECTIONS. CONTRACTOR ACCEPTS FULL RESPONSIBILITY FOR APPROPRIATE AND PROPER DETAILING FOR AND BETWEEN ALL ACTUAL PRODUCTS/MATERIALS SELECTED WHEN INSTALLED.
- 6.0 ALL COMPONENTS, MATERIALS, ASSEMBLIES AND FINISHES TO BE CONSTRUCTED AND INSTALLED PER MANUFACTURER'S RECOMMENDATIONS, CODE REQUIREMENTS AND REGULATED BUILDING PRACTICES.
- 7.0 DESIGNER IS NOT RESPONSIBLE FOR MEANS AND METHODS OF CONSTRUCTION WHICH ARE NOT DETAILED IN THESE CONSTRUCTION DOCUMENTS. CONTRACTOR WILL BE RESPONSIBLE FOR ALL ASPECTS OF CONSTRUCTION INCLUDING BUT NOT LIMITED TO ALL WATER AND DAMP PROOFING, LOAD CONNECTIONS AND MECHANICAL, ELECTRICAL AND PLUMBING SYSTEMS.
- 8.0 ALL MATERIALS AND LABOR TO BE GUARANTEED FOR ONE YEAR FROM THE DATE OF FINAL PAYMENT. IN ADDITION TO ALL WARRANTIES THAT ARE STANDARD IN THE INDUSTRY, CONTRACTOR TO PROVIDE (SUPPLY AND INSTALL) ALL EQUIPMENT, LABOR SERVICES, AND MATERIALS REQUIRED FOR THE COMPLETE APPROVED INSTALLATION OF THE SYSTEMS CALLED FOR.
- 9.0 THESE DRAWINGS DO NOT INCLUDE NECESSARY COMPONENTS FOR CONSTRUCTION SAFETY. THE CONTRACTOR IS RESPONSIBLE FOR INITIATING, MAINTAINING AND SUPERVISING ALL SAFETY PRECAUTIONS AND PROGRAMS NECESSARY FOR COMPLETION OF WORK. ALL DIMENSIONS TO BE VERIFIED IN THE FIELD. REPORT ANY AND ALL DISCREPANCIES, ERRORS OR OMISSIONS TO THE DESIGNER PRIOR TO COMMENCING WORK AND/OR ORDERING MATERIALS. MINOR DEVIATIONS, SUBJECT TO CONSTRUCTION REQUIREMENTS AND FIELD CONDITIONS, CAN BE EXPECTED.
- 10.0 UNDER NO CIRCUMSTANCES SHALL ANY DIMENSION BE SCALED FROM THESE DRAWINGS. ANY CRUCIAL DIMENSION NOT GIVEN SHALL BE BROUGHT TO THE ATTENTION OF THE DESIGNER.
- 11.0 ALL DIMENSIONS SHOWN ON PLAN ARE TO THE STRUCTURAL FACE OF WALL AND DO NOT INCLUDE WALL FINISHES OR FURRING.
- 12.0 THE CONTRACTOR SHALL GIVE NOTICE TO ALL AUTHORIZED INSPECTORS, SUPERINTENDENTS OR PERSONS IN CHARGE OF UTILITIES AFFECTED BY HIS OPERATIONS PRIOR TO COMMENCING WORK.
- 13.0 THE CONTRACTOR IS TO FILE FOR, AND SECURE ALL APPROVALS, PERMITS, TESTS, INSPECTIONS AND CERTIFICATES OF COMPLIANCE AS REQUIRED. THE CONTRACTOR IS RESPONSIBLE FOR ASSURING THAT ALL PERMITS NECESSARY TO LEGALLY PERFORM THE WORK HAVE BEEN OBTAINED PRIOR TO COMMENCING WORK.
- 14.0 VERIFY EXISTING CONDITIONS AND DIMENSIONS PRIOR TO CONSTRUCTION START.
- 15.0 IN CASE OF DISCREPANCIES OR CONFLICTS ON THE DRAWINGS AND SPECIFICATIONS, OR BETWEEN THE DRAWINGS AND THE EXISTING CONDITIONS, CONTACT THE DESIGNER OR OWNER BEFORE PROCEEDING WITH THE WORK.
- 16.0 CONTRACTOR SHALL CLEAN UP CONSTRUCTION AREAS AFFECTED BY DAILY WORK AND MAINTAIN A CLEAN AND ORDERLY WORK AREA AT ALL TIMES. REMOVE MATERIALS TO APPROVED DUMP SITES ONLY.

ROOF PLAN

SCALE 1/4" = 1'-0"

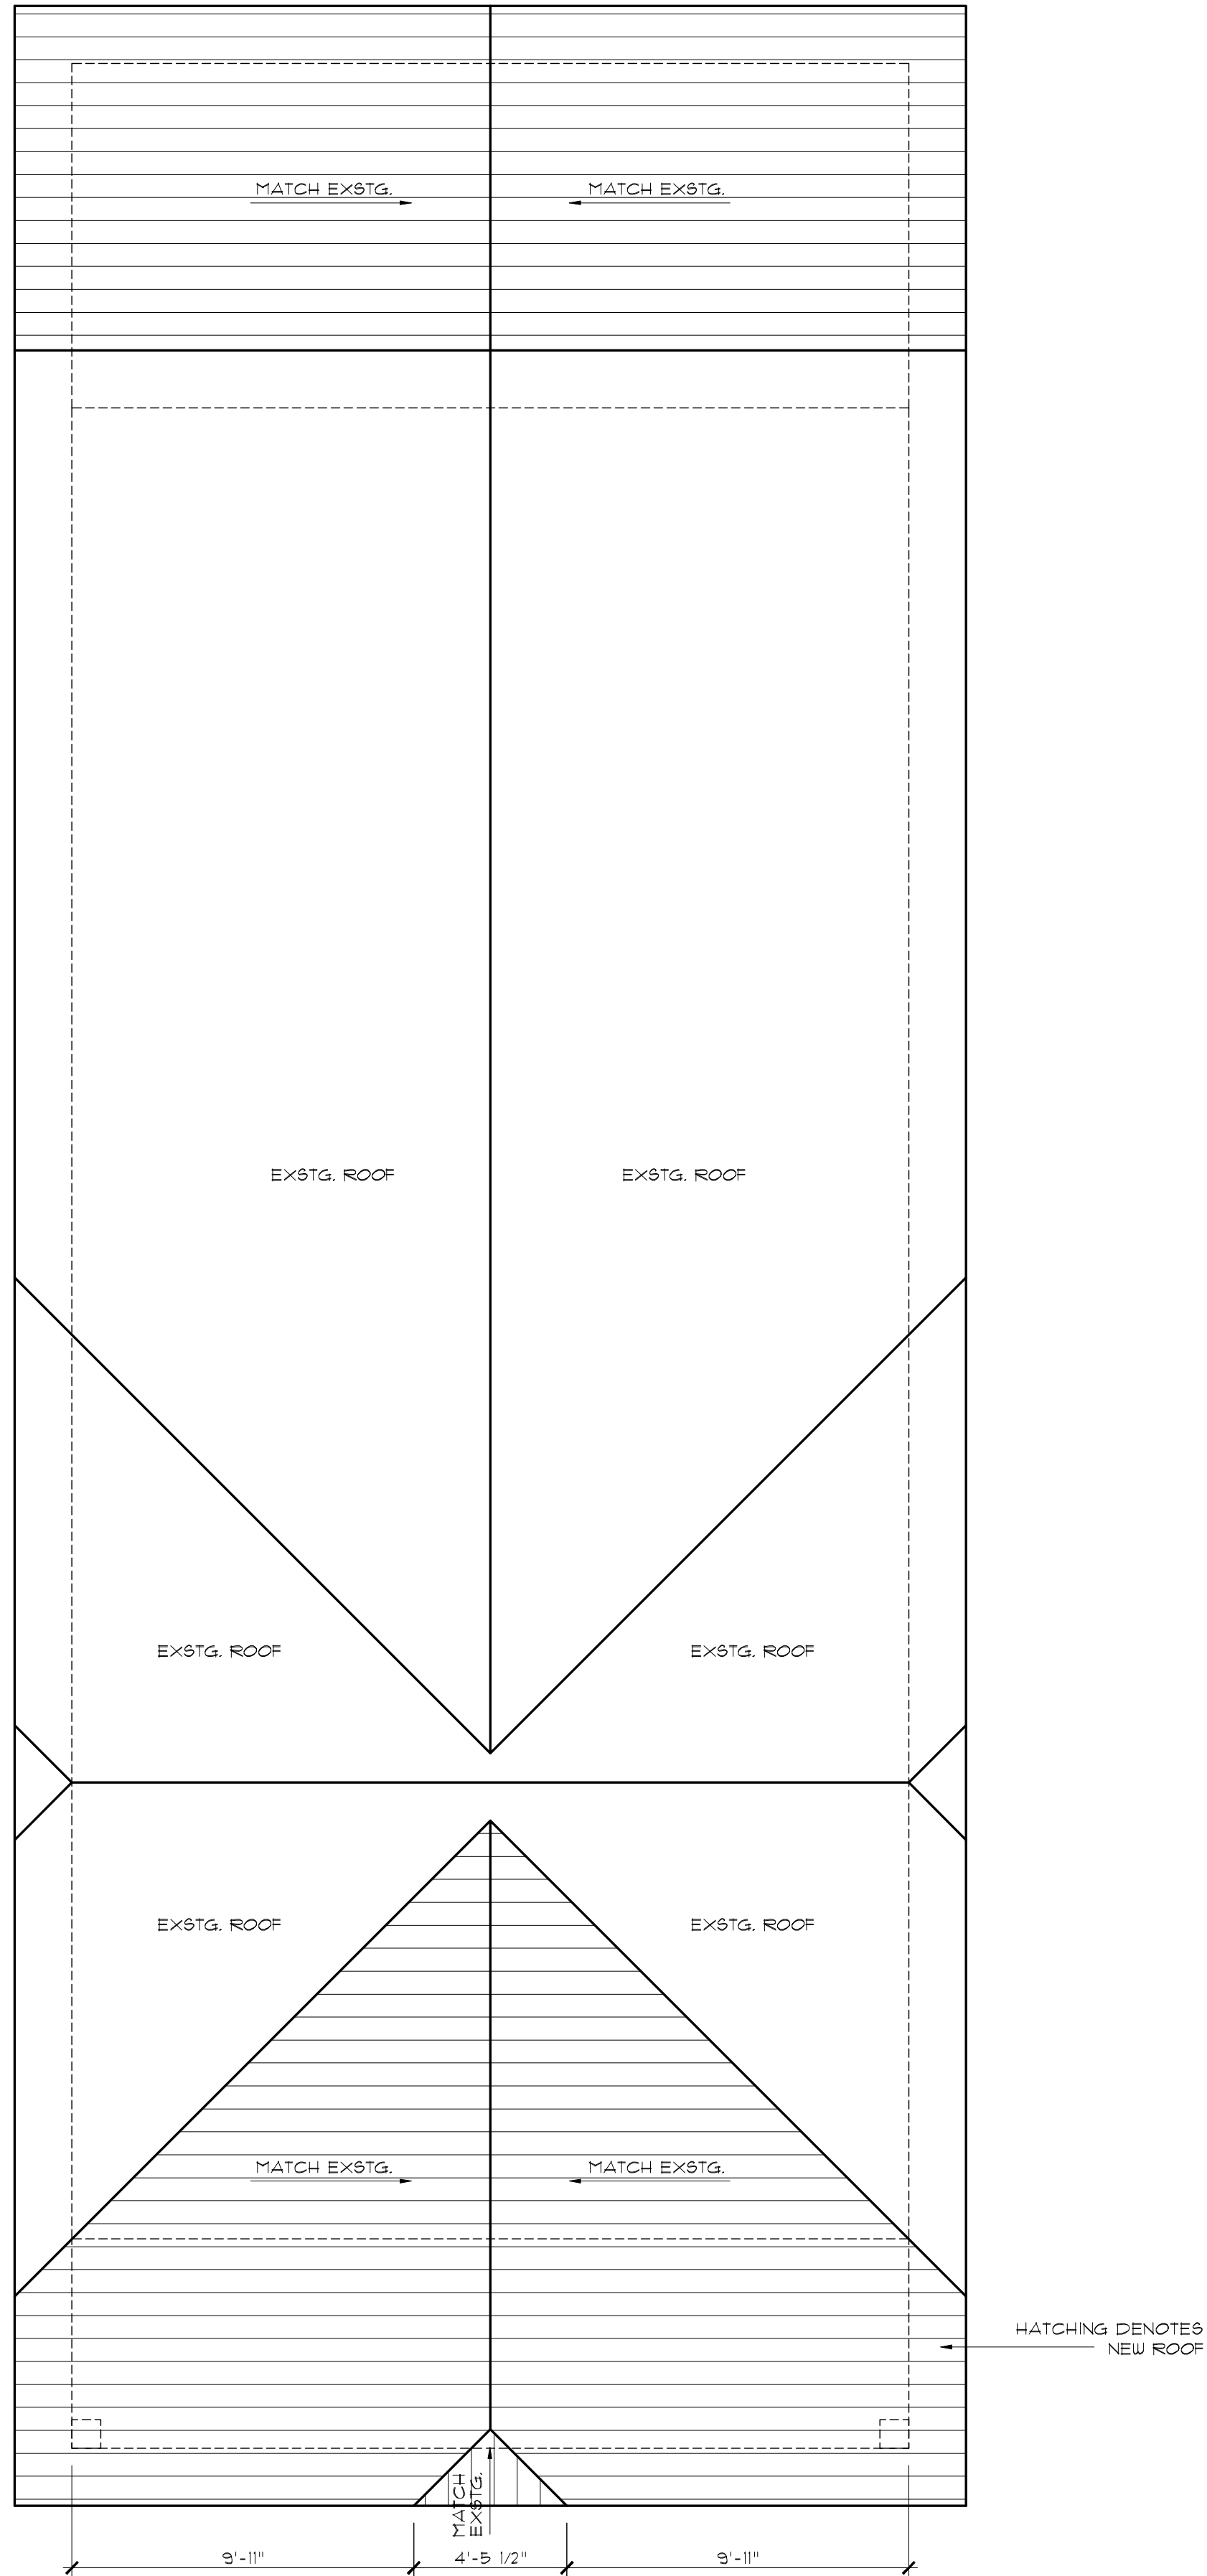

GENERAL PLAN NOTES:

- 1.0 ALL WINDOWS WILL BE DIMENSIONED TO CENTER LINE UNLESS OTHERWISE NOTED. GLASS SIZE PER MFR SPEC.
- 2.0 ALL WINDOWS WITHIN 24" OF AN EXTERIOR OR INTERIOR DOOR TO BE TEMPERED GLASS. WINDOW MANUFACTURER TO VERIFY FOR ALL TEMPERED GLASS LOCATIONS AS
- 3.0 ALL HINGED SHOWER DOORS SHALL SWING OUTWARD. GLAZING USED IN DOORS AND PANELS OF BATHTUB/SHOWER ENCLOSURES AND BUILDING WALLS ENCLOSING THESE COMPARTMENTS SHALL BE FULLY TEMPERED OR LAMINATED SAFETY GLASS. WINDOW MANUFACTURER & BUILDER TO VERIFY EGRESSIBLE WINDOWS INSTALLED WHERE REQUIRED BY CODE.
- 4.0 PROVIDE BLOCKING FOR CEILING FANS WHERE SPECIFIED.
- 5.0 PROVIDE ELECTRIC FOR POOL 4/OR SPA EQUIP. & LIGHTS. PROVIDE NECESSARY PLUMBING FOR POOL 4/OR SPA. VERIFY LOCATION WITH BUILDER OR OWNER.
- 6.0 BUILDER TO VERIFY SIZING AND LOCATION OF ALL APPLIANCES & RELATED COMPONENTS.
- 7.0 WEATHERSTRIP ATTIC ACCESS DOOR(S).
- 8.0 CONTRACTOR TO PROVIDE A 3/4" PLYWOOD CATWALK FROM ATTIC ACCESS TO HVAC UNITS (IF APPL. CABLE) UNITS TO BE LOCATED WITHIN 20'-0" OF ACCESS.
- 9.0 PROVIDE 1.6% NET FREE AREA OF ATTIC VENTILLATION PER 150 SF. OF TOTAL COVERED ROOF AREA AS PER CODE. IF PLATE HEIGHT IS 10'-0" OR HIGHER, ALL DOORS AND CABED OPENINGS TO BE 8'-0" HT. UNLESS NOTED OTHERWISE. IF PLATE HEIGHT IS 9'-0" OR LESS, ALL DOORS AND CABED OPENINGS TO BE 6'-8" HT. UNLESS NOTED OTHERWISE. EXCEPTION: IF A 7'-0" HT. DOOR IS USED, ADJUST WINDOWS TO 7'-0" HEADER HT.
- 10.0 ALL PLUMBING, APPLIANCE AND GAS VENTS TO VENT TO REAR OF ROOF RIDGE WHEREVER POSSIBLE. ALL VENTS TO BE GANGED TO THE FEWEST NUMBER POSSIBLE PENETRATING THE ROOF.
- 11.0 PROVIDE CONTROL AND EXPANSION JOINTS AS REQUIRED ON CONCRETE DRIVES, WALKS AND PATIOS.
- 12.0 PROVIDE WEATHERSEAL AND A 3/2" MASONRY DOOR SILL AT ALL EXTERIOR DOOR THRESHOLDS.
- 13.0 UNLESS NOTED OTHERWISE STANDARD PANTRY SHELVING TO BE AS FOLLOWS: LOWEST 2 SHELVES TO BE 16" D. WITH HEIGHT SPACING OF 14". CLEAR REMAINING SHELVES TO BE 12" D. WITH HEIGHT SPACING OF 12". CLEAR ALL WALLS OVER 10'-0" IN HEIGHT TO BE FRAMED WITH 2x6 STUDS. IF WALLS OVER 10'-0" IN HEIGHT ARE NOT BUILT WITH 2x6 STUDS THEY MUST BE BUILT WITH DOUBLE 2x4 STUDS AT 12" O.C.
- 14.0 THE DROP FROM INTERIOR FINISH FLOOR TO ANY EXTERIOR FINISH FLOOR IS TO BE A MINIMUM OF 1/12". CONTRACTOR TO VERIFY MATERIALS USED FOR DECK CONSTRUCTION AND FINISH FLOORING TO MAINTAIN MINIMUM DROP.
- 15.0 THE STANDARD MOUNTING HEIGHT FOR SHOWER HEADS IS 7'-0" ABOVE FINISH FLOOR UNLESS NOTED OTHERWISE.
- 16.0 PROVIDE BLOCKING FOR HANDRAIL MOUNTING AT STAIRS AS NECESSARY.

LEGEND:
- GAS
- GAS KEY
- SHOWER HEAD
- HOSE BIBB

GROSS FLOOR AREA


EXISTG. CONDITIONED	1210 SF
TOTAL CONDITIONED	1210 SF
GARAGE	400 SF
(PARKING EXEMPTION)	-400 SF
GROSS FLOOR AREA	1210 SF
FRONT COVERED PORCH	51 SF
REAR COVERED PORCH	24 SF

EXISTG. CONDITIONED	1210 SF
NEW CONDITIONED	84 SF
TOTAL CONDITIONED	1294 SF
GARAGE	400 SF
(PARKING EXEMPTION)	-400 SF
GROSS FLOOR AREA	1294 SF
TOTAL LOT AREA	6003 SF
(ALLOWABLE G.F.A.)	(240) SF
FLOOR AREA RATIO	21.6
FRONT COVERED PORCH	148 SF
REAR SCREEN PORCH	293 SF

DENOTES EXISTING WALLS
DENOTES NEW WALLS

FLOOR PLAN

SCALE 1/4" = 1'-0"

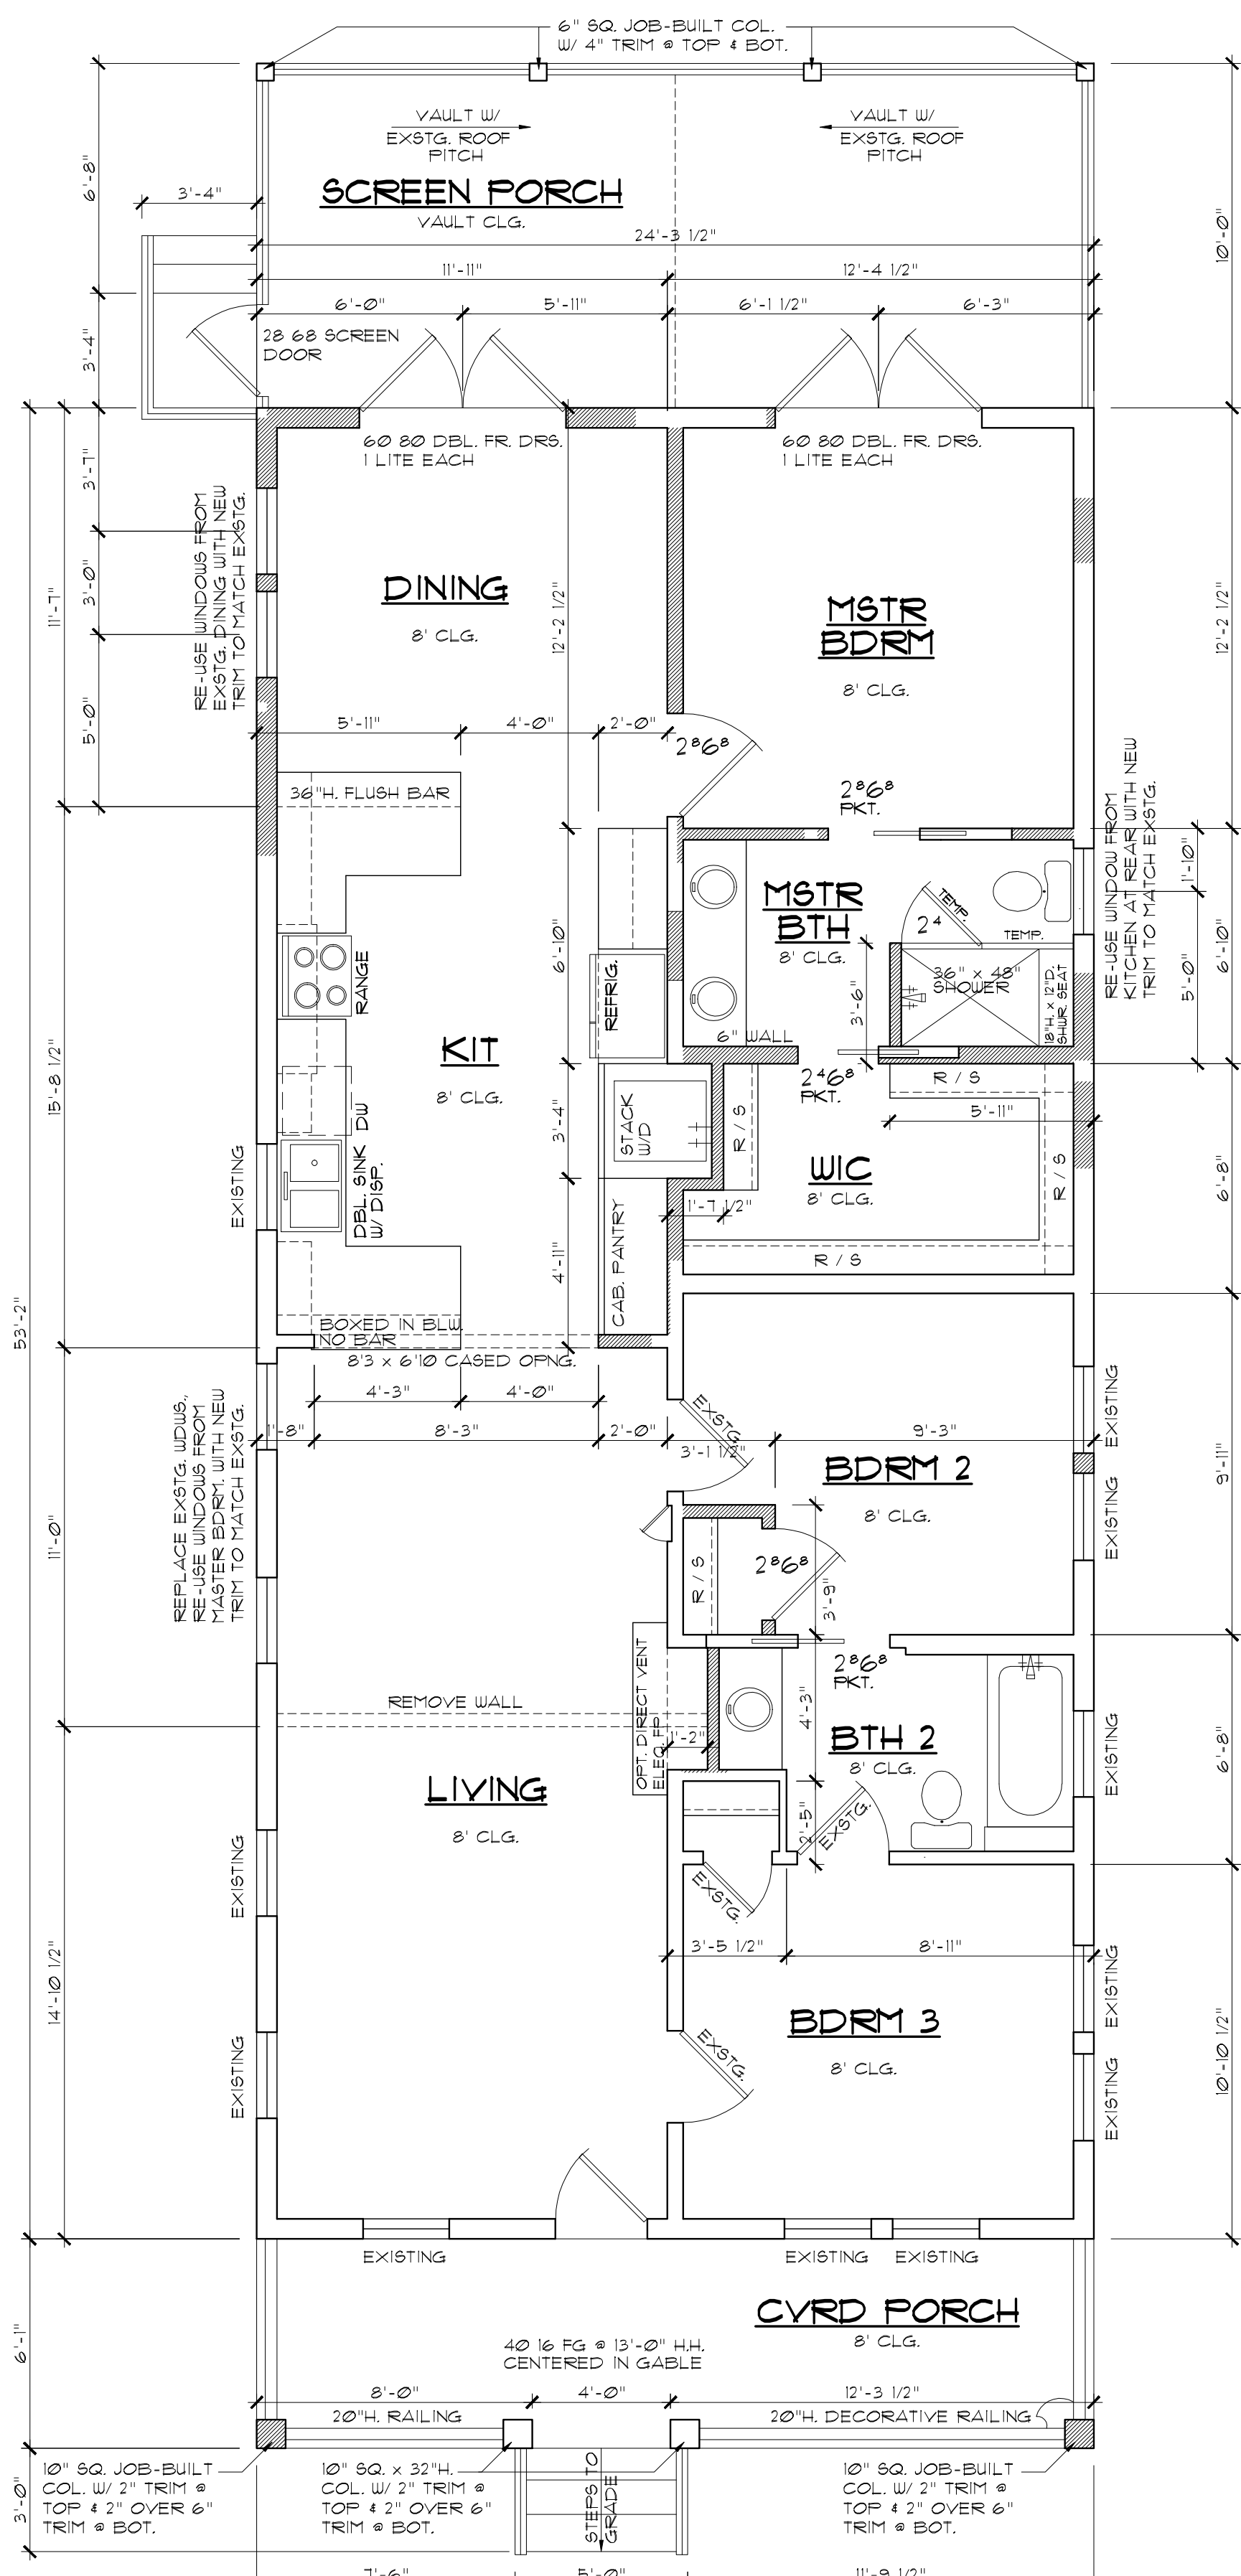

FORD RESIDENCE
4005 AVENUE C AUSTIN, TX

FIVE STAR
design & drafting
11105 Sandstone Trail, Austin, TX 78720 (512) 538-0079


SEP. 2015

4005 AVE C


10/16/15

4 OF 5


ALL RIGHTS RESERVED
©2015 FIVE STAR DESIGN & DRAFTING
The copyright holder hereby grants the user permission to use the drawings and any other documents or materials contained herein for the project only and may not be reproduced or transmitted in any form without written permission.

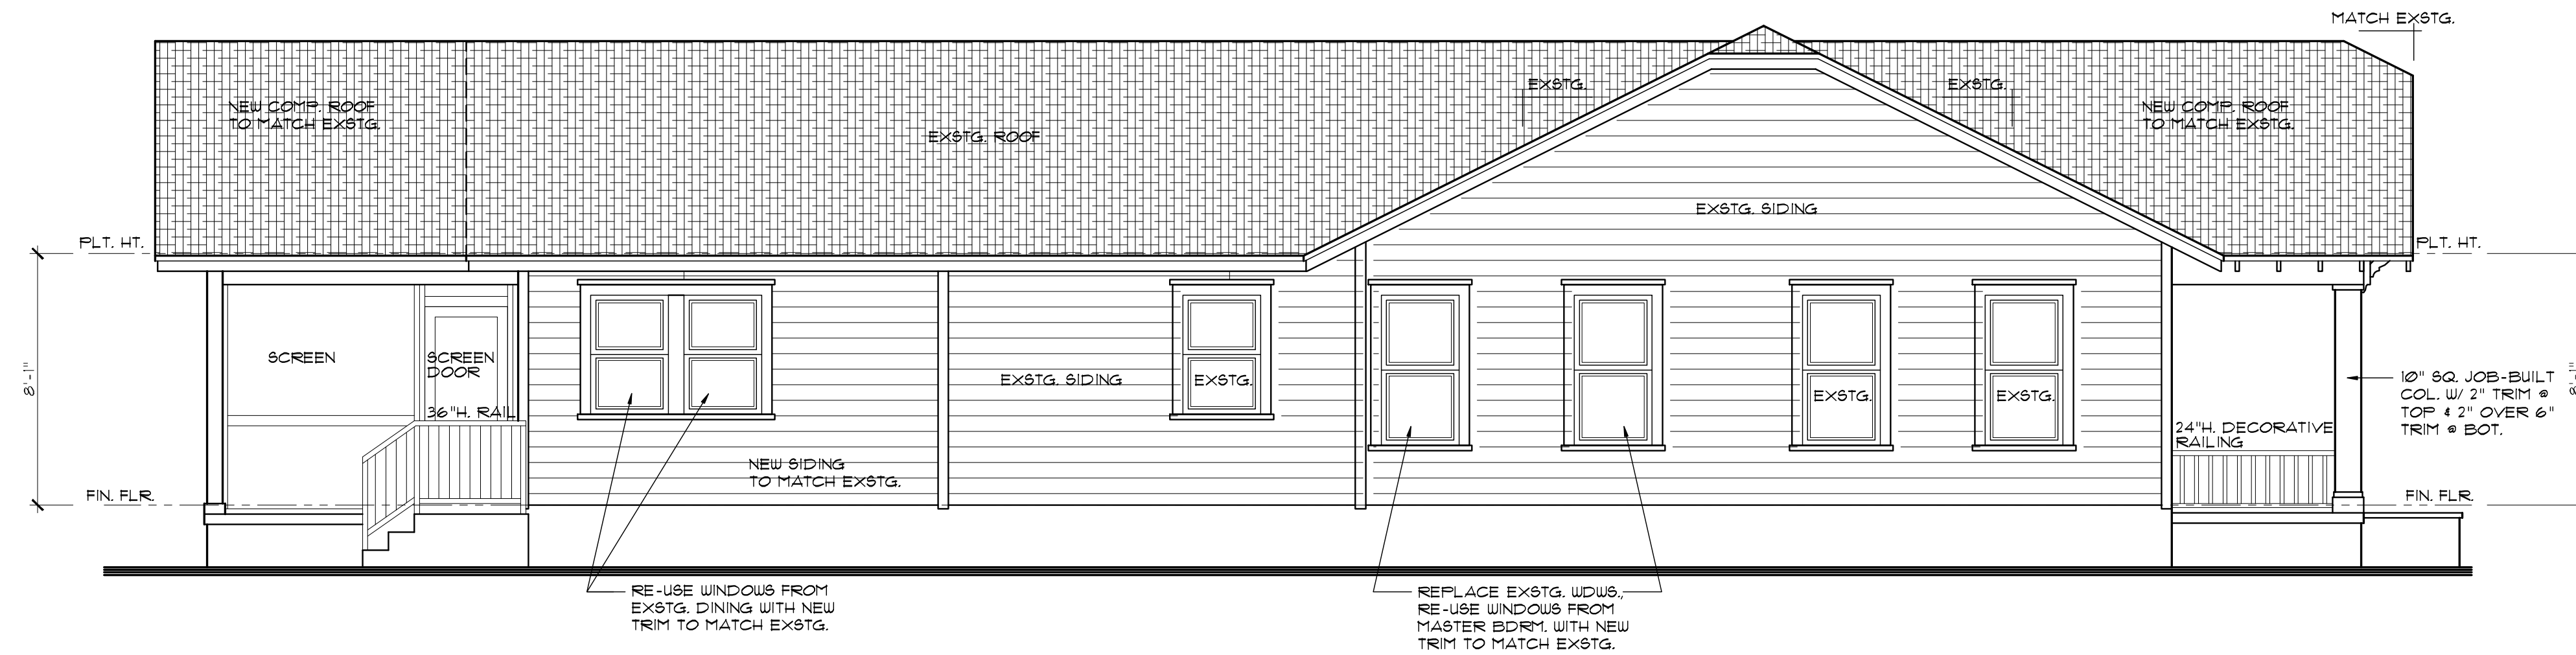


NEW LEFT SIDE ELEVATION
SCALE 1/4" = 1'-0"

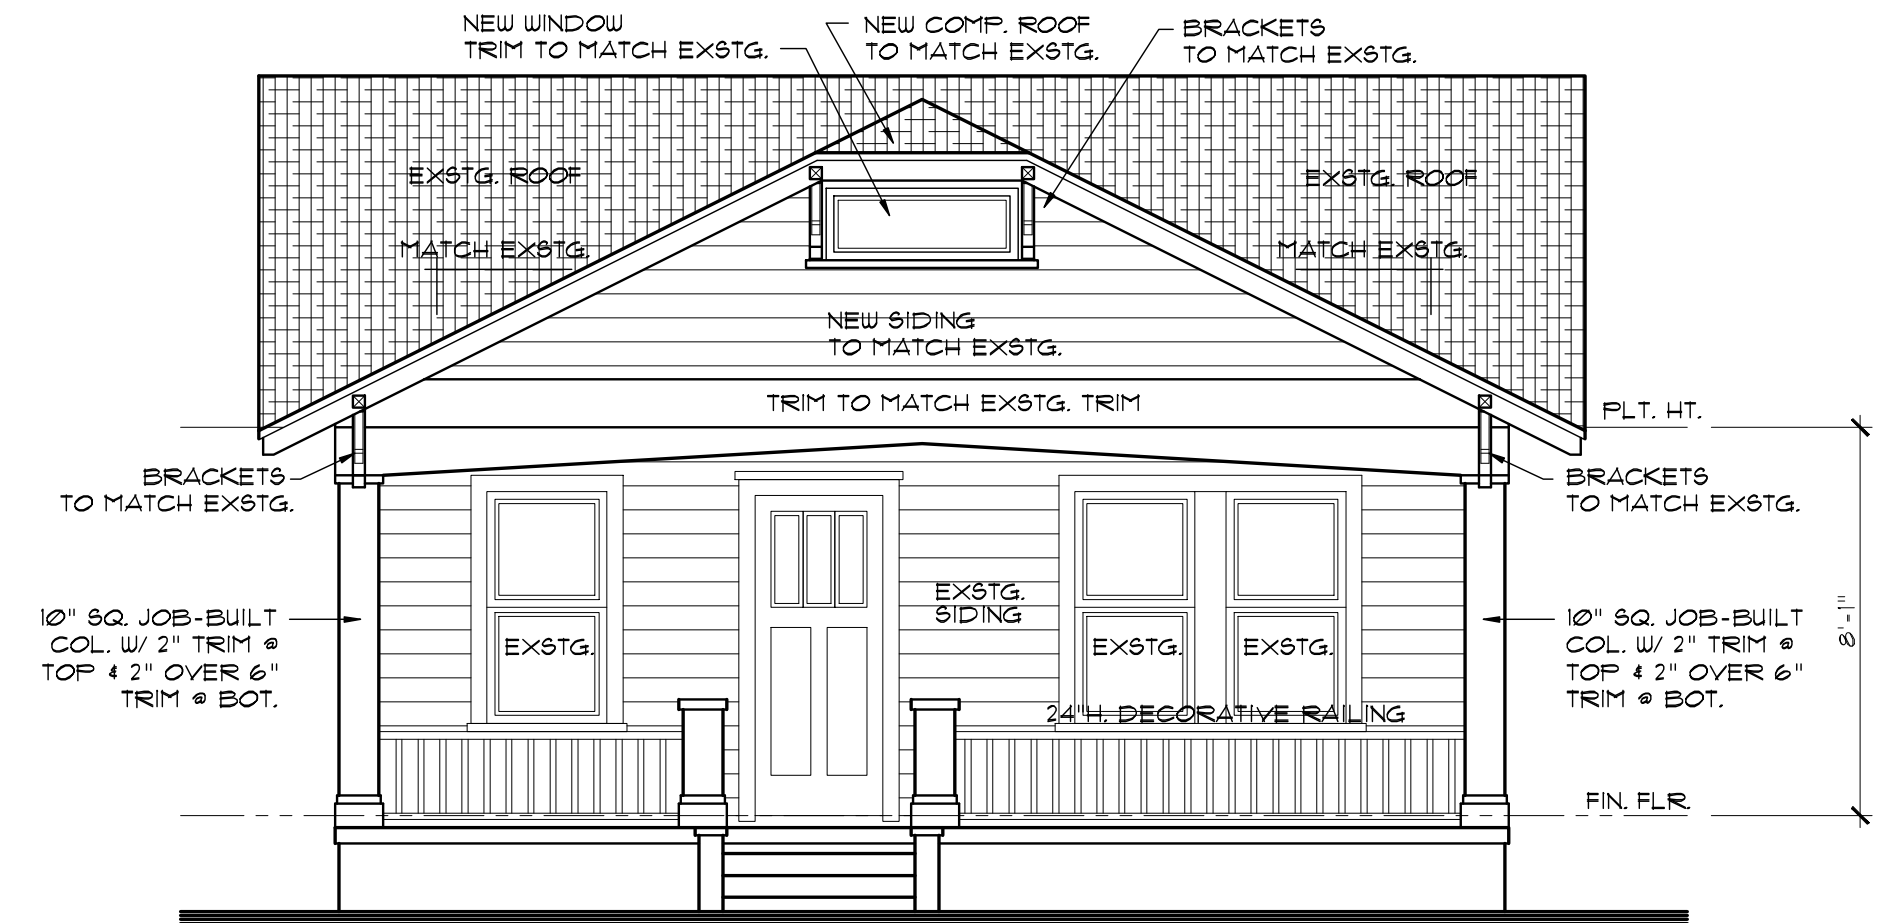

NEW FRONT ELEVATION
SCALE 1/4" = 1'-0"

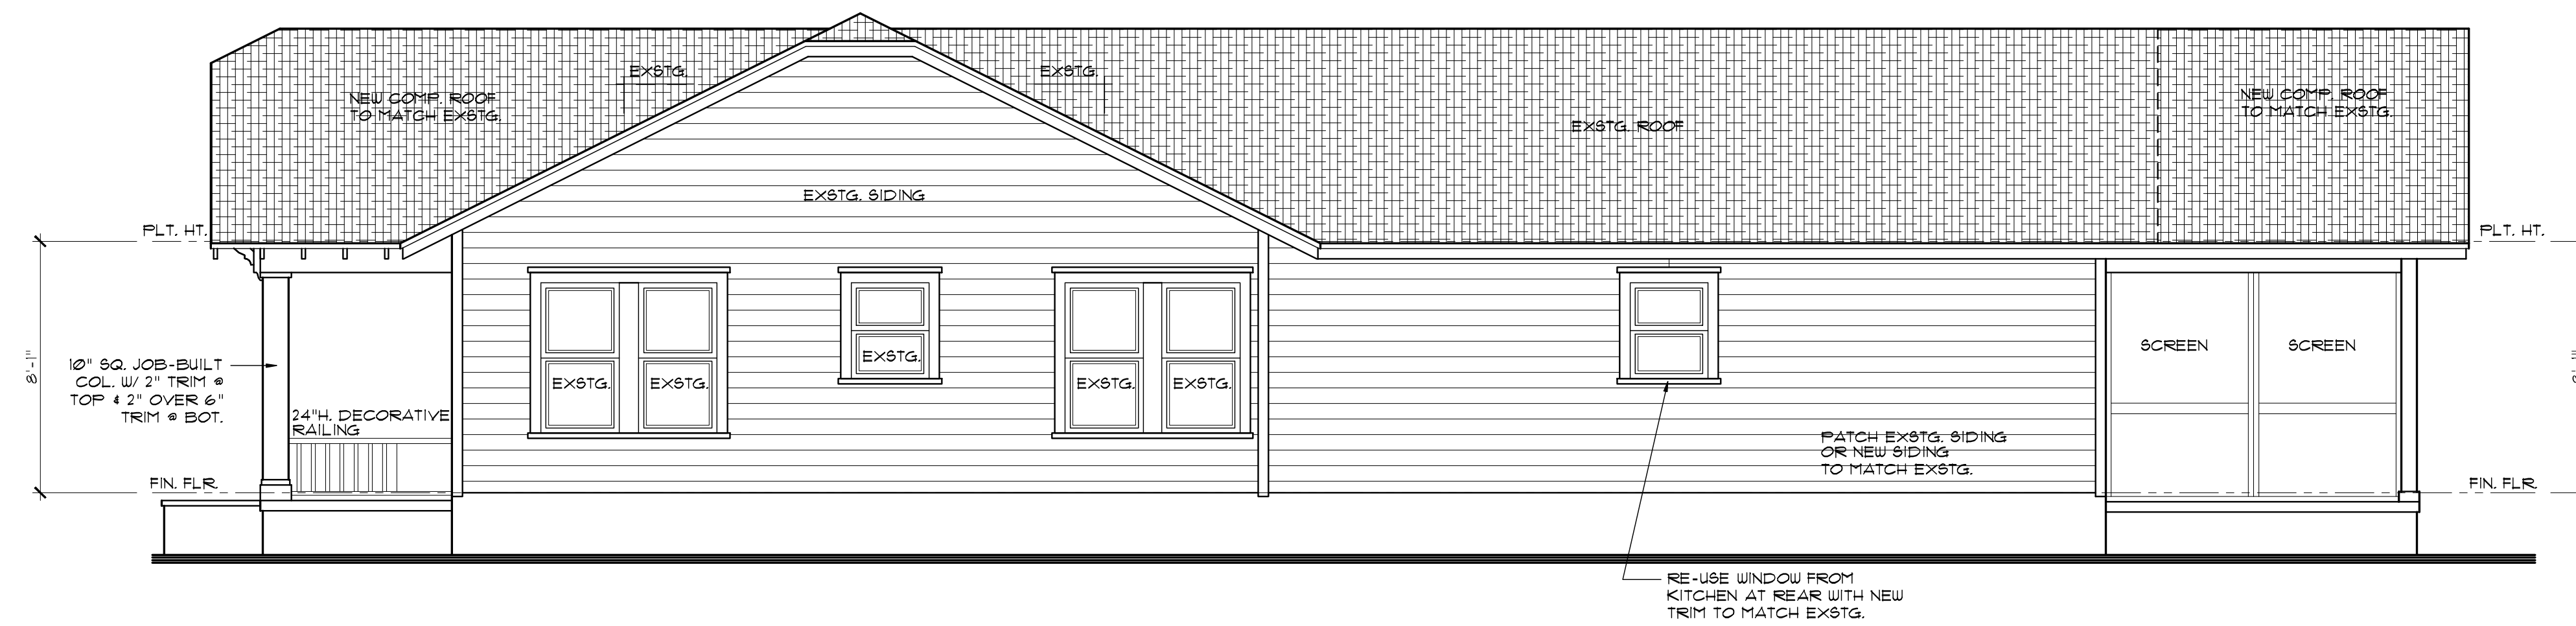

NEW RIGHT SIDE ELEVATION
SCALE 1/4" = 1'-0"

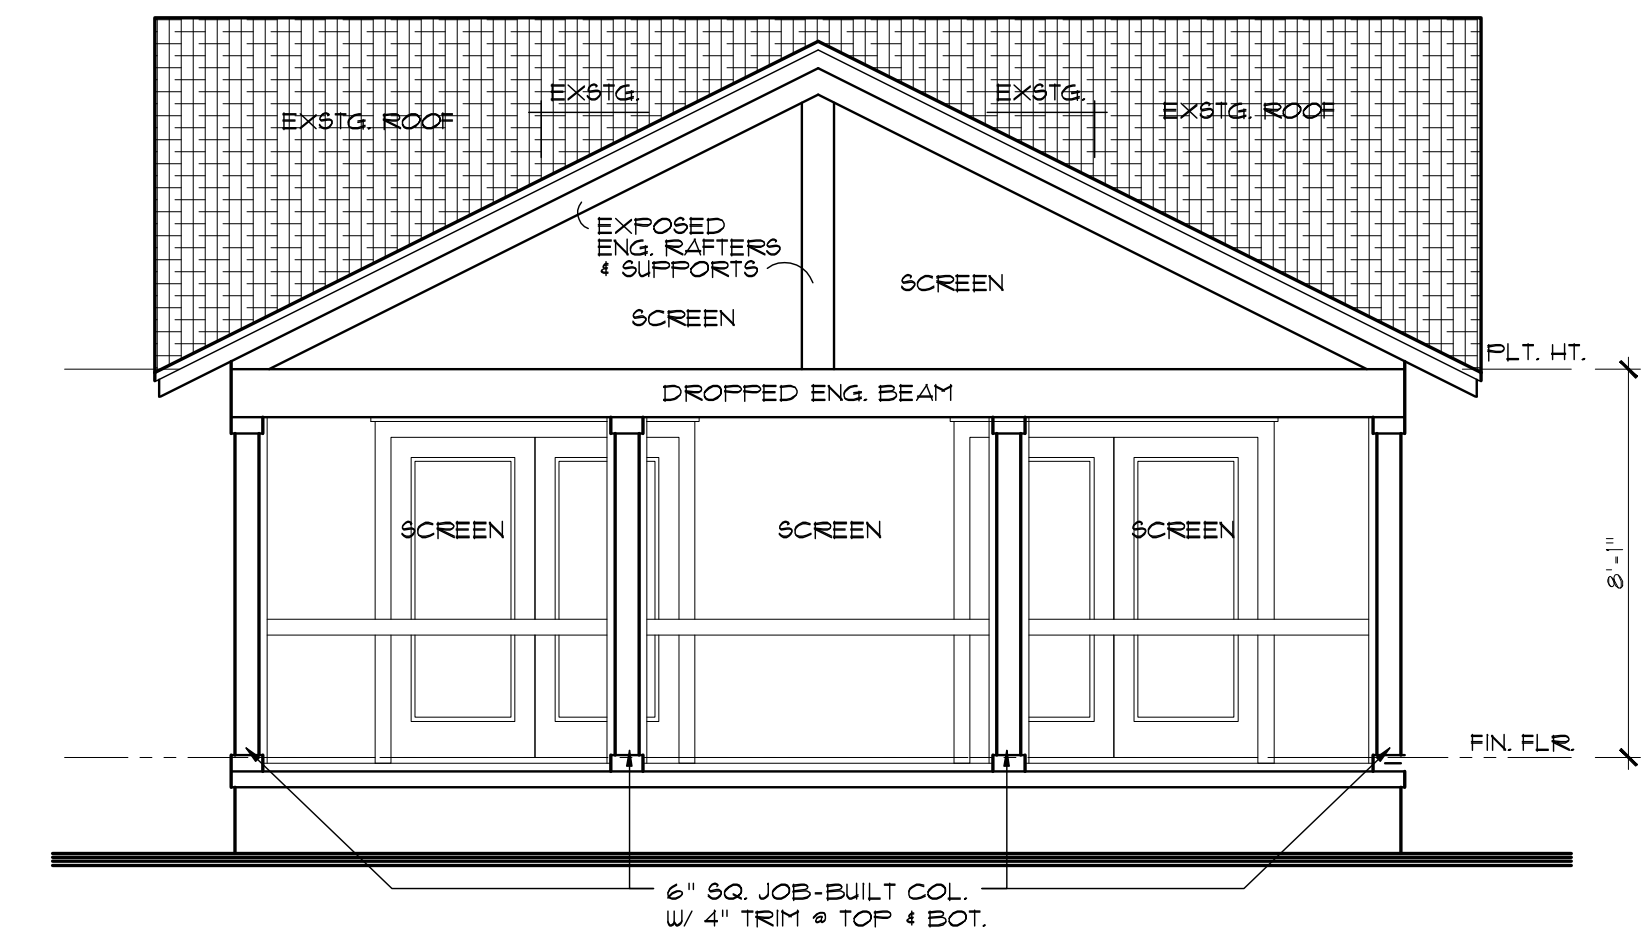

NEW REAR ELEVATION
SCALE 1/4" = 1'-0"

FORD RESIDENCE
4005 AVENUE C AUSTIN, TX

FIVE STAR
designs & drafting
11105 Sandstone Trail Austin, TX 78720 (512) 558-0059


SEP. 2015

4005 AVE C

10/16/15

5 OF 5

ALL RIGHTS RESERVED
©2015 FIVE STAR DESIGNS & DRAFTING
The copyright, design ideas and the
site property of Five Star Designs & Drafting
and may not be reproduced in any form
without written permission.

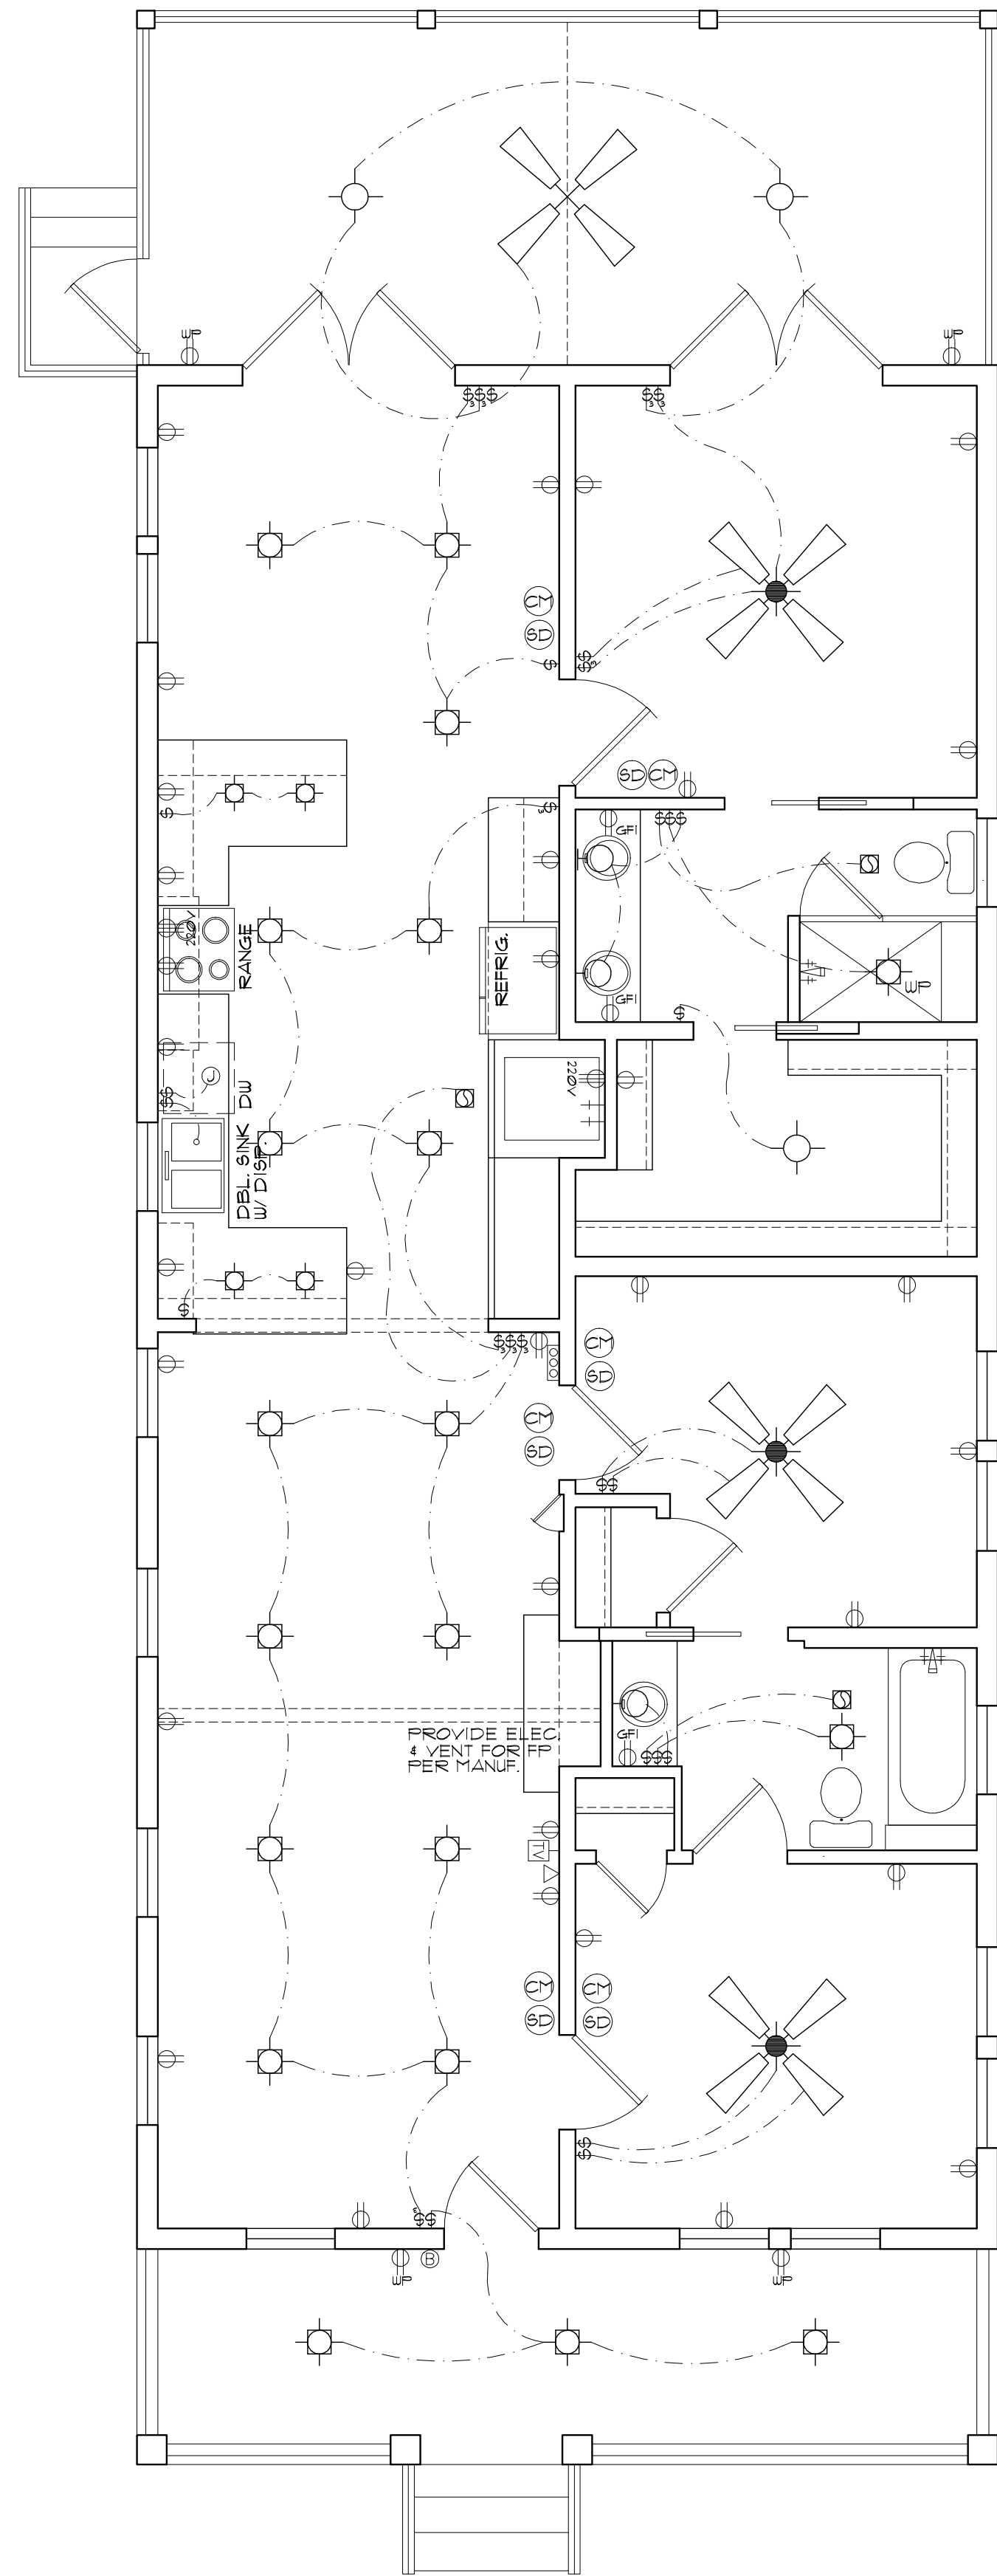

ELECTRICAL LEGEND

- | | |
|--------------------------|-------------------------------------|
| \$ SWITCH | CEILING MOUNTED FIXTURE |
| SWITCH - 3 WAY | RECESSED CAN LIGHT |
| PHONE OUTLET | RECESSED CAN LIGHT WATERPROOF |
| TELEVISION OUTLET | WALL MOUNT FIXTURE |
| JUNCTION BOX | FLUOR. LIGHT |
| OUTLET - 110V DUPLEX | UNDER CABINET LT. (TYPE PER SPECS.) |
| OUTLET - 110V WATERPROOF | VENT/EXHAUST |
| OUTLET - 220V | GAS VALVE |
| EXT. DOOR BELL | |
| CHIMES | |
| SMOKE DETECTOR | |
| CARBON MONOXIDE DETECTOR | |
| CLG. FAN W/ LIGHT KIT | CEILING FAN (WITHOUT LIGHT KIT) |

ELECTRICAL NOTES:

- ALL SWITCHES TO MATCH HEIGHT TO CENTER LINE OF EXISTING SWITCH PLATES UNLESS NOTED OTHERWISE.
- GANG ALL SWITCHES AND OUTLETS WHERE POSSIBLE.
- VERIFY LOCATION OF POWER TO ALL APPLIANCES.
- OUTLETS WITHIN 3'-0" OF A SINK OR LAVATORY TO BE ON A GFI. CIRCUIT.
- NO SWITCHES TO BE WITHIN 5'-0" OF A TUB.
- PROVIDE PHONE & CATV OUTLETS PER PLAN OR PER OWNERS REQUEST.
- NOTE TO ELECTRICIAN: CENTER LIGHT OVER PEDESTAL LAV. WHERE SHOWN.
- SUPPLY 220V/410V OR GAS/410V TO HVAC UNIT(S) IN ATTIC. (REFER TO SPECS.)
- PROVIDE FOR LIGHT NEAR HVAC UNIT(S) IN ATTIC
- WIRE TO 2005 N.E.C.
- PROVIDE SMOKE DETECTOR SYSTEM - HARD WIRED, INTERCONNECTED, BATTERY BACKUP AT EACH SLEEPING ROOM AND VICINITY, IF APPLICABLE AS WELL ON EACH ADDITIONAL STORY WITHIN THE DWELLING UNIT INCLUDING BASEMENTS, IN ACCORDANCE WITH 2012 IRC sec R314.
- ALL CARBON MONOXIDE DETECTORS WILL BE INSTALLED OUTSIDE OF EACH SEPARATE SLEEPING AREA IN THE IMMEDIATE VICINITY OF THE BEDROOMS IN THE DWELLING UNITS WITHIN WHICH FUEL-FIRED APPLIANCES ARE INSTALLED AND IN THE DWELLING UNITS THAT HAVE ATTACHED GARAGES, IN ACCORDANCE WITH 2012 IRC sec R315.1.

ELECTRICAL LAYOUT

SCALE 1/4" = 1'-0"

FORD RESIDENCE
4005 AVENUE C AUSTIN, TX

FIVE STAR
DESIGN & DRAFTING
11105 Sandstone Trail Austin, TX 78720 (512) 658-0059

SEP. 2015

4005 AVE C

10/16/15

E1 OF 1

ALL RIGHTS RESERVED
©2015 FIVE STAR DESIGNS & DRAFTING
The copyright, design ideas and the
work product of Five Star Designs & Drafting
and may not be reproduced in any form
without written permission.