


LIST OF DRAWINGS


AC-1	SITE PLAN EXEMPTION	ADA-1	TOILET AND LAVATORY CLEARANCES
A-1.1	SITE PLAN EXISTING	ADA-2	TOILET ROOM ELEVATION
A-1.2	FLOOR PLAN PROPOSED	ADA-3	DRINKING FOUNTAINS
A-2.1	FLOOR PLAN	ADA-4	MANUEVERING CLEARANCES AT DOORS
A-2.2	FLOOR PLAN	ADA-5	REACH LIMITATIONS
A-3.1	ROOF PLAN		CHANGES IN LEVEL
A-3.2	ROOF PLAN		PROTRUSION LIMITS
AE-1.1	ELECTRICAL PLAN		GRATING DIMENSIONS
AE-1.2	ELECTRICAL SCHEDULE	ADA-6	MIN. PASSAGE WIDTH
AM-1.1	MECHANICAL		ELECTRICAL FIXTURE HT.
AM-1.2	MECHANICAL PLAN		EMERGENCY SYSTEM HT.
AS-1.1	FOUNDATION	ADA-7	DOOR HARDWARE
AS-1.2	FOUNDATION		DOOR THRESHOLD
A-4.1	EXTERIOR ELEVATIONS		DOOR SIGNAGE GRAPHICS
A-4.2	EXTERIOR ELEVATIONS	ADA-8	CURB RAMPS
A-5.1	INTERIOR ELEVATIONS		SIDEWALKS
A-5.2	INTERIOR ELEVATIONS		
A-6.1	BUILDING SECTIONS		
A-6.2	BUILDING SECTIONS		
A-7.1	WALL SECTIONS		
A-7.2	WALL SECTIONS		
A-8.1	DETAILS		
A-8.2	DETAILS		
A-9.1	DOOR SCHEDULE		
A-9.2	WINDOW SCHEDULE		

SPEC. 1	DIV.1 GENERAL CONDITIONS
	DIV.2 SITE WORK
SPEC. 2	DIV.6 CARPENTRY
SPEC. 3	DIV.7 THERMAL AND MOISTURE PROTECTION
SPEC. 4	DIV.8 DOOR AND WINDOWS
SPEC. 5	DIV.9 FINISHES
SPEC. 6	FINISH SCHEDULE

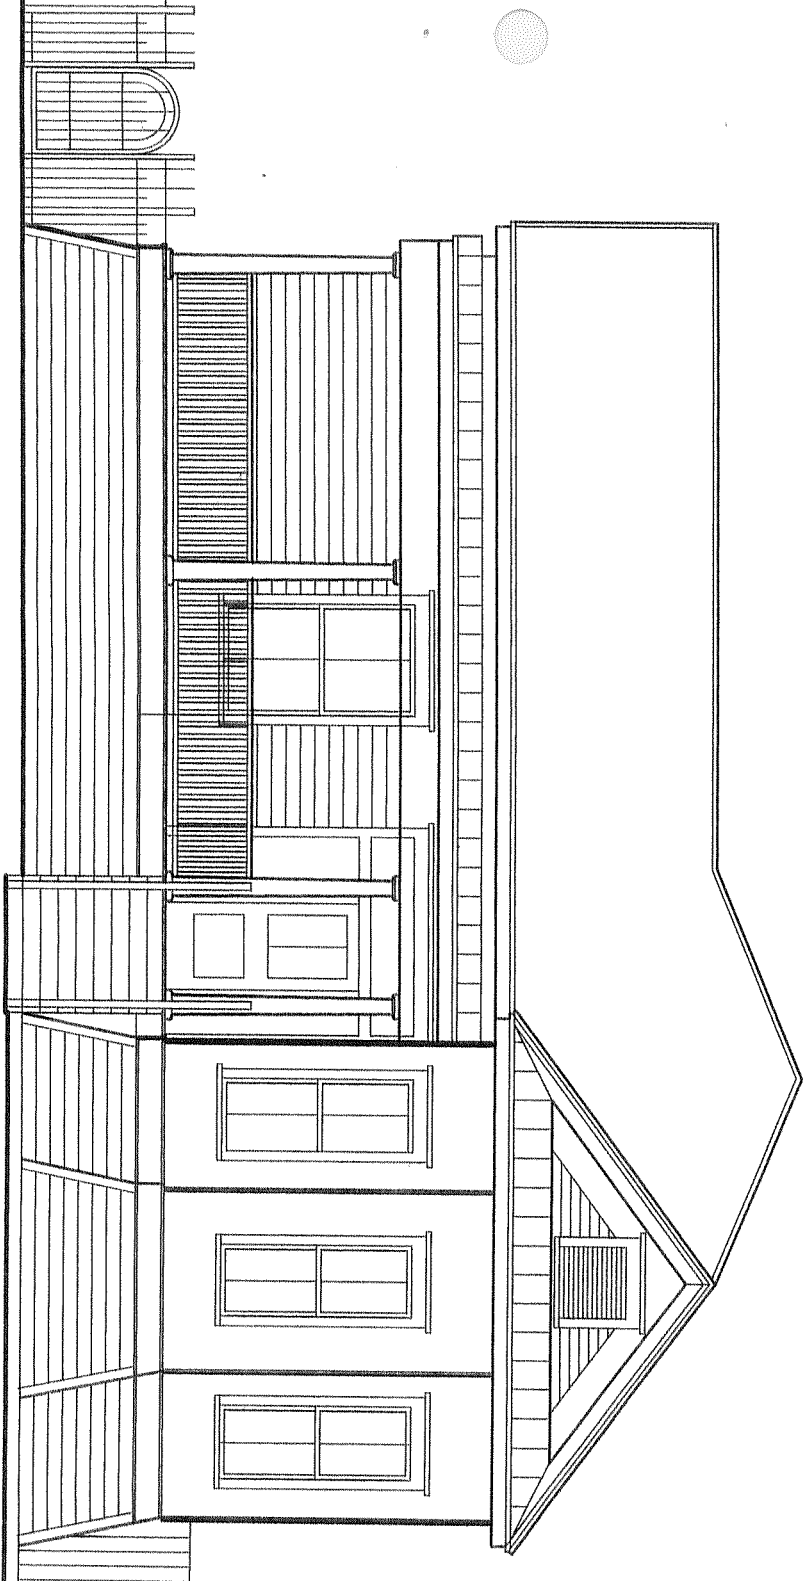



 HOLLAND
ARCHITECTURAL
1413 PRESTON AVE
AUSTIN, TEXAS 78703
512-577-2061




KAVOUSSI OFFICE
REMODEL ADDITION
1405 EAST CESAR CHAVEZ STREET
AUSTIN, TEXAS 78701

COVER
A0

APR. 25, 2016



 HOLLAND
ARCHITECTURAL
1413 PRESTON AVE
AUSTIN, TEXAS 78703
512-577-2061





KAVOUSSI OFFICE
REMODEL ADDITION
1405 EAST CESAR CHAVEZ STREET
AUSTIN, TEXAS 78702

COVER
A0

APR. 15, 2016



FRONT	15'
SIDE	NONE
BACK	NONE

EAST CESAR CHAVEZ STREET
60' ROW

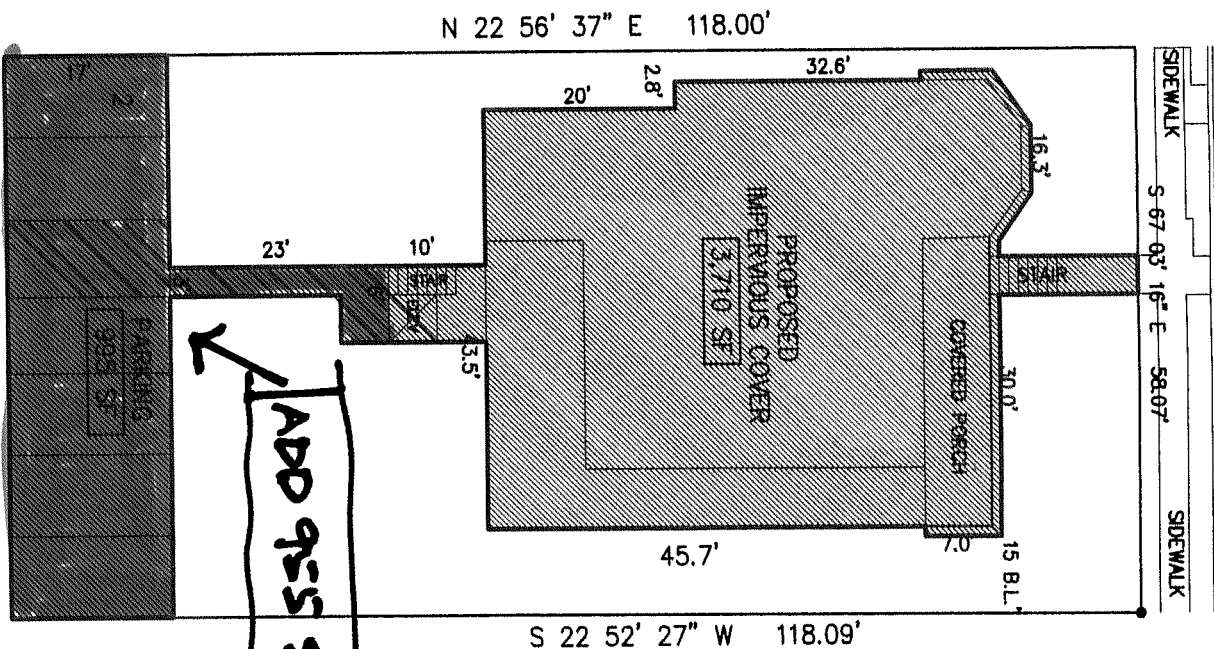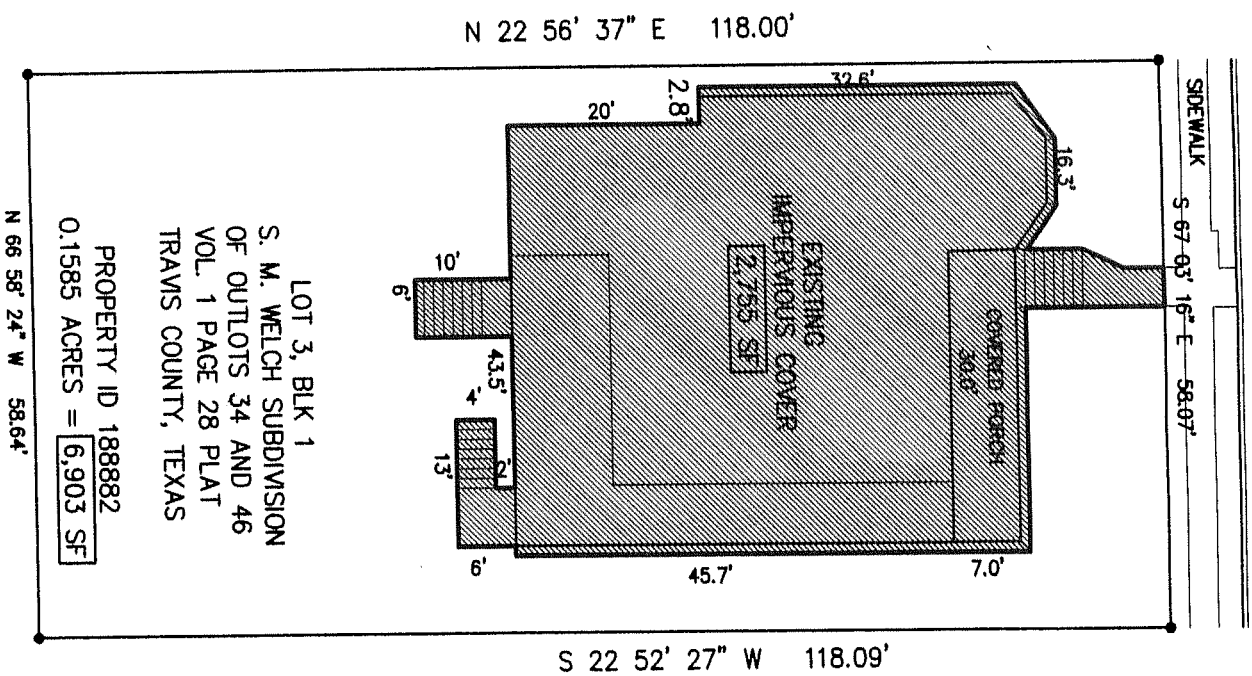

FRONT	15'
SIDE	NONE
BACK	NONE

60' ROW EAST CESAR CHAVEZ STREET 60' ROW

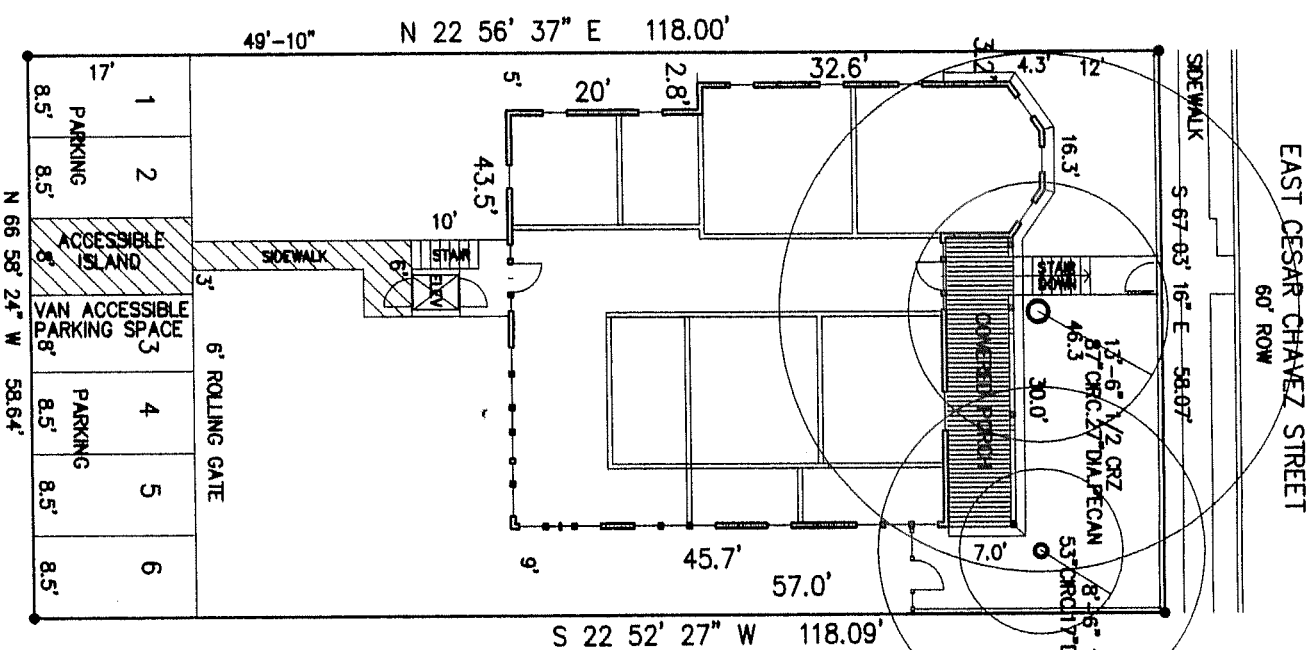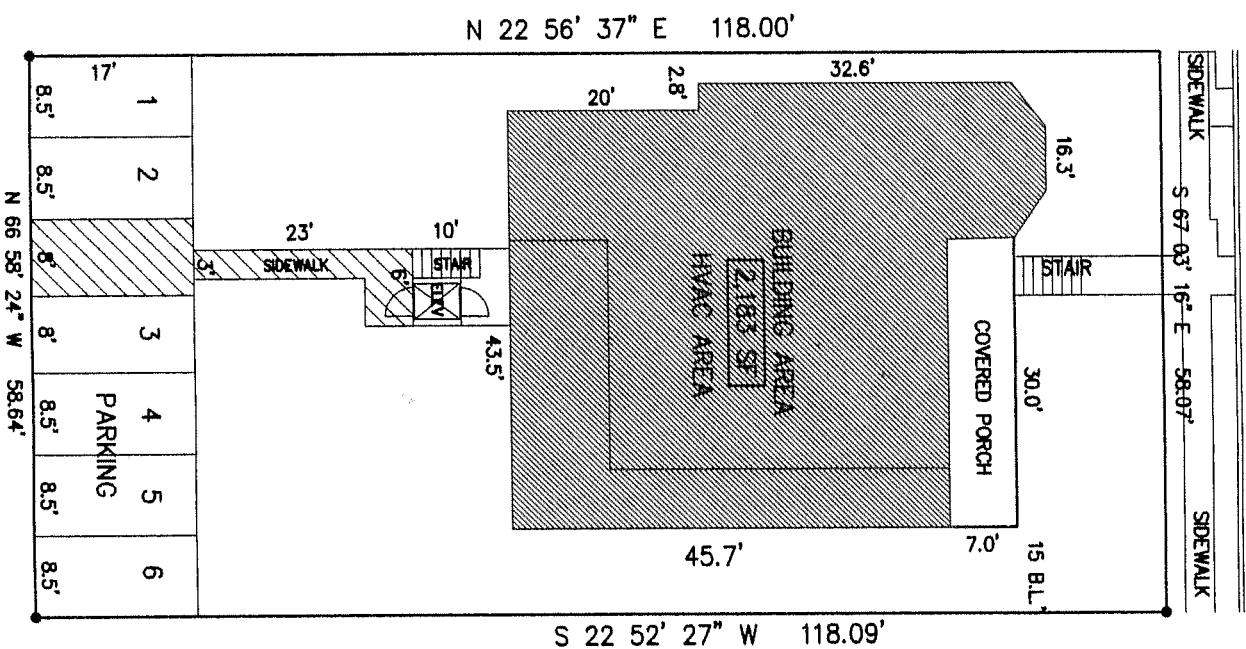

SITE PLAN 2,183 SF/6,903 SF = .32 FAR

0.1585 ACRES = 6,903 SF
BUILT YEAR 1900 = HISTORIC

SCALE 1"=20'-0"



SITE PLAN

0.1585 ACRES = 6,903 SF

3 SF SCALE 1"=20'-0"



8/2/20

HOLLAND
ARCHITECTURAL
1413 PRESTON AVE
AUSTIN, TEXAS 78703
512-577-2061



KAVOUSSI OFFICE
REMODEL ADDITION
1405 EAST CESAR CHAVEZ STREET
AUSTIN, TEXAS 78702

A1.1

APR. 25, 2016

BUILT YEAR: 1900
SITE PLAN

0.1585 ACRES = 6,903 SF SCALE 1"=20'-0"

903 SF SCALE 1"=20'-0"



SITE PLAN

$$\frac{\text{COVERED AREA } 5,400 \text{ SF}}{\text{SITE AREA } 6,903 \text{ SF}} = 78 \% \text{ IMPERVIOUS COVER}$$

COVER

BUILT YEAR 1900
0.1585 ACRES = 6,903 SF


10' 2

81-682-10

HOLLAND
ARCHITECTURAL
1413 PRESTON AVE
AUSTIN, TEXAS 78703
512-577-2061



KAVOUSSI OFFICE
REMODEL ADDITION
1405 EAST CESAR CHAVEZ STREET
AUSTIN, TEXAS 78701



A1.2

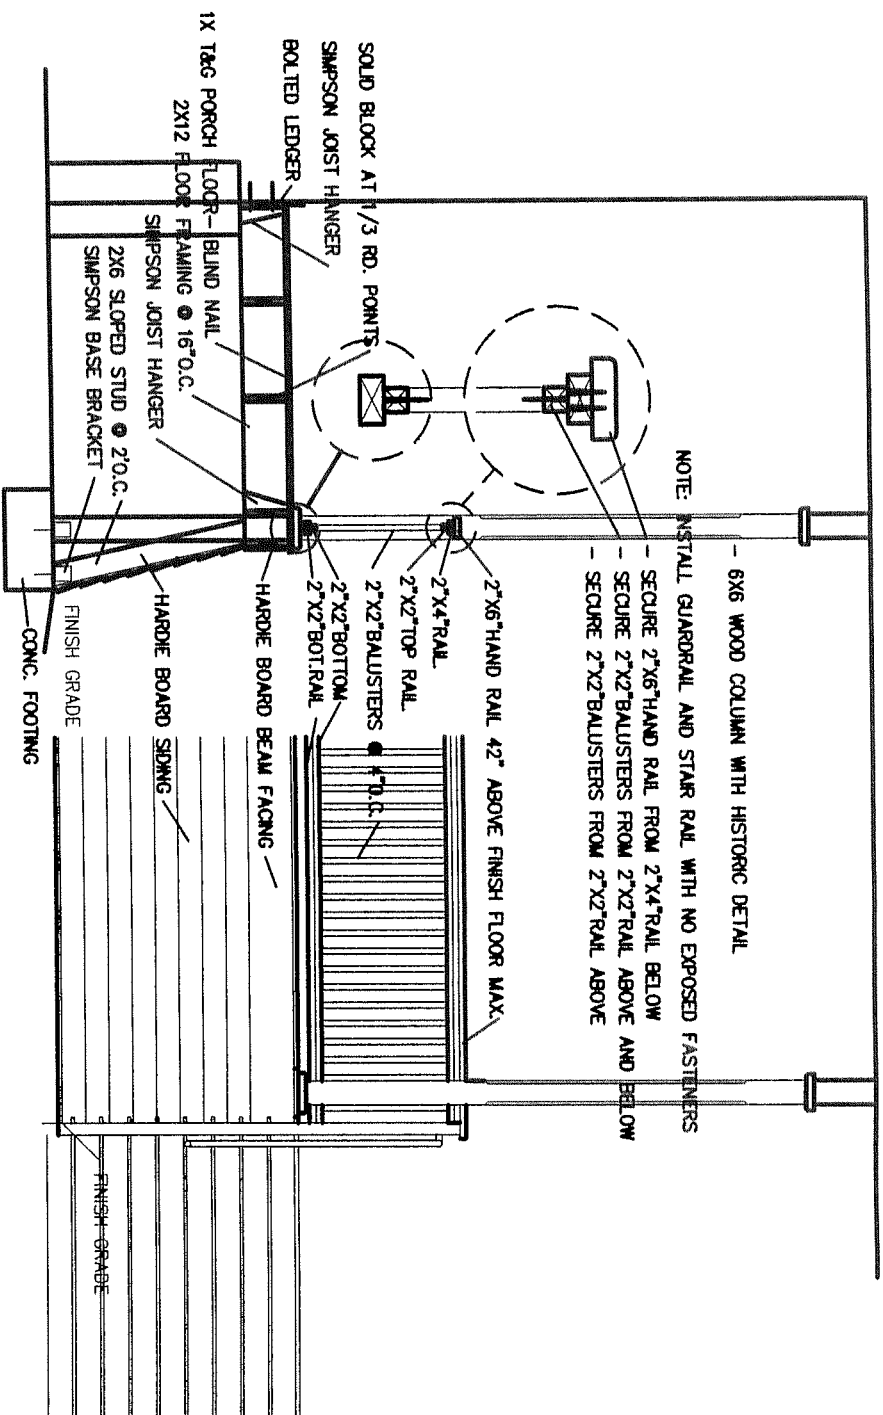

1 PORCH SECTION
SCALE 1/8"=1'-0"

 2 PORCH ELEV. DETAIL
SCALE 1/2"=1'-0"

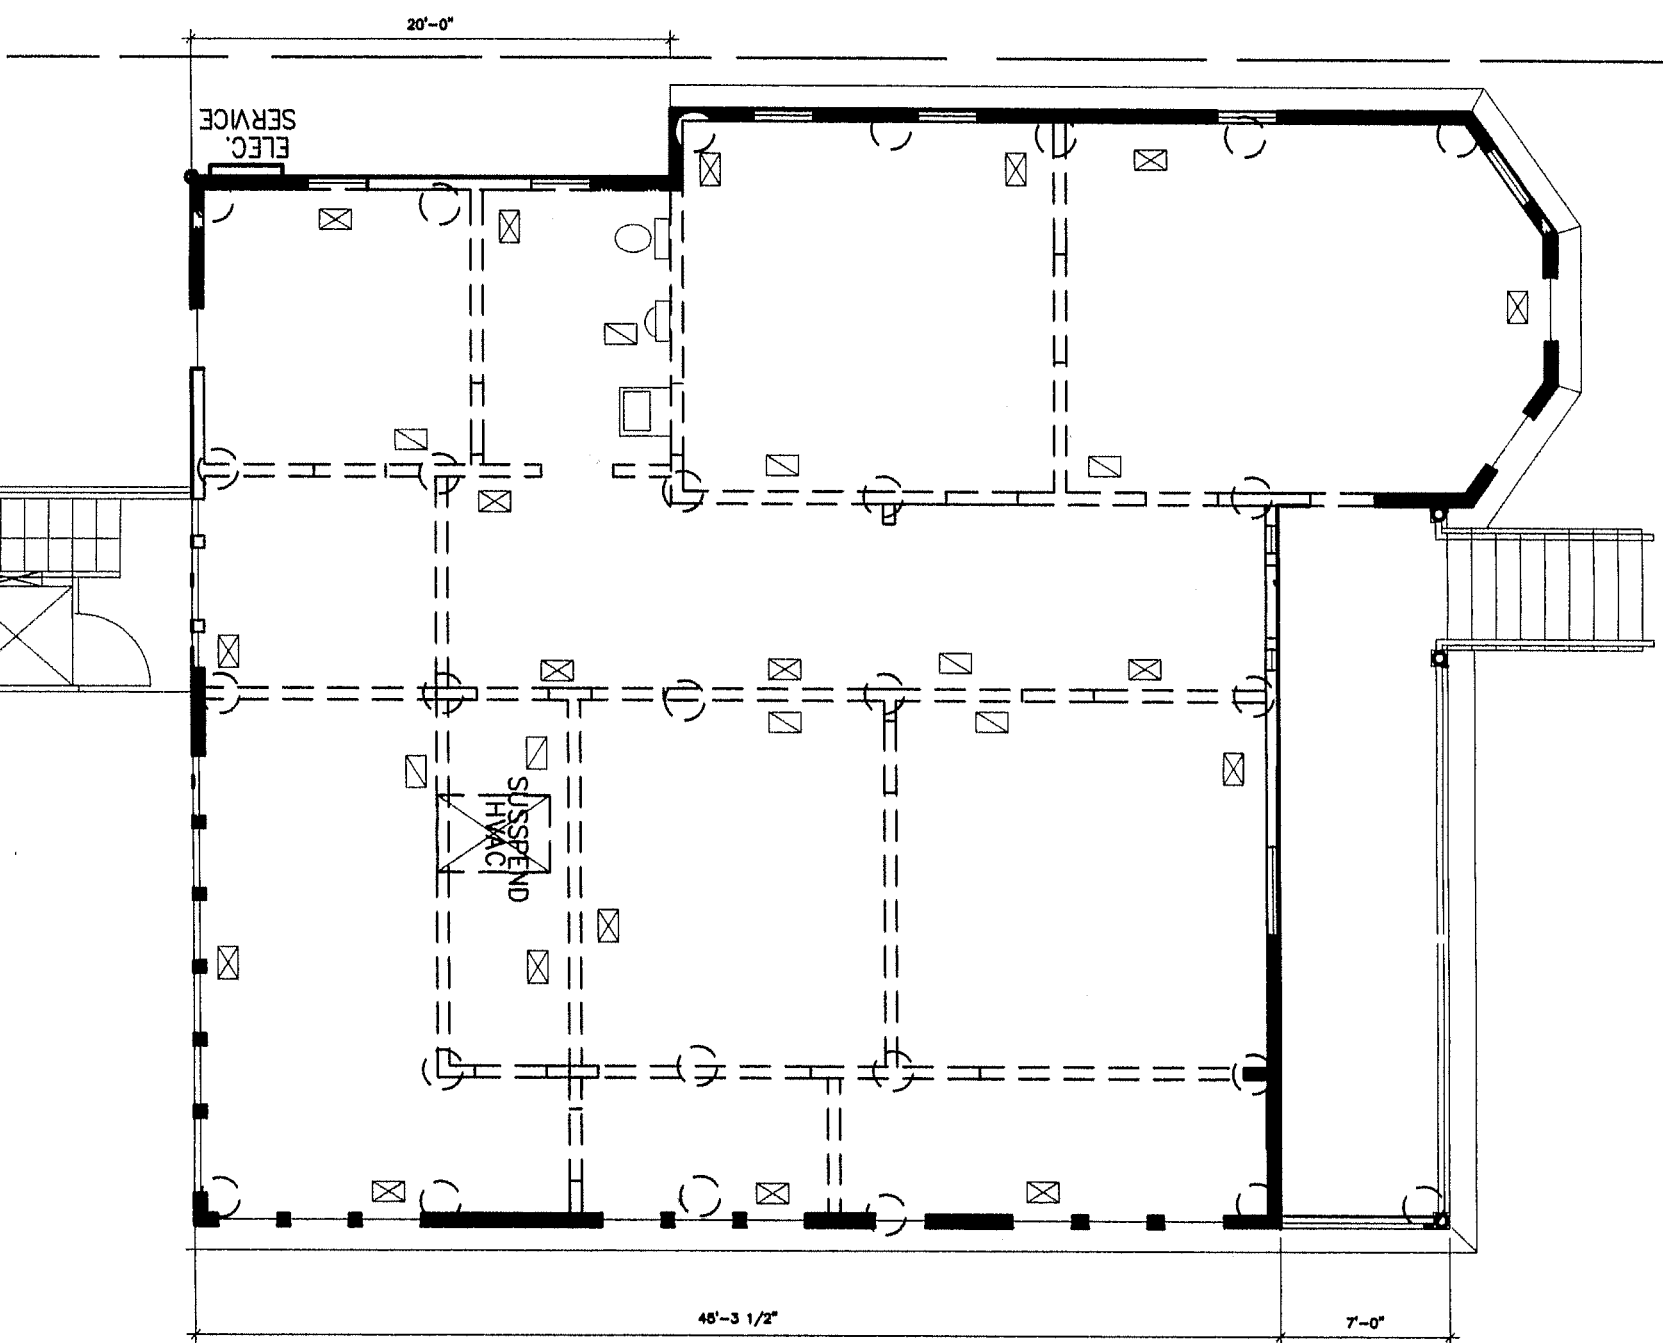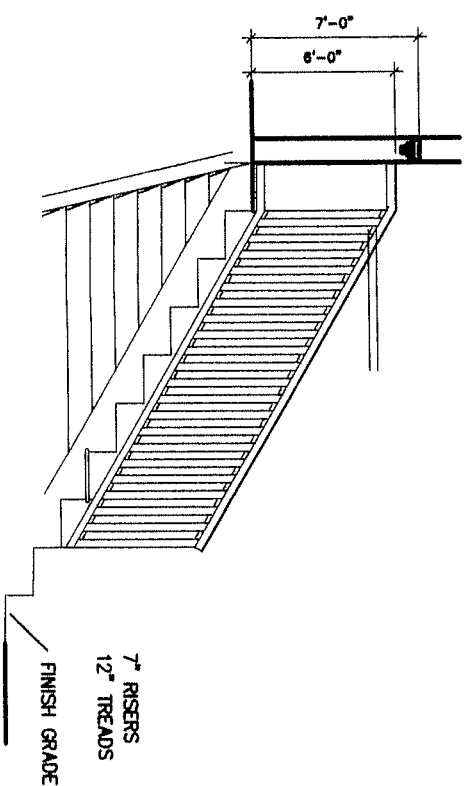

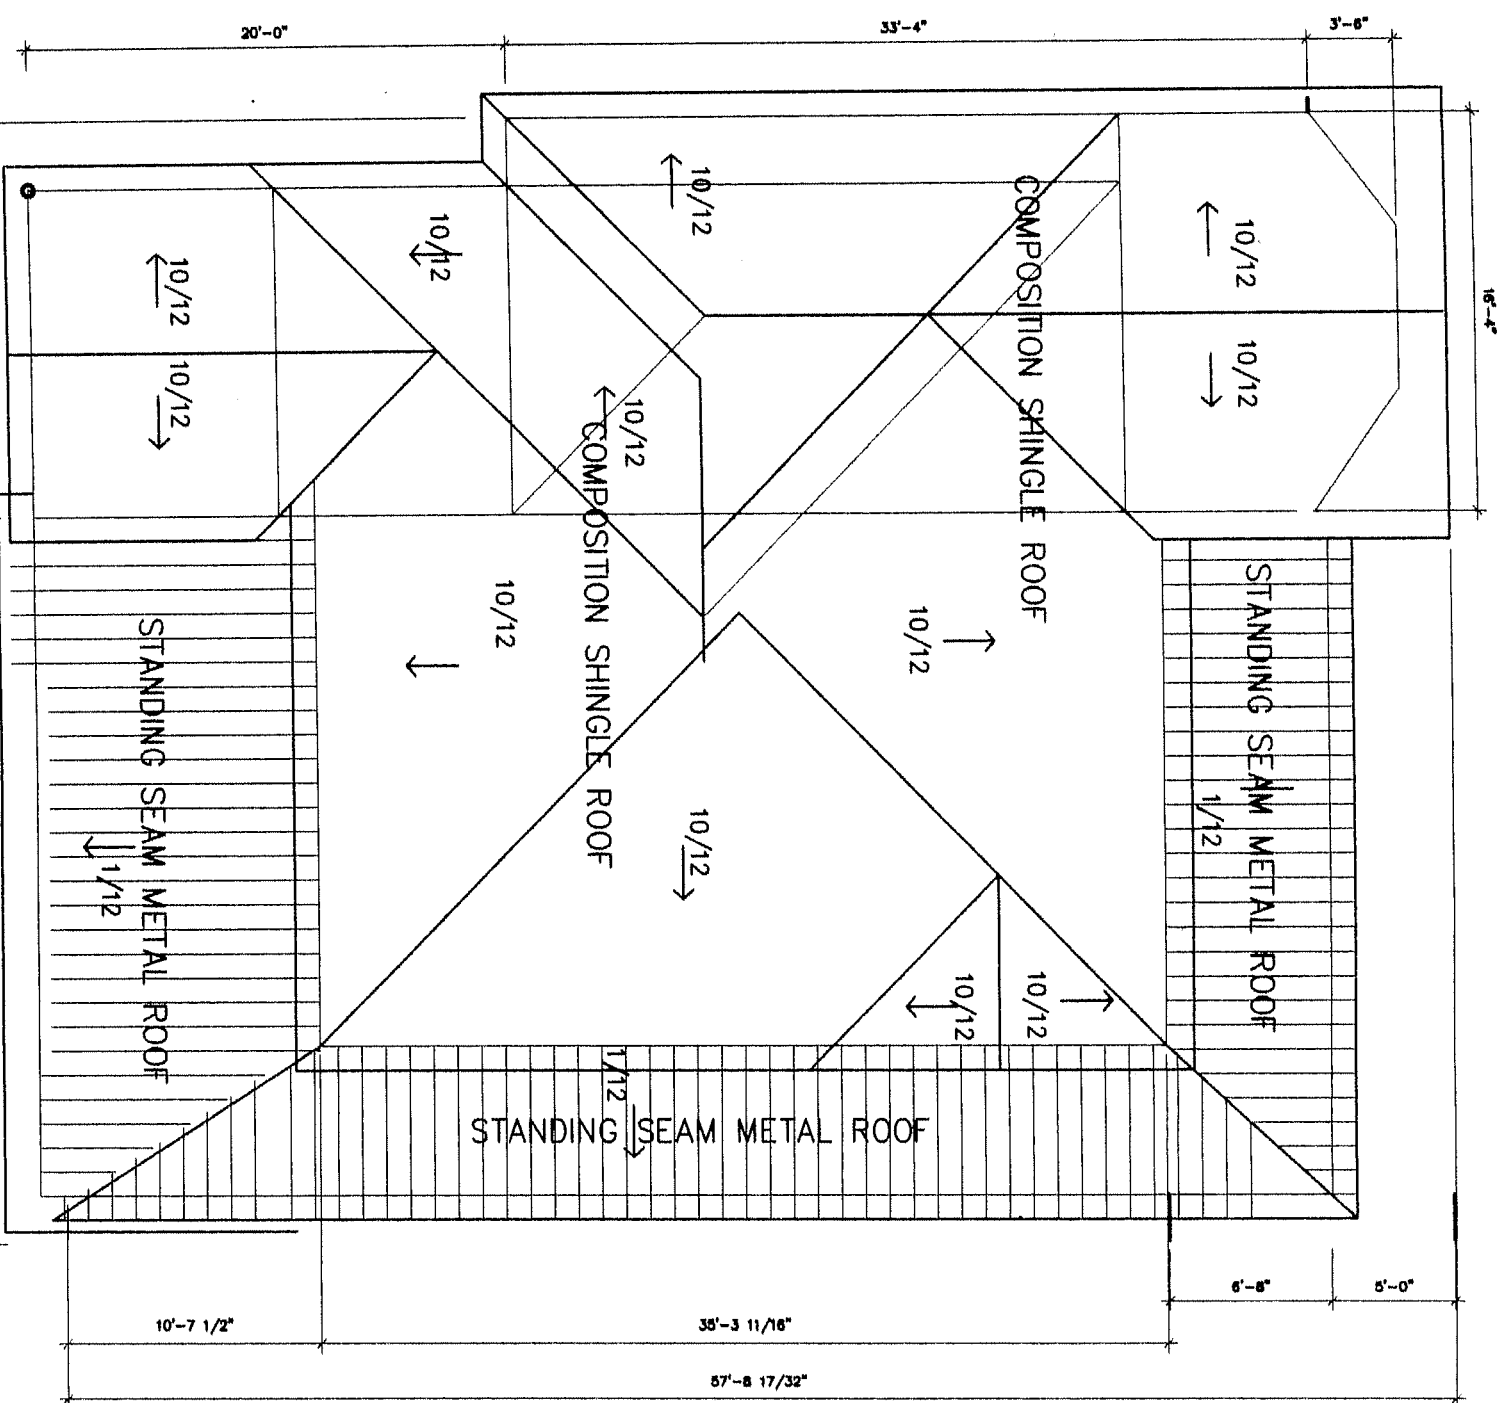


HOLLAND ARCHITECTURAL
1413 PRESTON AVE
AUSTIN, TEXAS 78703
512-577-2061

KAVOUSSI REMODEL
1405 EAST CESAR CHAVEZ STREET
AUSTIN, TEXAS 78702

ROOF PLAN

A3.1
APR. 25, 2016

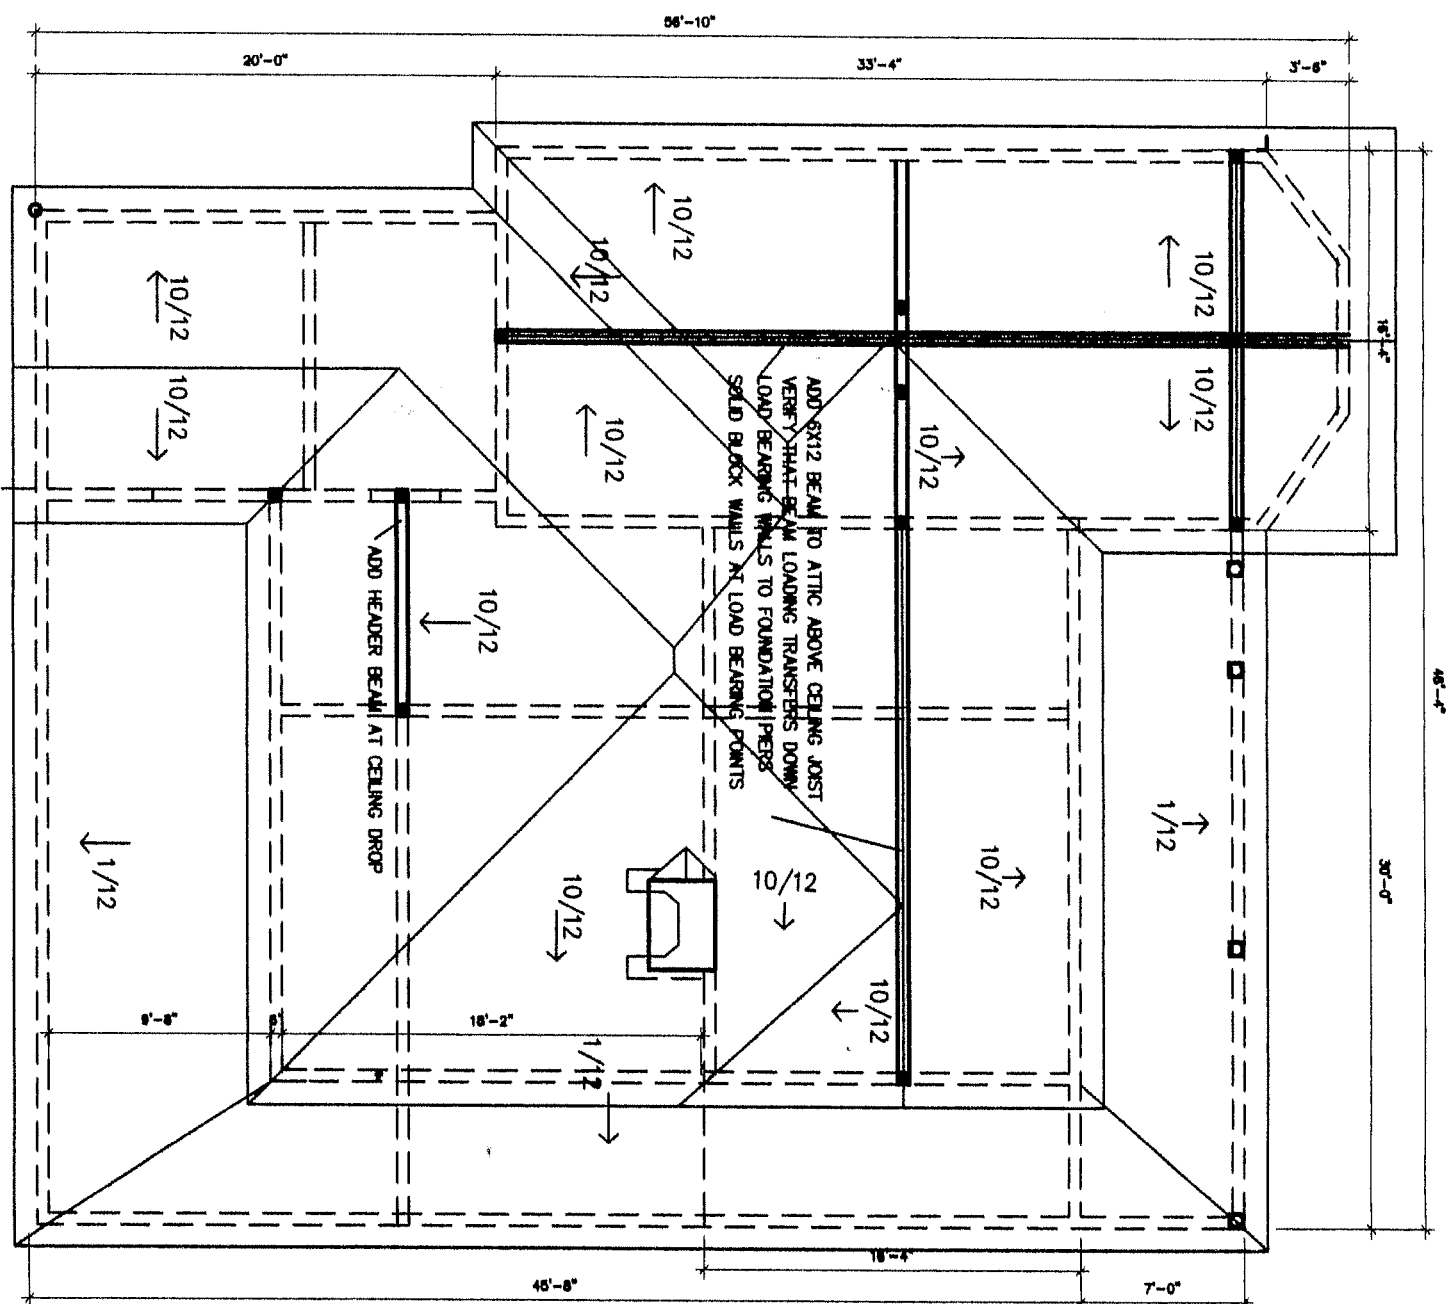


HOLLAND ARCHITECTURAL
1413 PRESTON AVE
AUSTIN, TEXAS 78703
512-577-2061

KAVOUSSI REMODEL
1405 EAST CESAR CHAVEZ
AUSTIN, TEXAS 78702

FLOOR FRAMING PLAN

A3.1
APR. 25, 2016

DOOR SCHEDULE

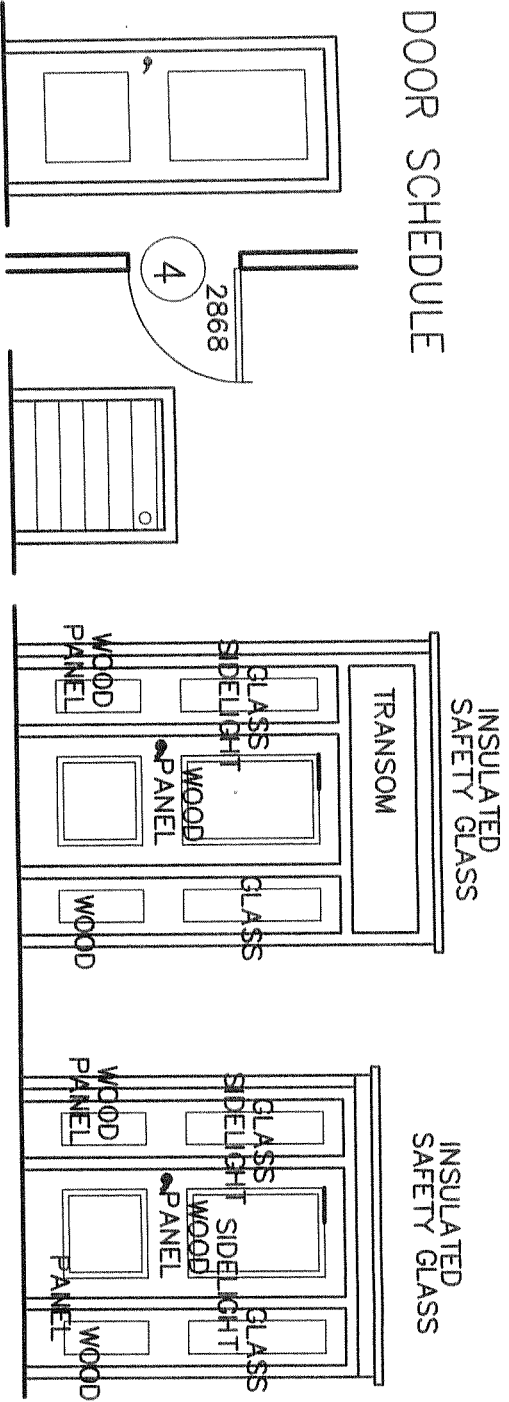

- B** PANEL **C** METAL CLAD **A** ENTRY **D** ENTRY

DOOR. NO	EXTERIOR	INTERIOR	REPLACE EXISTING NEW DOOR AND FRAME	REMOVE AND ENCLOSE WALL	DOOR AND SIDELIGHT PANEL	META; CLAD	TYPE	NOTE-VERIFY JAMB WIDTH AS REQUIRED MANUF: OWNER SELECTION TRIM TO MATCH: SEE DETAILS
1	☒		☒		☒		A	1 3/4" X 2'-8" X 6'-8"
2	☒		☒				D	1 3/4" X 3'-0" X 6'-8"
3								REMOVE/ENCLOSE
4								REMOVE/ENCLOSE
5	☒		☒		☒		B	1 3/8" X 3'-0" X 6'-8"
6	☒		☒		☒		B	1 3/8" X 2'-8" X 6'-8"
7	☒		☒		☒		B	1 3/8" X 2'-8" X 6'-8"
8	☒		☒		☒		B	1 3/8" X 3'-0" X 6'-8"
9							B	REMOVE/ENCLOSE
10	☒		☒		☒		B	1 3/8" X 3'-0" X 6'-8"
11							B	REMOVE/ENCLOSE
12	☒		☒		☒		B	1 3/8" X 3'-0" X 6'-8"
13	☒		☒		☒		B	1 3/8" X 3'-0" X 6'-8"
14	☒		☒		☒		B	1 3/8" X 3'-0" X 6'-8"
15	☒		☒		☒		B	1 3/8" X 3'-0" X 6'-8"
16	☒		☒		☒		B	1 3/8" X 3'-0" X 6'-8"
17	☒		☒		☒		B	1 3/8" X 3'-0" X 6'-8"
18	☒		☒		☒		C	1 3/8" X 3'-0" X 3'-8"

HOLLAND ARCHITECTURAL
1413 PRESTON AVE
AUSTIN, TEXAS 78703
512-577-2061

KAVOUSSI REMODEL


1405 EAST CESAR CHAVEZ STREET
AUSTIN, TEXAS 78702

DOOR SCHEDULE

A9.1

APR. 15, 2016

WINDOW SCHEDULE

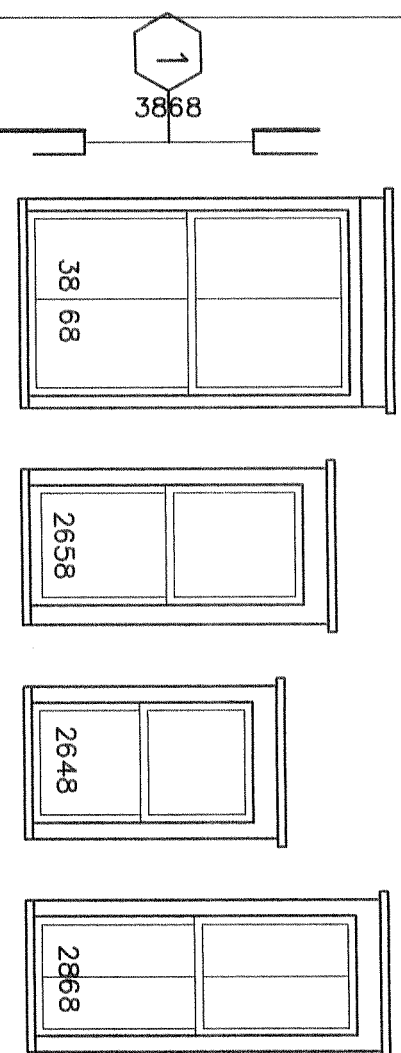

- A** WOOD DBL-HUNG **B** WOOD DBL-HUNG **C** WOOD DBL-HUNG **D** WOOD DBL-HUNG

NUMBER	TYPE	WOOD	GLASS	DIMENSION	PAINT	VERIFY JAMB WIDTH AS REQUIRED MANUF: OWNER SELECTION MANUF. HARDWARE FINISH-OIL RUB BRONZE U.ON.
1	A			3'-8" X 6'-8"		FRONT PORCH
2	B			2'-6" X 5'-8"		EAST SIDE
3	B			2'-6" X 5'-8"		EAST SIDE
4	B			2'-6" X 5'-8"		EAST SIDE
5	C			2'-6" X 4'-8"		EAST SIDE
6	B			2'-6" X 5'-8"		EAST SIDE
7	B			2'-6" X 5'-8"		EAST SIDE
8	B			2'-6" X 5'-8"		EAST SIDE
9	B			2'-6" X 5'-8"		EAST SIDE
10	B			2'-6" X 5'-8"		EAST SIDE
11	B			2'-6" X 4'-8"		BACK PORCH
12	C			2'-6" X 4'-8"		BACK PORCH
13	C			2'-6" X 4'-8"		BACK PORCH
14	C			2'-6" X 4'-8"		BACK PORCH
15	C			2'-6" X 4'-8"		BACK PORCH
16	C			2'-6" X 4'-8"		BACK PORCH
17	C			2'-6" X 4'-8"		BACK PORCH
18	D			2'-6" X 6'-8"		BACK/SOUTH
19	D			2'-6" X 6'-8"		WEST SIDE
20	C			2'-6" X 4'-8"		WEST SIDE
21	D			2'-6" X 6'-8"		WEST SIDE
22	D			2'-6" X 6'-8"		WEST SIDE
23	D			2'-6" X 6'-8"		NORTH BAY
24	D			2'-6" X 6'-8"		NORTH BAY
25	D			2'-6" X 6'-8"		NORTH BAY

HOLLAND ARCHITECTURAL
1413 PRESTON AVE
AUSTIN, TEXAS 78703
512-577-2061

KAVOUSSI REMODEL

1405 EAST CESAR CHAVEZ STREET
AUSTIN, TEXAS 78702

WINDOW SCHEDULE

A9

APR. 15, 2016