



SIGN COMPANY
www.FederalHealth.com

4602 North Avenue
Oceanside, CA 92056
[760] 941-0715 Fax [760] 631-5065

Manufacturing Facilities:
Oceanside, CA | Euless, TX | Jacksonville, TX | Delaware, OH

Office Locations:
Oceanside, CA | Las Vegas, NV | Laughlin, AZ
Isaiah Falls, ID | El Paso, TX | Jacksonville, TX | San Antonio, TX
Houston, TX | Corpus Christi, TX | Indianapolis, IN
Louisville, KY | Knoxville, TN | Galton, WI | Delaware, OH
Waukegan, IL | Tampa, MS | Atlanta, GA
Tampa, FL | Daytona Beach, FL | Orlando, FL

Building Quality Signage Since 1901

- Revisions
- R1 JG 1.27.16 Replace TBD with actual dim.
 - R2 BW 2.3.16 Revise depth of blade sign & clean up elev.
 - R3 BW 4.14.16 Increase depth of blade sign.
 - R4 & 22.16.08 Update All Specs Per 6/2016 Sub;
 - R5 & 25.16 Add "HBAR" Sign &

Account Rep: Saul Stankus

Project Manager: Lynn Anderson

Drawn By: Gene Bourbonnais

Project / Location:



901 Neches Street
Austin, TX
78701

Underwriters Laboratories Inc. nfc ELECTRICAL TO USE U.L. LISTED COMPONENTS AND SHALL MEET ALL N.E.C. STANDARDS
ALL ELECTRICAL SIGNAGE TO COMPLY WITH ALL N.E.C. STANDARDS INCLUDING THE PROPER GROUNDING AND BONDING OF ALL SIGNS

Client Approval/Date:

Landlord Approval/Date:

This original drawing is provided as part of a planned project and is not to be exhibited, copied or reproduced without the written permission of Federal Health Sign Company LLC or its authorized agent. © FHSC

Colors Depicted in This Rendering May Not Match Actual Material Finishes. Refer to Product Samples For Exact Color Match.

Job Number: 23-32213-10

Date: 30 June 2015

Sheet Number: 1 of 10

Design Number: 23-32213-10 R5



901 Neches Street
Hyatt House - Austin, TX
78701

CU-2016-0006

Building Quality Signage Since 1901

Revisions:
R1 10 127 16 Replace TBD with actual dim
R2 BW 2.3 16 Revise depth of blade sign & clean up elevs.
R3 BW 4 14 Increase depth of blade sign.
R4 8 22 16 CB Update All Specs Per 6/2016 Std;
R5 8 25 16 Add "HBAR" Sign E

Saul Stankus

Account Rep.

Lynn Anderson

Project Manager

Gene Bourbonnais

Drawn By

Project / Location



901 Neches Street
Austin, TX
78701

Underwriters Laboratories Inc. ELECTRICAL TO USE U.L. LISTED COMPONENTS AND SHALL MEET ALL N.E.C. STANDARDS
ALL ELECTRICAL SIGNS MUST COMPLY WITH U.L. STANDARDS AND BE INSTALLED IN ACCORDANCE WITH THE PROPER GROUNDING AND BONDING UP ALL LINES

Client Approval/Date

Landlord Approval/Date


This original drawing is provided as part of a planned project and is not to be exhibited, copied or reproduced without the written permission of Federal Heath Sign Company LLC or its authorized agent FHSC
Colors Depicted in This Rendering May Not Match Actual Material Finishes. Refer to Product Samples For Exact Color Match

Job Number: 23-32213-10

Date: 30 June 2015

Sheet Number: 2 of 10

Design Number: 23-32213-10 R5

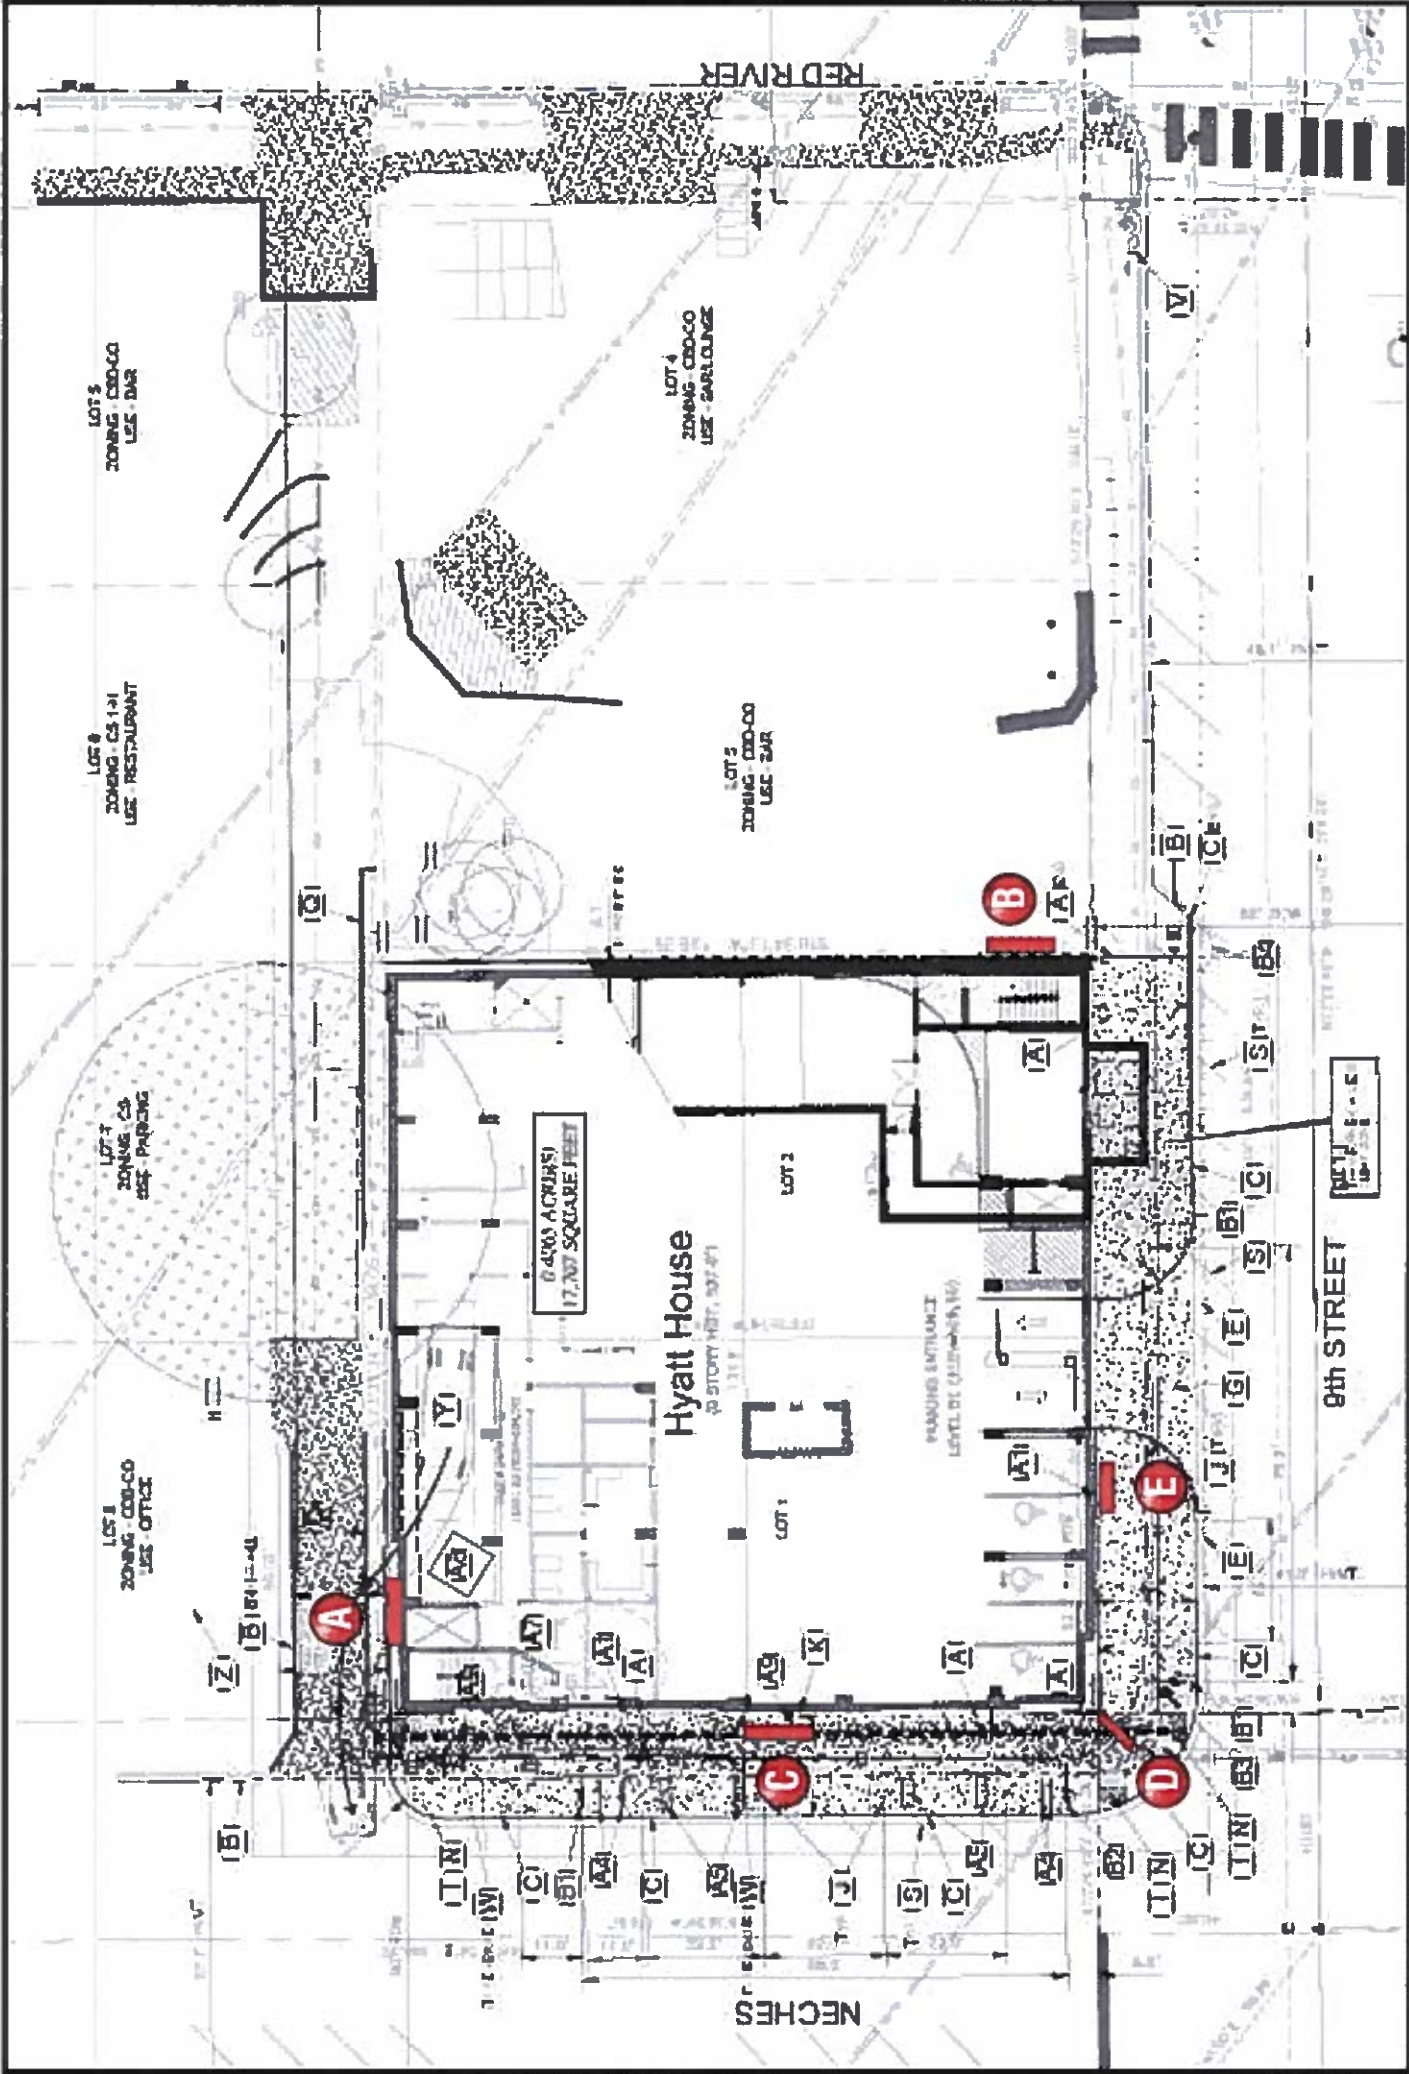

SITE PLAN

SIGN SCHEDULE

- A** INT. ILLUM. CHANNEL LETTERS / CIV-3L-3 / 93.5 SQ.FT.
- B** INT. ILLUM. CHANNEL LETTERS / CIV-3L-3 / 93.5 SQ.FT.
- C** INT. ILLUM. CHANNEL LTRS (RCWY) / CIH-1L3H-1 / 71.5 SQ.FT.
- D** INT. ILLUM. D/F BLADE SIGN / 198.33 SQ.FT.

- E** INT. ILLUM. CHANNEL LETTERS / CIV-3L-3 / 93.5 SQ.FT.

Manufacturing Facilities: Oceanside, CA - Elbert, TX - Jacksonville, TX - Delaware, OH	Office Locations:
	Oceanside, CA - Las Vegas, NV - Laughlin, AZ Isidro Falls, ID - Elbert, TX - Jacksonville, TX - San Antonio, TX Houston, TX - Corpus Christi, TX - Indianapolis, IN Louisville, KY - Knoxville, TN - Canton, WI - Delaware, OH Waynesboro, VA - Turin, MS - Atlanta, GA Tempe, AZ - Daytona Beach, FL - Orlando, FL

Building Quality Signage Since 1901

REVISIONS
R1 IG 1.27.16 Replace T80 with actual dim.
R2 BW 2.3.16 Reverse depth of blade sign & clean up elevs.
R3 BW 4.14.16 Increase depth of blade sign
R4 8.22.16 GB Update All Specs Per 6/2016 Specs
R5 8.25.16 Add "HBAK" Sign E

Account Rep **Saul Stankus**

Project Manager **Lynn Anderson**

Drawn By **Gene Bourbonnais**

Project / Location:



901 Neches Street
Austin, TX
78701

Underwriters Laboratories Inc. **UL** **ETC** **FHSC**
ELECTRICAL TO USE U.L. LISTED COMPONENTS AND SHALL BE INSTALLED IN ACCORDANCE WITH THE ELECTRICAL CODES AND STANDARDS OF THE M.C. STANDARD, INCLUDING THE PROPER GROUNDING AND BONDING OF ALL SIGNS

Client Approval/Date

Landlord Approval/Date


This original drawing is provided as part of a planned project and is not to be exhibited, copied or reproduced without the written permission of Federal Heath Sign Company LLC or its authorized agent. © FHSC
Colors Depicted In This Rendering May Not Match Actual Material Finishes. Refer To Product Samples For Exact Color Match.

Job Number: **23-32213-10**

Date: **30 June 2015**

Sheet Number: **3** or **10**

Design Number: **23-32213-10 R5**

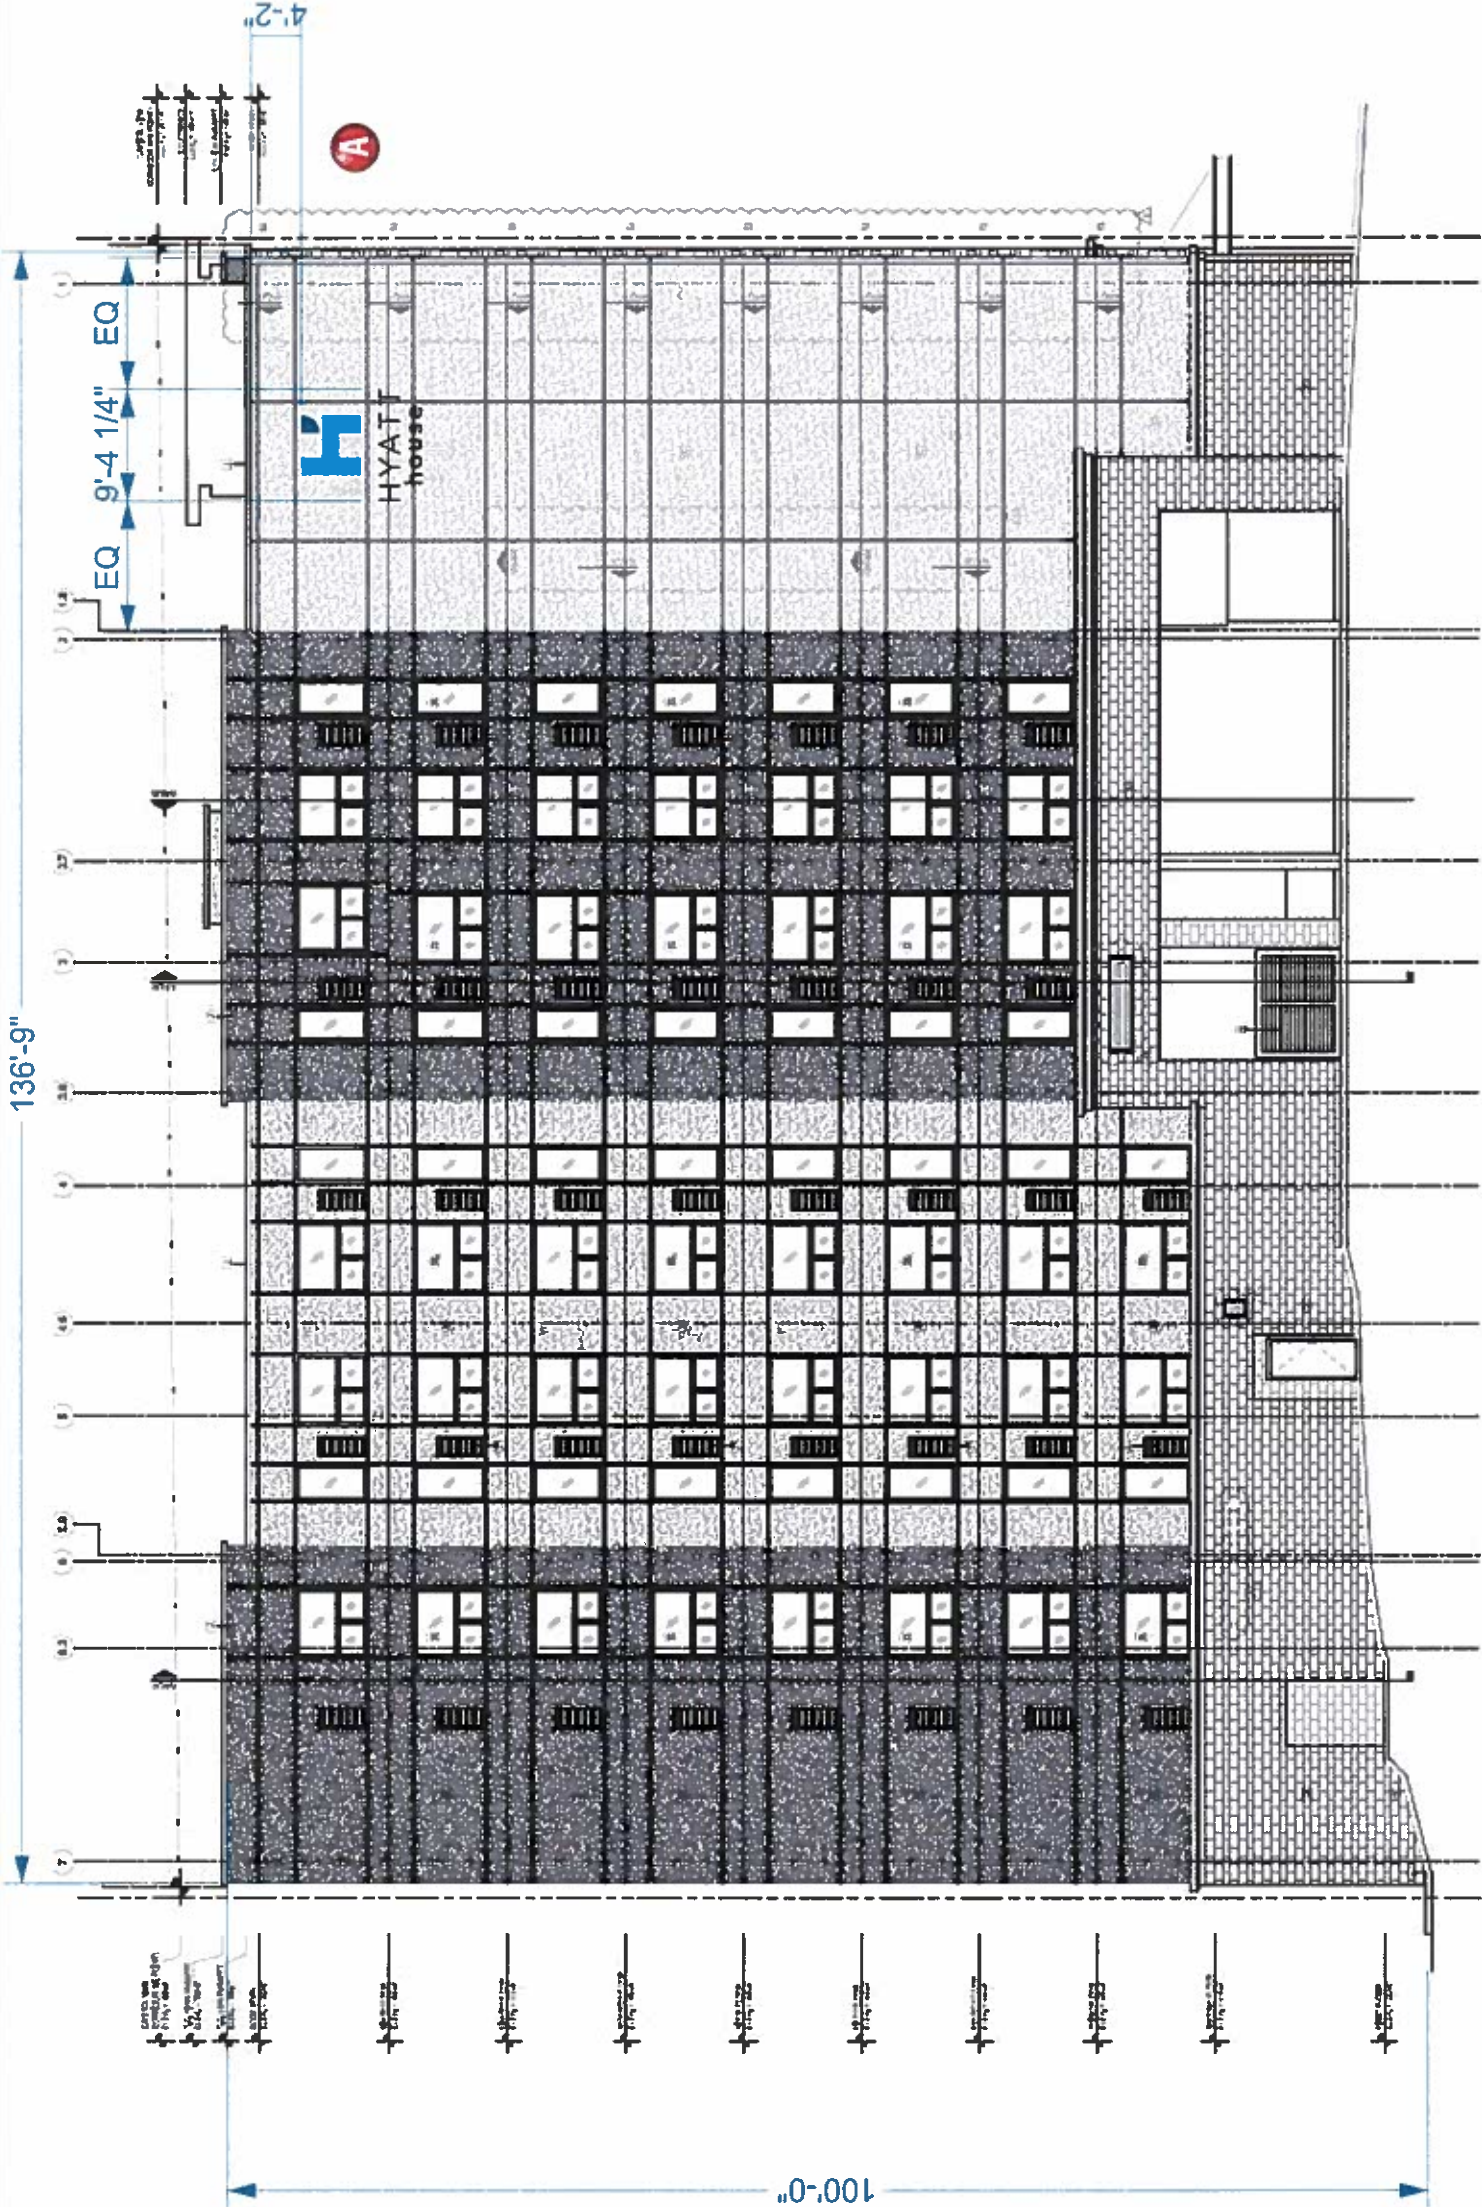

A NORTH ELEVATION - SCALE: 1/16" = 1'-0"

Manufacturing Facilities:	
Oceanside, CA	Eufess, TX
Jacksonville, TX	Delaware, OH
Other Locations:	
Oceanside, CA	Las Vegas, NV
Laughlin, AZ	Island Park, ID
Eufess, TX	Jacksonville, TX
San Antonio, TX	Houston, TX
Corpus Christi, TX	Indianapolis, IN
Louisville, KY	Knoxville, TN
Granton, WI	Delaware, OH
Waukegan, IL	Tulaca, MS
Atlanta, GA	Tampa, FL
Daytona Beach, FL	Orlando, FL

Building Quality Signage Since 1901

Revisions:
R1 JG 1.27.16 Replace TBD with actual dim
R2 BW 2.3.16 Revise depth of blade sign & clean up elevs.
R3 BW 4.14.16 Increase depth of blade sign.
R4 B.ZZ.16 GB Update All Specs Per 6/2016 Specs;
R5 B.ZS.16 Add "HBAR" Sign E

Account Rep: Saul Stankus

Project Manager: Lynn Anderson

Drawn By: Gene Bourbonnais

Project / Location:



901 Neches Street
Austin, TX
78701

Underwriters Laboratories Inc. ELECTRICAL TO USE UL LISTED COMPONENTS AND SHALL MEET ALL N.E.C. STANDARDS
ALL ELECTRICAL SIGNS ARE TO COMPLY WITH U.L. 48 AND THE PROPER GROUNDING AND BONDING OF ALL SIGNS

Client Approval/Date

Landlord Approval/Date:


This original drawing is provided as part of a planned project and is not to be exhibited, copied or reproduced without the written permission of Federal Heath Sign Company LLC or its authorized agent FHSC
Colors Depicted In This Rendering May Not Match Actual Material Finishes. Refer to Product Samples For Exact Color Match

Job Number: 23-32213-10

Date: 30 June 2015

Sheet Number: 4 of 10

Design Number: 23-32213-10 R5

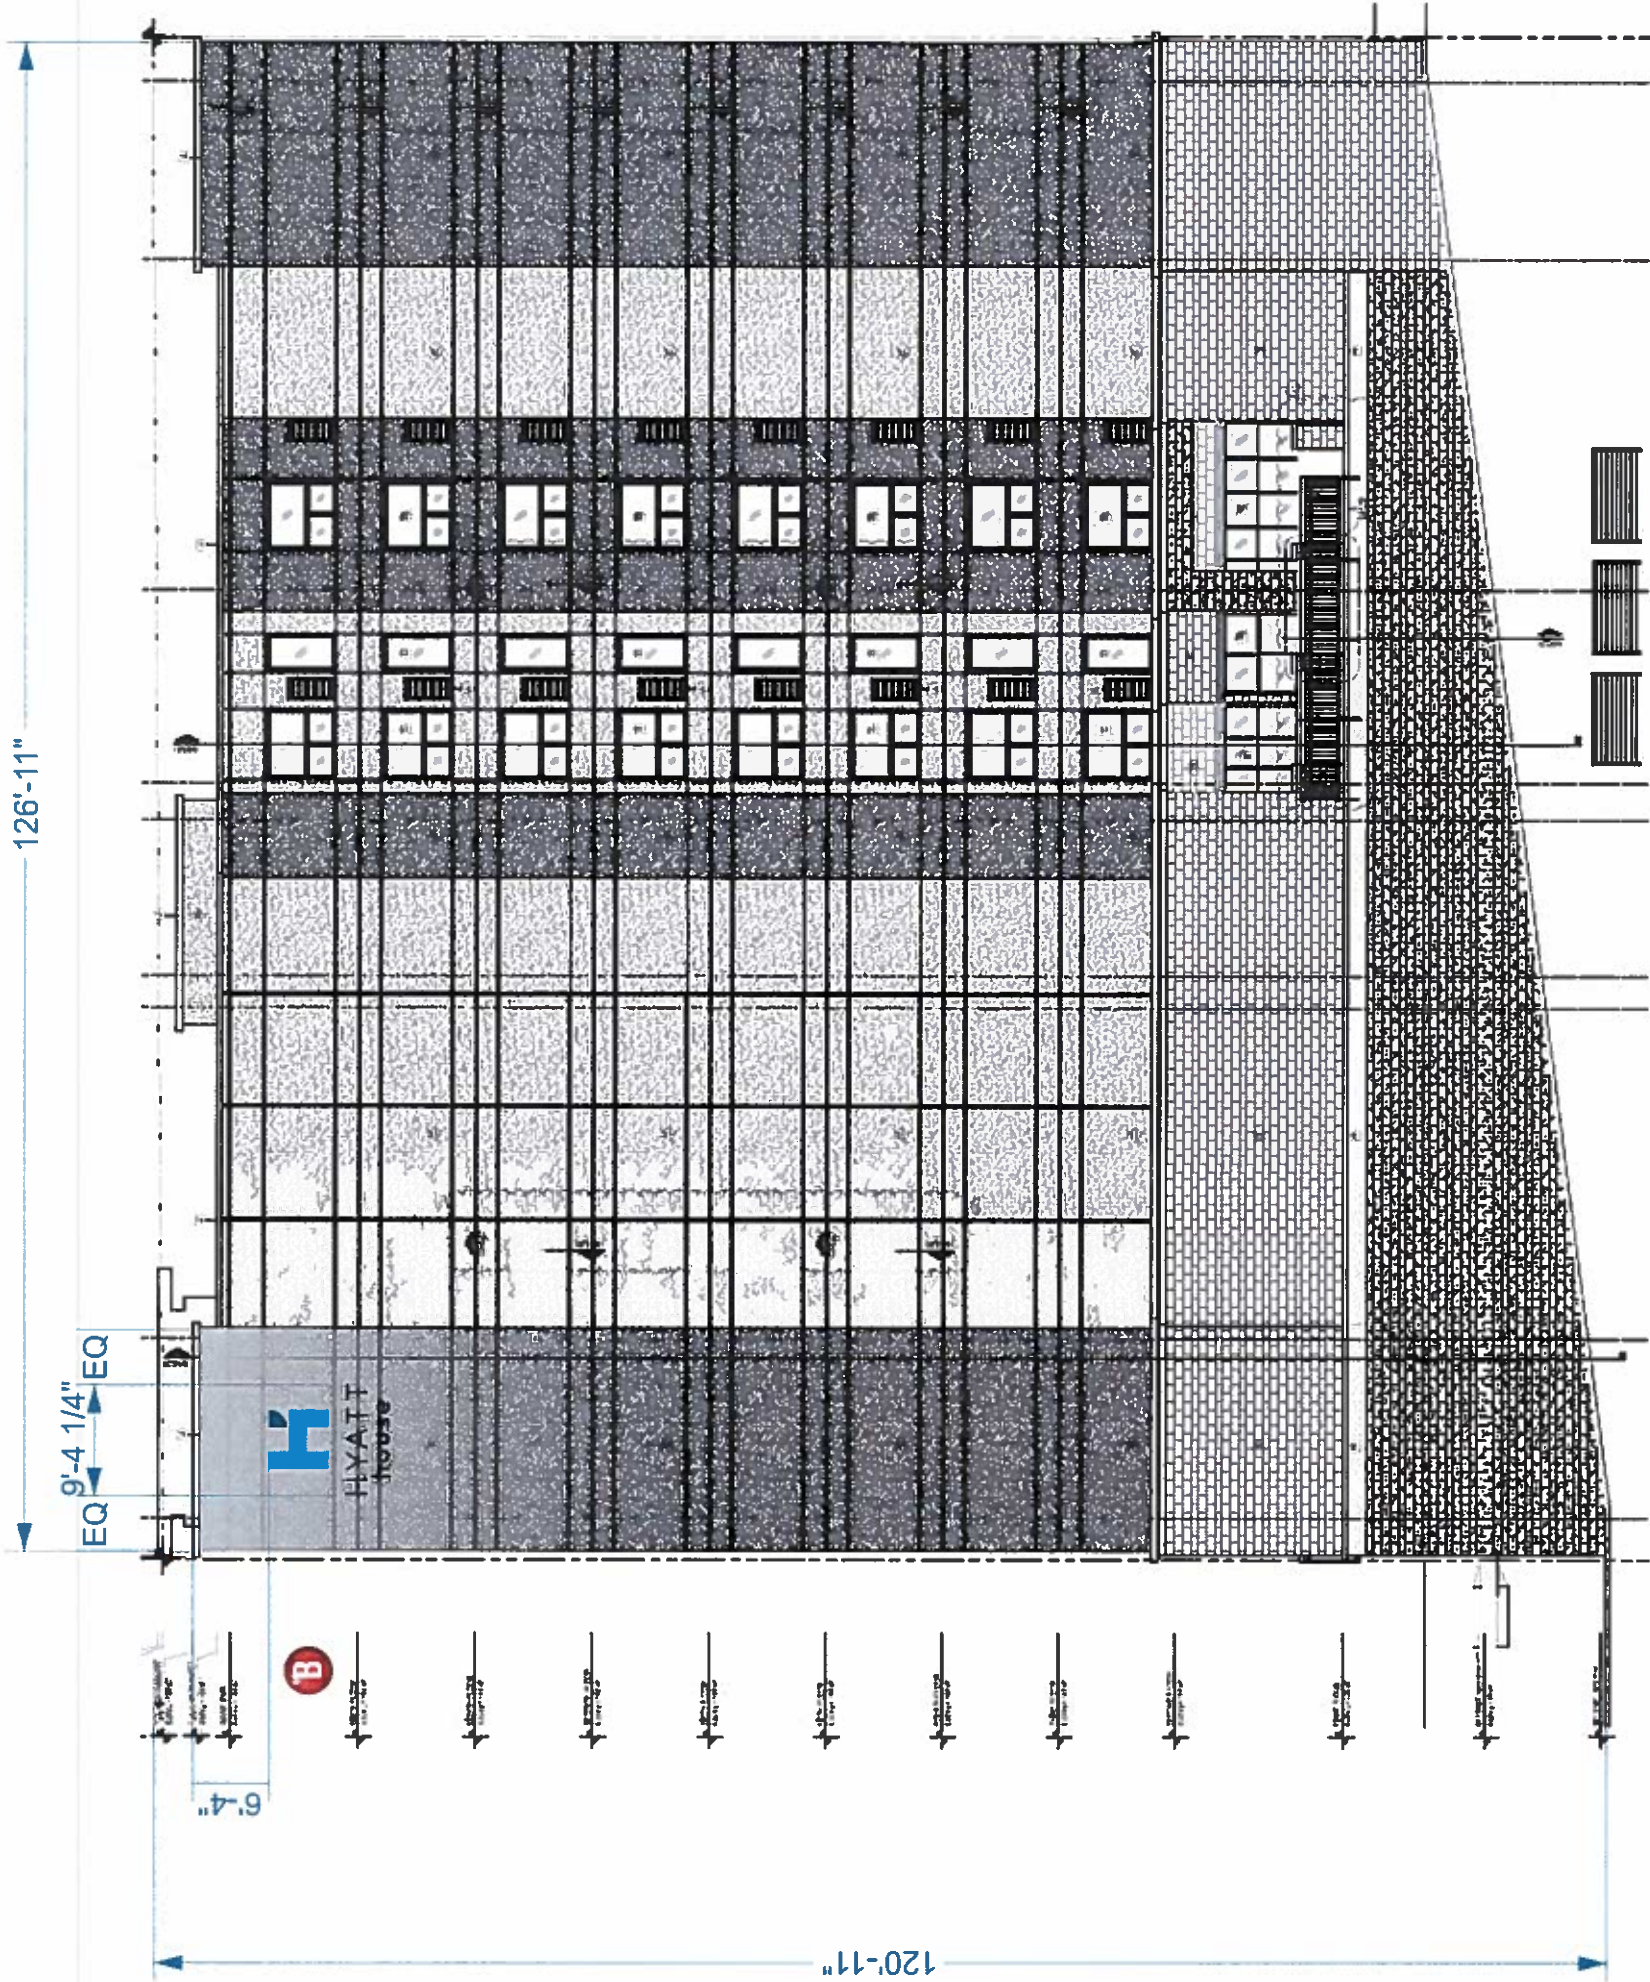

B EAST ELEVATION - SCALE: 1/16" = 1'-0"

Manufacturing Facilities	
Oceanside, CA	East, TX - Jacksonville, TX - Delaware, OH
Office Locations	
Oceanside, CA	Las Vegas, NV - Laughlin, AZ
Idaho Falls, ID	El Paso, TX - Jacksonville, TX - San Antonio, TX
Houston, TX	Corpus Christi, TX - Indianapolis, IN
Louisville, KY	Knoxville, TN - Galton, WI - Delaware, OH
Wilkesboro, IL	Itasca, MS - Atlanta, GA
Lampa, FL	Daytona Beach, FL - Orlando, FL

Building Quality Signage Since 1901

REVISIONS:

- R1 1G 127 16 Replace TBD with actual dim.
- R2 BW 2 3 16 Revise depth of blade sign & clean up elevs.
- R3 BW 4 14 16 Increase depth of blade sign.
- R4 8 22 16 GB Update All Specs Per 6/2016 Sds;
- RS 8 25 16 Add "H&B" Sign E

Account Rep

Saul Stankus

Project Manager

Lynn Anderson

Drawn By:

Gene Bourbonnais

Project / Location



901 Neches Street
Austin, TX
78701

Underwriters Laboratories Inc. ELECTRONIC TO USE U.L. LISTED COMPONENTS AND SHALL MEET ALL N.E.C. STANDARDS
ALL ELECTRICAL SIGNS ARE TO COMPLY WITH U.L. 48 AND U.L. 1910. ALL SIGNS SHALL BE PROPERLY GROUNDING AND BONDING OF ALL SIGNS

Client Approval/Date:

Landlord Approval/Date

This original drawing is provided as part of a planned project and is not to be exhibited, copied or reproduced without the written permission of Federal Heath Sign Company LLC or its authorized agent. FHSC
Colors Depicted In This Rendering May Not Match Actual Material Finishes. Refer To Product Samples For Exact Color Match

Job Number:

23-32213-10


Date:

30 June 2015

Sheet Number:

5 of 10

Design Number: 23-32213-10 R5

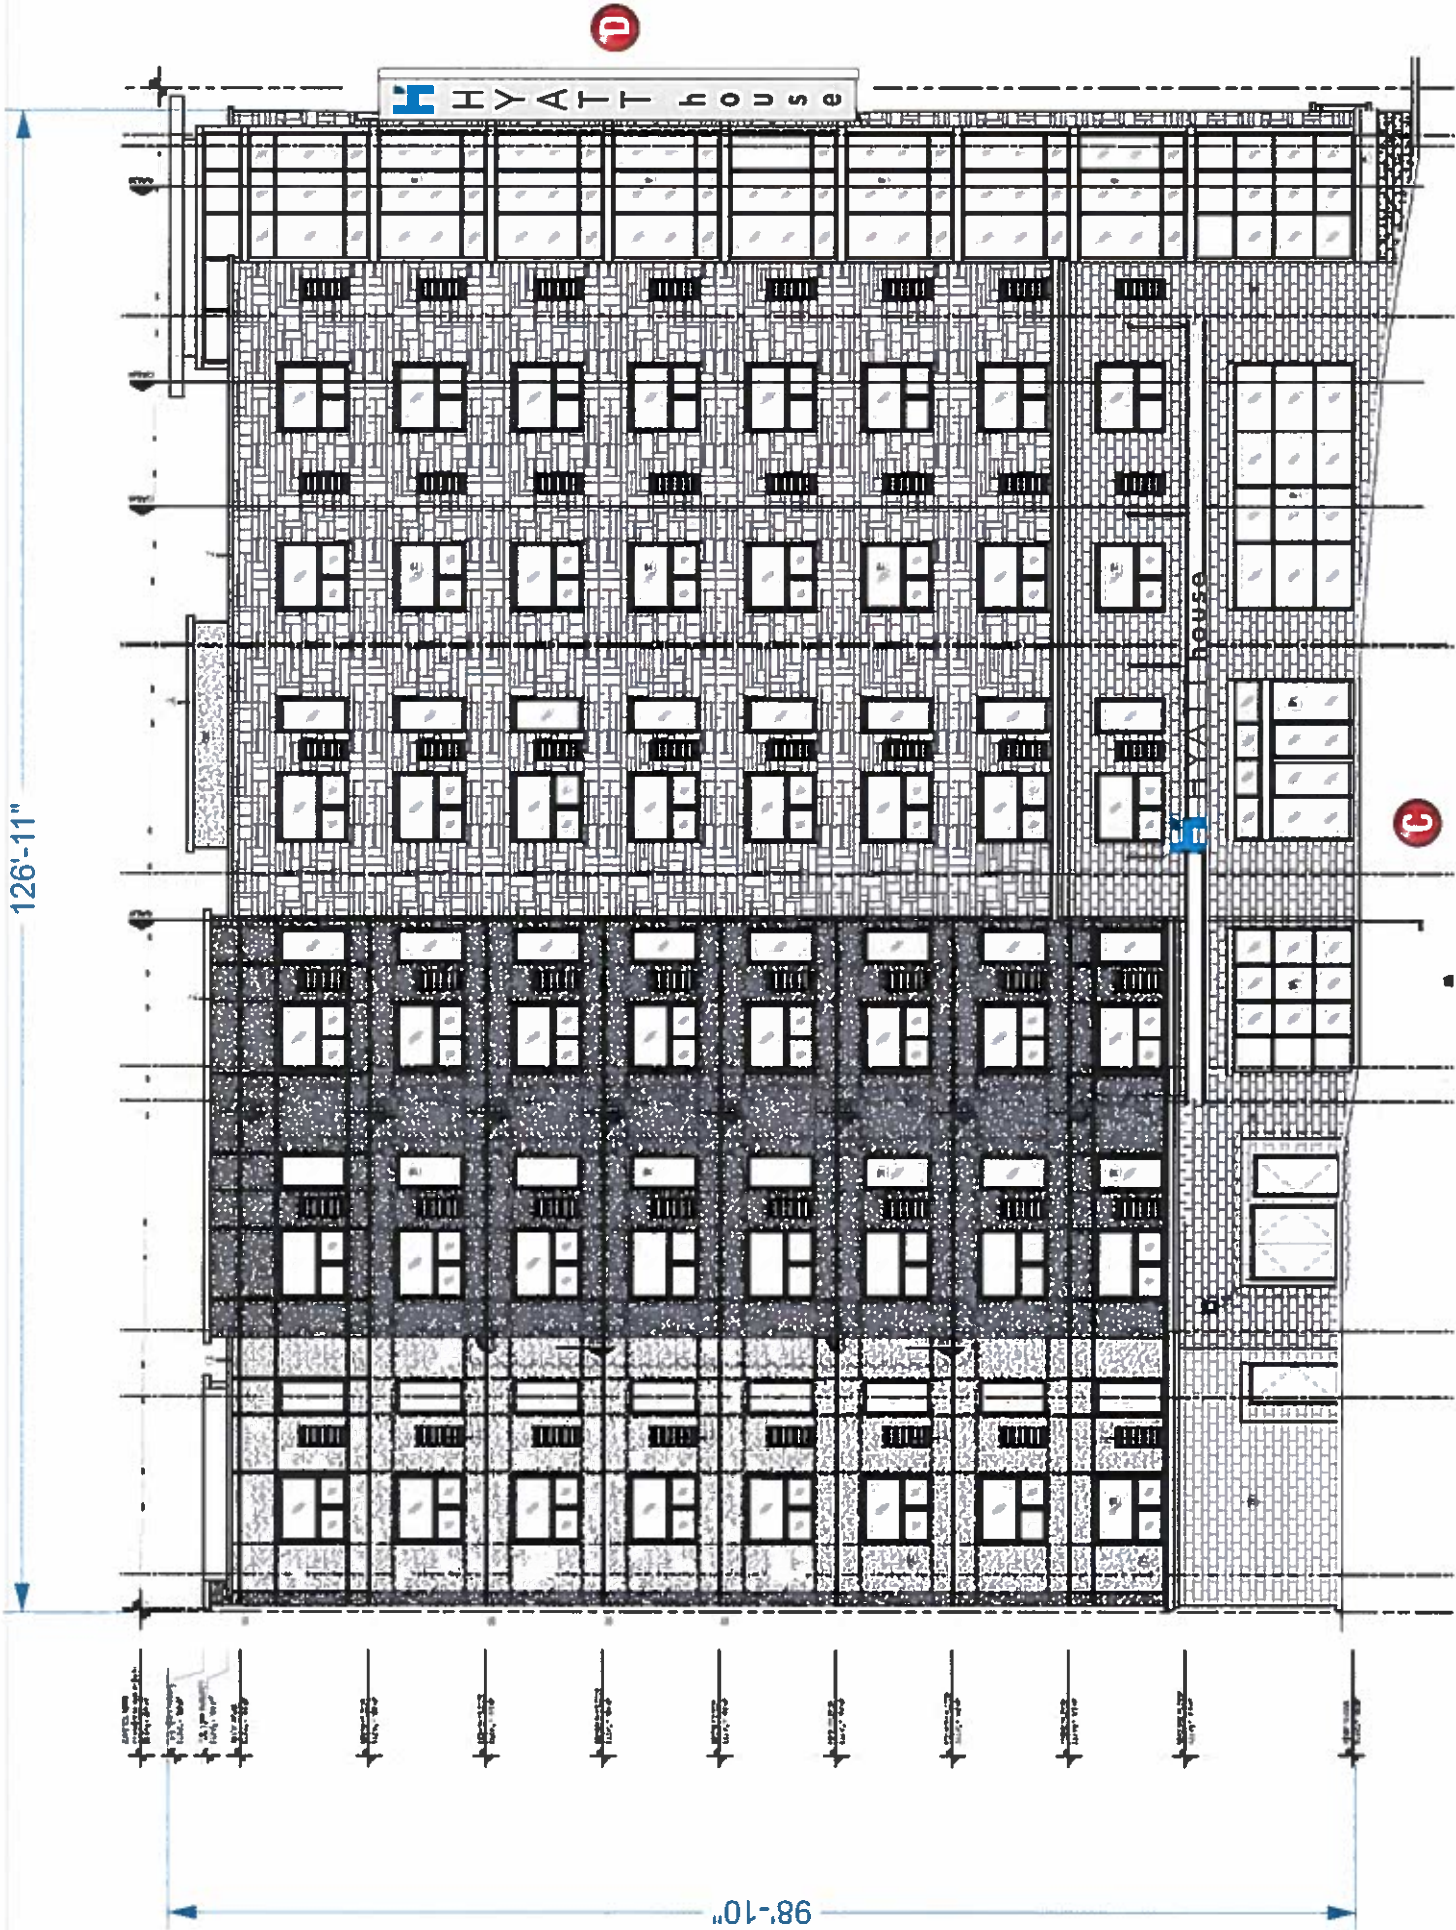

C D WEST ELEVATION - SCALE: 1/16" = 1'-0"

Building Quality Signage Since 1901

REVISIONS:

- R1 JG 1 27 16 Replace TBD with actual dim.
- R2 BW 2 3 16 Revise depth of blade sign & clean up elevs
- R3 BW 4 14 16 Increase depth of blade sign.
- R4 8 22 16 GB Update All Specs Per 6/2016 Specs
- R5 8 25 16 Add "HBAR" Sign E

Account Rep

Saul Stankus

Project Manager

Lynn Anderson

Drawn By:

Gene Bourbonnais

Project / Location



901 Neches Street
Austin, TX
78701

Underwriters Laboratories Inc. ELECTRICAL TO USE ALL LISTED COMPONENTS AND SHALL MEET ALL N.E.C. STANDARDS
ALL ELECTRICAL SIGNS ARE TO COMPLY WITH U.L. 86 AND ALL ELECTRICAL SIGNS ARE TO BE TESTED AND APPROVED BY THE PEOPLE ORIGINATING AND BONDING OF ALL SIGNS

Client Approval/Date:

Landlord Approval/Date:

This original drawing is provided as part of a planned project and is not to be exhibited, copied or reproduced without the written permission of Federal Heath Sign Company LLC or its authorized agent. FHSC
Colors Depicted In This Rendering May Not Match Actual Material Finishes. Refer To Product Samples For Exact Color Match.

Job Number:

23-32213-10

Date:

30 June 2015

Sheet Number:

6 of 10

Design Number: 23-32213-10 R5



Oceanside, CA	Manufacturing Facilities
	Essex, TX - Jacksonville, TX - Delaware, OH
Oceanside, CA	Office Locations
	Las Vegas, NV - Laughlin, AZ Elbert, TX - Jacksonville, TX - San Antonio, TX Houston, TX - Corpus Christi, TX - Indianapolis, IN Louisville, KY - Knoxville, TN - Graton, WI - Delaware, OH Waukegan, IL - Tulsa, KS - Atlanta, GA Empire, FL - Daytona Beach, FL - Orlando, FL

Building Quality Signage Since 1901

Revisions
R1 JG 1 27 16 Replace T8D with actual dim
R2 BW 2 3 16 Revise depth of blade sign & clean up elevs.
R3 BW 4 14 16 Increase depth of blade sign.
R4 & 22 16 GB Update All Specs Per 6/20 16 Side;
R5 8 25 16 Add "HBAR" Sign E

Account Rep Saul Stankus

Project Manager Lynn Anderson

Drawn By Gene Bourbonnais

Project / Location



901 Neches Street
Austin, TX
78701

Underwriters Laboratories Inc.
ELECTRICAL TO USE UL LISTED COMPONENTS AND SHALL MEET ALL N.E.C. STANDARDS
ALL ELECTRICAL WORK IS TO BE DONE IN ACCORDANCE WITH THE NATIONAL ELECTRICAL CODE AND THE PROPER GROUNDING AND BONDING OF ALL TIONS

Client Approval/Date:


Landlord Approval/Date:

This original drawing is provided as part of a planned project and is not to be exhibited, copied or reproduced without the written permission of Federal Heath Sign Company LLC or its authorized agent. © FHSC
Colors Depicted in This Rendering May Not Match Actual Material Finishes. Refer to Product Samples For Exact Color Match.


Job Number:	23-32213-10
Date:	30 June 2015
Sheet Number:	7 of 10

Design Number: 23-32213-10 R5

NOTE: CUSTOMER TO VERIFY
FABRICATION SPECIFICATIONS.

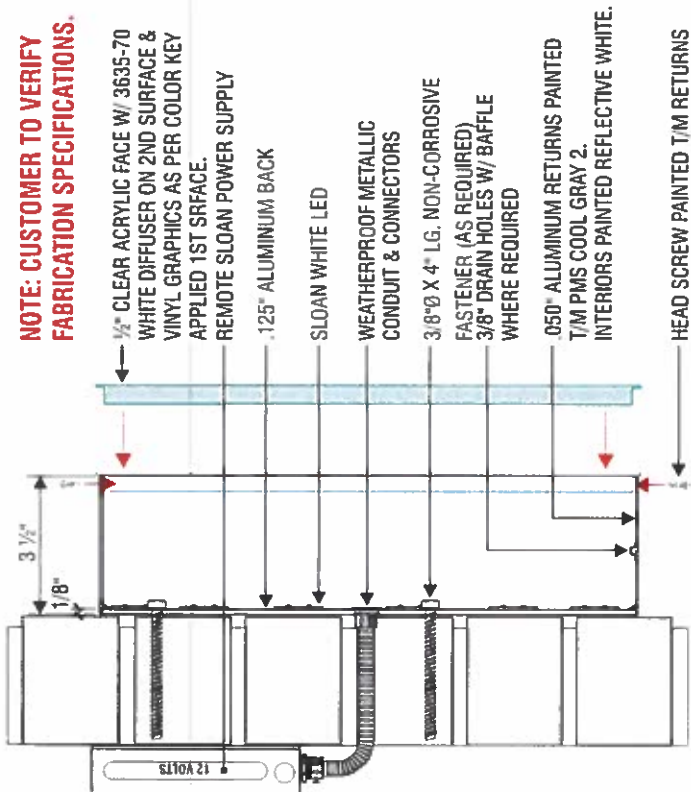

TYPICAL LETTER SECTION DETAIL
NOT TO SCALE

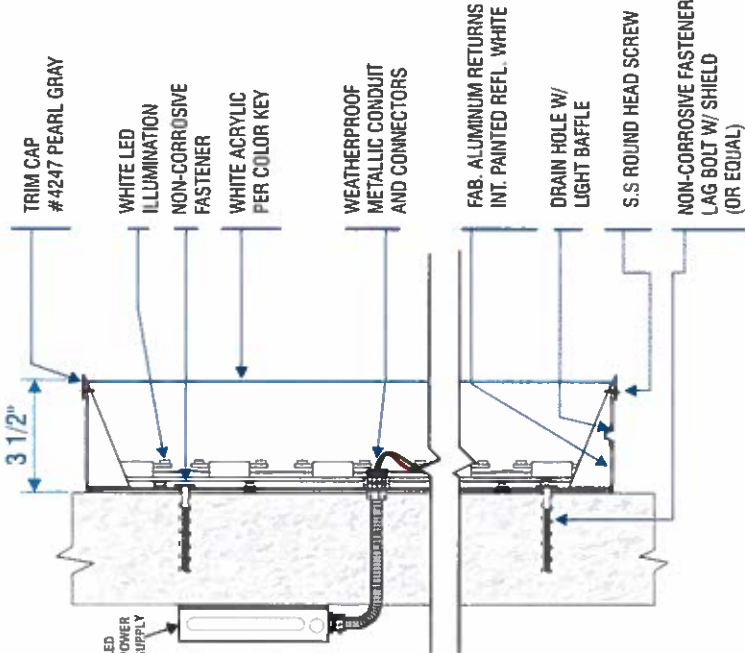

TYPICAL LOGO SECTION DETAIL
NOT TO SCALE



Perspective | Daytime




Perspective | Daytime

ELECTRICAL REQUIREMENTS	
Total:	T.B.D. Amps
# of 120V, 20A Circuits Req'd T.B.D. ALL BRANCH CIRCUITS SHALL BE DEDICATED TO SIGNS (INCLUDING GROUND AND NEUTRAL) AND SHALL NOT BE SHARED WITH OTHER LOADS.	

CUSTOMER TO PROVIDE DEDICATED BRANCH CIRCUITS FOR SIGNS ONLY PER NEC CODE 404.5 ALL BRANCH CIRCUITS SHALL BE DEDICATED TO SIGNS (INCLUDING GROUND AND NEUTRAL) AND SHALL NOT BE SHARED WITH OTHER LOADS. PROPERLY SIZED GROUND WIRE THAT CAN BE TRACED BACK TO BREAKER PANEL IS REQUIRED.	NEW & REMODEL CONSTRUCTION ADEQUATE BEHIND THE WALL BACKING AND ACCESS IS REQUIRED FOR THE INSTALLATION OF NEW SIGNAGE. CUSTOMER TO FORWARD APPROVED SIGNAGE DRAWINGS TO THE ON SITE CONTACT TO INSURE THAT THE REQUIRED PROVISIONS ARE MADE DURING CONSTRUCTION, PRIOR TO THE SIGN INSTALLATION.
INSTALLER REQUIREMENTS ALL MOUNTING HARDWARE, SECONDARY WIRING AND CONDUITS ARE TO BE PROVIDED BY THE INSTALLATION CONTRACTOR. ALL PENETRATIONS IN THE WALL ARE TO BE SEALED WITH SIKING AND TO BE WATER TIGHT.	INSTALLER REQUIREMENTS FOR LIFE WALLS IT IS THE RESPONSIBILITY OF THE INSTALLATION CONTRACTOR TO PROVIDE ANY WALL SPACERS REQUIRED TO KEEP THE WALL MATERIAL FROM BEING COMPRESSED DURING INSTALLATION OF ANY MOUNTING BOLTS REQUIRED FOR SIGNAGE.

GENERAL NOTE • INSTALLER SHALL VERIFY WALL CONDITIONS IN THE FIELD • THE SIZE AND NUMBER OF FASTENERS TO BE DETERMINED BASED ON THE TYPE OF WALL MATERIAL • ISOLATE ALL ALUMINUM FROM STEEL

120V 20 AMP CIRCUIT ELECTRICAL PRIMARY TO WITHIN 2' OF SIGN LOCATION AND THE FINAL HOOK UP TO BE BY THE CUSTOMER'S CERTIFIED ELECTRICIAN. NUMBER OF CIRCUITS PER SIGN TO BE PER FEDERAL HEATH SIGN REQUIREMENTS. ALL SIGNS TO COMPLY WITH U.L. 48 REQUIREMENTS AND ARTICLE 600 OF THE N.E.C., AND ALSO MEET ANY STATE AND LOCAL CODE REQUIREMENTS.

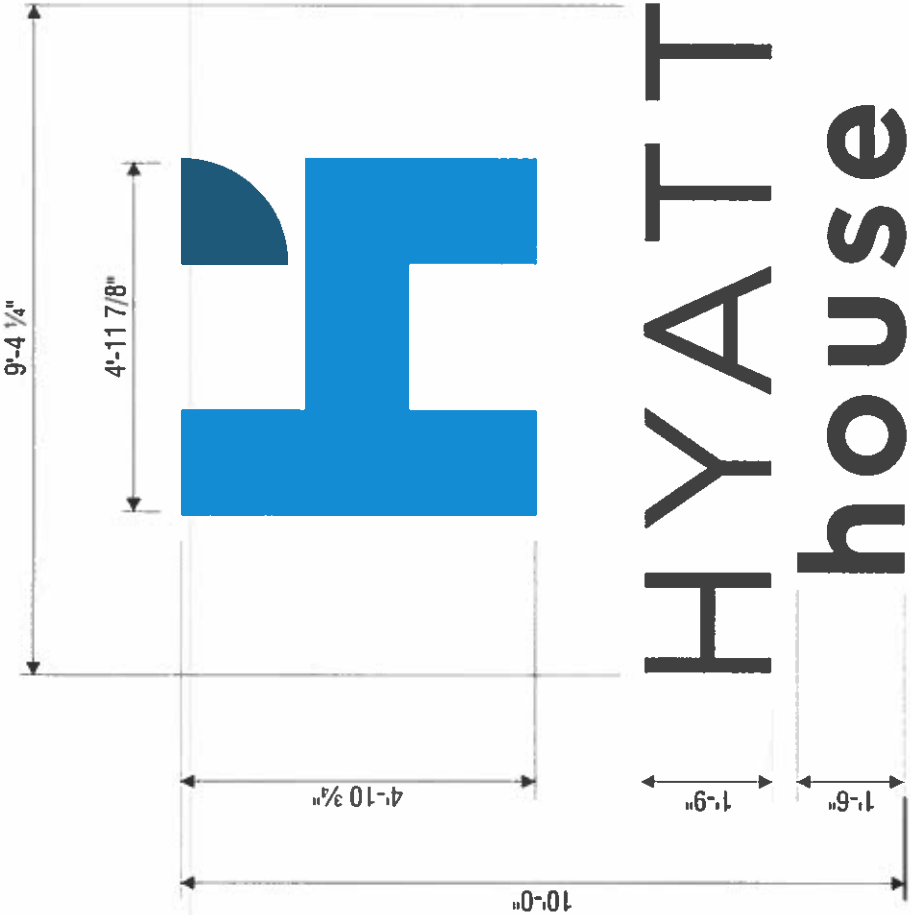

INTERNALLY ILLUMINATED CHANNEL LETTERS / CIV-3L-3 / 93.5 SQ.FT. / TWO (2) SET REQUIRED

SCALE : 3/8" = 1'-0"

MANUFACTURE & INSTALL CHANNEL LOGO & LETTER SET

LOGO: 3 1/2" DEEP FABRICATED ALUMINUM RETURNS, PAINTED PMS COOL GRAY 2, SATIN FINISH
FACE IS 3/16" #7328 WHITE ACRYLIC W/ 2500-2498 VINYL OVERLAY PER COLOR KEY,
WITH 1" #4272 "PEARL GRAY" TRIM CAP.
LOGO ACCENT: 3 1/2" DEEP FABRICATED ALUMINUM RETURNS, PAINTED PMS COOL GRAY 2, SATIN FINISH
FACE IS 3/16" #2447 WHITE ACRYLIC W/ 3630-7570 VINYL OVERLAY PER COLOR KEY.
LETTERS: 3 1/2" DEEP FABRICATED ALUMINUM RETURNS, PAINTED PMS COOL GRAY 2, SATIN FINISH
FACE IS "TUPPERWARE" STYLE 1/2" CLEAR ACRYLIC W/ 3635-222 DUAL-COLOR VINYL & #30 DIFFUSER PER COLOR KEY.

ILLUMINATION PROVIDED BY WHITE LEDs AND REMOTE POWER SUPPLIES

COLOR KEY

	PAINT: T/M PMS COOL GRAY 2, SATIN FINISH
	LOGO FACE: 3/16" 7328 WHITE ACRYLIC W/ 1ST & 2ND SURFACE CYAN VINYL #2500-2498
	LOGO ACCENT: 3/16" 2447 WHITE ACRYLIC W/ 1ST SURFACE DK. BLUE VINYL #3630-7570
	LETTER FACES: 1/2" CLEAR ACRYLIC W/ 1ST SURFACE DUAL-COLOR BLACK 3635-222 & 2ND SURFACE #30 DIFFUSER

Manufacturing Facilities
Oceanside, CA - Euless, TX - Jacksonville, TX - Delaware, OH
Office Locations:
Oceanside, CA - Las Vegas, NV - Laughlin, AZ
Indian Falls, ID - Euless, TX - Jacksonville, TX - San Antonio, TX
Houston, TX - Corpus Christi, TX - Indianapolis, IN
Louisville, KY - Knoxville, TN - Graton, WA - Delaware, OH
Wilmington, IL - Tunica, MS - Atlanta, GA
Tampa, FL - Daytona Beach, FL - Orlando, FL

Building Quality Signage Since 1901

Revisions:
R1 IG 1 27 16 Replaced 180 with actual dim.
R2 BW 2 3 16 Revise depth of blade sign & clean up elev.
R3 BW 4 14 16 Increase depth of blade sign.
R4 8 22 16 CB Update All Specs Per 6/2016 Side;
85 8 25 16 Add "HBAR" Sign E

Account Rep **Saul Stankus**

Project Manager: **Lynn Anderson**

Drawn By: **Gene Bourbonnais**

Project / Location:



901 Neches Street
Austin, TX
78701



Client Approval/Date:

Landlord Approval/Date:

This original drawing is provided as part of a planned project and is not to be exhibited, copied or reproduced without the written permission of Federal Heath Sign Company LLC or its authorized agent. © FHSC

Colors Depicted in This Rendering May Not Match Actual Material Finishes. Refer to Product Samples For Exact Color Match.


Job Number: **23-32213-10**

Date: **30 June 2015**


Sheet Number: **8** of **10**

Design Number: **23-32213-10 R5**

NOTE: CUSTOMER TO VERIFY
FABRICATION SPECIFICATIONS.

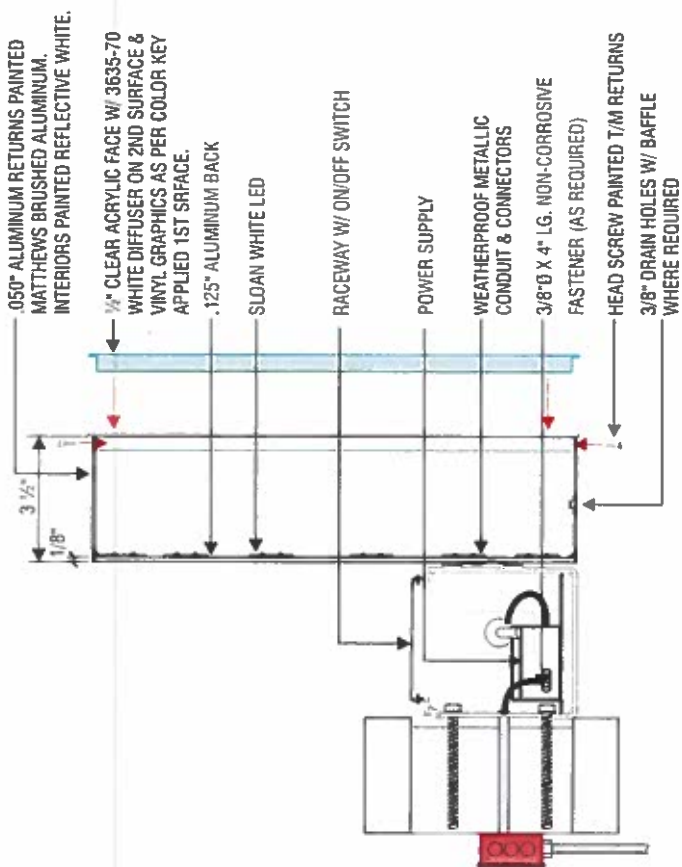

TYPICAL LETTER SECTION DETAIL
NOT TO SCALE

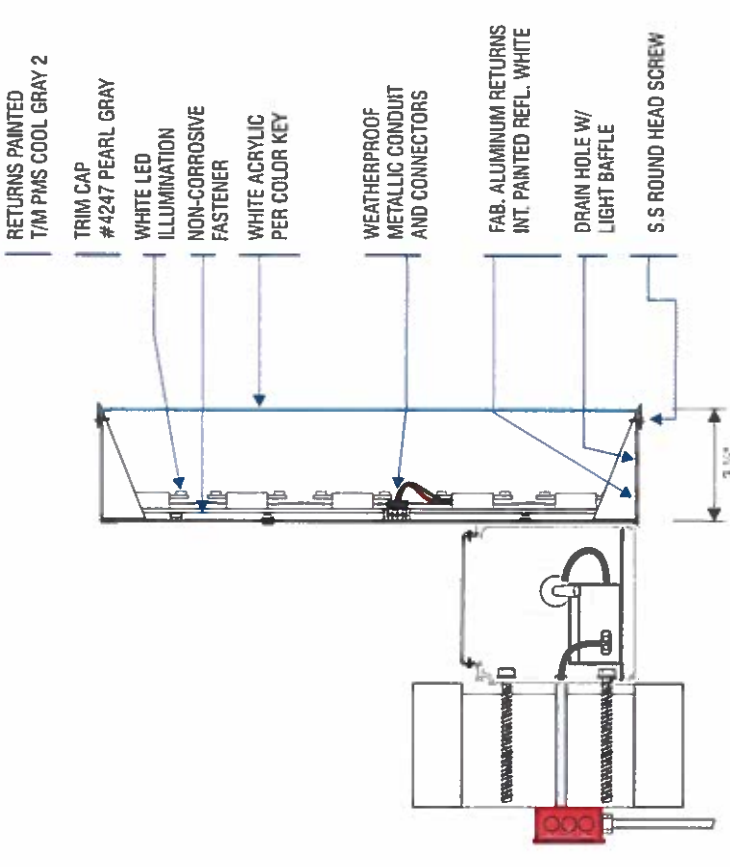

DETAIL FOR TYPICAL RACEWAY MOUNTED LOGO W/ ILLUMINATED PLEX FACE (TRIM CAP)
NOT TO SCALE



Perspective | Daytime



Perspective | Daytime



INTERNALLY ILLUMINATED CHANNEL LETTERS / CIH-1L3H-1 / 71.5 SQ.FT. / ONE (1) SET REQUIRED

SCALE : 3/8" = 1'-0"

MANUFACTURE & INSTALL CHANNEL LOGO & LETTER SET

LOGO: 3 1/2" DEEP FABRICATED ALUMINUM RETURNS, PAINTED PMS COOL GRAY 2, SATIN FINISH
FACE IS 3/16" #7328 WHITE ACRYLIC W/ VINYL OVERLAY PER COLOR KEY, WITH 1" #4272 "PEARL GRAY" TRIM CAP.
LOGO ACCENT: 3 1/2" DEEP FABRICATED ALUMINUM RETURNS, PAINTED PMS COOL GRAY 2, SATIN FINISH
FACE IS 3/16" #2447 WHITE ACRYLIC W/ VINYL OVERLAY PER COLOR KEY.
LETTERS: 3 1/2" DEEP FABRICATED ALUMINUM RETURNS, PAINTED PMS COOL GRAY 2, SATIN FINISH
FACE IS "TUPPERWARE" STYLE 1/2" CLEAR ACRYLIC W/ 3635-222 DUAL-COLOR VINYL & #30 DIFFUSER PER COLOR KEY.

ILLUMINATION PROVIDED BY WHITE LEDs AND REMOTE POWER SUPPLIES

RACEWAY TO BE PAINTED T/M (TBD), SATIN FINISH

COLOR KEY

- PAINT: T/M PMS COOL GRAY 2, SATIN FINISH
- LOGO FACE: 3/16" 7328 WHITE ACRYLIC W/ 1ST & 2ND SURFACE CYAN VINYL #2500-2498
- LOGO ACCENT: 3/16" 2447 WHITE ACRYLIC W/ 1ST SURFACE DK. BLUE VINYL #3630-7570
- LETTER FACES: 1/2" CLEAR ACRYLIC W/ 1ST SURFACE DUAL-COLOR BLACK 3635-222 & 2ND SURFACE #30 DIFFUSER

ELECTRICAL REQUIREMENTS
Total: T.B.D. Amps
of 120V, 20A Circuits Req'd T.B.D.
ALL BRANCH CIRCUITS SHALL BE DEDICATED TO SIGNS (INCLUDING GROUND AND NEUTRAL) AND SHALL NOT BE SHARED WITH OTHER LOADS.

CUSTOMER TO PROVIDE DEDICATED BRANCH CIRCUITS FOR SIGNS ONLY PER NEC CODE 600.5 ALL BRANCH CIRCUITS SHALL BE DEDICATED TO SIGNS (INCLUDING GROUND AND NEUTRAL) AND SHALL NOT BE SHARED WITH OTHER LOADS. PROPERLY SIZED GROUND WIRE THAT CAN BE TAPPED BACK TO BREAKER PANEL IS REQUIRED.	INSTALLER REQUIREMENTS ALL MOUNTING HARDWARE, SECONDARY WIRING AND CONDUITS ARE TO BE PROVIDED BY THE INSTALLATION CONTRACTOR. ALL PENETRATIONS IN THE WALL ARE TO BE SEALED WITH SILICONE AND TO BE WATER-TIGHT. ANY DISJUNCTION FROM FEDERAL HEALTH REQUIREMENTS MAY RESULT IN DAMAGE TO OR IMPROPER OPERATION OF SIGNAGE, CAUSING DELAYS AND ADDITIONAL COSTS.	NEW & REMODEL CONSTRUCTION ADEQUATE BEHIND THE WALL BACKING AND ACCESS IS REQUIRED FOR THE INSTALLATION OF NEW SIGNAGE. CUSTOMER TO FORWARD APPROVED SIGNAGE DRAWINGS TO THE ON-SITE CONTACT TO INSURE THAT THE REQUIRED PROVISIONS ARE MADE DURING CONSTRUCTION PRIOR TO THE SIGN INSTALLATION. INSTALLER REQUIREMENTS FOR EFT WALLS IT IS THE RESPONSIBILITY OF THE INSTALLATION CONTRACTOR TO PROVIDE THE FOLLOWING: -ALL MOUNTING BRITS REQUIRED FOR SIGNAGE. -ALL MOUNTING BRITS REQUIRED FOR SIGNAGE.	GENERAL NOTE -SIGNALS SHALL BE MOUNTED TO THE WALL. -TYPE OF MOUNTING HARDWARE IS TO BE DETERMINED BY THE INSTALLATION CONTRACTOR. -ALL MOUNTING BRITS TO BE PROVIDED BY THE INSTALLATION CONTRACTOR. -ALL MOUNTING BRITS TO BE PROVIDED BY THE INSTALLATION CONTRACTOR.
---	---	--	---

120V 20 AMP CIRCUIT ELECTRICAL PRIMARY TO WITHIN 5' OF SIGN LOCATION AND THE SIGNAL LOOK UP TO BE BY THE CUSTOMER'S CERTIFIED ELECTRICIAN. NUMBER OF CIRCUITS PER SIGN TO BE PER FEDERAL TRAINING REQUIREMENTS. ALL SIGNS TO COMPLY WITH U.L. #8 REQUIREMENTS AND ARTICLE 600 OF THE NEC, AND ALSO MEET ANY STATE AND LOCAL CODE REQUIREMENTS.

Manufacturing Facilities: Oceanside, CA • Elvert, TX • Jacksonville, TX • Delaware, OH	Office Locations:
	Oceanside, CA • Las Vegas, NV • Laughlin, AZ Isidro Falls, ID • Elvert, TX • Jacksonville, TX • San Antonio, TX Houston, TX • Corpus Christi, TX • Indianapolis, IN Louisville, KY • Knoxville, TN • Galveston, UT • Delaware, OH Westborough, IL • Tuncna, MS • Atlanta, GA Tampa, FL • Daytona Beach, FL • Orlando, FL

Building Quality Signage Since 1901

Revisions
R1 IG 1.27 16 Replace TBD with actual dim.
R2 BW 2.3 16 Revise depth of blade sign & clean up elevs.
R3 BW 4.14 16 Increase depth of blade sign
R4 & 22 16 GB Update All Specs Per 6/2016 Sids,
R5 & 25 16 Add "H&R" Sign E

Account Rep

Saul Stankus

Project Manager:

Lynn Anderson

Drawn By

Gene Bourbonnais

Project / Location



901 Neches Street
Austin, TX
78701

UL Underwriters Laboratories Inc. nfc	ELECTRICAL TO USE U.L. LISTED COMPONENTS AND SHALL MEET ALL N.E.C. STANDARDS. ALL ELECTRICAL WORK SHALL BE DONE IN ACCORDANCE WITH THE NATIONAL ELECTRICAL CODE (NEC) AND THE NATIONAL FIRE PROTECTION ASSOCIATION (NFPA) 70B STANDARD. THE PROPER GROUNDING AND BONDING OF ALL LIGHTS
---------------------------------------	--

Client Approval/Date:

Landlord Approval/Date:

This original drawing is provided as part of a planned project and is not to be exhibited, copied or reproduced without the written permission of Federal Heath Sign Company LLC or its authorized agent © FHSC

Colors Depicted in This Rendering May Not Match Actual Material Finishes. Refer to Product Samples For Exact Color Match

Job Number

23-32213-10

Date:

30 June 2015

Sheet Number:

9

Of

10

Design Number: 23-32213-10 R5

INTERNALLY ILLUMINATED D/F BLADE SIGN / 198.33 SQ.FT. / ONE (1) REQUIRED

SCALE : 3/16" = 1'-0"

SCOPE OF WORK: MANUFACTURE AND INSTALL D/F BLADE SIGN

LOGO: TO BE 1/2" WHITE ACRYLIC PUSH-THRU W/ VINYL PER COLOR KEY

COPY: TO BE 1/4" WHITE ACRYLIC IN-FILL W/ VINYL PER COLOR KEY

FACE: .125 ALUMINUM FACE W/ ROUT-OUT GRAPHICS TO BE PAINTED PMS COOL GRAY 2, SATIN FINISH

CABINET FILLERS: .125 ALUMINUM PAINTED t/m PMS COOL GRAY 2, SATIN FINISH

INTERNAL ILLUMINATION: FLUORESCENT LAMPS AND TRANSFORMERS

MOUNTING: BLADE TO BE MOUNTED FLUSH TO WALL OVER CUSTOMER PROVIDED OUTRIGGERS

BLADE SIGN TO MOUNT ON CORNER OF BUILDING

NOTE: ENGINEERING REQUIRED

NOTE: OWNER TO SUPPLY OUTRIGGERS FROM BUILDING TO MOUNT BLADE SIGN TO.

COLOR KEY



PAINT: T/M PMS COOL GRAY 2, SATIN FINISH



LOGO FACE: .5" 7328 WHITE ACRYLIC W/ 1ST & 2ND SURFACE CYAN VINYL #2500-2498



LOGO ACCENT: .5" 2447 WHITE ACRYLIC W/ 1ST SURFACE DK. BLUE VINYL #3630-7570



LETTER FACES: .25" 2447 WHITE ACRYLIC W/ 1ST SURFACE DUAL-COLOR BLACK 3635-222

ELECTRICAL REQUIREMENTS

Total: T.B.D., Amps

of 120V, 20A Circuits: Req'd T.B.D.

ALL BRANCH CIRCUITS SHALL BE DEDICATED TO SIGNS (INCLUDING GROUND AND NEUTRAL) AND SHALL NOT BE SHARED WITH OTHER LOADS.

CUSTOMER TO PROVIDE

DEDICATED BRANCH CIRCUITS FOR SIGN ONLY PER NEC CODE 680.5

ALL BRANCH CIRCUITS SHALL BE DEDICATED TO SIGNS INCLUDING GROUND AND NEUTRAL AND SHALL NOT BE SHARED WITH OTHER LOADS. PROPERLY SIZED GROUND WIRE THAT CAN BE TRACED BACK TO BREAKER PANEL IS REQUIRED.

INSTALLER REQUIREMENTS

ALL MOUNTING HARDWARE, SECONDARY WIRING AND GROUNDING ARE TO BE PROVIDED BY THE INSTALLATION CONTRACTOR. ALL PENETRATIONS IN THE WALL ARE TO BE SEALED WITH SILICONE AND TO BE WATER-TIGHT.

ANY DEVIATION FROM FEDERAL HEALTH REQUIREMENTS MAY RESULT IN DAMAGE TO OR IMPROPER OPERATION OF SIGNAGE, CAUSING DELAYS AND ADDITIONAL COSTS.

NEW & REMODEL CONSTRUCTION


ADDITIONAL BEHIND THE WALL BACKING AND ACCESS IS REQUIRED FOR THE INSTALLATION OF PERMANENT SIGNAGE. THE CONTRACTOR SHALL PROVIDE SIGNAGE DRAWINGS TO THE ON-SITE CONTACT TO INSURE THAT THE REQUIRED PREVISIONS ARE MADE DURING CONSTRUCTION PRIOR TO THE SIGN INSTALLATION.

IT IS THE RESPONSIBILITY OF THE INSTALLATION CONTRACTOR TO PROVIDE ANY WALL SPACES REQUIRED TO KEEP ETS WALL MATERIAL FROM BEING COMPACTED DURING INSTALLATION OF ANY MOUNTING HOLDS REQUIRED PER SIGNAGE.

GENERAL NOTE

• INSTALLER SHALL VERIFY WALL CONDITIONS IN THE FIELD
• TYPES, SIZE AND NUMBER OF FASTENERS TO BE DETERMINED
• ALL HOIST HOLES TO BE DRILLED OR PUNCHED
• ISOLATE ALL ALUMINUM FROM STEEL


TOO TO AMP CIRCUIT ELECTRICAL PRIMARY TO WITHIN 5' OF SIGN LOCATION AND THE FINAL TAP UP TO BE BY THE CUSTOMER'S LICENSED ELECTRICIAN. NUMBER OF CIRCUITS PER SIGN TO BE PER FEDERAL HEALTH SIGN REQUIREMENTS. ALL SIGNS TO COMPLY WITH UL 58 REQUIREMENTS AND ARTICLE 605 OF THE NEC, AND ALSO MEET ANY STATE AND LOCAL CODE REQUIREMENTS.

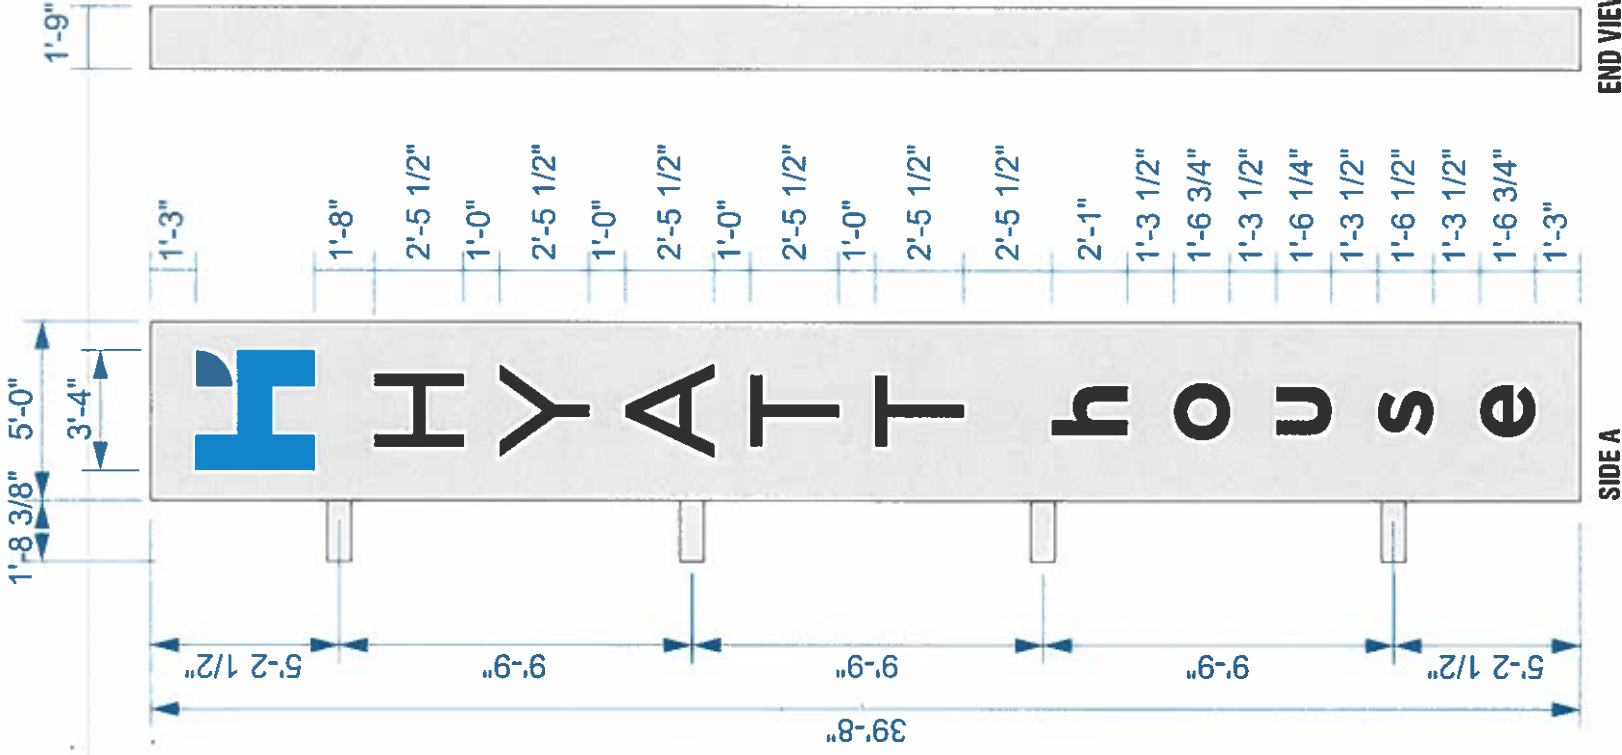

SIDE A

END VIEW

SIDE B

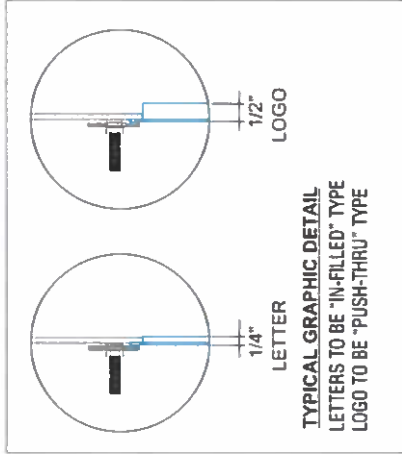

Perspective | Daytime



Perspective | Daytime



SIGN COMPANY
www.FederalHeath.com

4602 North Avenue
Oceanside, CA 92056
[760] 941-0715 Fax [760] 631-5065

Manufacturing Facilities:	
Oceanside, CA	Elbert, TX Jacksonville, TX Delaware, OH
Office Locations:	
Oceanside, CA	Las Vegas, NV Laughlin, AZ
Indian Falls, ID	Elbert, TX Jacksonville, TX San Antonio, TX
Houston, TX	Corpus Christi, TX Indianapolis, IN
Louisville, KY	Evansville, TN Galton, WI Delaware, OH
Waukegan, IL	Tulaca, MS Atlanta, GA
Tampa, FL	Daytona Beach, FL Orlando, FL

Building Quality Signage Since 1901

REVISIONS:
R1 1G 1.27.16 Replace TBD with actual dim.
R2 BW 2.3.16 Revise depth of blade sign & clean up elevs.
R3 BW 4.14.16 Increase depth of blade sign.
R4 8.22.16 CB Update All Specs Per 6/2016 Specs
R5 8.25.16 Add "H-BAR" Sign E

Account Rep:	Saul Stankus
Project Manager:	Lynn Anderson

Drawn By: Gene Bourbonnais

Project / Location:



901 Neches Street
Austin, TX
78701

Underwriters Laboratories Inc.	Electrical to use U.L. Listed components and shall meet all N.E.C. standards
All electrical signs are to comply with U.L. 84 and U.L. 1207 and shall be properly grounded and bonding of all signs.	

Client Approval/Date

Landlord Approval/Date

This original drawing is provided as part of a planned project and is not to be exhibited, copied or reproduced without the written permission of Federal Heath Sign Company LLC or its authorized agent. © FHSC
Colors Depicted in This Rendering May Not Match Actual Material Finishes. Refer to Product Samples for Exact Color Match.

Job Number:	23-32213-10
Date:	30 June 2015
Sheet Number:	10 of 10

Design Number: 23-32213-10 R5



E H-BAR WALL SIGN
ONE (1) REQ'D

SCALE: 1" = 1'-0"

MANUFACTURE & INSTALL ONE "H-BAR" WALL SIGN

SIGN CABINET IS HINGED 2 PIECE FABRICATED ALUMINUM, PAINTED MATTE BLACK W/ 2.5" DEEP FABRICATED HALO-ILLUMINATED REVERSE CHANNEL LETTERS.

OPTION 1: FACE & RETURNS TO BE ARCHITECTURAL GRADE BRUSHED ALUMINUM W/ HORIZONTAL GRAIN.

OPTION 2: FACE & RETURNS PAINTED T/M SM 171S "BRUSHED ALUMINUM".

LETTER INTERIOR PAINTED W/ LIGHT ENHANCING WHITE PAINT.
ILLUMINATION PROVIDED BY WHITE LEDs & SELF-CONTAINED POWER SUPPLY.

LETTERS TO BE MOUNTED W/ 1/2" STAND-OFFS.
CABINET TO BE MOUNTED FLUSH T WALL.



PERSPECTIVE VIEW