

**1705 NEWTON
AUSTIN, TX**

Содержание

NOTE: The drawings and specifications and ideas, designs and arrangements, representations and parts herein shall remain the property of DDC-A, and no part thereof shall be copied, disclosed to others or used in connection with any work or project other than the specific project for which they have been prepared and developed without the written consent of DDC-A. Visual contact with these drawings or specifications shall constitute conclusive evidence of acceptance of these restrictions.

[illegible]

**ANTHONY &
SUSAN WOOD**
1703 NEWTON ST.
AUSTIN, TX 78704

English

**LOC STRUCTURAL
DIVISION**

1707B KINNEY AVE
AUSTIN, TX 78704

Deriving:

DIG:A
Craig Hoveman
414 W ANNIE ST
AUSTIN, TX 78704


ALL RIGHTS RESERVED

1	2	3	466
---	---	---	---	---	---	---	---	---	----	----	-----	-----	
Drawn By: **Total Sheet Set:**

Drawing: GENERAL NOTES

G1.0

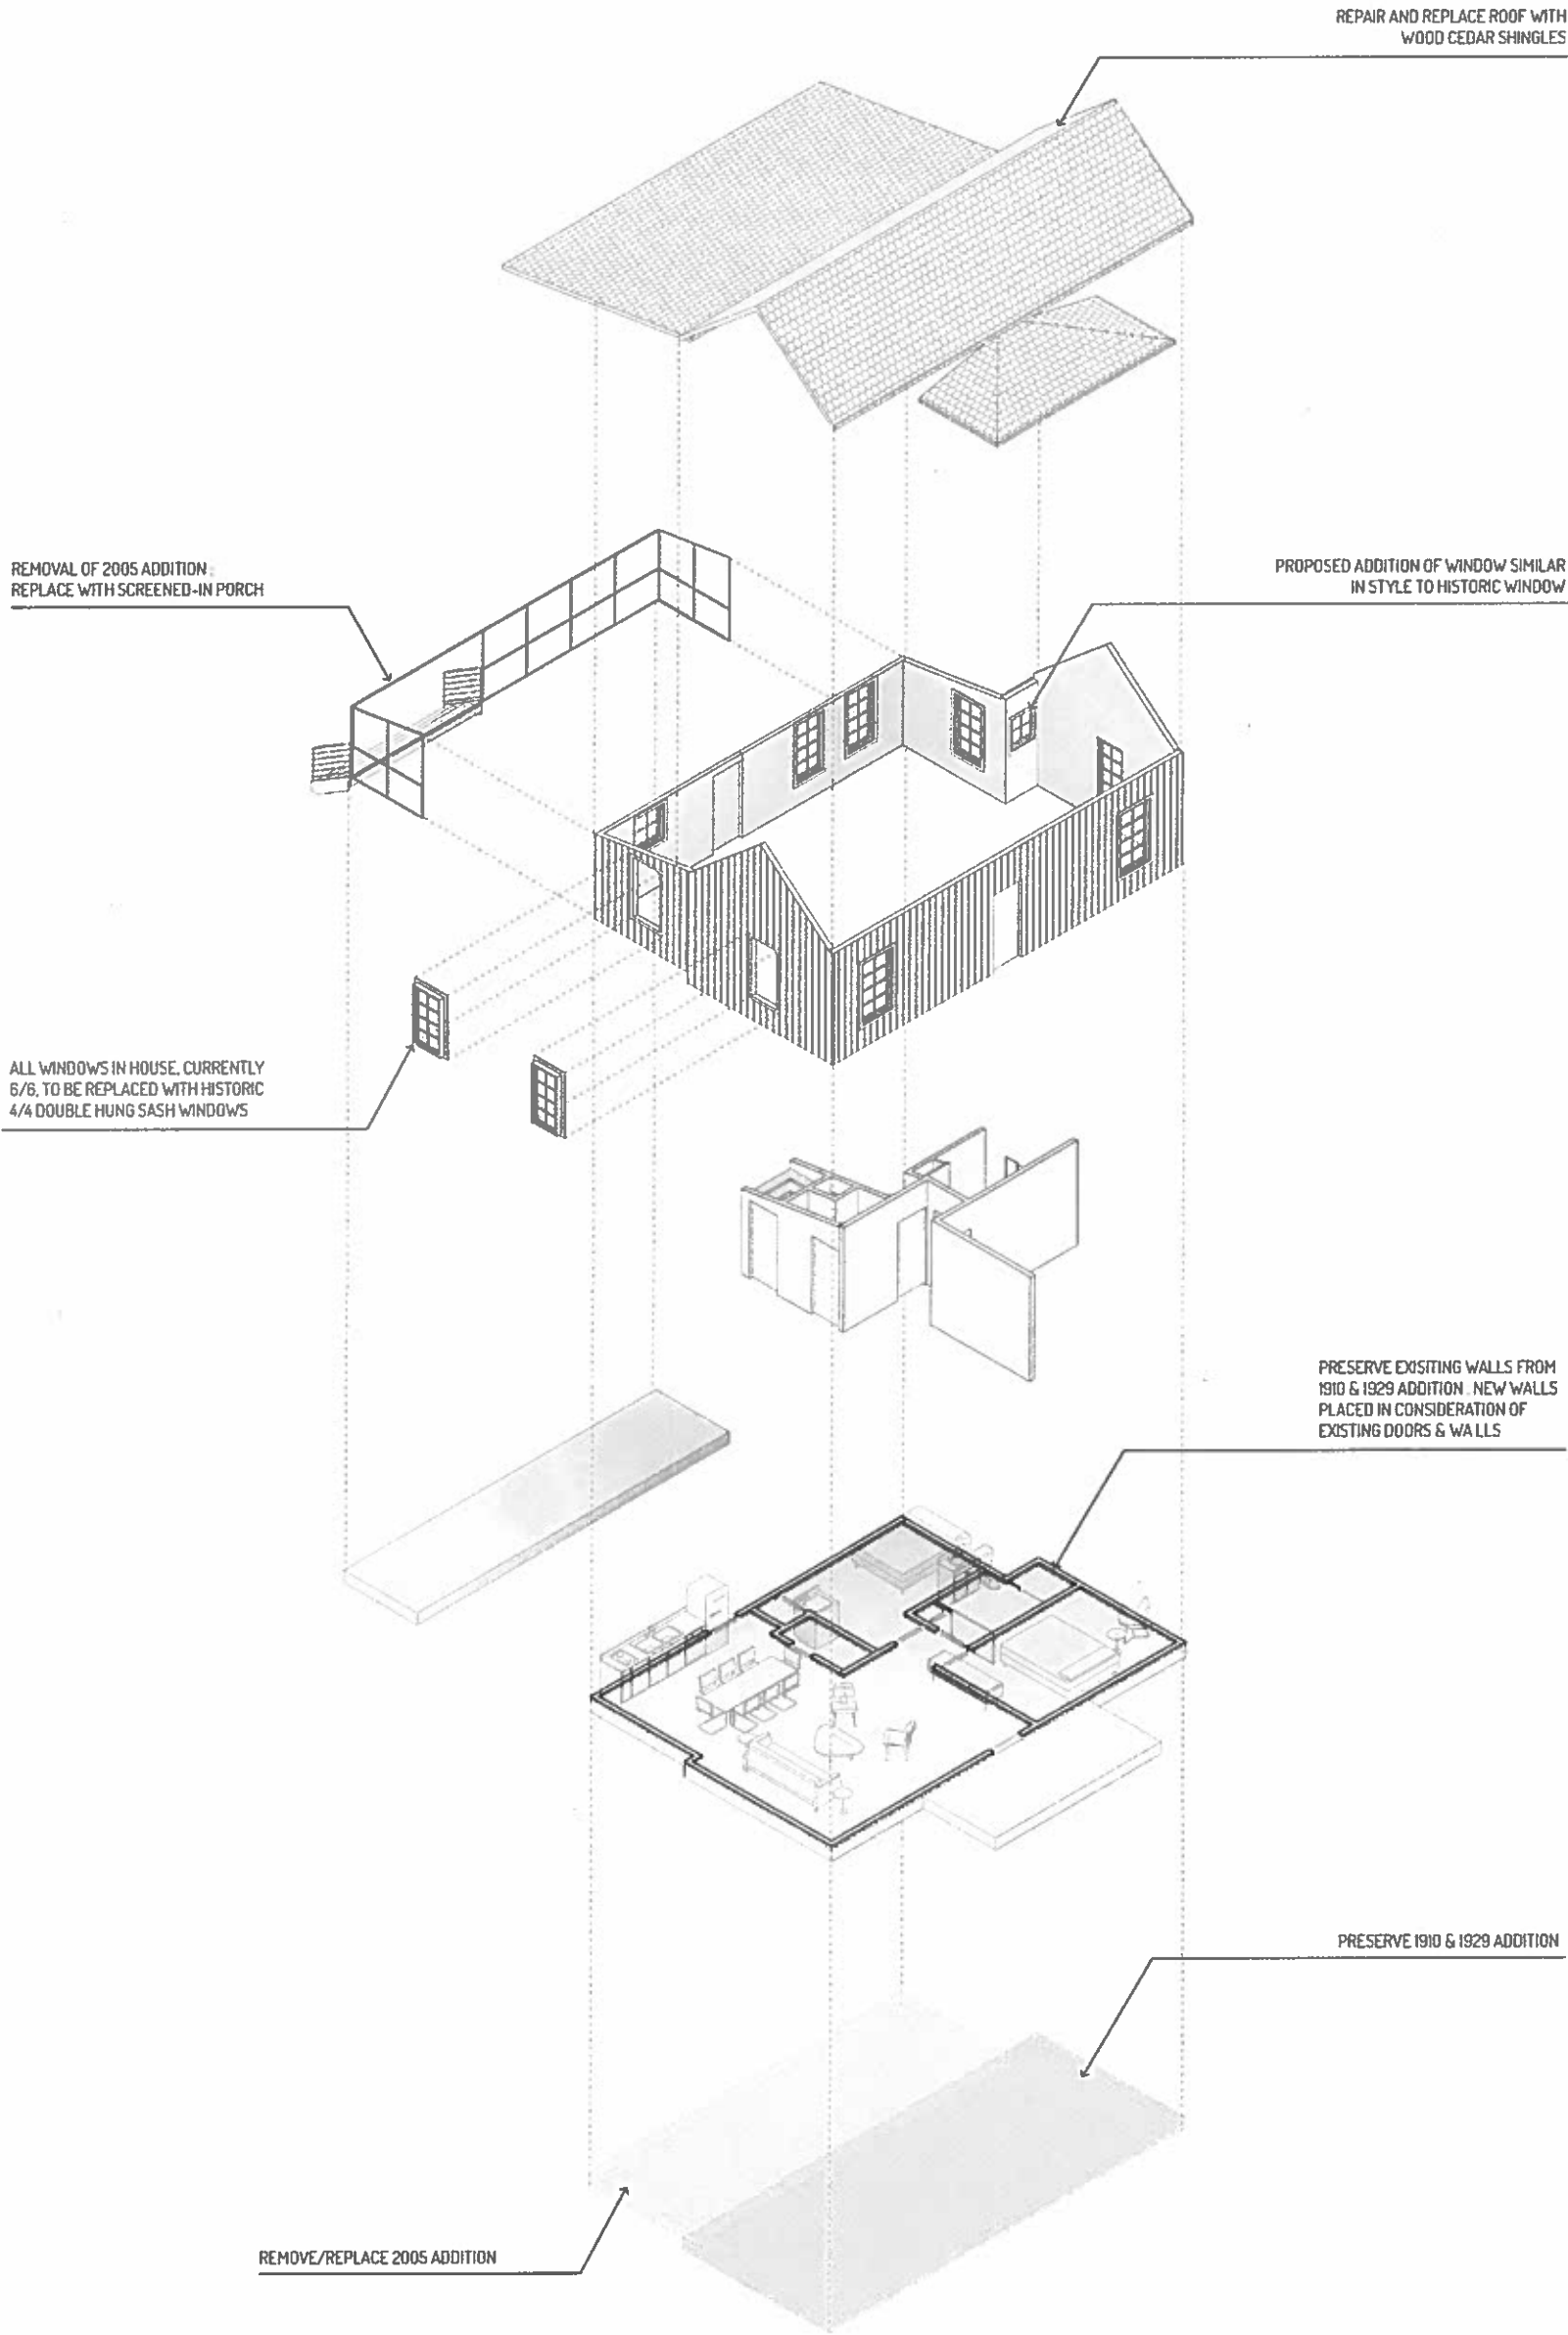

Project: 1705 NEWTON AUSTIN, TX																							
Stamp:																							
NOTE: The drawings and specifications and ideas, designs and arrangements represented hereby are and shall remain the property of DIG: A and no part thereof shall be copied, reproduced or used in connection with any project or building without the express written consent of the author and DIG: A. Violation of these drawings or specifications shall constitute conclusive evidence of acceptance of these instructions. <table><thead><tr><th>Date</th><th>Issue</th></tr></thead><tbody><tr><td> </td><td> </td></tr><tr><td> </td><td> </td></tr><tr><td> </td><td> </td></tr><tr><td> </td><td> </td></tr><tr><td> </td><td> </td></tr><tr><td> </td><td> </td></tr><tr><td> </td><td> </td></tr><tr><td> </td><td> </td></tr><tr><td> </td><td> </td></tr><tr><td> </td><td> </td></tr></tbody></table> Owner: ANTHONY & SUSAN WOOD 1705 NEWTON ST. AUSTIN, TX 78704 Engineer: LOC STRUCTURAL DIVISION Terrance Ortiz 1707B KIMMEY AVE AUSTIN, TX 78704 Drawing: DIG: A Craig Thompson 414 W AVINE ST AUSTIN, TX 78704 © 2017 ALL RIGHTS RESERVED Job No. Sheet Title: Drawn By: Total Sheet Count: Drawing: HISTORICAL KEY G1.1		Date	Issue																				
Date	Issue																						

ALLEY ACCESS

(N) ALLEY ACCESS PER
EMAIL XX.XX.XXXX 2
CONCRETE APPROACH
INTO ALLEY WITH
EXPANSION JOINT AT
ALLEY INTERSECTION
ALLEY WILL BE MAINTAINED
BY CITY OF AUSTIN WITH
ASPHALT MATERIAL

**1705 NEWTON
AUSTIN, TX**

Summary:

NOTE: The drawings and specifications and ideas, designs and arrangements represented thereby are and shall remain the property of DGA, and no part thereof shall be copied, disclosed or derived or used in connection with any work or project other than the specific project for which they have been prepared and developed without the written consent of DGA. Visual contact with these drawings or specifications shall constitute conclusive evidence of acceptance of these conditions.

Date		Issue
1	1/1/19	1/1/19
2	1/1/19	1/1/19
3	1/1/19	1/1/19
100	1/1/19	1/1/19

Center

**ANTHONY &
SUSAN WOOD**
1703 NEWTON ST.
AUSTIN, TX 78704

English:

**LOC STRUCTURAL
DIVISION**
Tenneco Ortiz
1707B KANAWAY AVE.
AUSTIN, TX 78704

Drawing:

DIG:A
Craig Hovveman
414 W ANNE ST
AUSTIN, TX 78704

(C) 2017

ALL RIGHTS RESERVED

姓名	姓名
----	----

Drawn by: **Todd Etnier**

Drawing: SITE PLAN

—

[illegible]

7

—


—

1883

A1.0


SITE PLAN

NOTE: REFER TO LANDSCAPE PLAN FOR LANDSCAPE AND PLANTING DETAILS

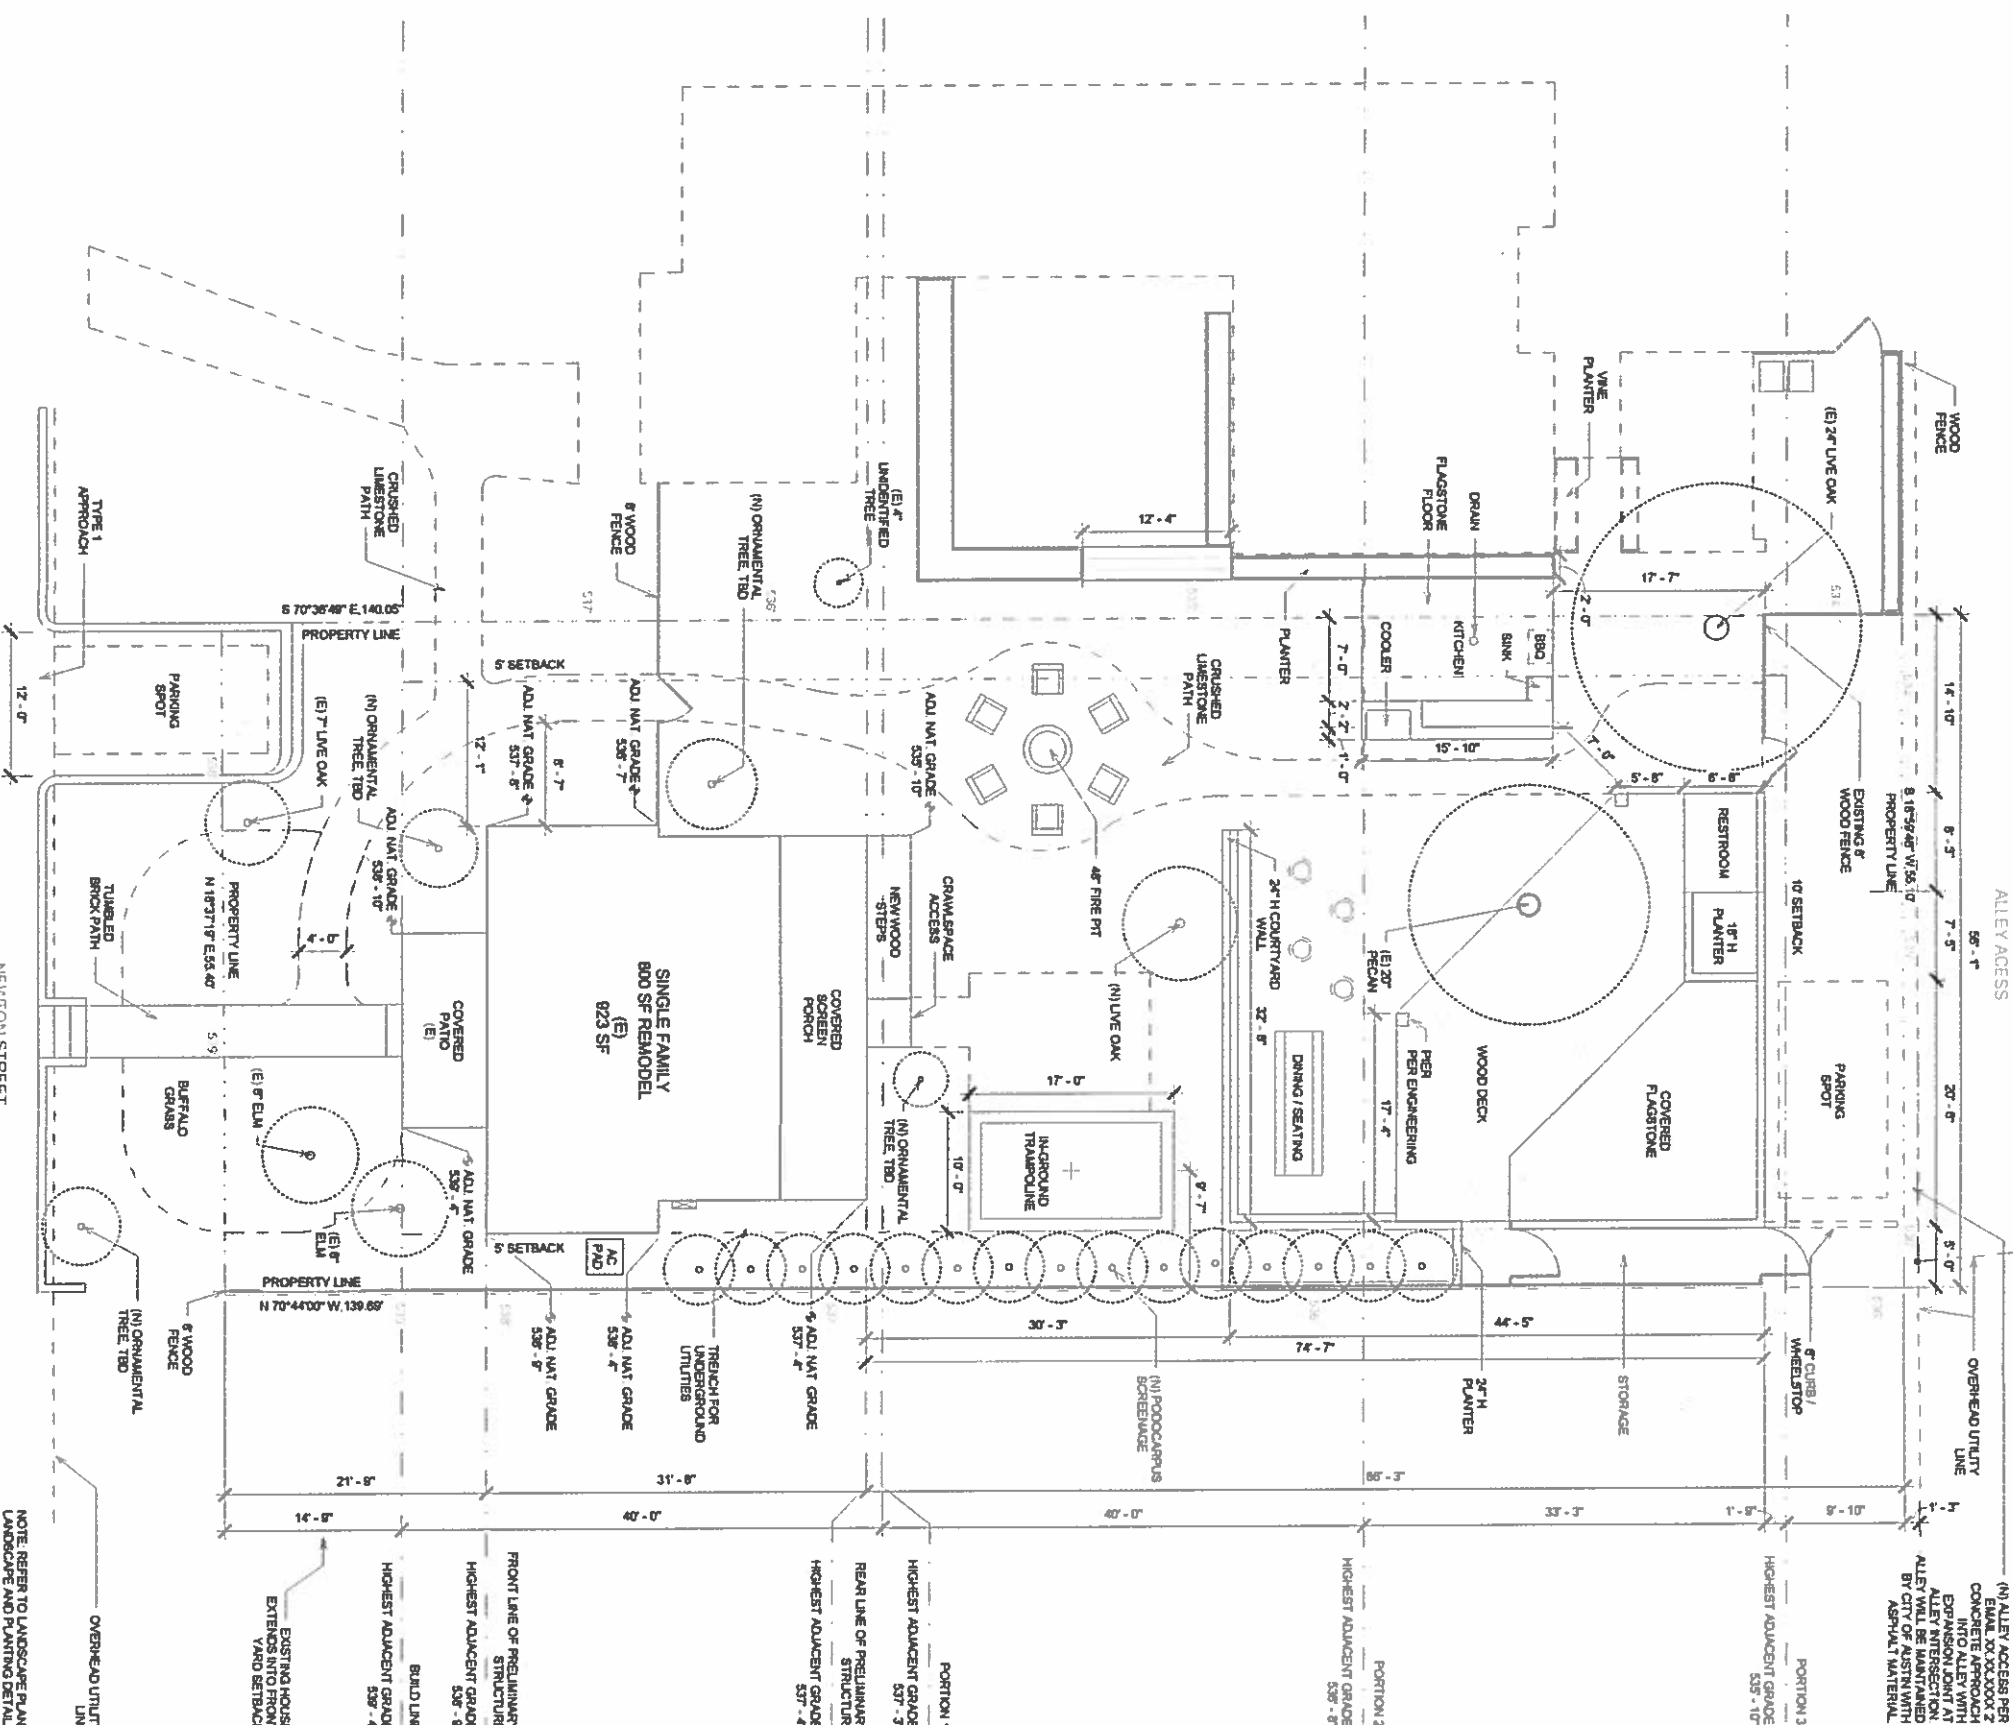


NEWTON STREET

LANDSCAPE AND PLANTING DETAILS

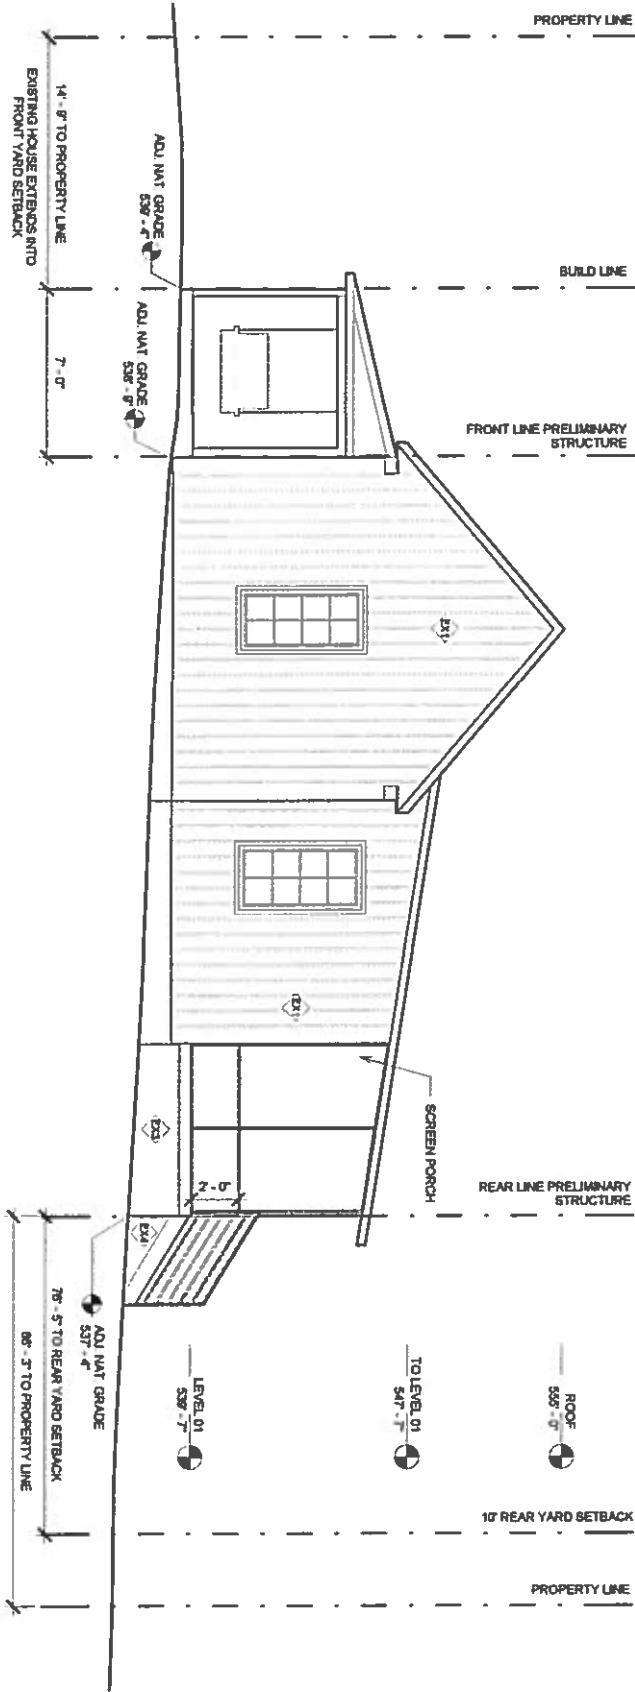

SOUTH ELEVATION

SCALE: 1/8" = 1'-0" FOR 11X17 FORMAT
SCALE: 1/4" = 1'-0" FOR 22X34 FORMAT

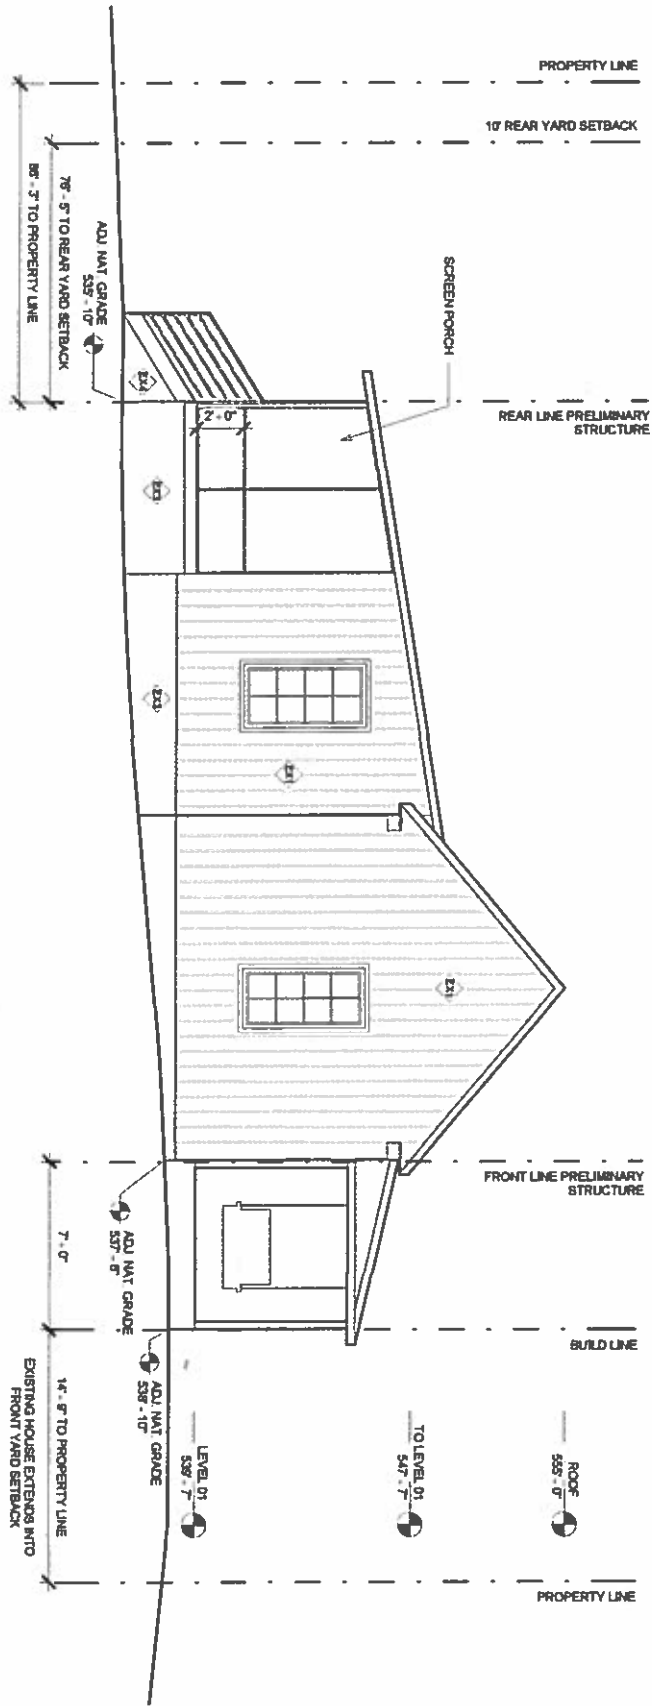

NORTH ELEVATION

SCALE: 1/8" = 1'-0" FOR 11X17 FORMAT
SCALE: 1/4" = 1'-0" FOR 22X34 FORMAT

- EXTERIOR FINISH SCHEDULE NOTES**
OWNER AND ARCHITECT TO REVIEW COLOR & MATERIAL SAMPLES PRIOR TO FINAL INSTALL.
- EXTERIOR FINISH SCHEDULE**
- | | |
|----------|---------------------------|
| EX1 (RR) | BOARD & BATTEN SIDING |
| EX2 (N) | CEDAR SHAKES |
| EX3 (N) | MATERIAL TO BE DETERMINED |
| EX4 (N) | WOOD DECK |
| EX5 (N) | METAL ROOF |

Project:

1705 NEWTON
AUSTIN, TX

Stamp:

NOTE: The drawings and specifications and ideas, designs and arrangements represented hereby are and shall remain the property of LOC STRUCTURAL and no part thereof shall be copied, reproduced or used in any way without the written consent of LOC STRUCTURAL. Violation of these provisions shall constitute a breach of contract and shall be cause for immediate termination of the agreement and shall be cause for the owner to pay LOC STRUCTURAL the sum of \$10,000.00 as liquidated damages.

Date	Issue

Owner:

ANTHONY &
SUSAN WOOD
1705 NEWTON ST.
AUSTIN, TX 78704

Engineer:

LOC STRUCTURAL
DIVISION
Terence O'Leary
1705 RAINIER AVE.
AUSTIN, TX 78704

Drawing:

DIG:A
Craig Howerman
414 W ANNIE ST
AUSTIN, TX 78704

CO: 2017

ALL RIGHTS RESERVED

Job No.

Sheet Name

Drawn By:

Yard Sheet Name:

Drawing:

EXTERIOR ELEVATIONS

A3.1