

1-3/52



I-3/53



I-3/54




I-3/55



I-3/56



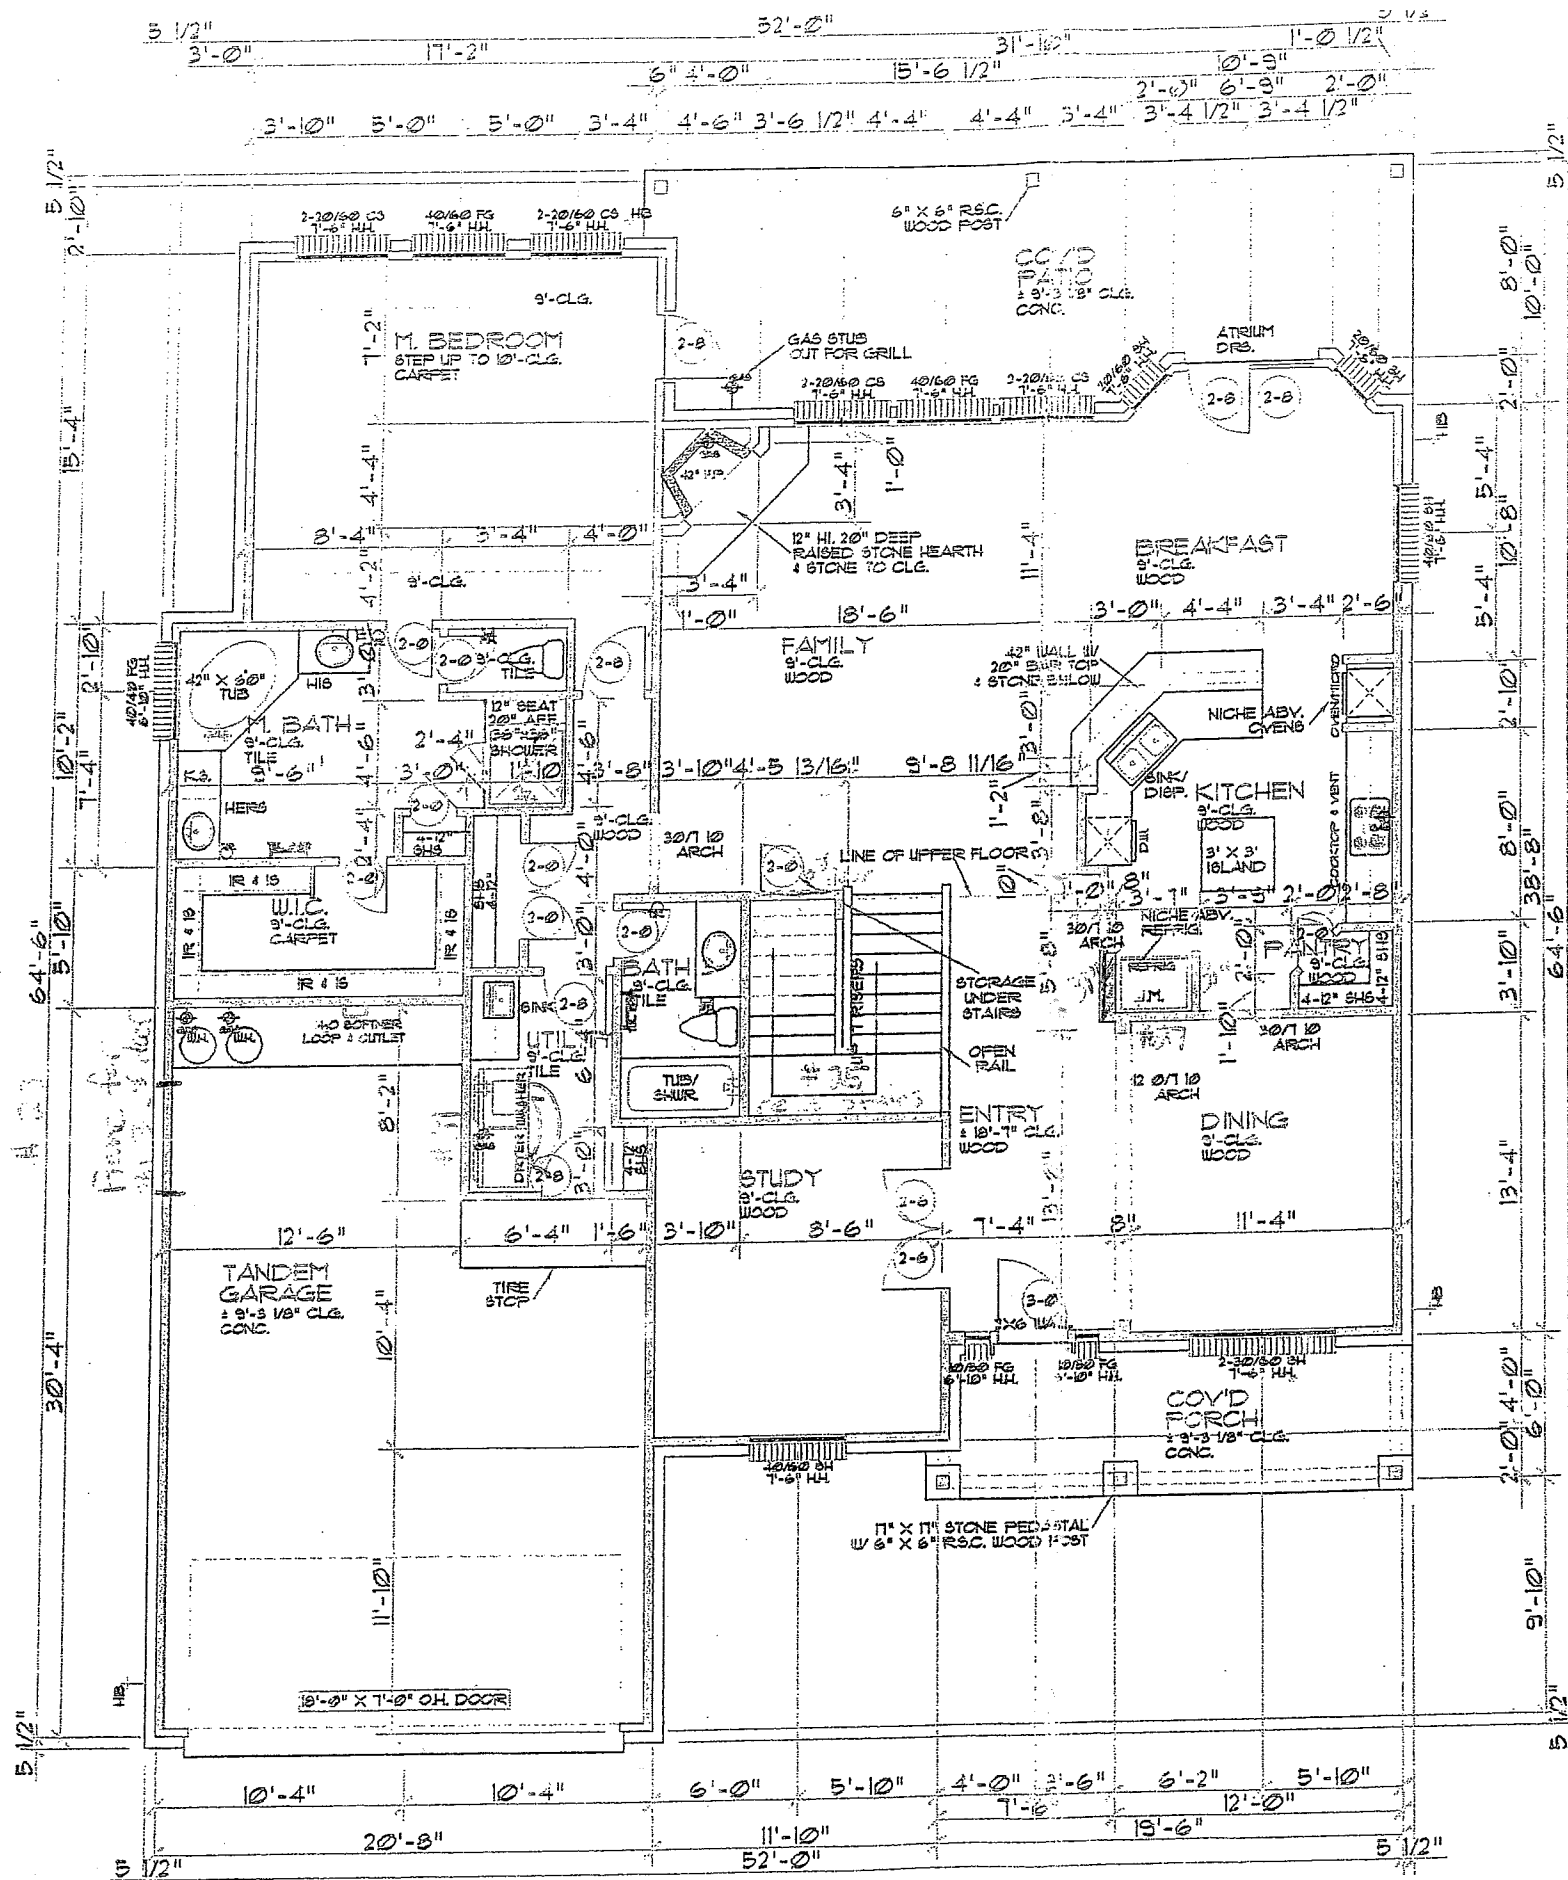

NOTE:
THIS PLAN IS A GRAPHIC REPRESENTATION FOR ESTIMATING PURPOSES ONLY. ACTUAL FIELD CONDITIONS MAY VARY AND MUST BE VERIFIED BEFORE PROCEEDING WITH CONSTRUCTION.

L-3/57

NOTICE

Subcontractor/Vendor/Supplier must have received signed-off proposal from Dimension Builders prior to job start and/or material delivery.

NOTICE

Subcontractor/Vendor/Supplier must have signed change order in work/material to be performed differs from plans and specs.

**RE
AS**

- #15 windows - same as 2nd
- #23 30" x 11" steel @ garage
- #25 12" x 12" stone / with 6" deep inset
- #26 pocket door changes 3/4" 3/4"
- #27 opening to be 31" or 7

NOTE: correction made to

#31 swap staircase
wooden
brackets

SQUARE FOOTAGES		
	FRAME	BRICK
LOWER LIVING	1833 SF.	1203 SF.
UPPER LIVING	1233 SF.	1268 SF.
TOTAL	3166 SF.	3271 SF.
GARAGE	536 SF.	564 SF.
COVD PORCH	116 SF.	116 SF.
COVD PATIO	317 SF.	317 SF.
TOTAL	4125 SF.	4274 SF.
SLAB		3006 SF.

DIMENSION BUILDERS
1900 W. UNIVERSITY AVE. STE. 103
GEORGETOWN TX, 75227
(512) 864-9191

DRAWN BY

CHECKED BY

DATE
06-10-04

KOPEC RESIDENCE
2800 VIVICREST
001-10000
PLAN NO.

SHEET NO.

2

FLOOR PLAN
1/8"=1'-0"

NOTE:
THESE PLANS ARE OWNED BY DIMENSION BUILDERS INC.
THESE PLANS ARE PROTECTED UNDER THE
TRADE SECRET LAWS, AND MAY NOT BE RELEASED
TO ANY THIRD PARTY WITHOUT THE SPECIFIC
WRITTEN PERMISSION OF DIMENSION BUILDERS, INC.

1-3/58

ANDERSON

(512) 664-3131

P. 12C

LPC

7-13-4

00-0000
087


PLAN NO.


NET NO.

3

$$V_{\text{eff}} = \frac{1}{2} \mu \omega^2 r^2$$

THESE PLANS ARE OWNED BY DIMENSION BUILDERS INC.
THESE PLANS ARE PROTECTED UNDER THE
TRADE SECRET LAWS, AND MAY NOT BE RELEASED
TO ANY THIRD PARTY WITHOUT THE SPECIFIC
WRITTEN PERMISSION OF DIMENSION BUILDERS, INC.

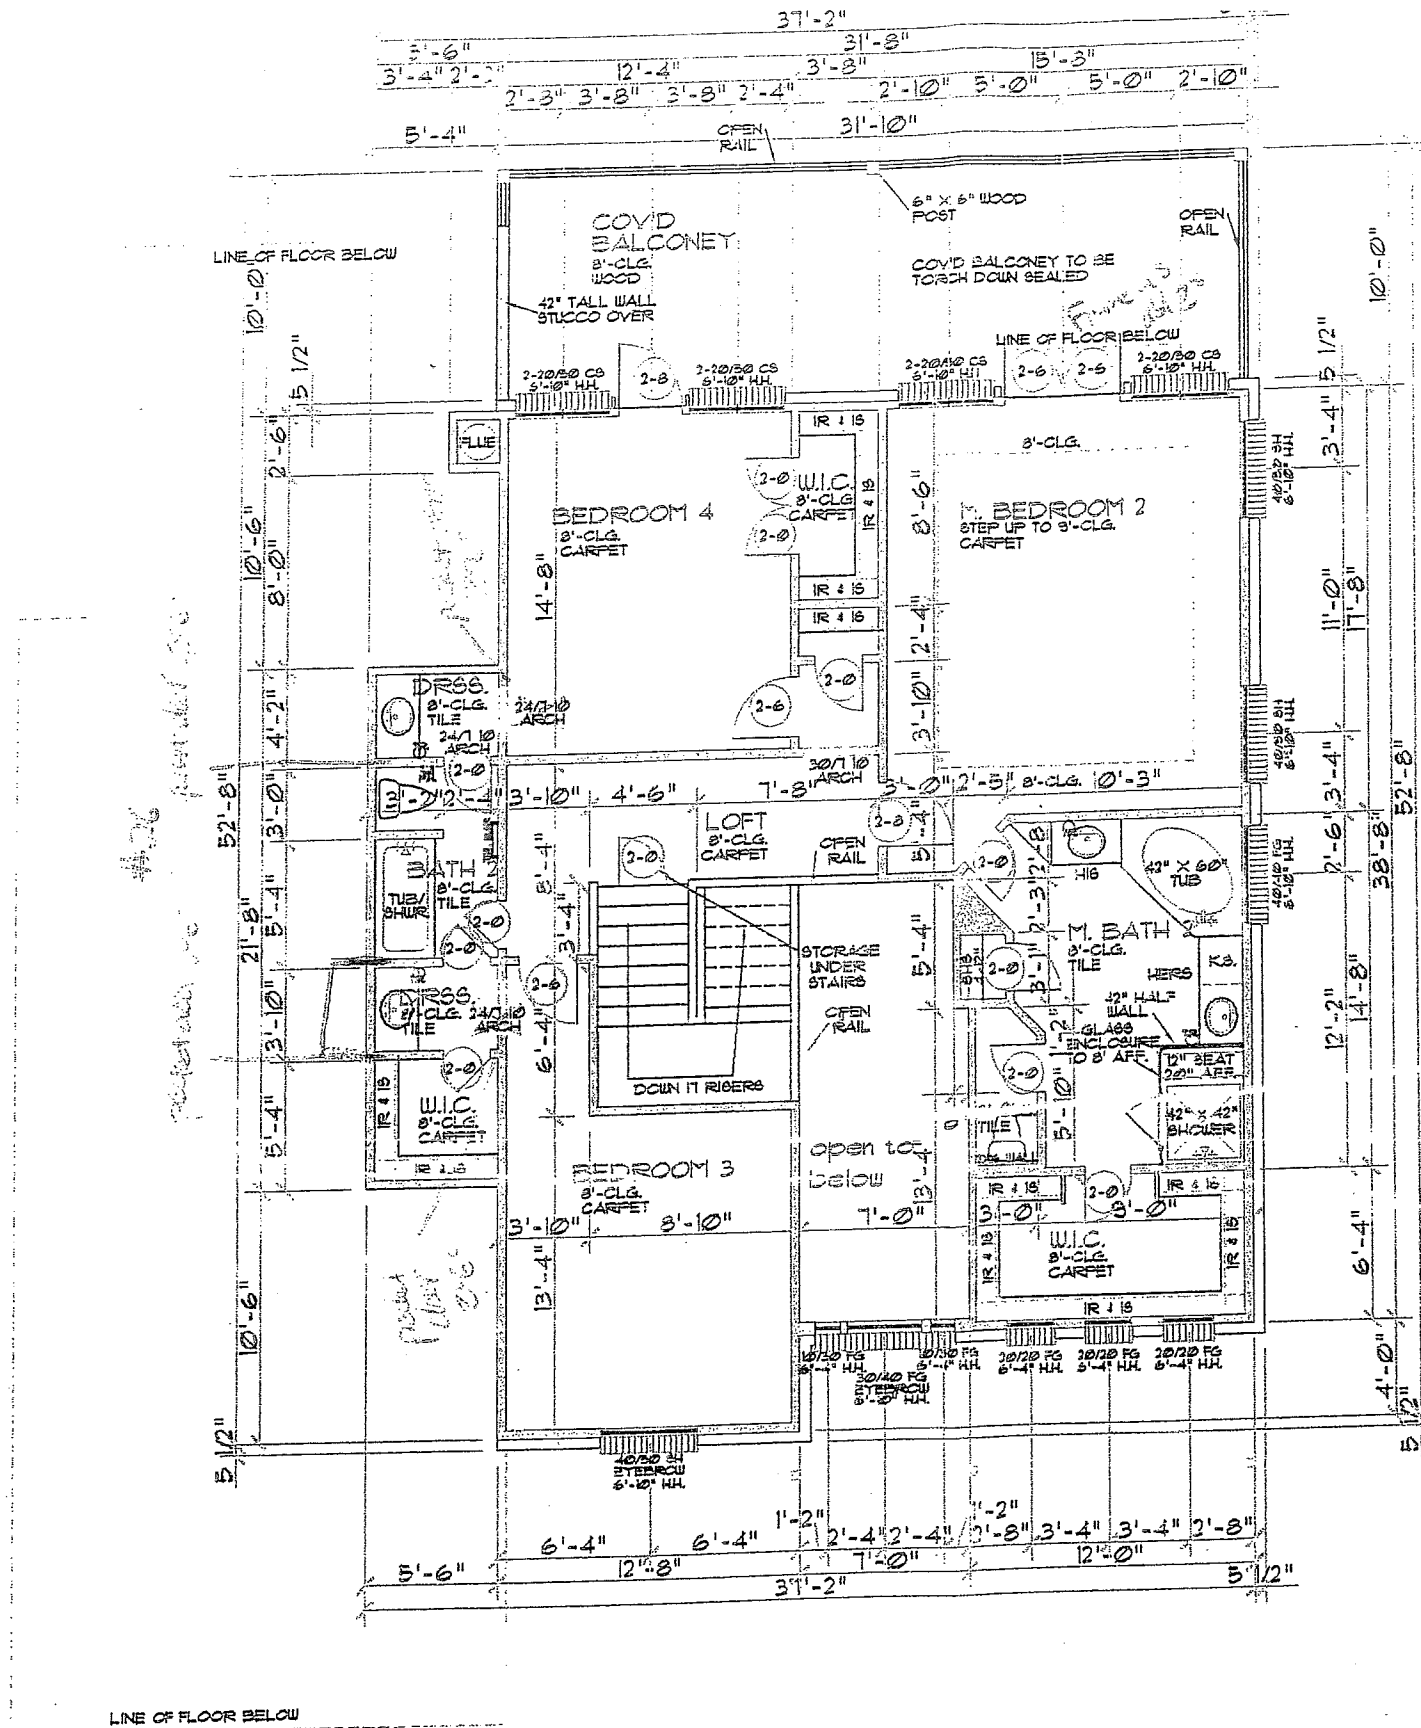

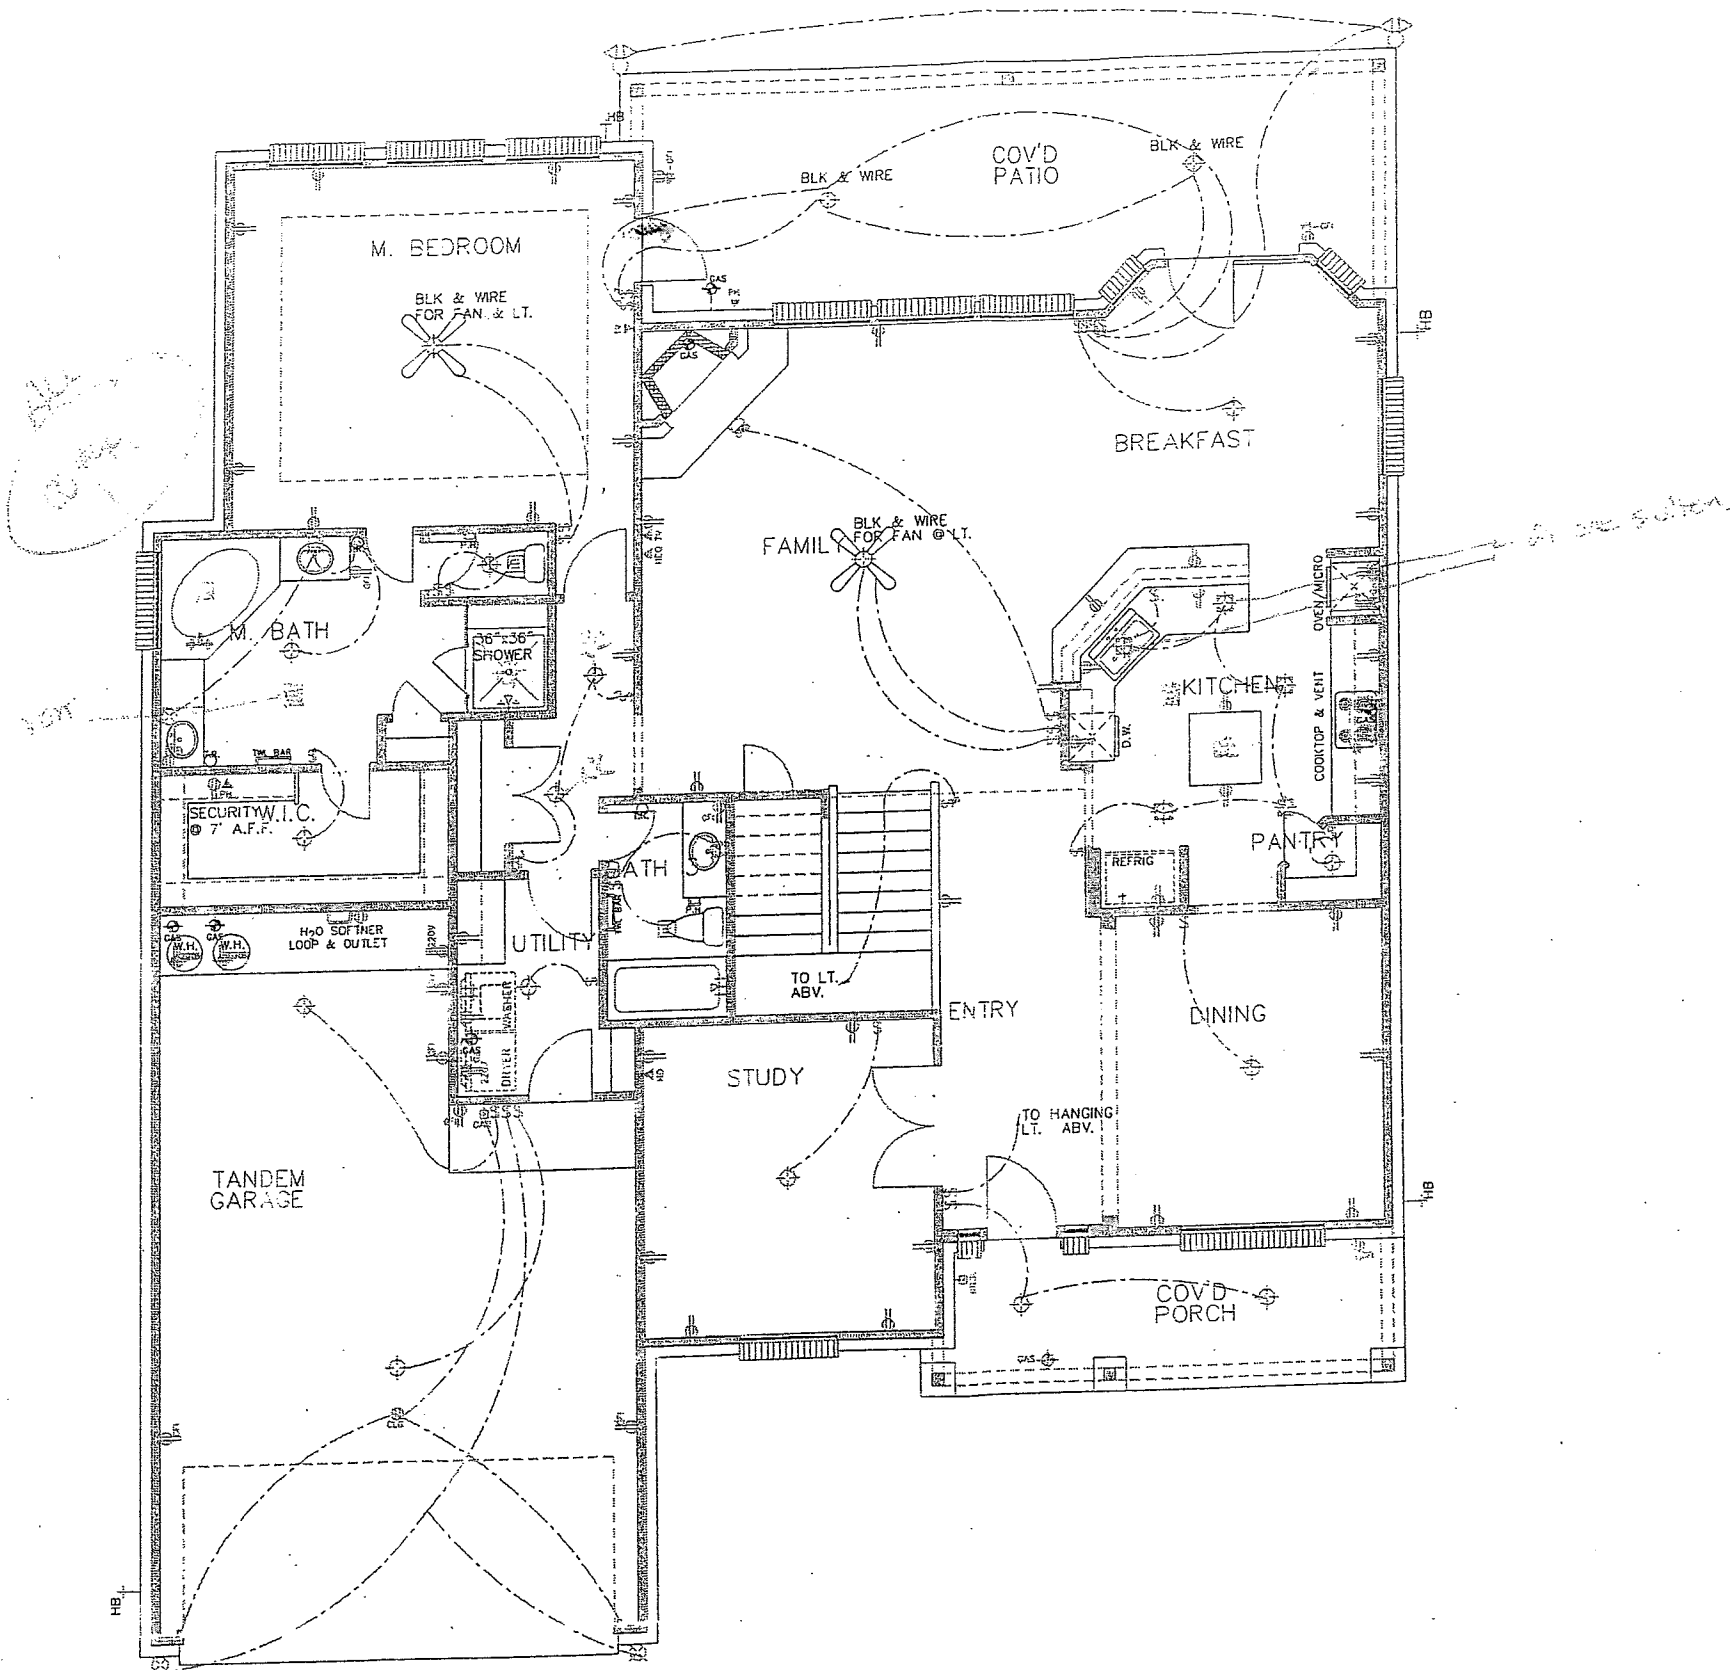

ELECTRICAL LEGEND	
[Symbol]	SWITCH
[Symbol]	THREE-WAY SWITCH
[Symbol]	FOUR-WAY SWITCH
[Symbol]	RHEOSTAT
[Symbol]	DUPLEX
[Symbol]	37" OR 42" COUNTERTOP DUPLEX
[Symbol]	SPLIT WIRED DUPLEX
[Symbol]	QUADRUPLX
[Symbol]	CEILING DUPLEX
[Symbol]	FLOOR DUPLEX
[Symbol]	PHONE OUTLET
[Symbol]	TV OUTLET
[Symbol]	THERMOSTAT
[Symbol]	SMOKE DETECTOR
[Symbol]	JUNCTION
[Symbol]	220 VOLT OUTLET
[Symbol]	CEILING LIGHT
[Symbol]	RECESSED CEILING LIGHT
[Symbol]	WALL HUNG LIGHT
[Symbol]	EYEBALL LIGHT
[Symbol]	RECESSED EYEBALL LIGHT
[Symbol]	VENT
[Symbol]	VENT AND LIGHT
[Symbol]	HEAT AND LIGHT
[Symbol]	HEAT AND VENT
[Symbol]	HEAT, VENT AND LIGHT
[Symbol]	LANDSCAPING LIGHT
[Symbol]	FLOODLIGHT

* CT OUTLETS AT 37" WITH JOB BUILT TOPS.
CT OUTLETS AT 42" WITH POST FORM TOPS
COUNTERTOPS PER COMMUNITY SPECS.

MASTER

NOTE:
THESE PLANS ARE OWNED BY DIMENSION BUILDERS INC.
THESE PLANS ARE PROTECTED UNDER THE
TRADE SECRET LAWS, AND MAY NOT BE RELEASED
TO ANY THIRD PARTY WITHOUT THE SPECIFIC
WRITTEN PERMISSION OF DIMENSION BUILDERS INC.

ELECTRICAL PLAN 1
1/8"=1'-0"

DIMENSION BUILDERS
1500 W. UNIVERSITY AVE., STE. 103
GEORGETOWN TX, 78627
(512) 864-9797

DRAWN BY

CHECKED BY

DATE
06-10-04


KOPEC RESIDENCE

PLAN NO.

SHEET NO.
4

NOTE:
THIS PLAN IS A GRAPHIC REPRESENTATION
FOR ESTIMATING PURPOSES ONLY. ACTUAL
FIELD CONDITIONS MAY VARY AND MUST BE
VERIFIED BEFORE PROCEEDING WITH
CONSTRUCTION.

L-3/60

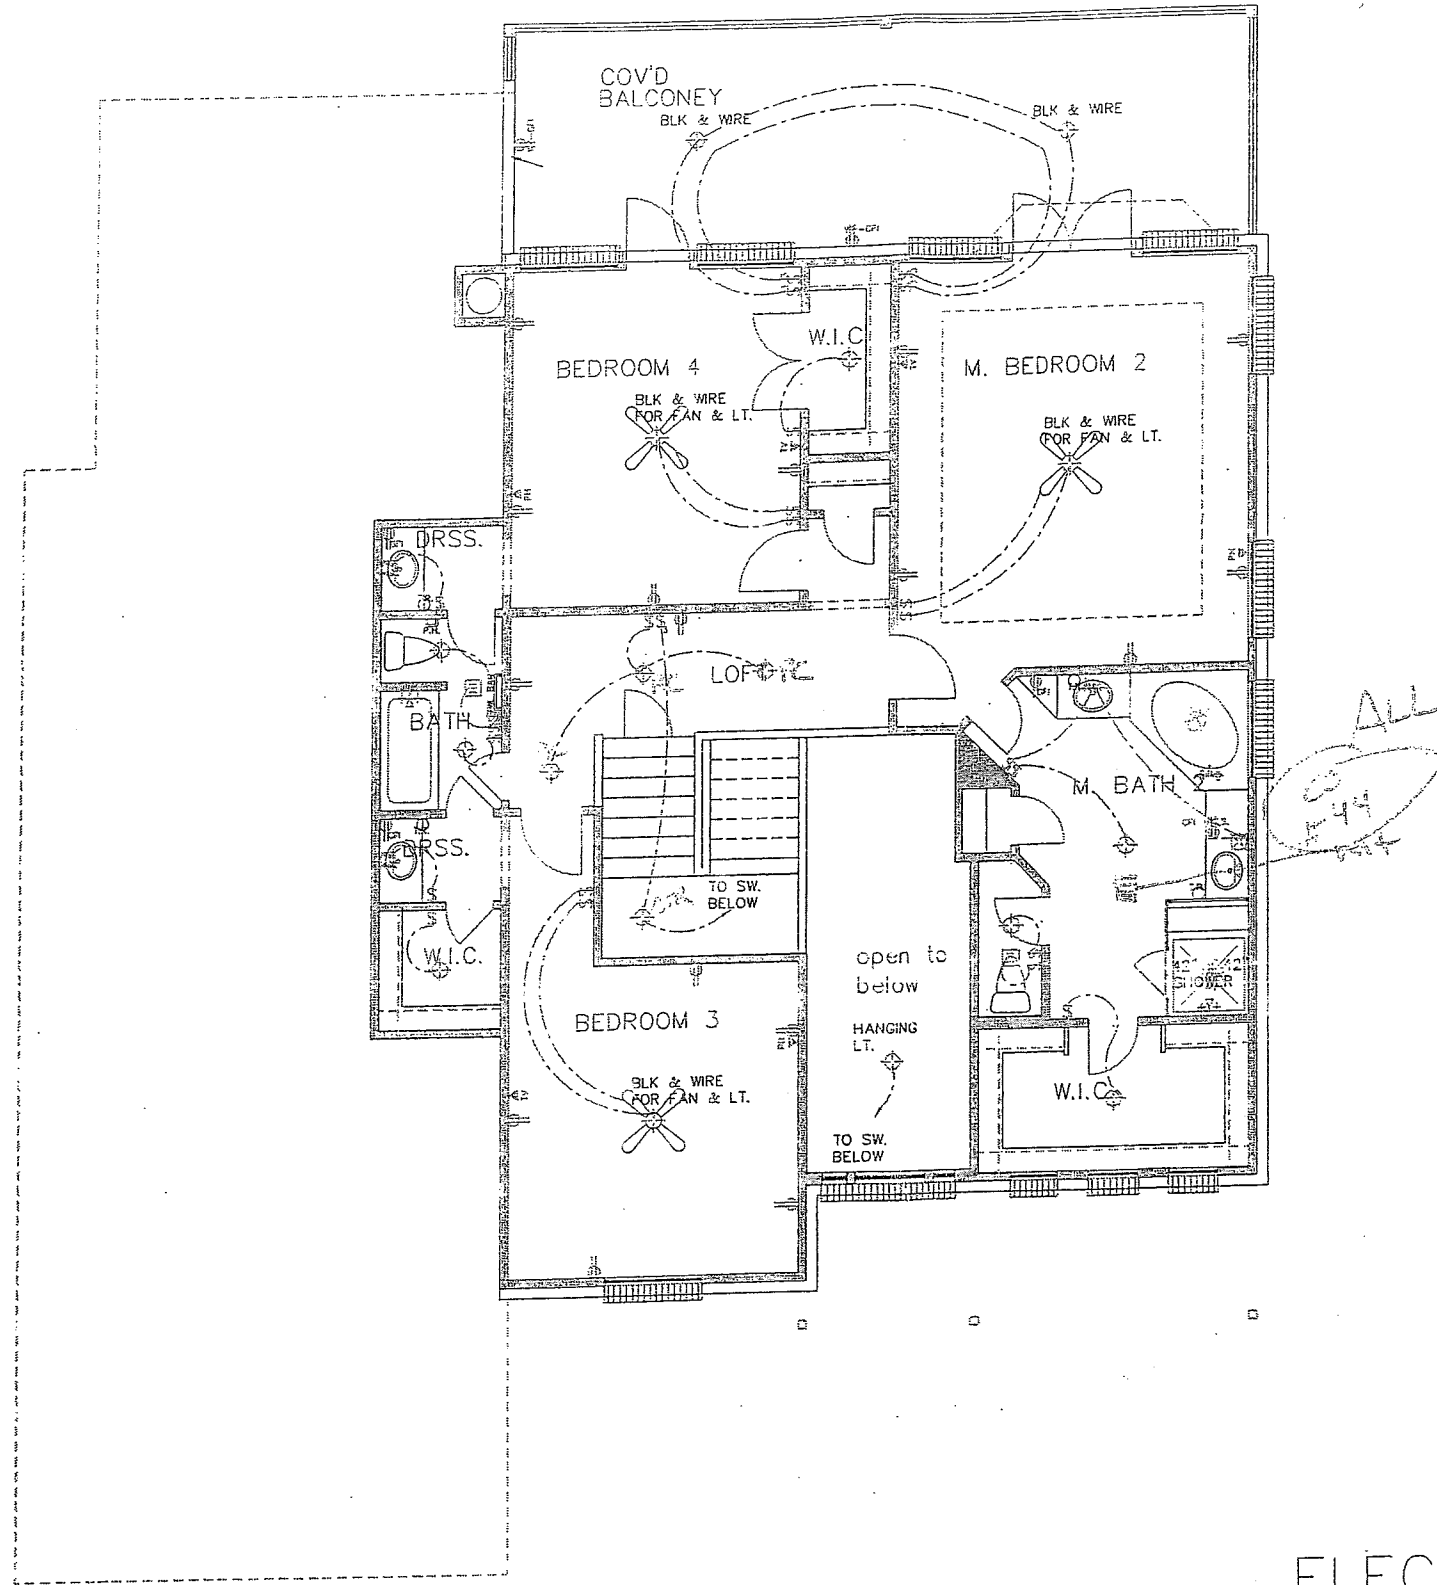

MASTER

ELECTRICAL PLAN 2
1/8"=1'-0"

NOTE:
THESE PLANS ARE OWNED BY DIMENSION BUILDERS INC.
THESE PLANS ARE PROTECTED UNDER THE
TRADE SECRET LAWS, AND MAY NOT BE RELEASED
TO ANY THIRD PARTY WITHOUT THE SPECIFIC
WRITTEN PERMISSION OF DIMENSION BUILDERS, INC.

DIMENSION BUILDERS
1500 W. UNIVERSITY AVE. STE. 103
GEORGETOWN TX. 78627
(512) 864-9797

DRAWN BY
JP, LPC

CHECKED BY
LPC

DATE
7-15-4

KOPEC RESIDENCE

PLAN NO.

SHEET NO.
5

NOTE:
THIS PLAN IS A GRAPHIC REPRESENTATION
FOR ESTIMATING PURPOSES ONLY. ACTUAL
FIELD CONDITIONS MAY VARY AND MUST BE
VERIFIED BEFORE PROCEEDING WITH
CONSTRUCTION.


















NOTE:
ACTUAL CABINET FRONTS, DOORS,
DRAWER FRONTS AND DRAWERS
MAY VARY FROM THE STANDARD
ARCHITECTURAL GRAPHICS USED
FOR THE ELEVATIONS.
CONSULT SALES COUNSELOR FOR
CLARIFICATION.

Handwritten signature

DIMENSION BUILDERS
1520 W. UNIVERSITY AVE. STE. 103
GEORGETOWN TX, 78627
(512) 864-5191

MASTER

DRAWN BY []
CHECKED BY []
DATE []
PLAN NO. []
SHEET NO. []

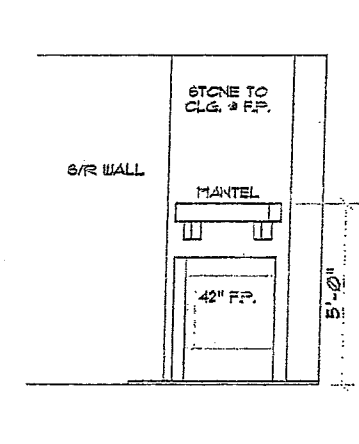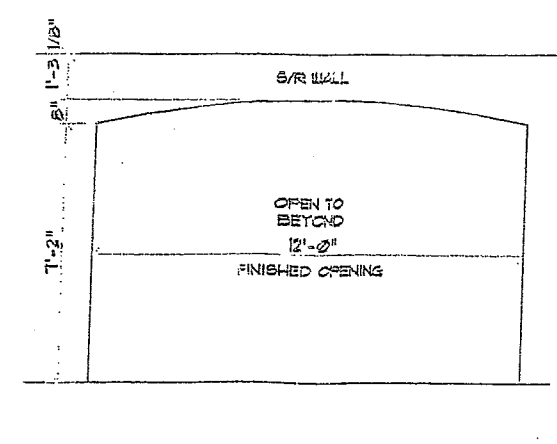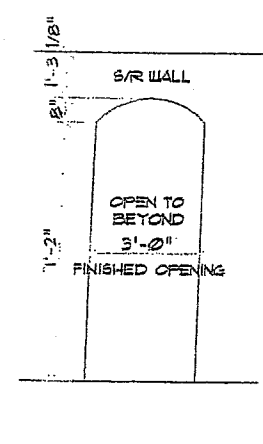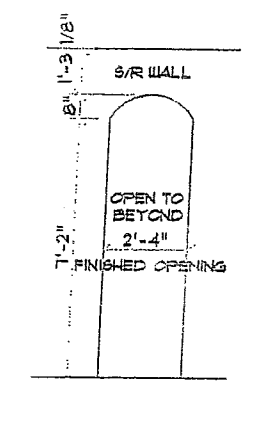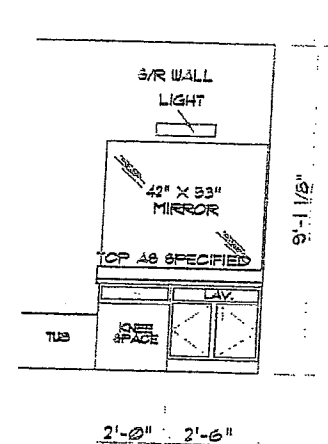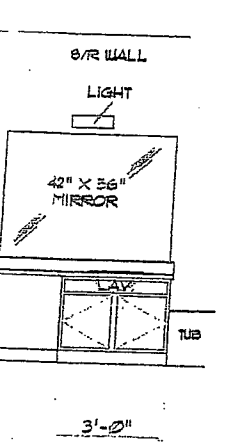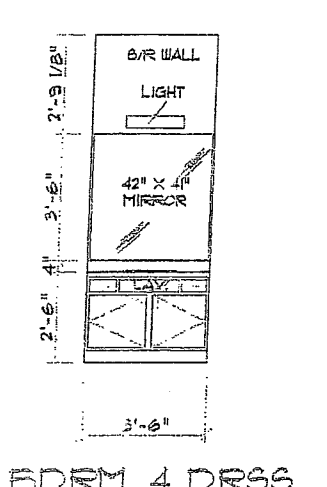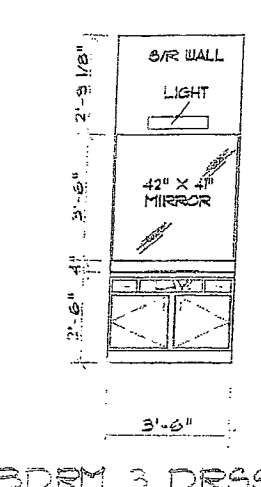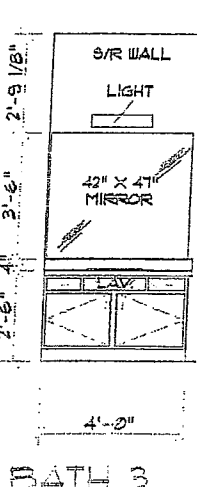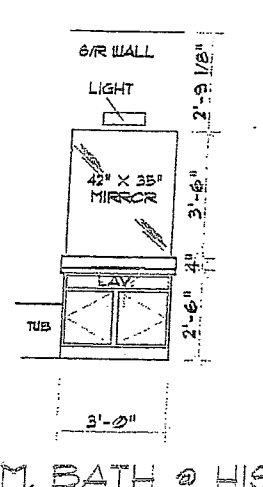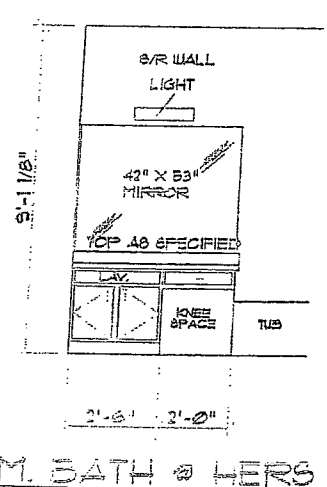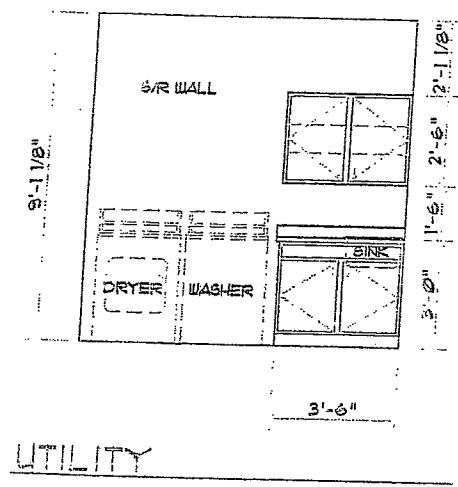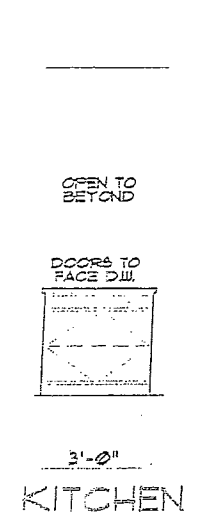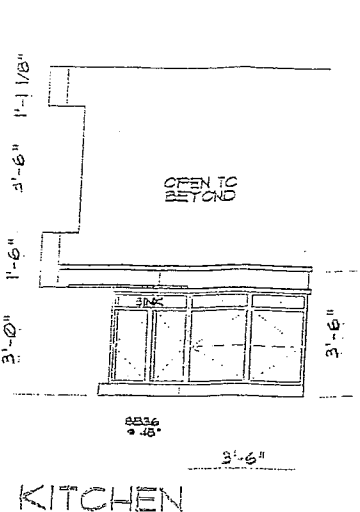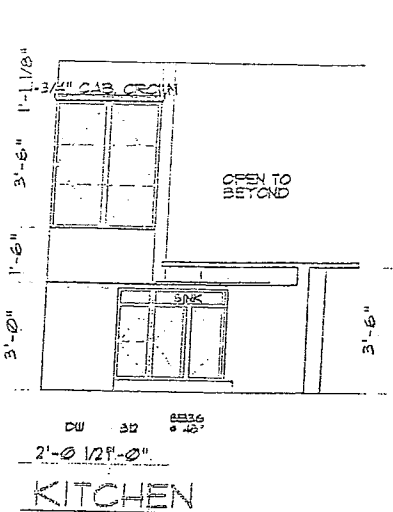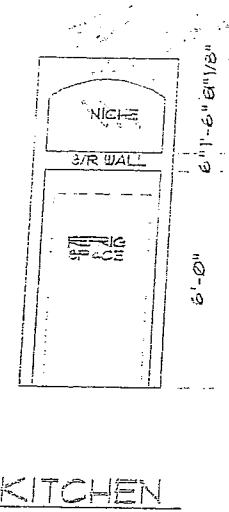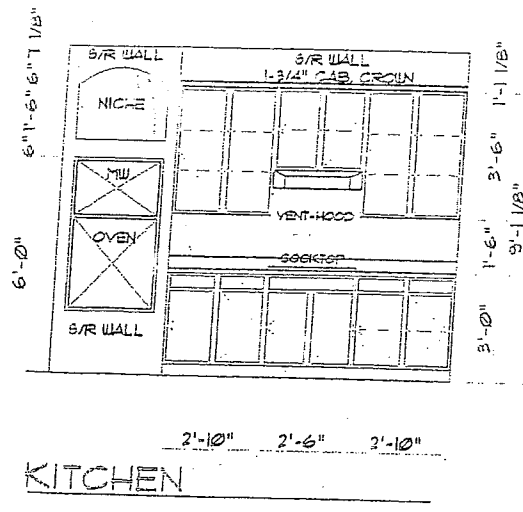

THE PLANS ARE OWNED BY DIMENSION BUILDERS INC.
THE PLANS ARE PROTECTED UNDER THE
DE SECREAT LAWS, AND MAY NOT BE RELEASED
NY THIRD PARTY WITHOUT THE SPECIFIC
TEN PERMISSION OF DIMENSION BUILDERS, INC.

CABINET DETAILS

KOPEC RESIDENCE

NOTE:

7/2/67

3-DIMENSION BUILDERS

REVISION BUILD
500 W. UNIVERSITY AVE. STE. 103

W. UNIVERSITY AVE. STE.
GEORGETOWN TX 78627

ARGENTON TX, 78627
(512) 864-9797

(512) 864-9797

1/8" = 1'-0'

 $1/8" \times 1" = 2'$

五、参考文献

RECEIVED BY

DATE 11/11/68

KOPEC RESIDENCE


PLAN NO.

SECRET NO

RE
1/8" x 11" - 2"


PLANS ARE OWNED BY DIMENSION BUILDERS INC.
PLANS ARE PROTECTED UNDER THE
E SECRET LAWS, AND MAY NOT BE RELEASED
Y THIRD PARTY WITHOUT THE SPECIFIC
EN PERMISSION OF DIMENSION BUILDERS, INC.

THIS PLAN IS A GRAPHIC REPRESENTATION
FOR ESTIMATING PURPOSES ONLY. ACTUAL
FIELD CONDITIONS MAY VARY AND MUST BE
VERIFIED BEFORE PROCEEDING WITH
CONSTRUCTION.

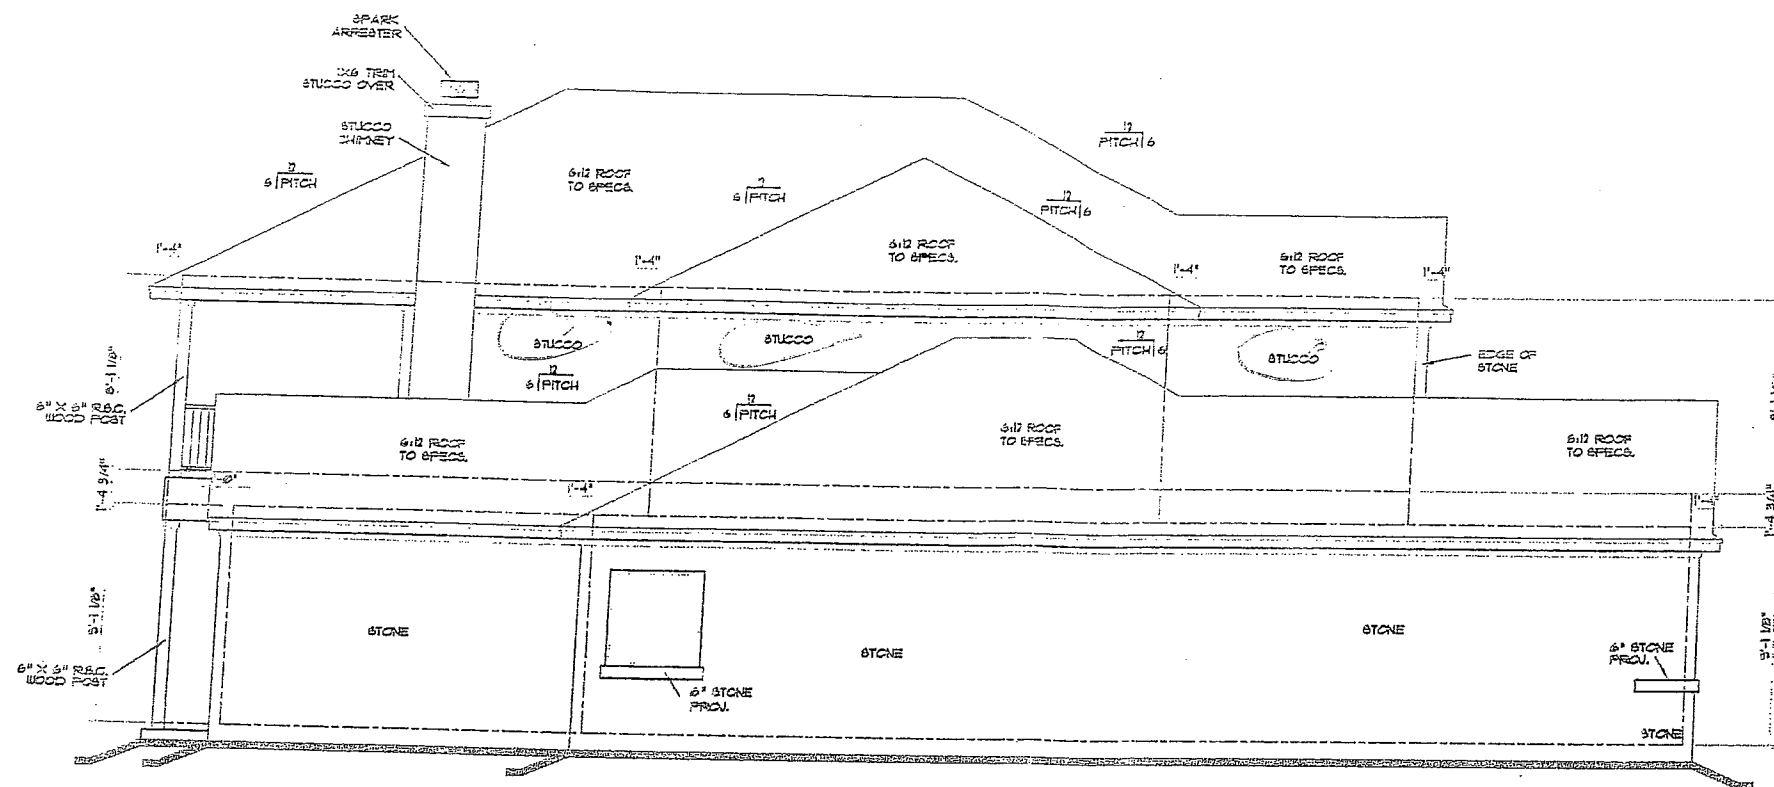

LEFT ELEVATION

1/2" x 1" - 01

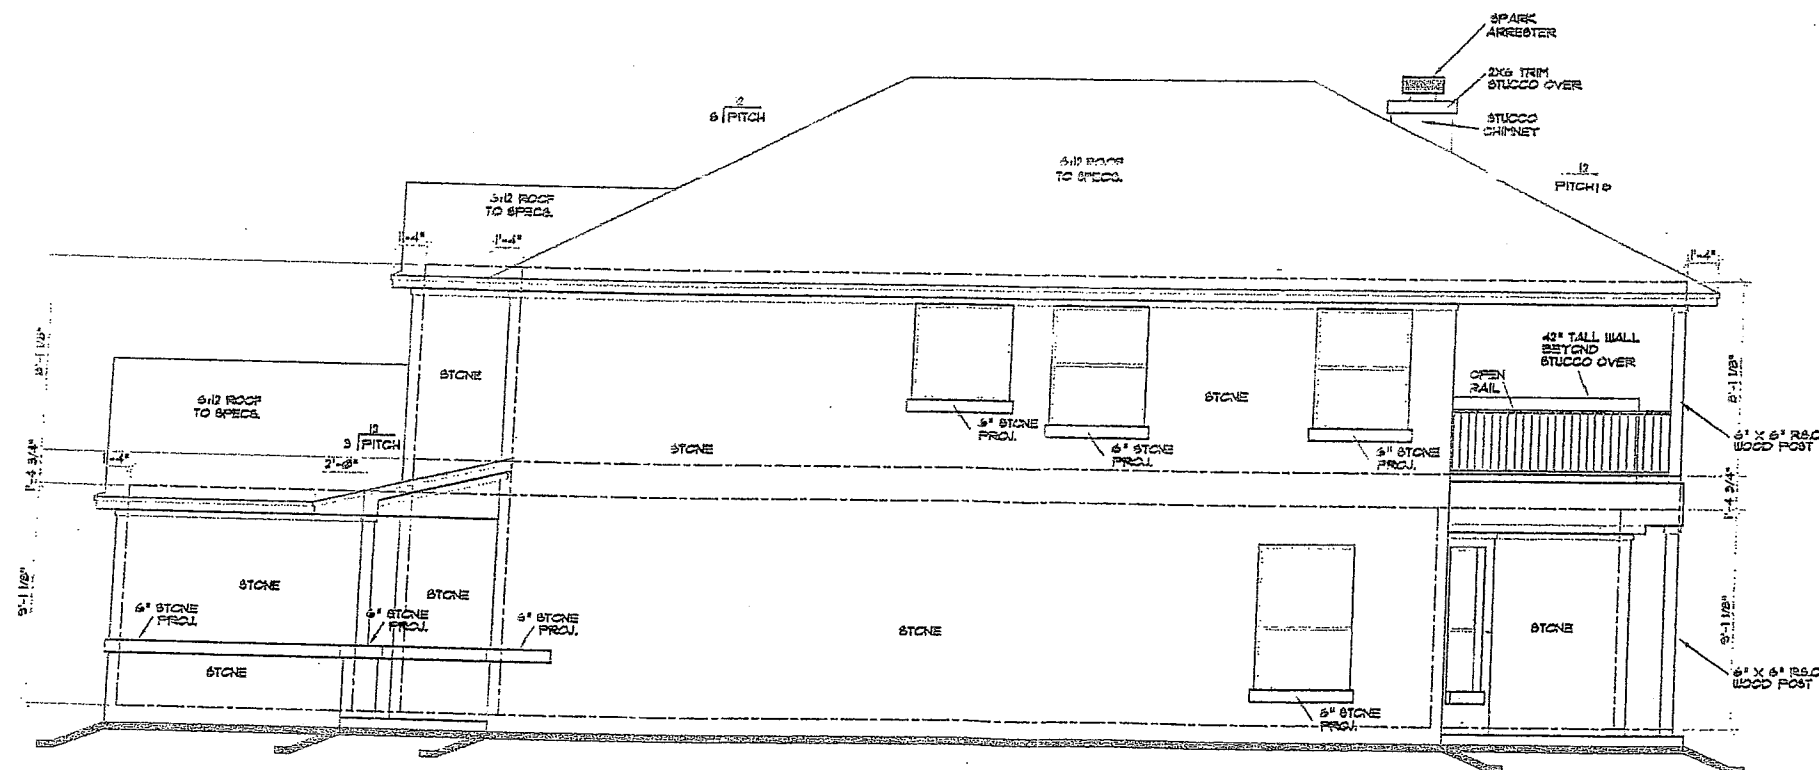

RIGHT ELEVATION

1/8" x 1'-0"

WAS THE

CONCRETE BUILDERS

500 W UNIVERSITY AVE STE 103

W UNIVERSITY AVE. STE.
GEORGETOWN TX 78627

REGENTOWN TX, 78125

RECEIVED BY

DATE

KOPEC RESIDENCE

PLAN NO.

SHEET NO. 10

6

PLANS ARE OWNED BY DIMENSION BUILDERS INC.
PLANS ARE PROTECTED UNDER THE
SECRET LAWS, AND MAY NOT BE RELEASED
TO THIRD PARTY WITHOUT THE SPECIFIC
PERMISSION OF DIMENSION BUILDERS, INC.