





5/5/2022 10:36:42 AM D:\JAY'S TRANSFERRED DATA FILES\SWED HILL\REVIT\13TH MAIN HOUSE.RVT

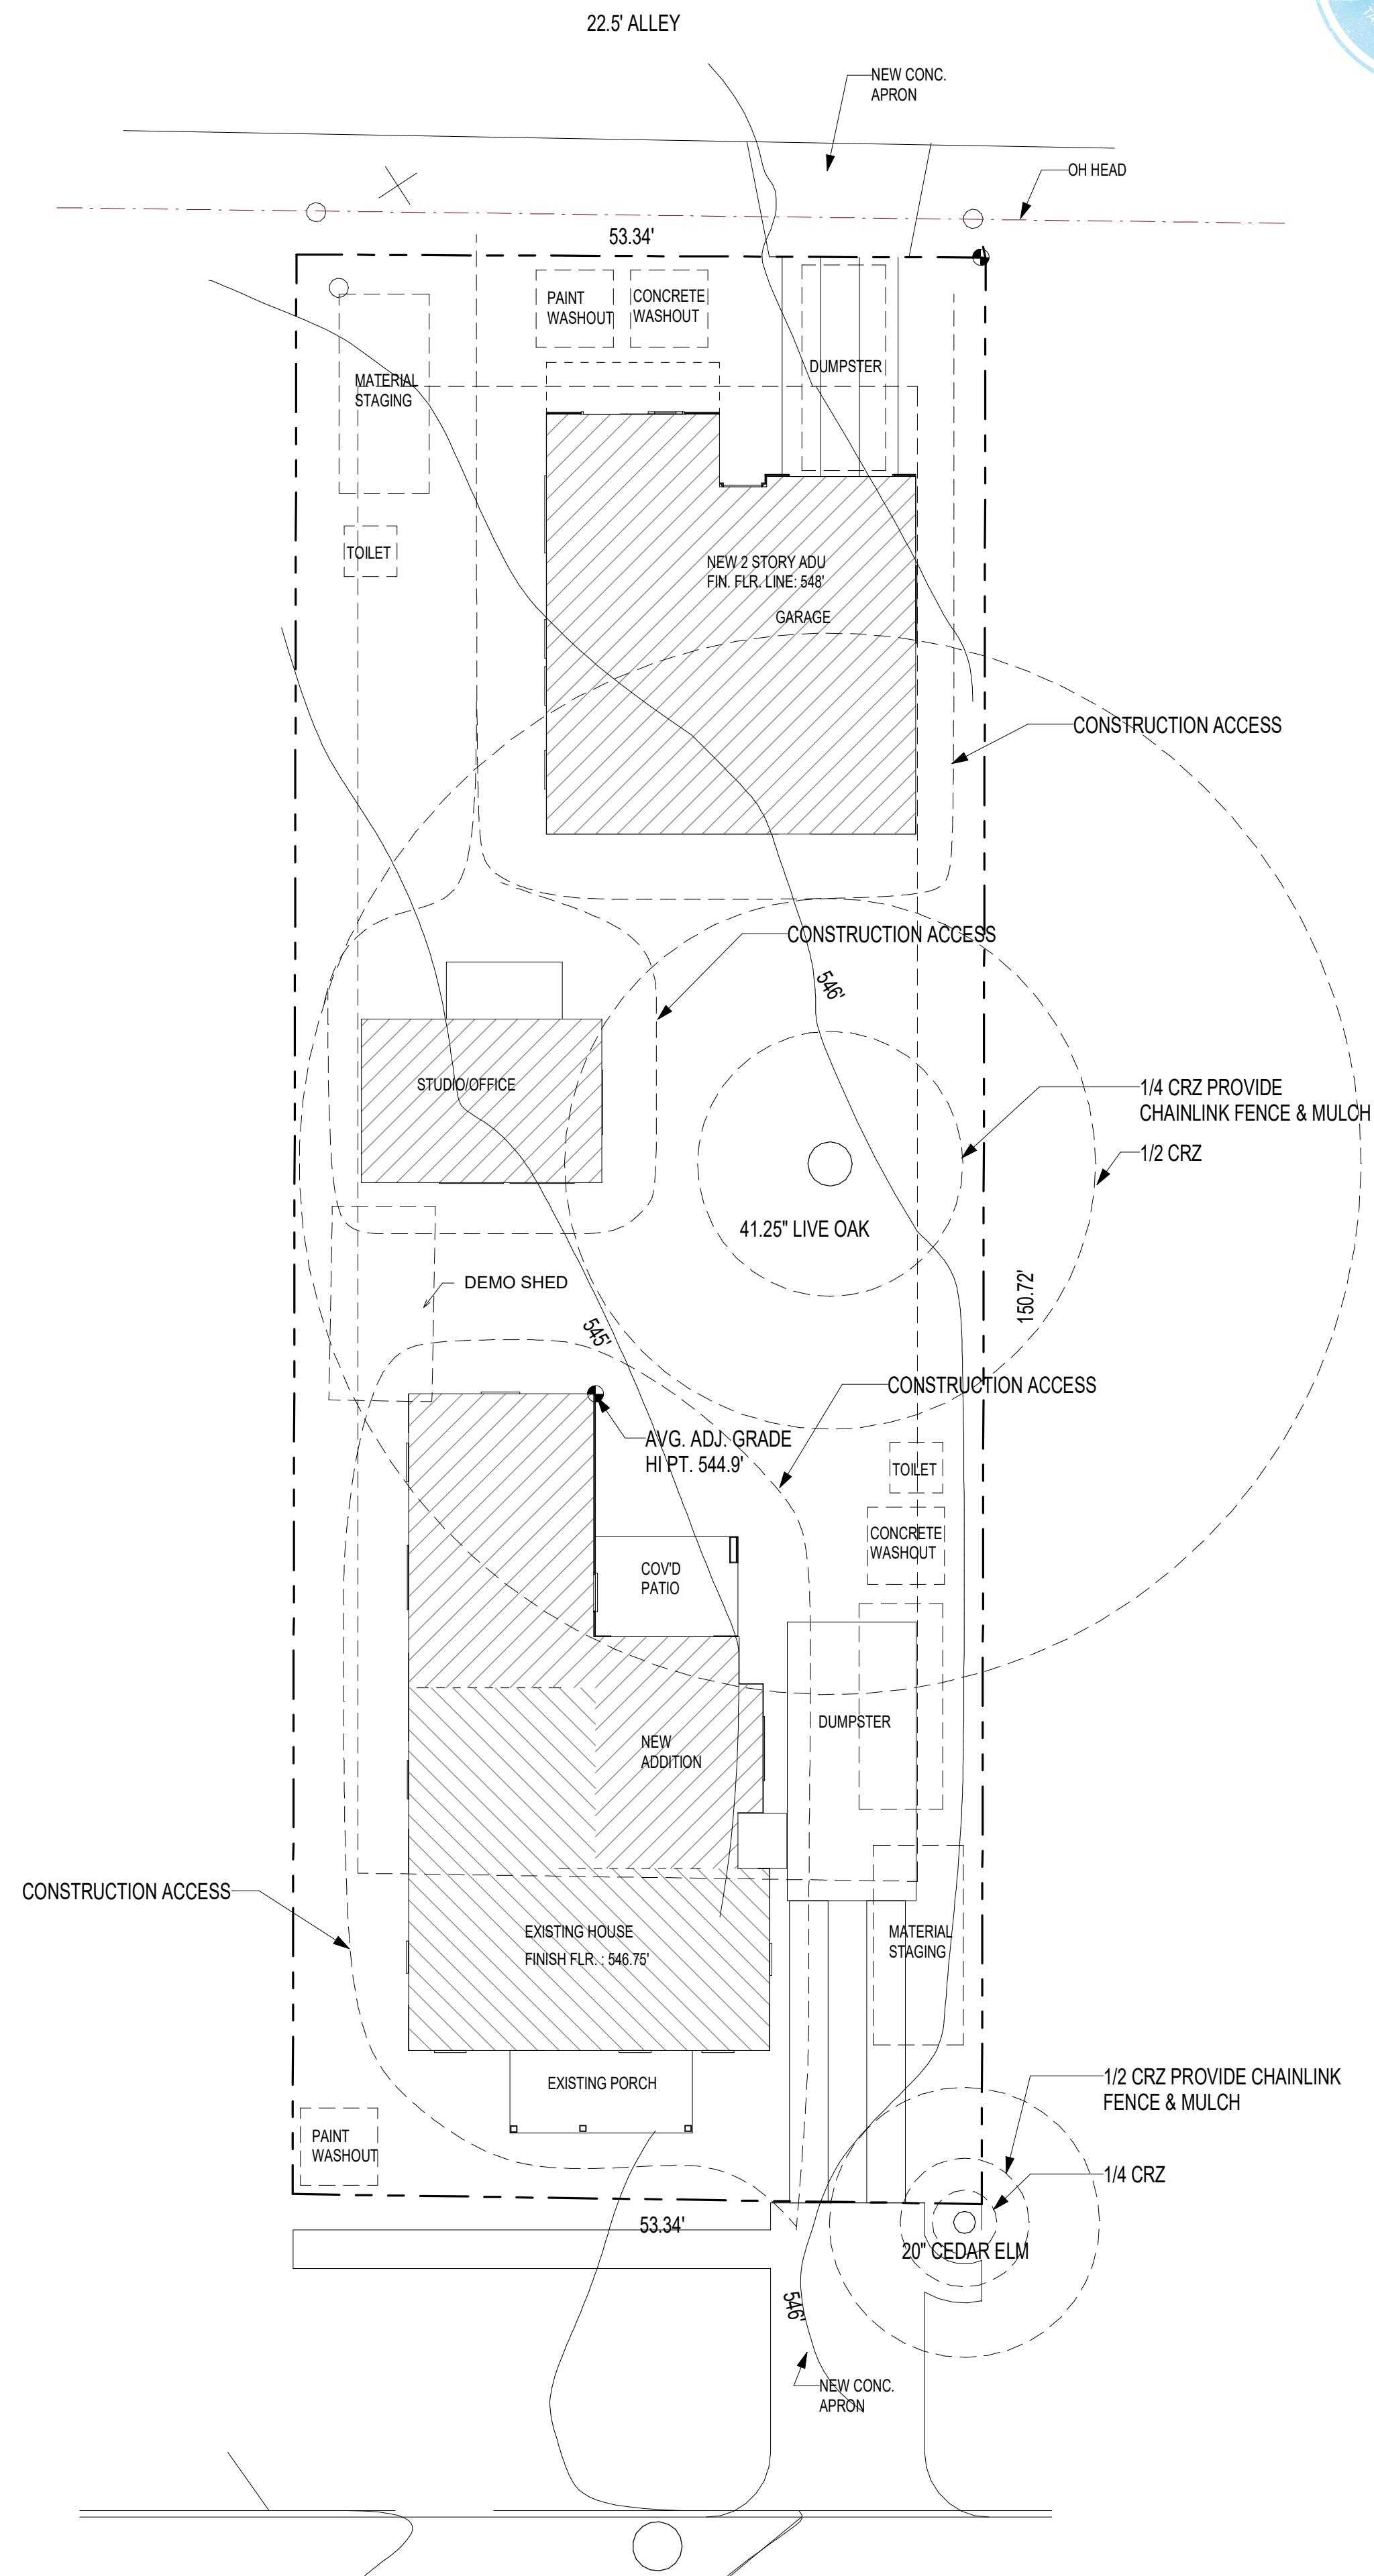

2 CONSTRUCTION PHASING PLAN  
1" = 10'-0"

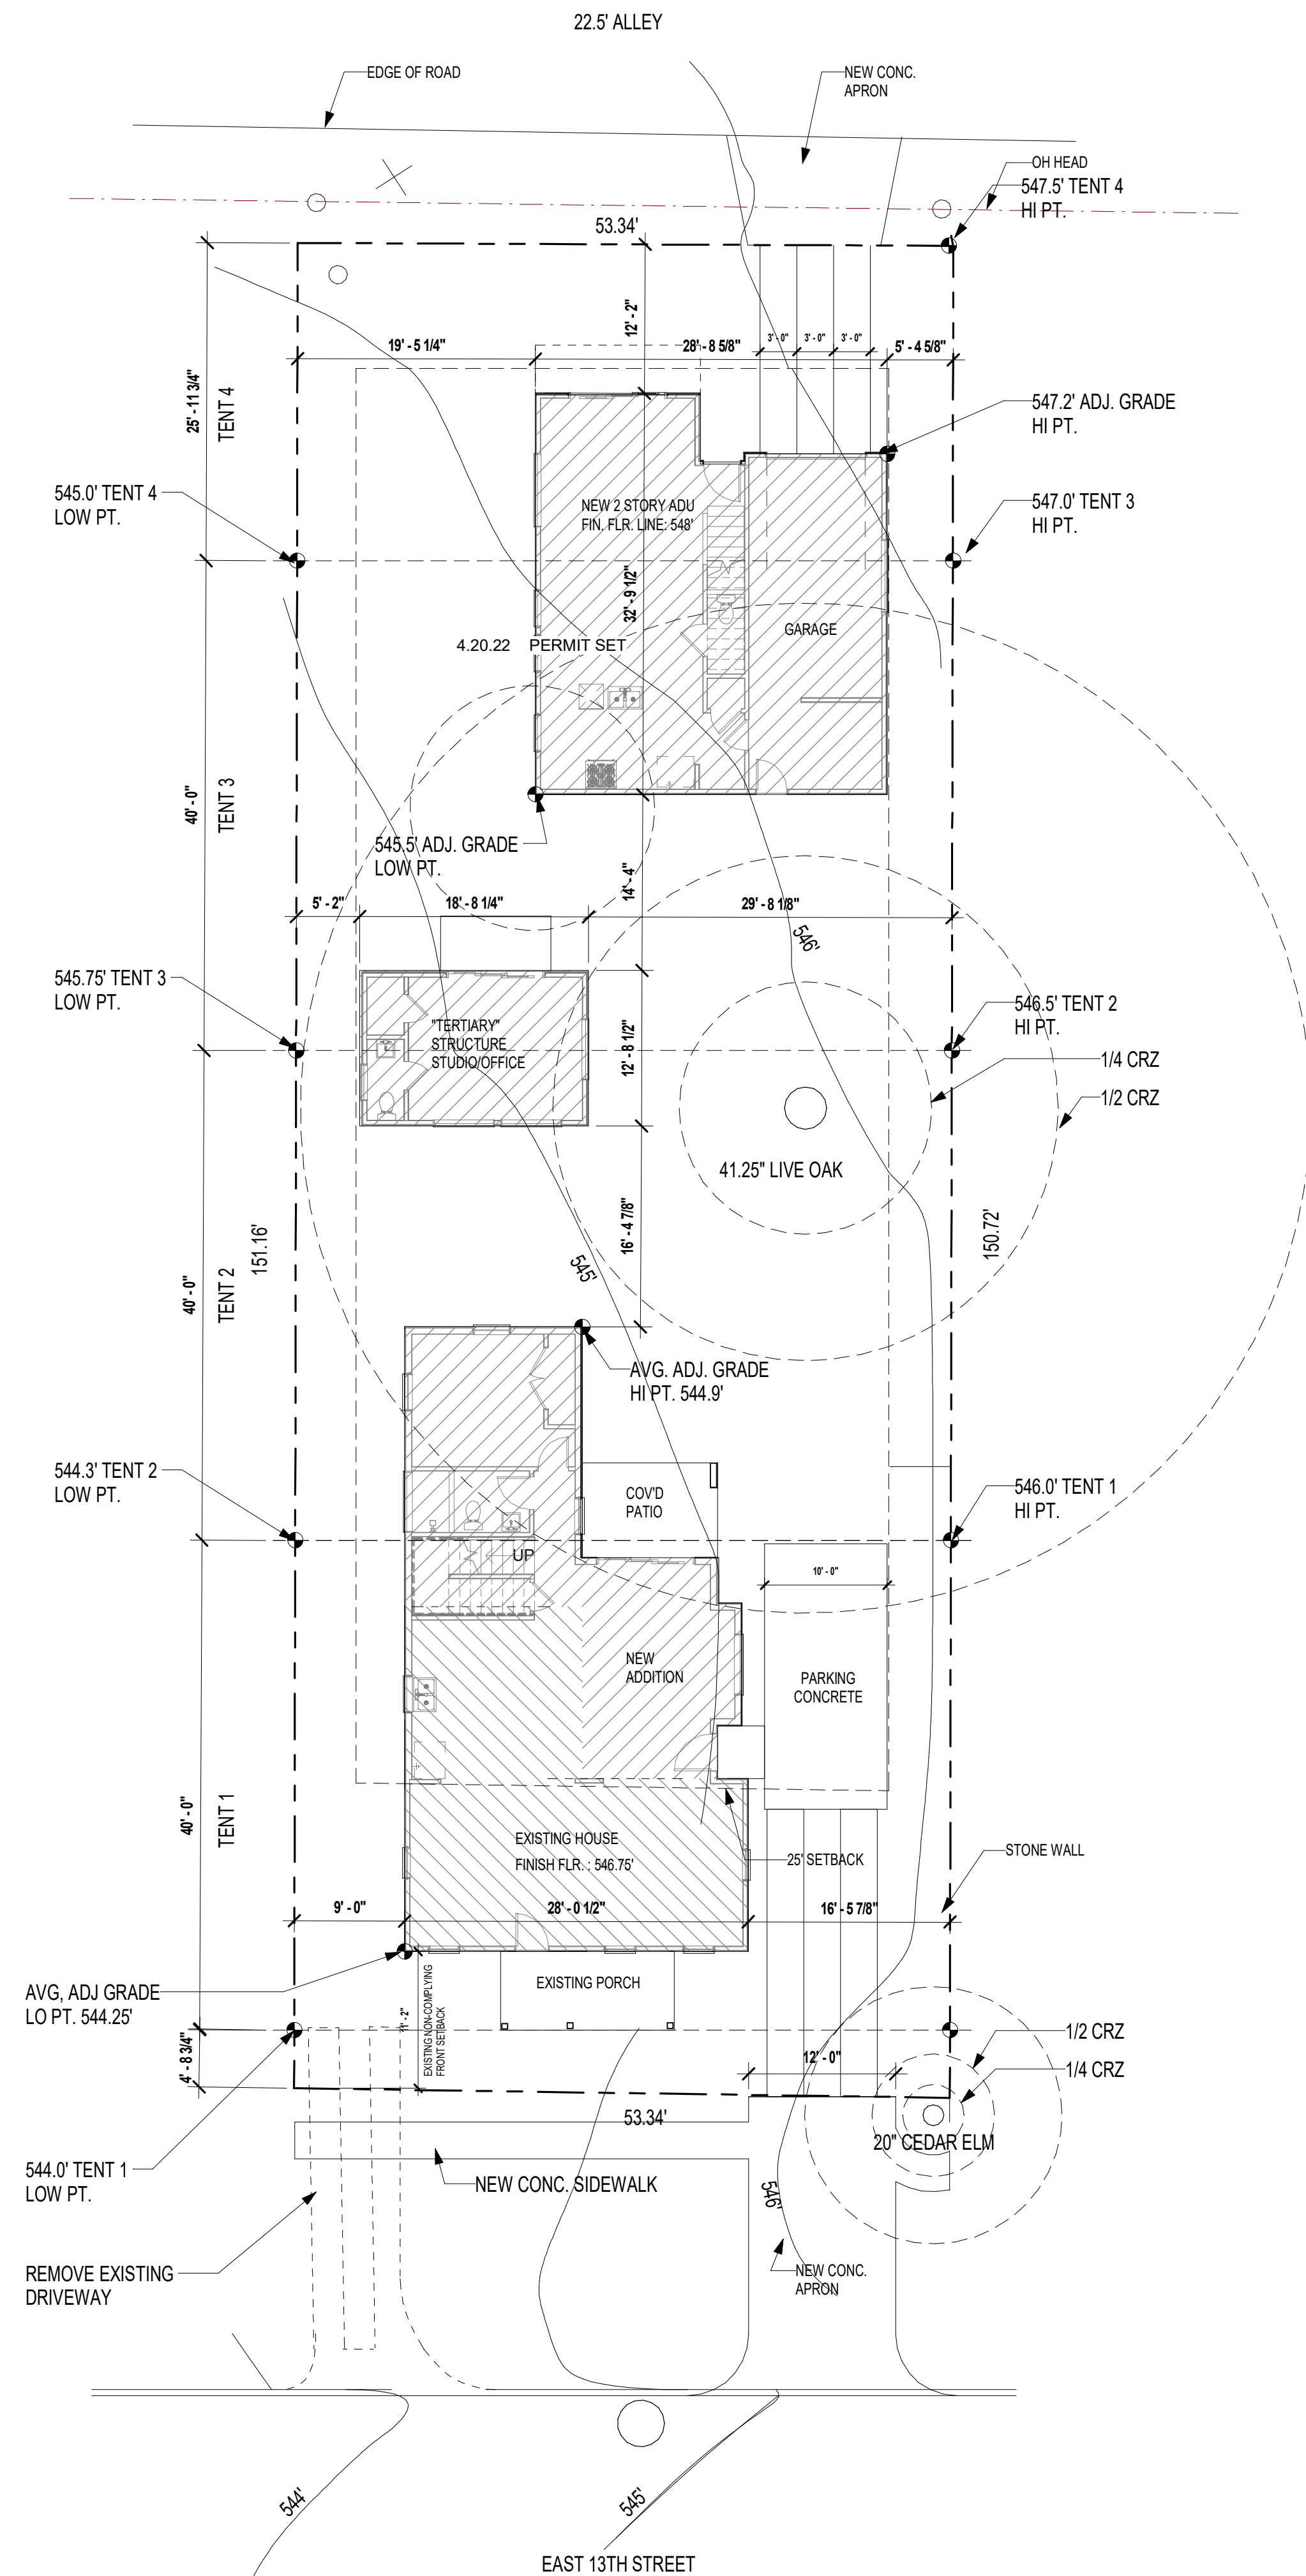

1 SITE / VISITABILITY PLAN  
1" = 10'-0"

|         |            |
|---------|------------|
| 4.22.22 | PERMIT SET |
|         |            |
|         |            |
ELEMENT 5  
ARCHITECTURE

RESIDENTIAL & HOSPITALITY  
ARCHITECTURE & PLANNING

1212 Chicon Street  
Ste. 101  
Austin, TX 78702  
(512) 473-8228 Voice

www.element5architecture.com



908 E. 13TH  
ADDITION &  
ADU

AUSTIN, TX 78702

SITE PLAN

A1.0

© COPYRIGHT 2009, E5A.  
ALL RIGHTS RESERVED

# 908 E. 13TH ADDITION & ADU

AUSTIN, TX 78702



## INDEX OF DRAWING

### SHEET NUMBER

### SHEET NAME

|      |                                      |
|------|--------------------------------------|
| A0.0 | COVER SHEET                          |
| A1.0 | SITE PLAN                            |
| A1.1 | DEMO PLANS                           |
| A2.0 | MAIN HOUSE FIRST & SECOND FLOOR PLAN |
| A2.1 | MAIN HOUSE THIRD FLOOR & ROOF PLAN   |
| A2.2 | ADU FLOOR PLANS                      |
| A3.0 | EXTERIOR ELEVATIONS                  |
| A3.1 | EXTERIOR ELEVATIONS                  |
| A3.2 | ADU ELEVATIONS                       |
| A3.3 | TERTIARY STRUCTURE PLANS & ELEVS     |
| A4.0 | BUILDING SECTIONS                    |
| A4.1 | ADU BUILDING SECTIONS                |
| A5.0 | INTERIOR ELEVATIONS                  |
| A5.1 | INTERIOR ELEVATIONS                  |
| E1.0 | FIRST FLOOR - ELECTRICAL PLAN        |
| E1.2 | SECOND FLOOR - ELECTRICAL PLAN       |

## PROJECT INFORMATION

### OWNER:

name

address

location of project

### PROJECT SUMMARY

## DESIGN PROFESSIONAL

### Architect

ELEMENT 5 ARCHITECTURE  
2124 E. 6th Street, Ste. 106  
Austin, TX 78702  
Project Architect - Jay Bolsega, AIA  
(512) 473. 8228

### Structural Engineer

5.5.22 PERMIT SET



**ELEMENT 5**  
ARCHITECTURE

RESIDENTIAL & HOSPITALITY  
ARCHITECTURE & PLANNING

1212 Chicon Street  
Ste. 101  
Austin, TX 78702  
(512) 473. 8228 Voice

www.element5architecture.com



## 908 E. 13TH ADDITION & ADU


AUSTIN, TX 78702

## COVER SHEET


**A0.0**

© COPYRIGHT 2008, E5A.  
ALL RIGHTS RESERVED

5/6/2022 10:51:50 AM D:\JAY'S TRANSFERRED DATA FILES\SWEDIE HILL\REVIT\13TH MAIN HOUSE.RVT

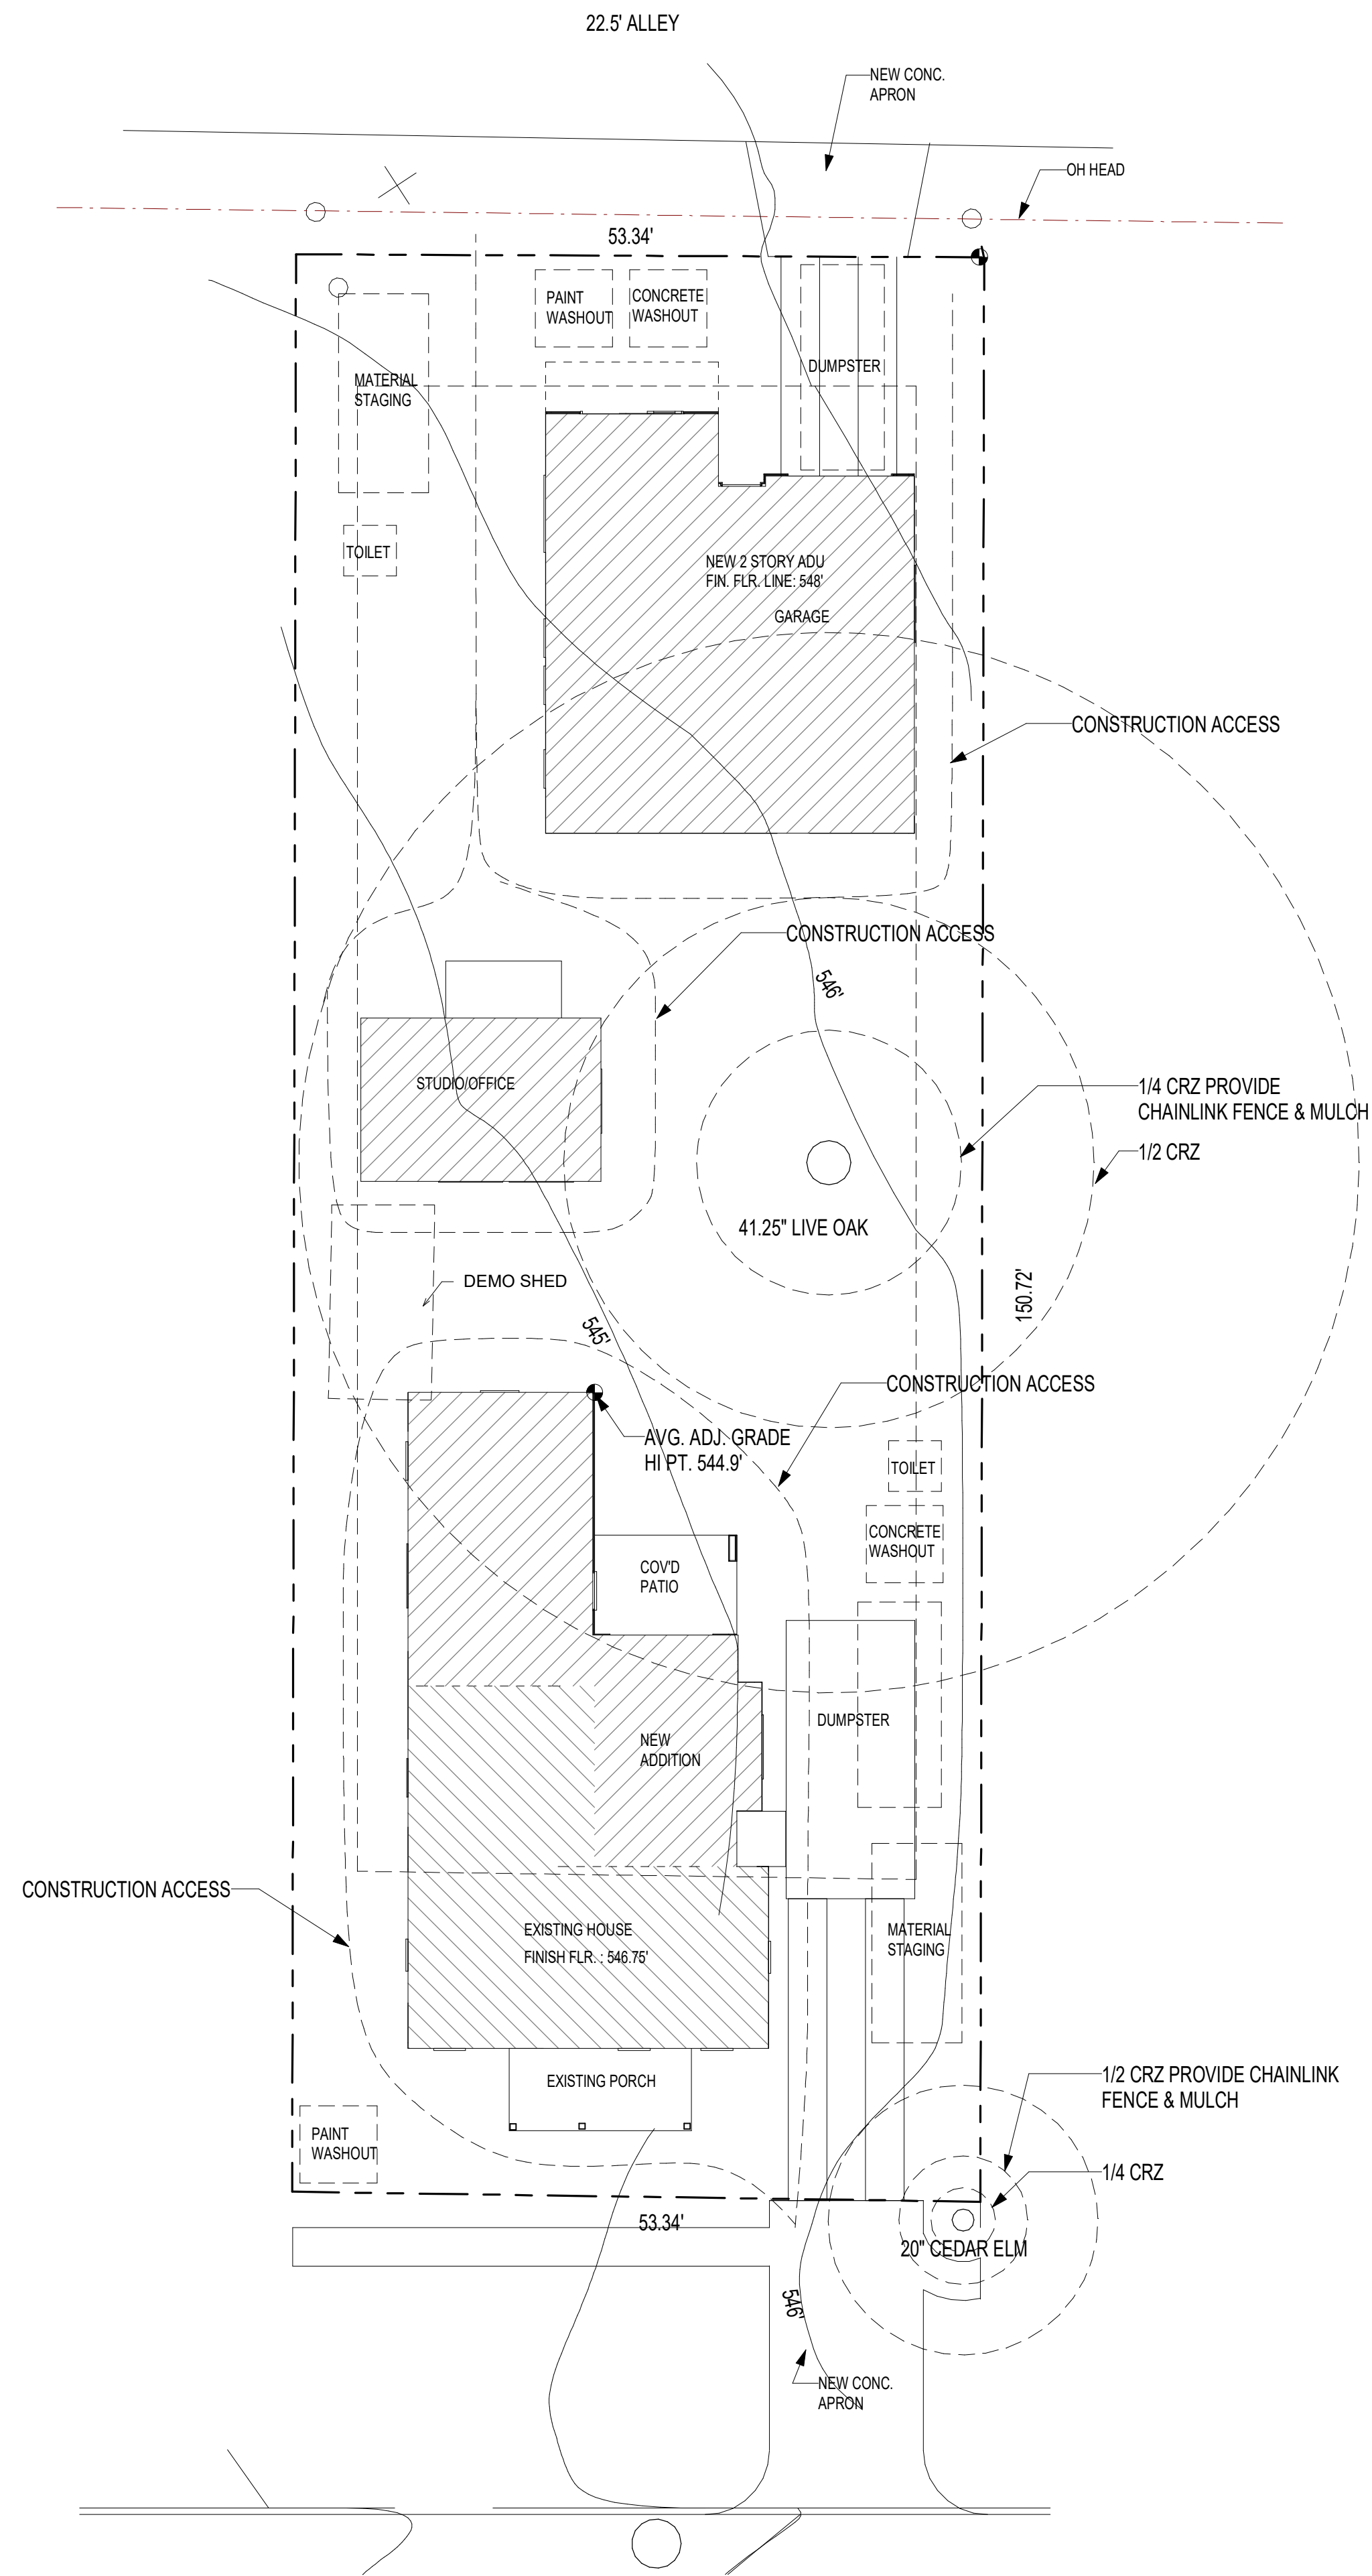


2 CONSTRUCTION PHASING PLAN  
1" = 10'-0"

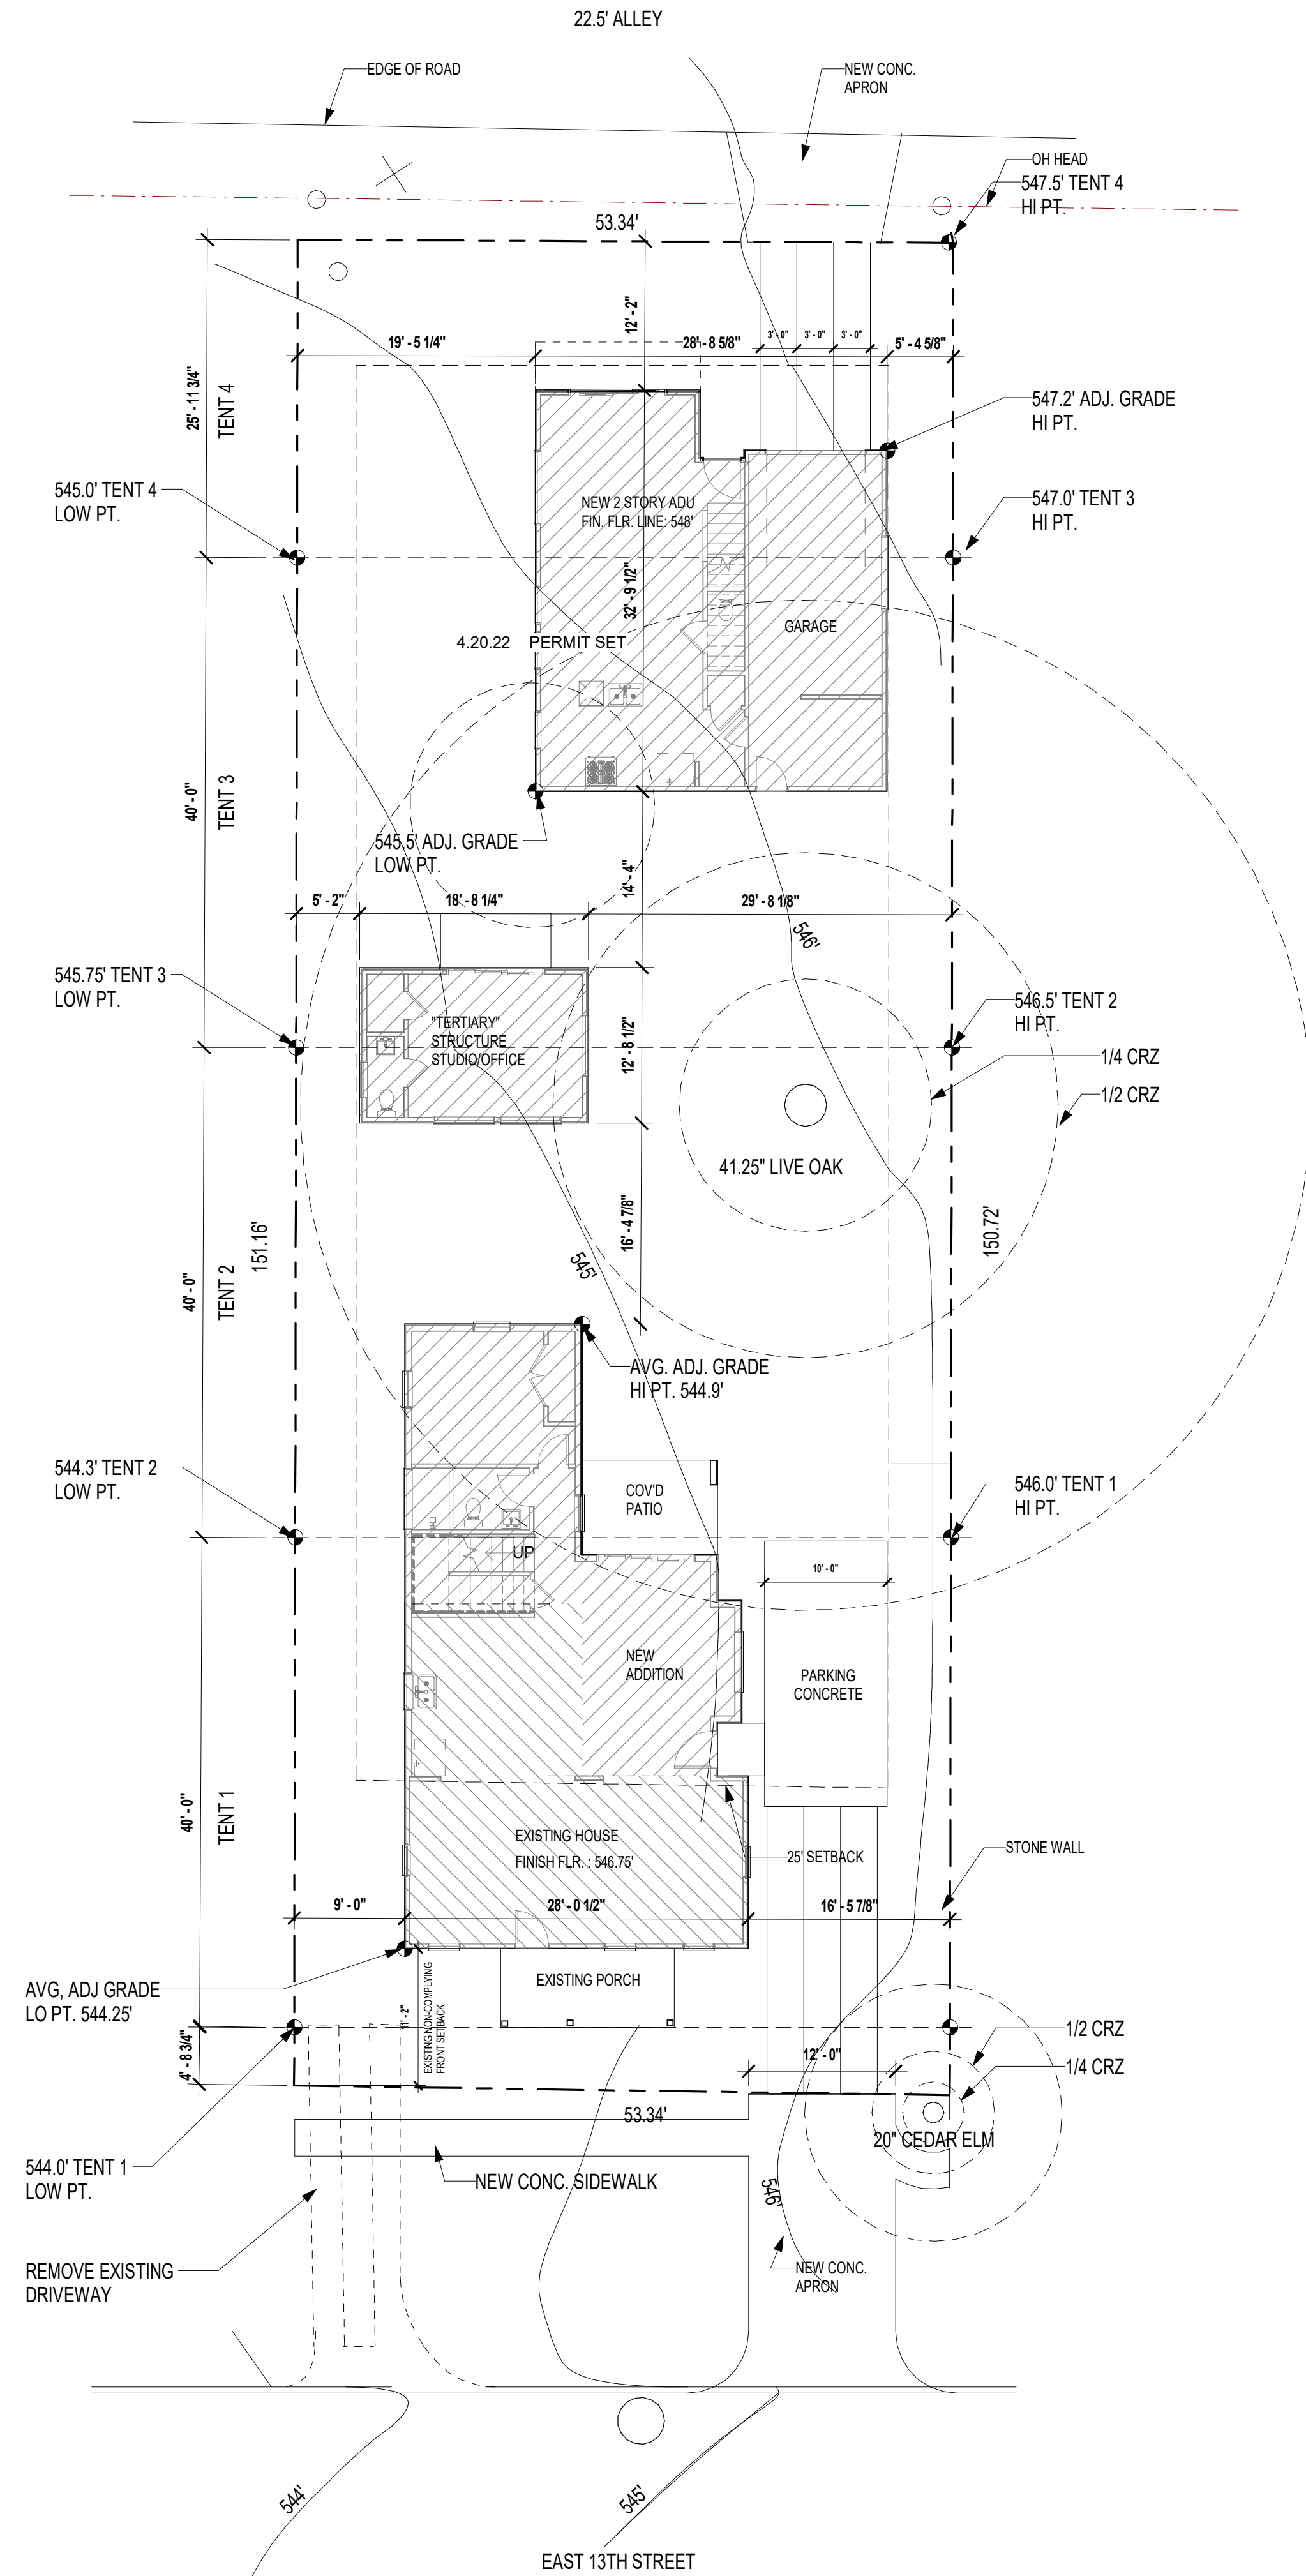

1 SITE / VISITABILITY PLAN  
1" = 10'-0"

|         |            |
|---------|------------|
| 4.22.22 | PERMIT SET |
|         |            |
|         |            |
**E**  
ELEMENT 5  
ARCHITECTURE  
RESIDENTIAL & HOSPITALITY  
ARCHITECTURE & PLANNING  
1212 Chicon Street  
Ste. 101  
Austin, TX 78702  
(512) 473. 8228 Voice  
www.element5architecture.com

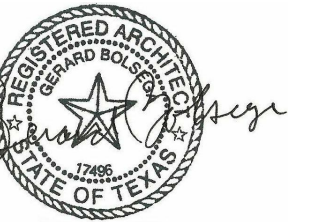


908 E. 13TH  
ADDITION &  
ADU  
AUSTIN, TX 78702

SITE PLAN


A1.0

© COPYRIGHT 2009, E5A.  
ALL RIGHTS RESERVED


5/6/2022 10:51:51 AM D:\JAY'S TRANSFERRED DATA FILES\SWEDIE HILL REVIT\13TH MAIN HOUSE.RVT

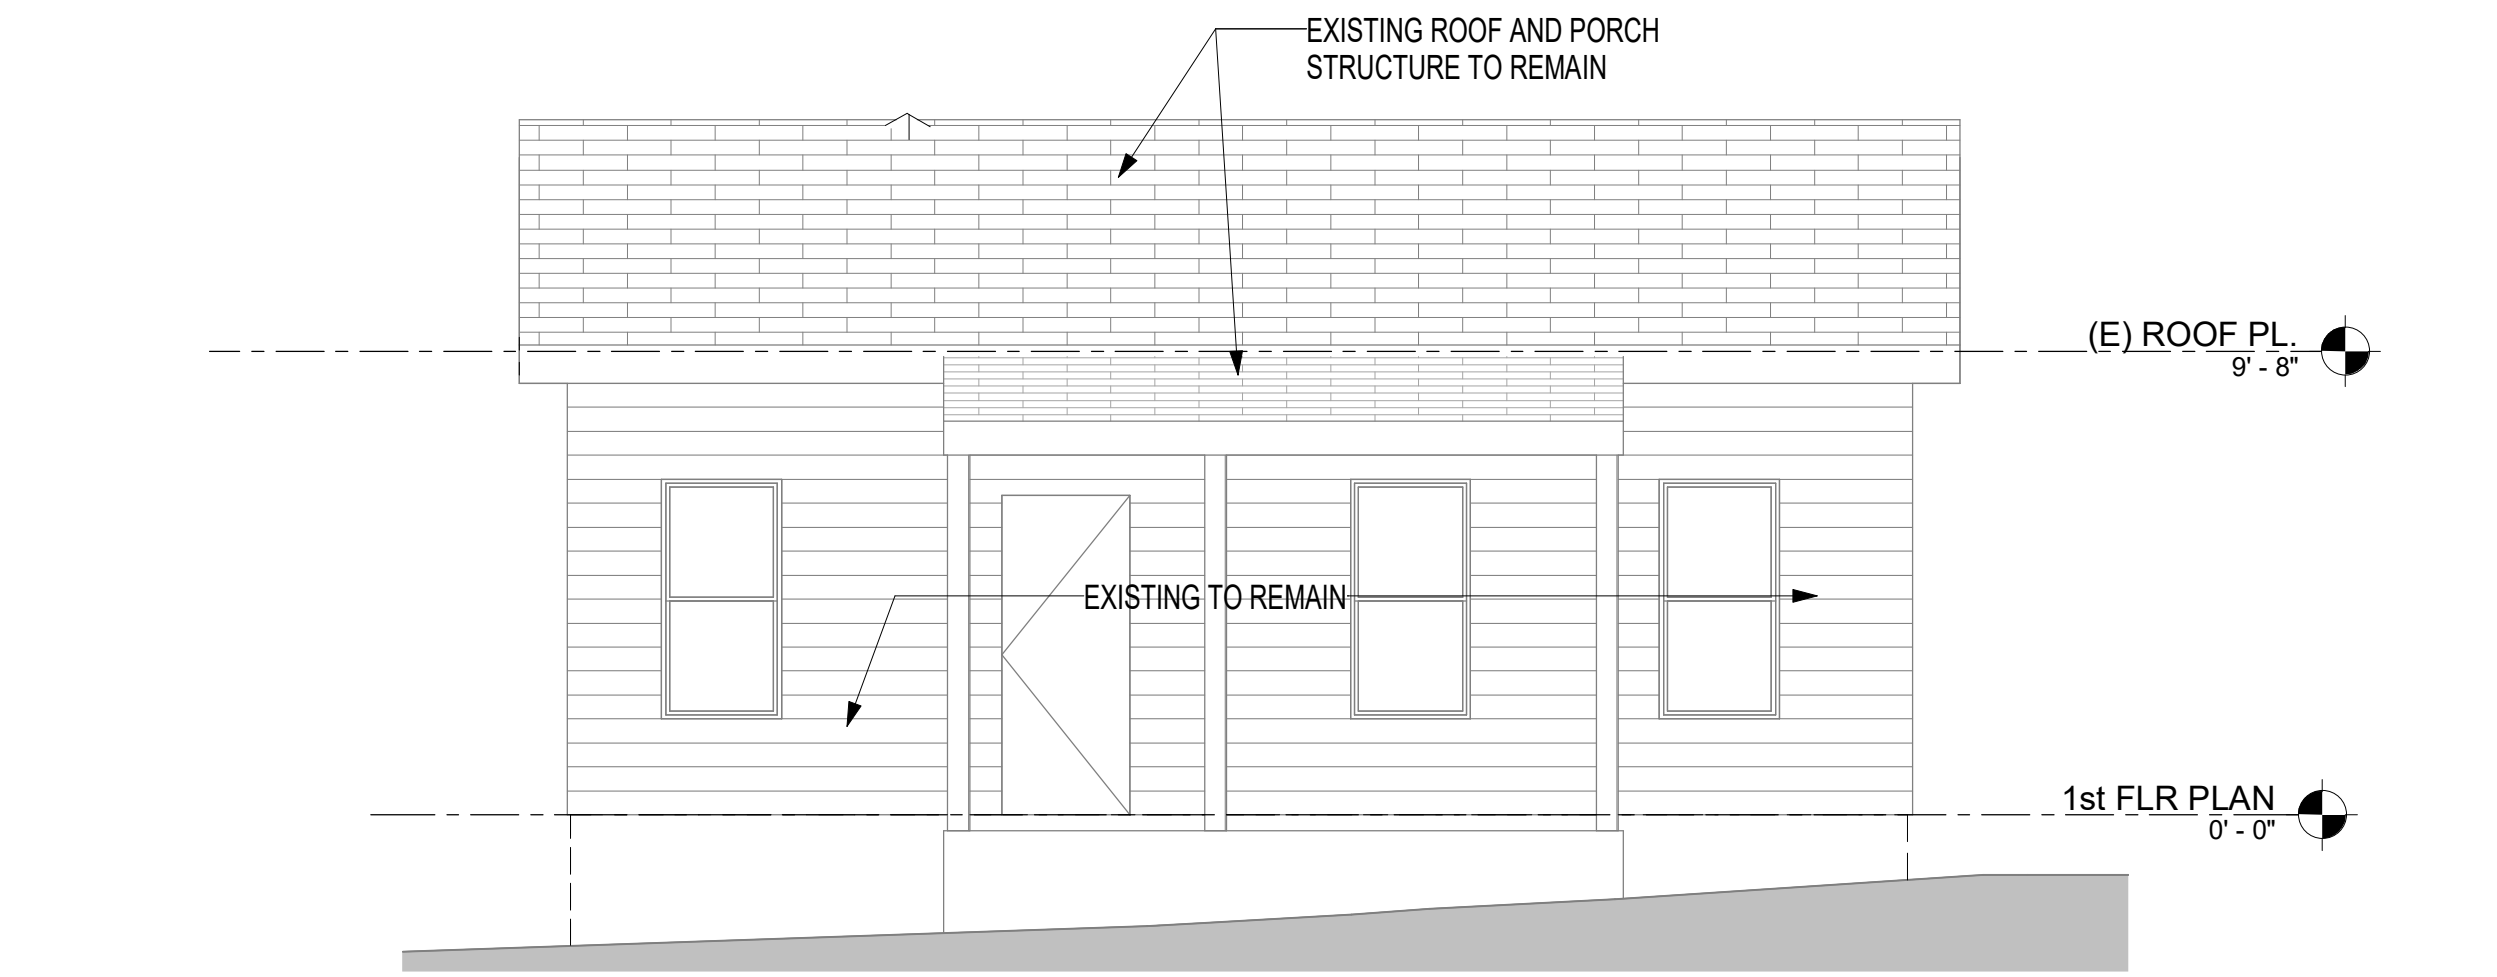


5 DEMO ELEVATION SOUTH  
1/4" = 1'-0"

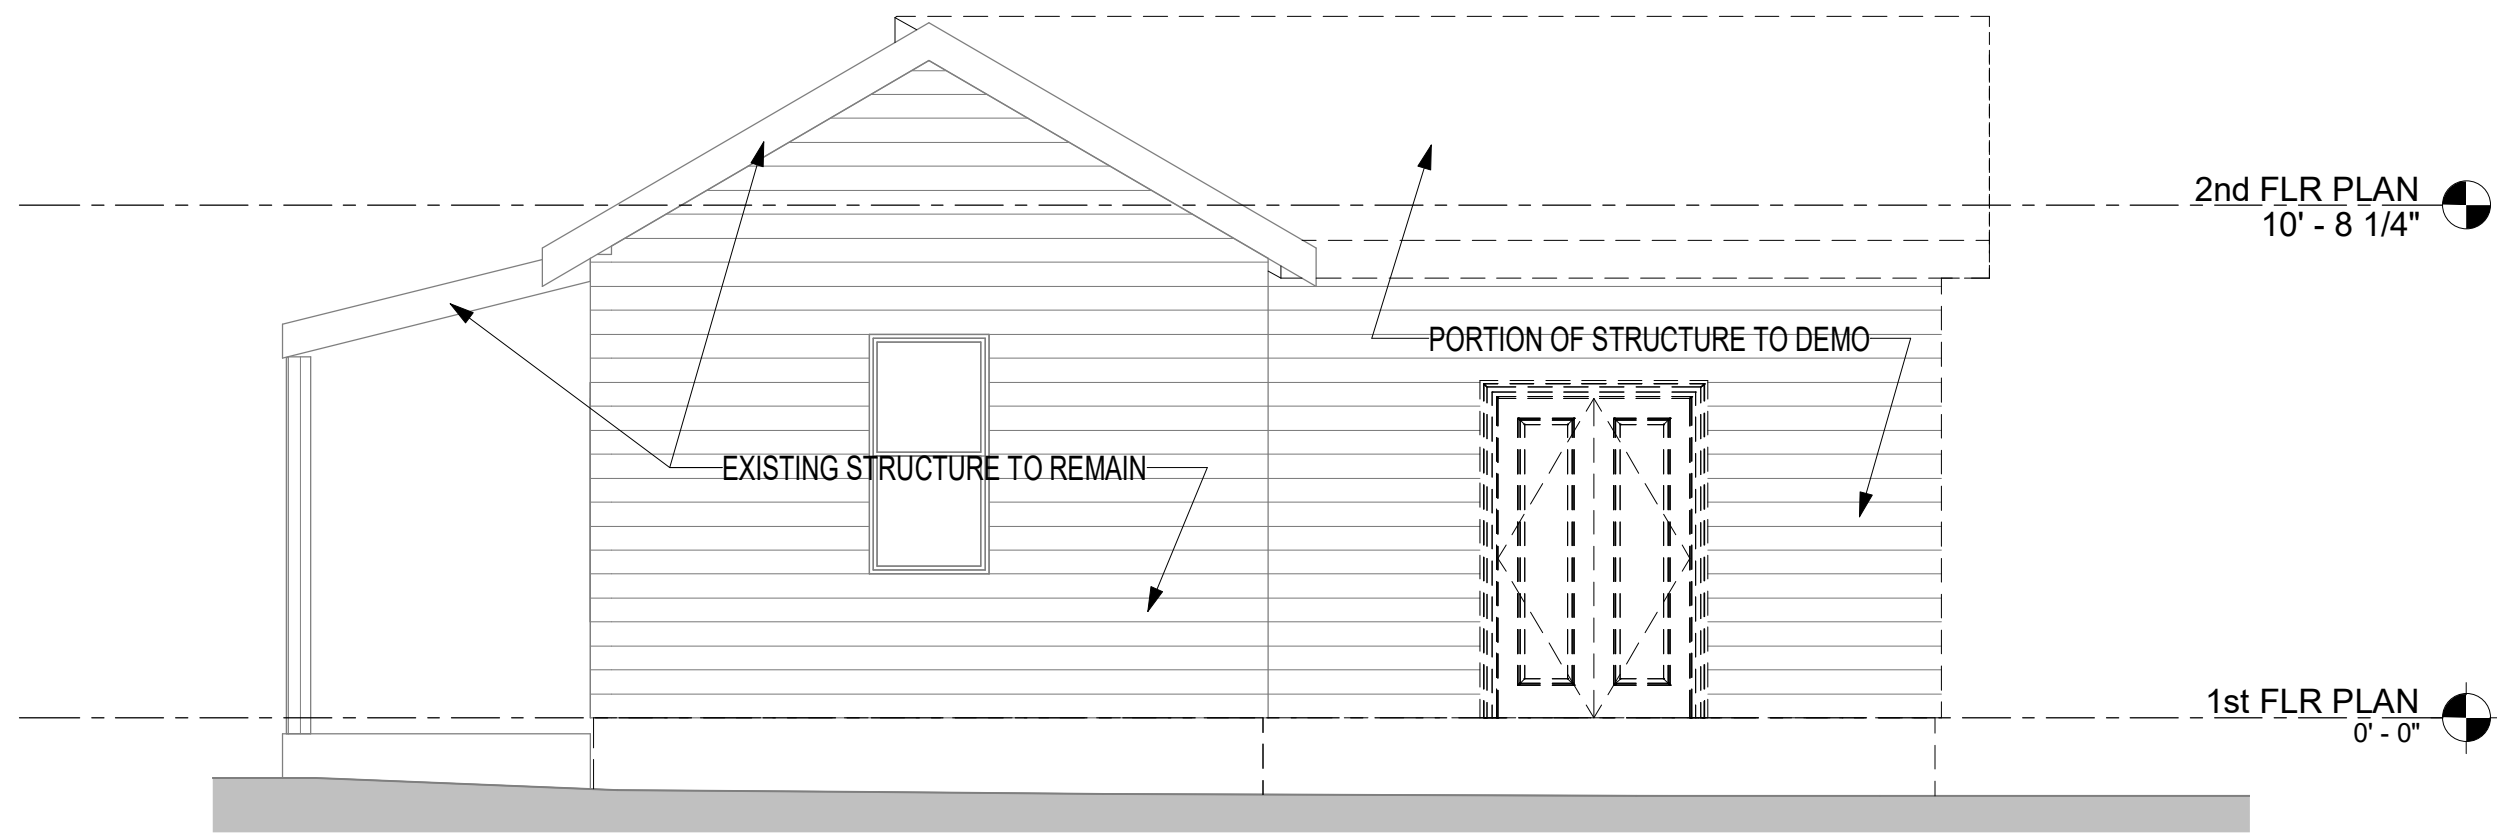


3 DEMO ELEVATION EAST  
1/4" = 1'-0"

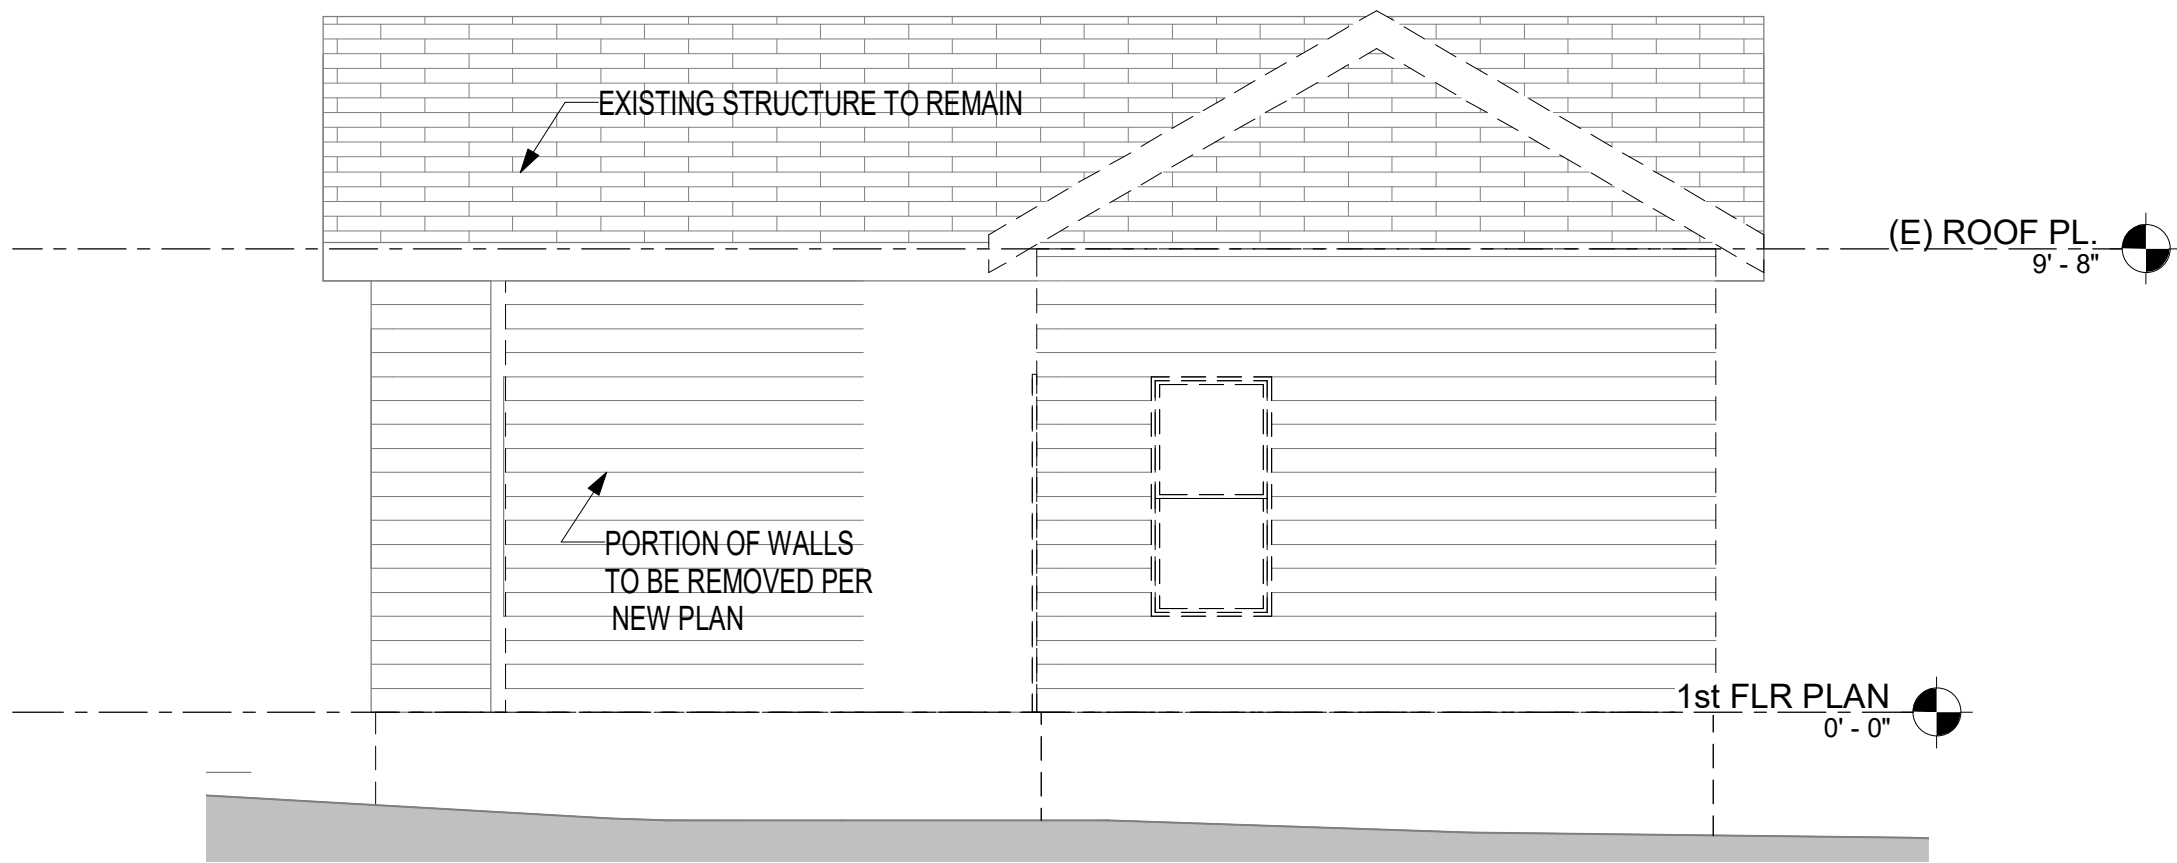


4 DEMO ELEVATION NORTH  
1/4" = 1'-0"

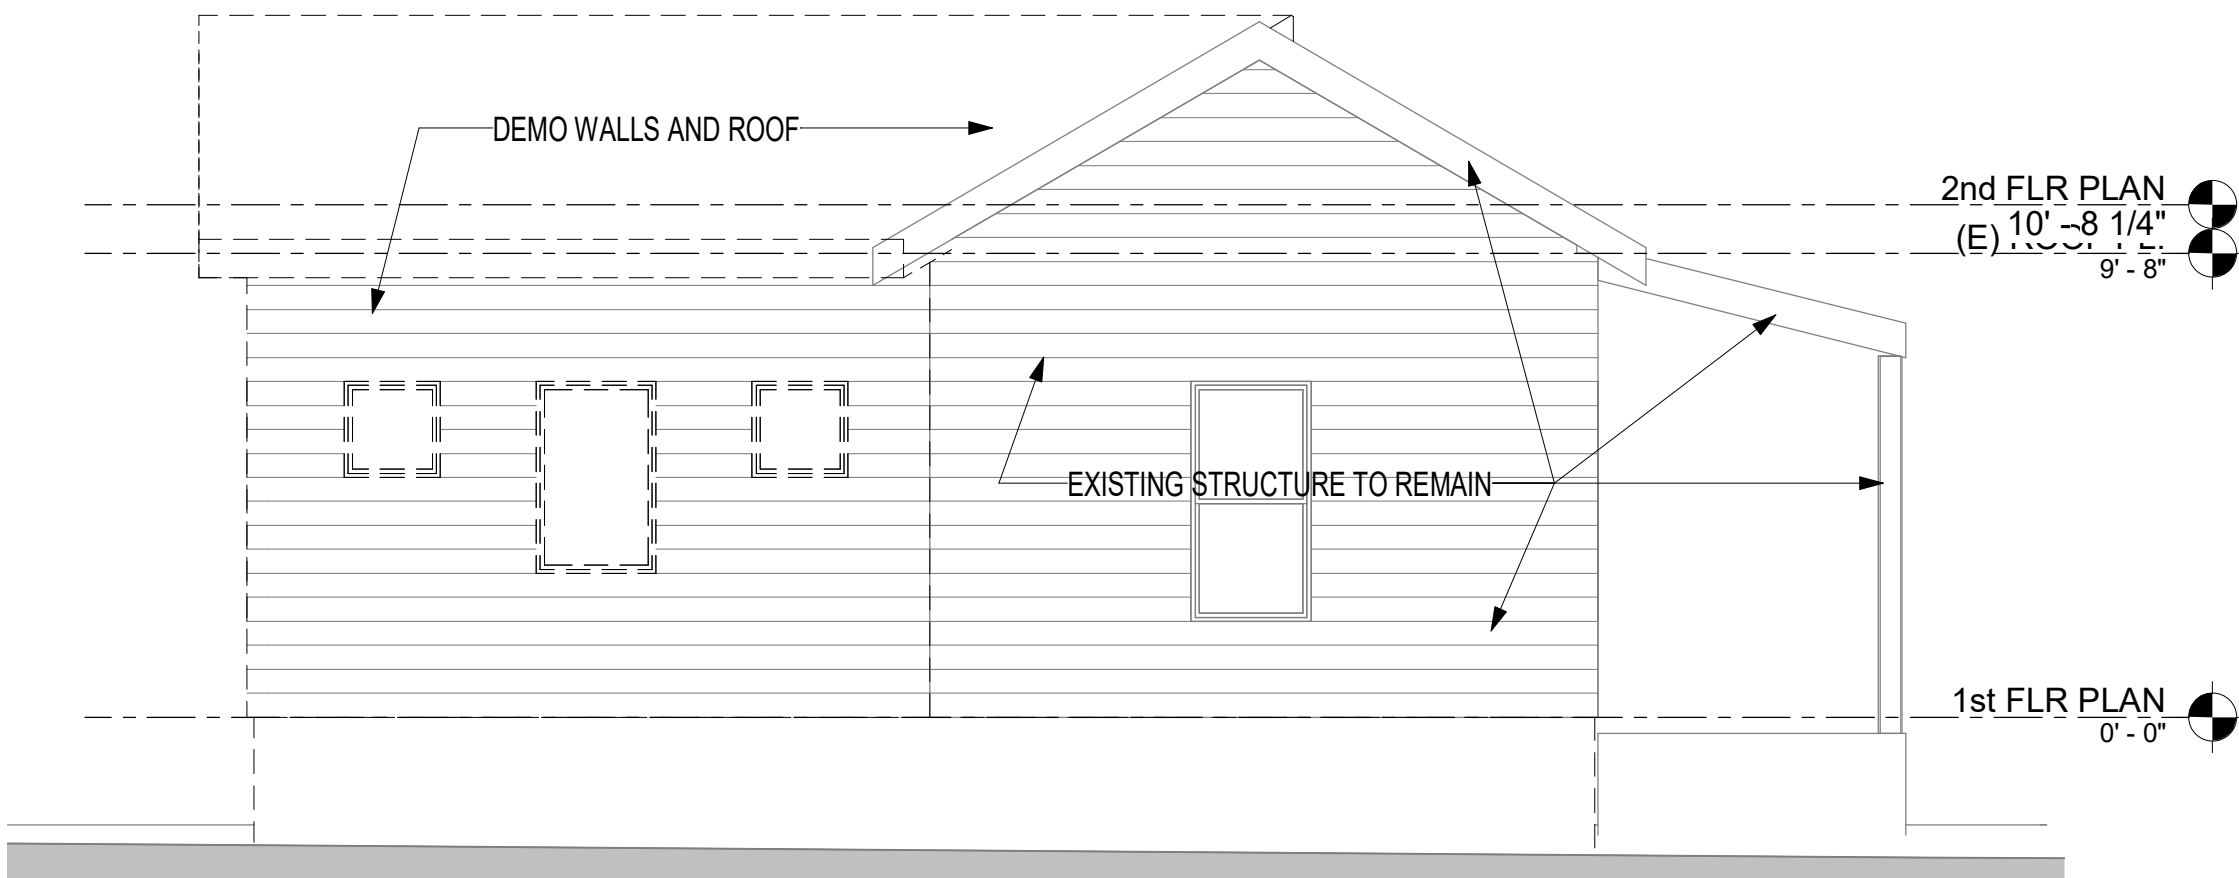

6 DEMO ELEVATION WEST  
1/4" = 1'-0"

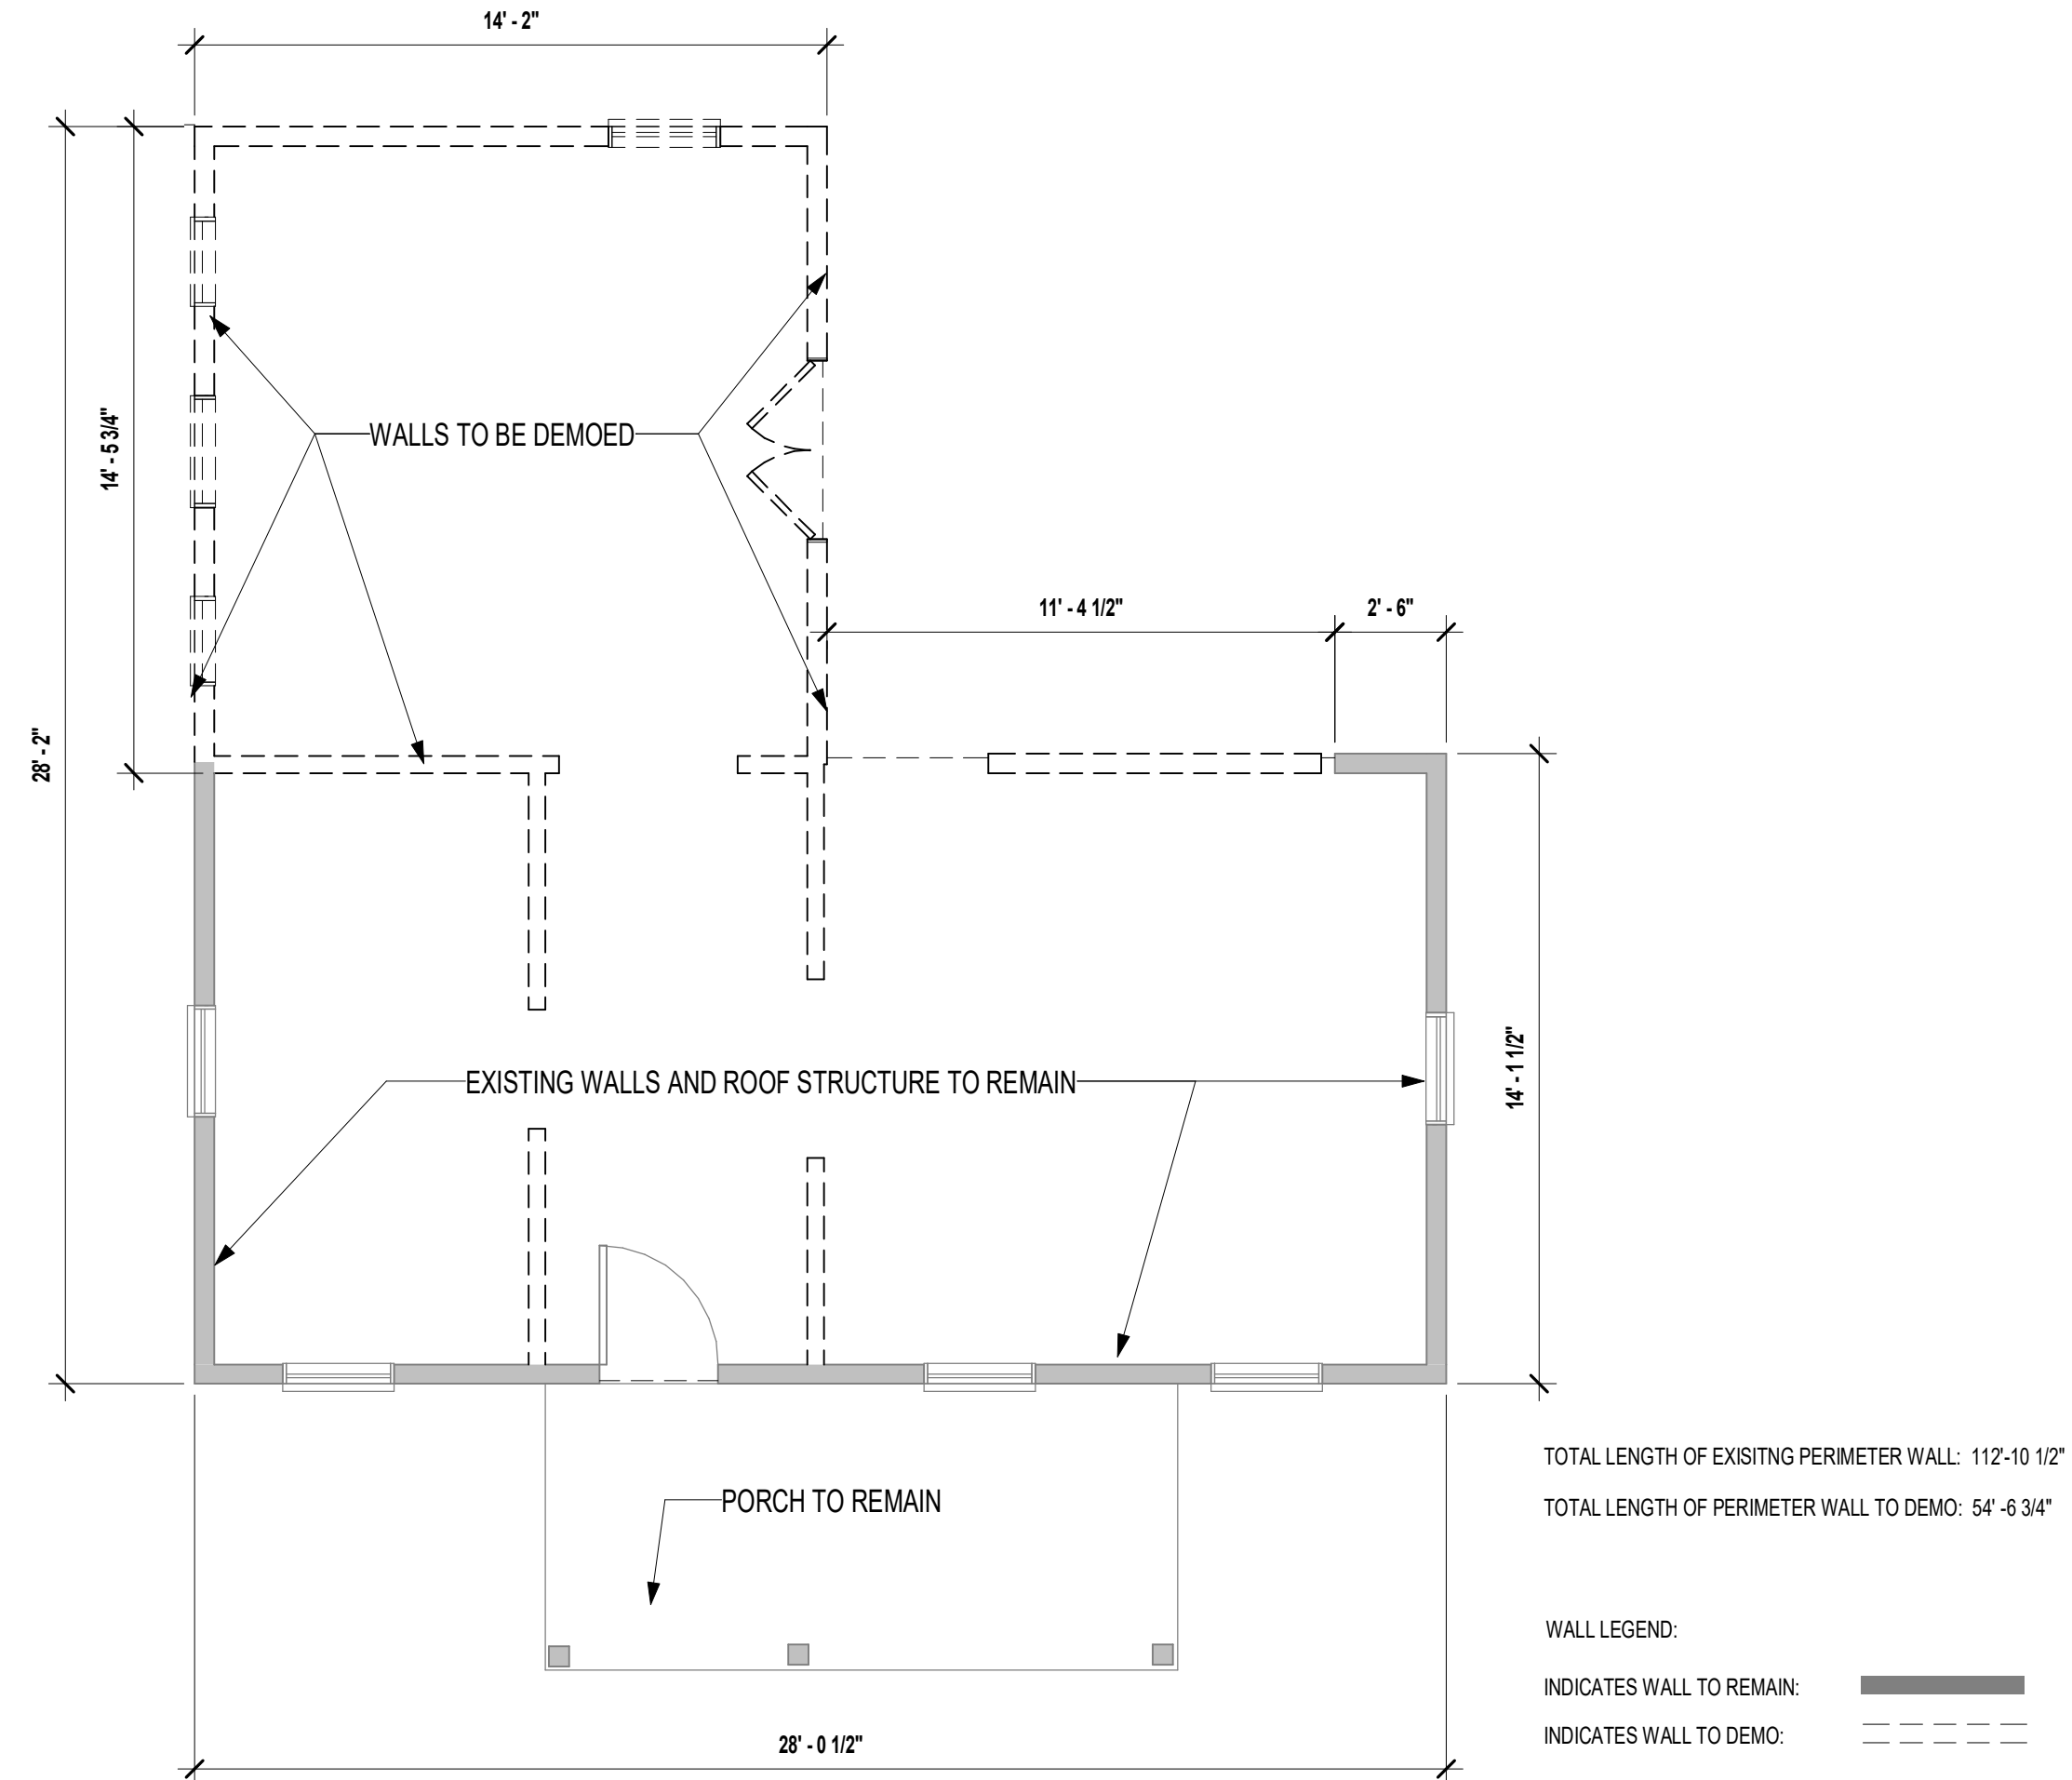

1 FIRST FLOOR  
1/4" = 1'-0"

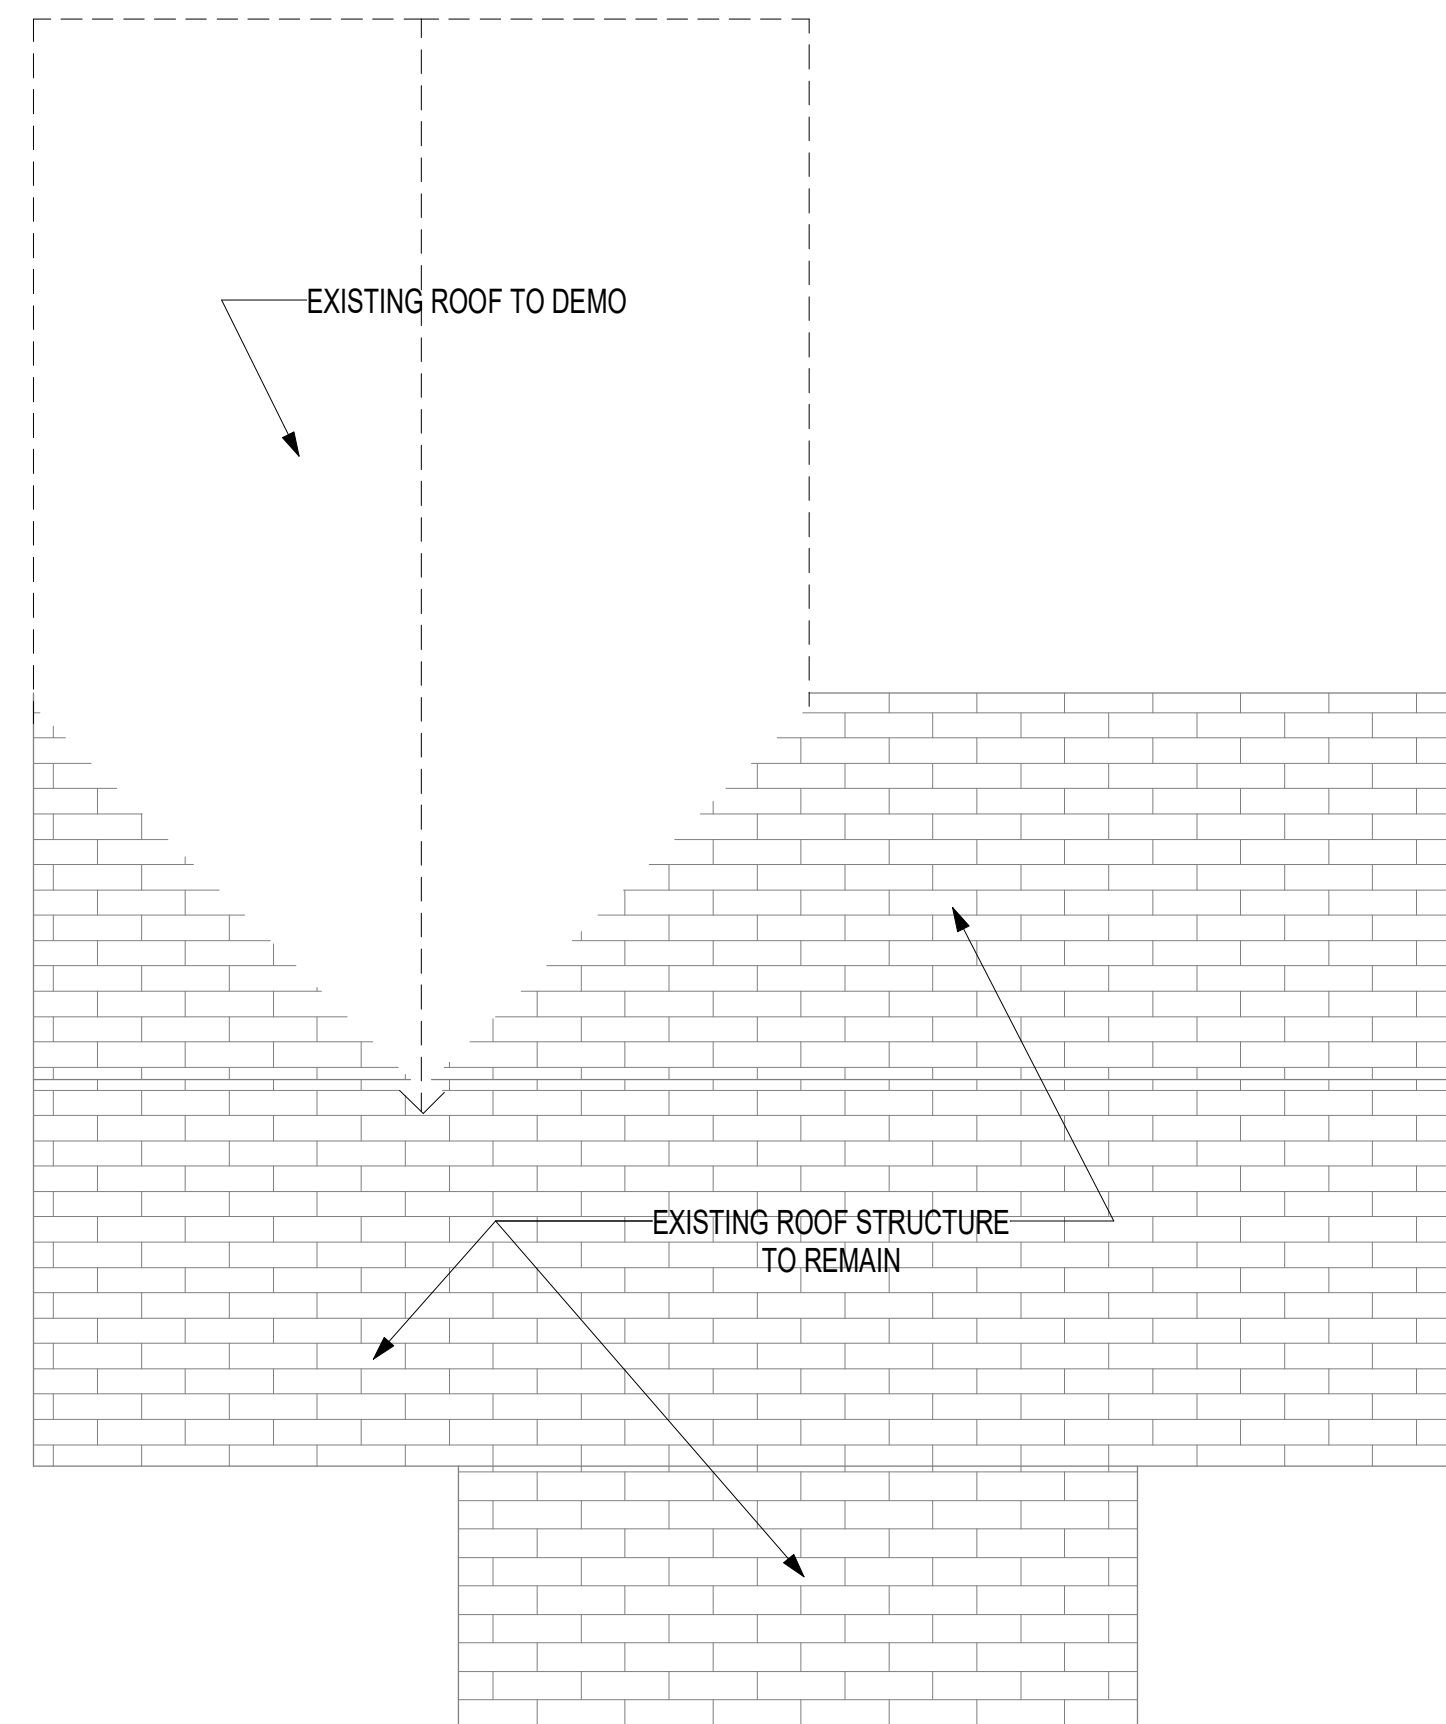

2 FIRST FLOOR  
1/4" = 1'-0"

|        |            |
|--------|------------|
| 5.5.22 | PERMIT SET |
|        |            |
|        |            |
ELEMENT 5  
ARCHITECTURE

RESIDENTIAL & HOSPITALITY  
ARCHITECTURE & PLANNING

1212 Chicon Street  
Ste. 101  
Austin, TX 78702  
(512) 473. 8228 Voice

www.element5architecture.com

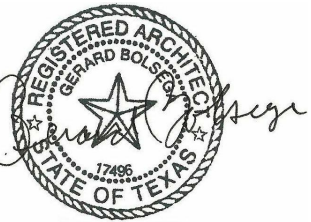

908 E. 13TH  
ADDITION &  
ADU

AUSTIN, TX 78702



DEMO PLANS

A1.1

© COPYRIGHT 2009, E5A.  
ALL RIGHTS RESERVED



5/6/2022 10:51:55 AM D:\JAY'S TRANSFERED DATA FILES\SWED HILL REVIT\E13TH MAIN HOUSE.RVT

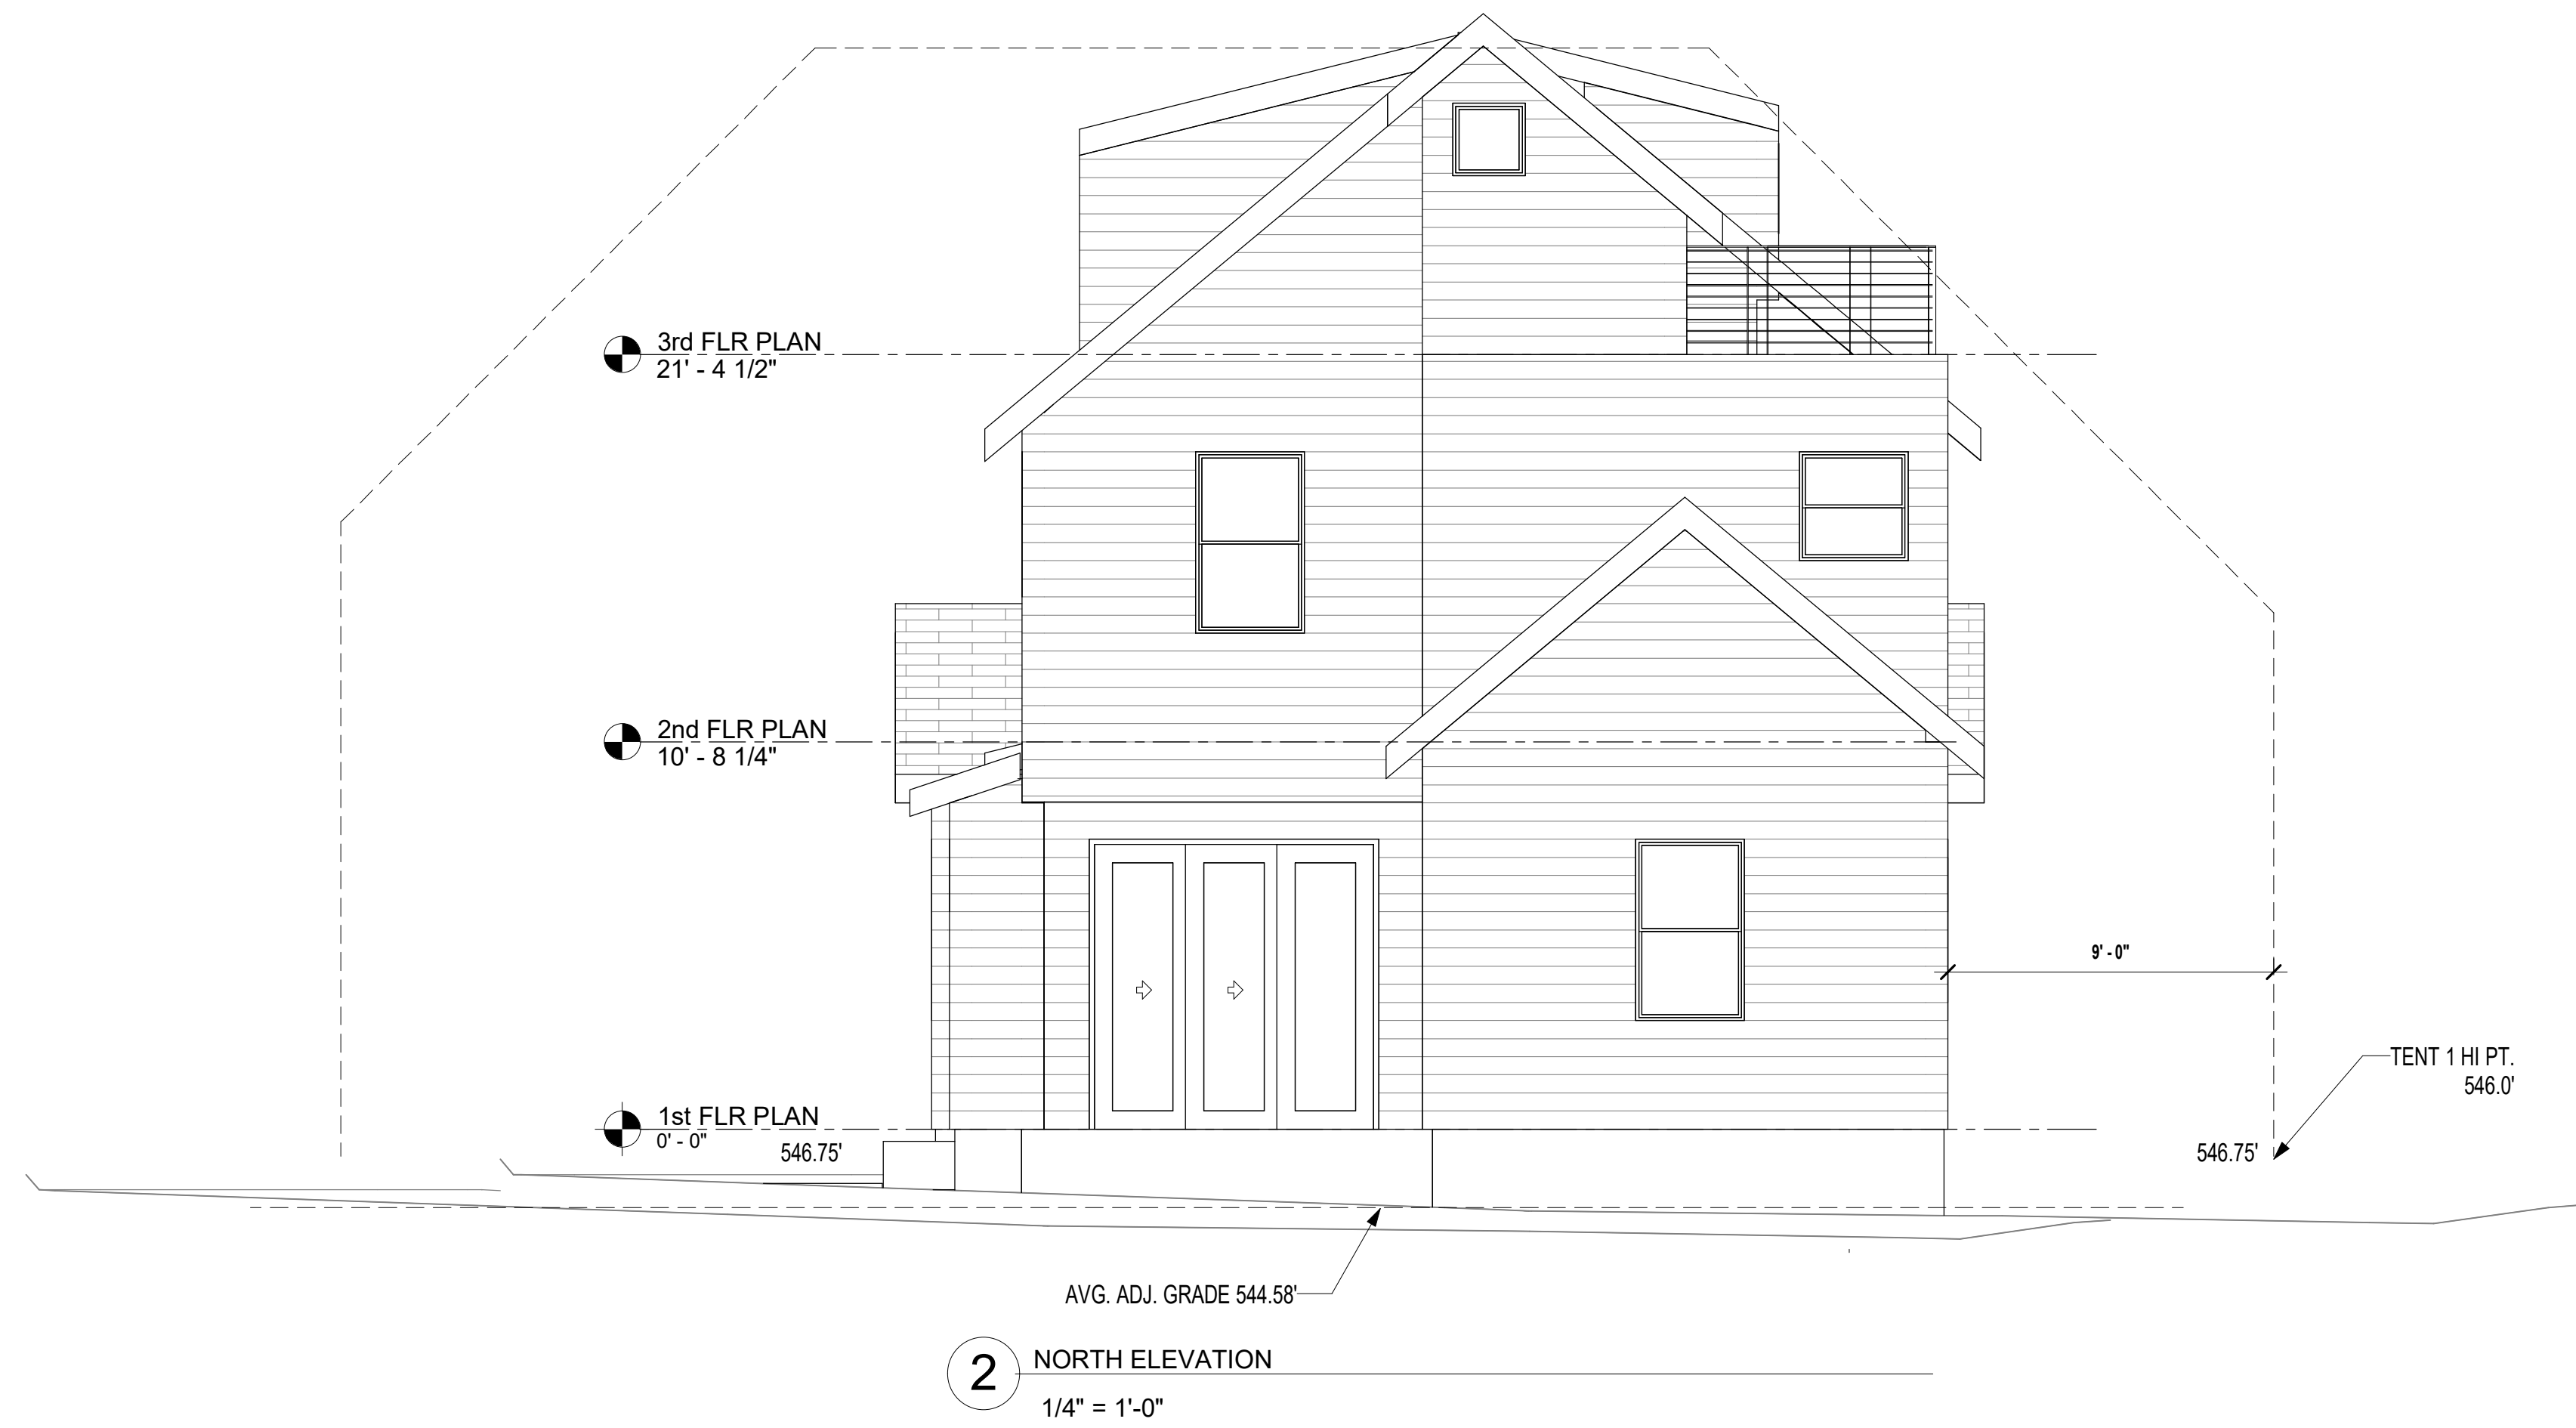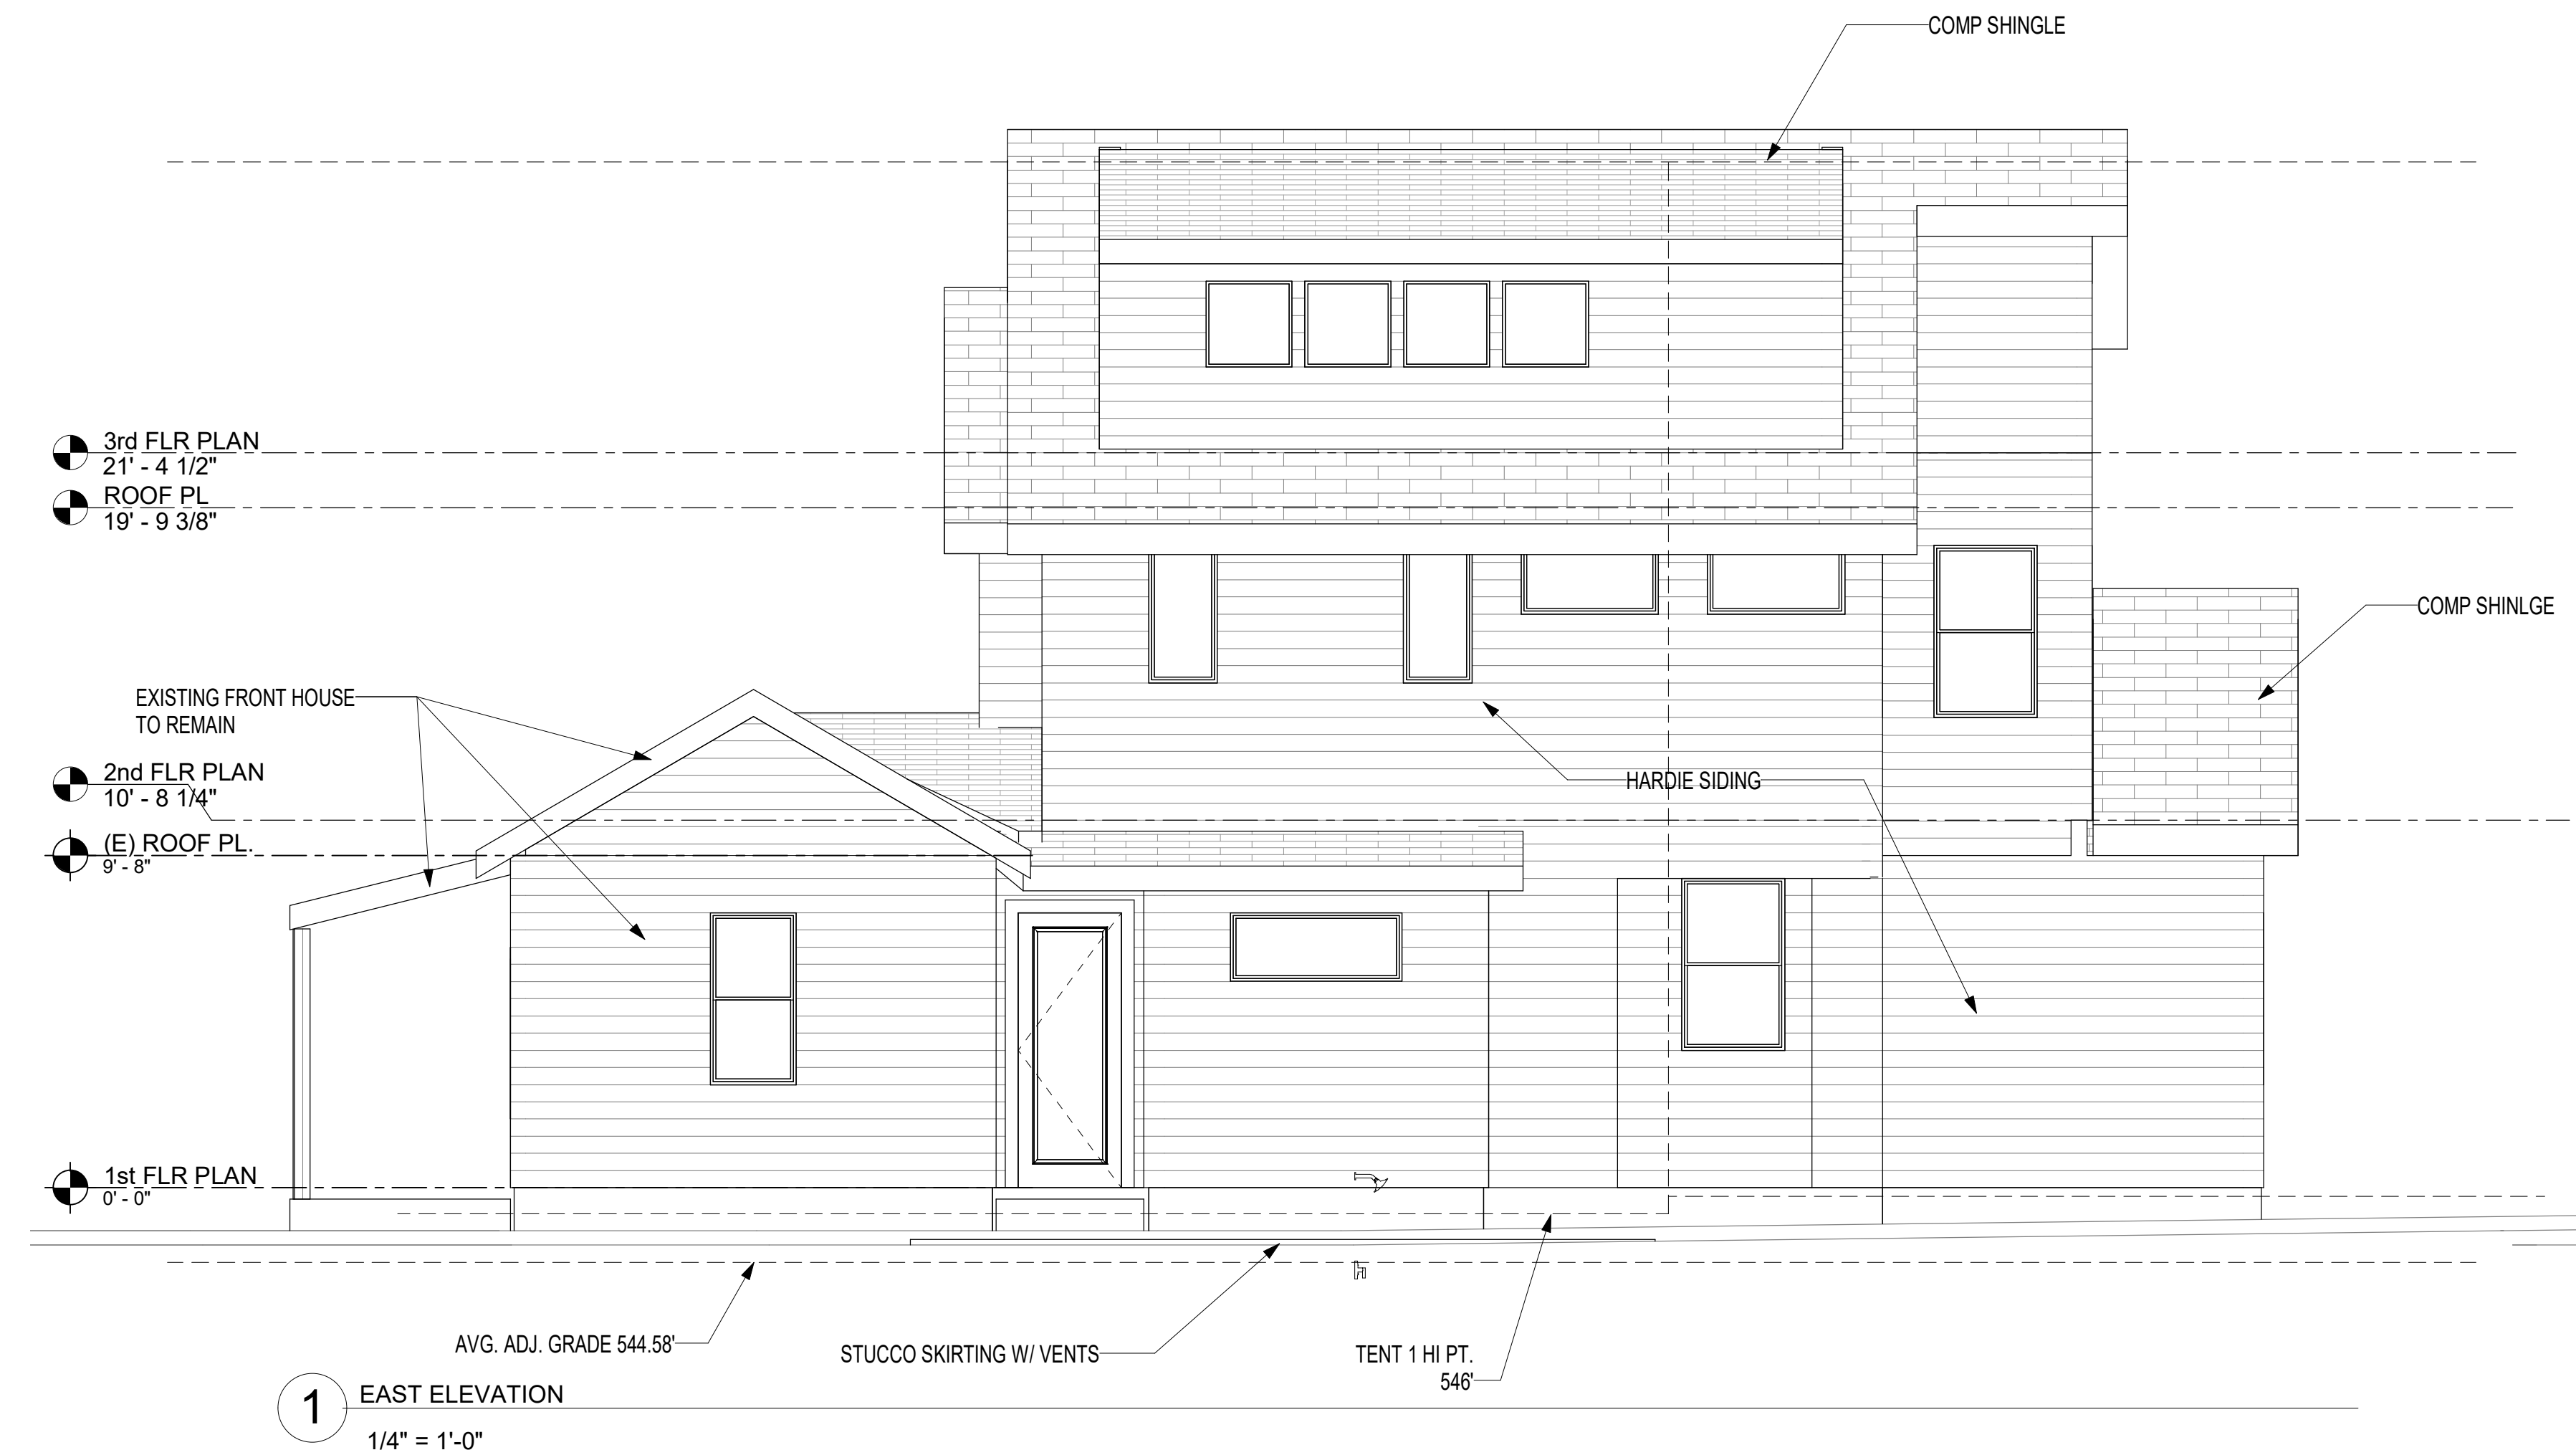

| 5.5.22 | PERMIT SET |
|--------|------------|
|        |            |
|        |            |
**ELEMENT 5**  
ARCHITECTURE

RESIDENTIAL & HOSPITALITY  
ARCHITECTURE & PLANNING

1212 Chicon Street  
Ste. 101  
Austin, TX 78702  
(512) 473. 8228 Voice  
[www.element5architecture.com](http://www.element5architecture.com)



**908 E. 13TH  
ADDITION &  
ADU**

AUSTIN, TX 78702



**EXTERIOR  
ELEVATIONS**

**A3.1**

© COPYRIGHT 2009, E5A.  
ALL RIGHTS RESERVED







South facade



East Facade



North Facade



West Facade