


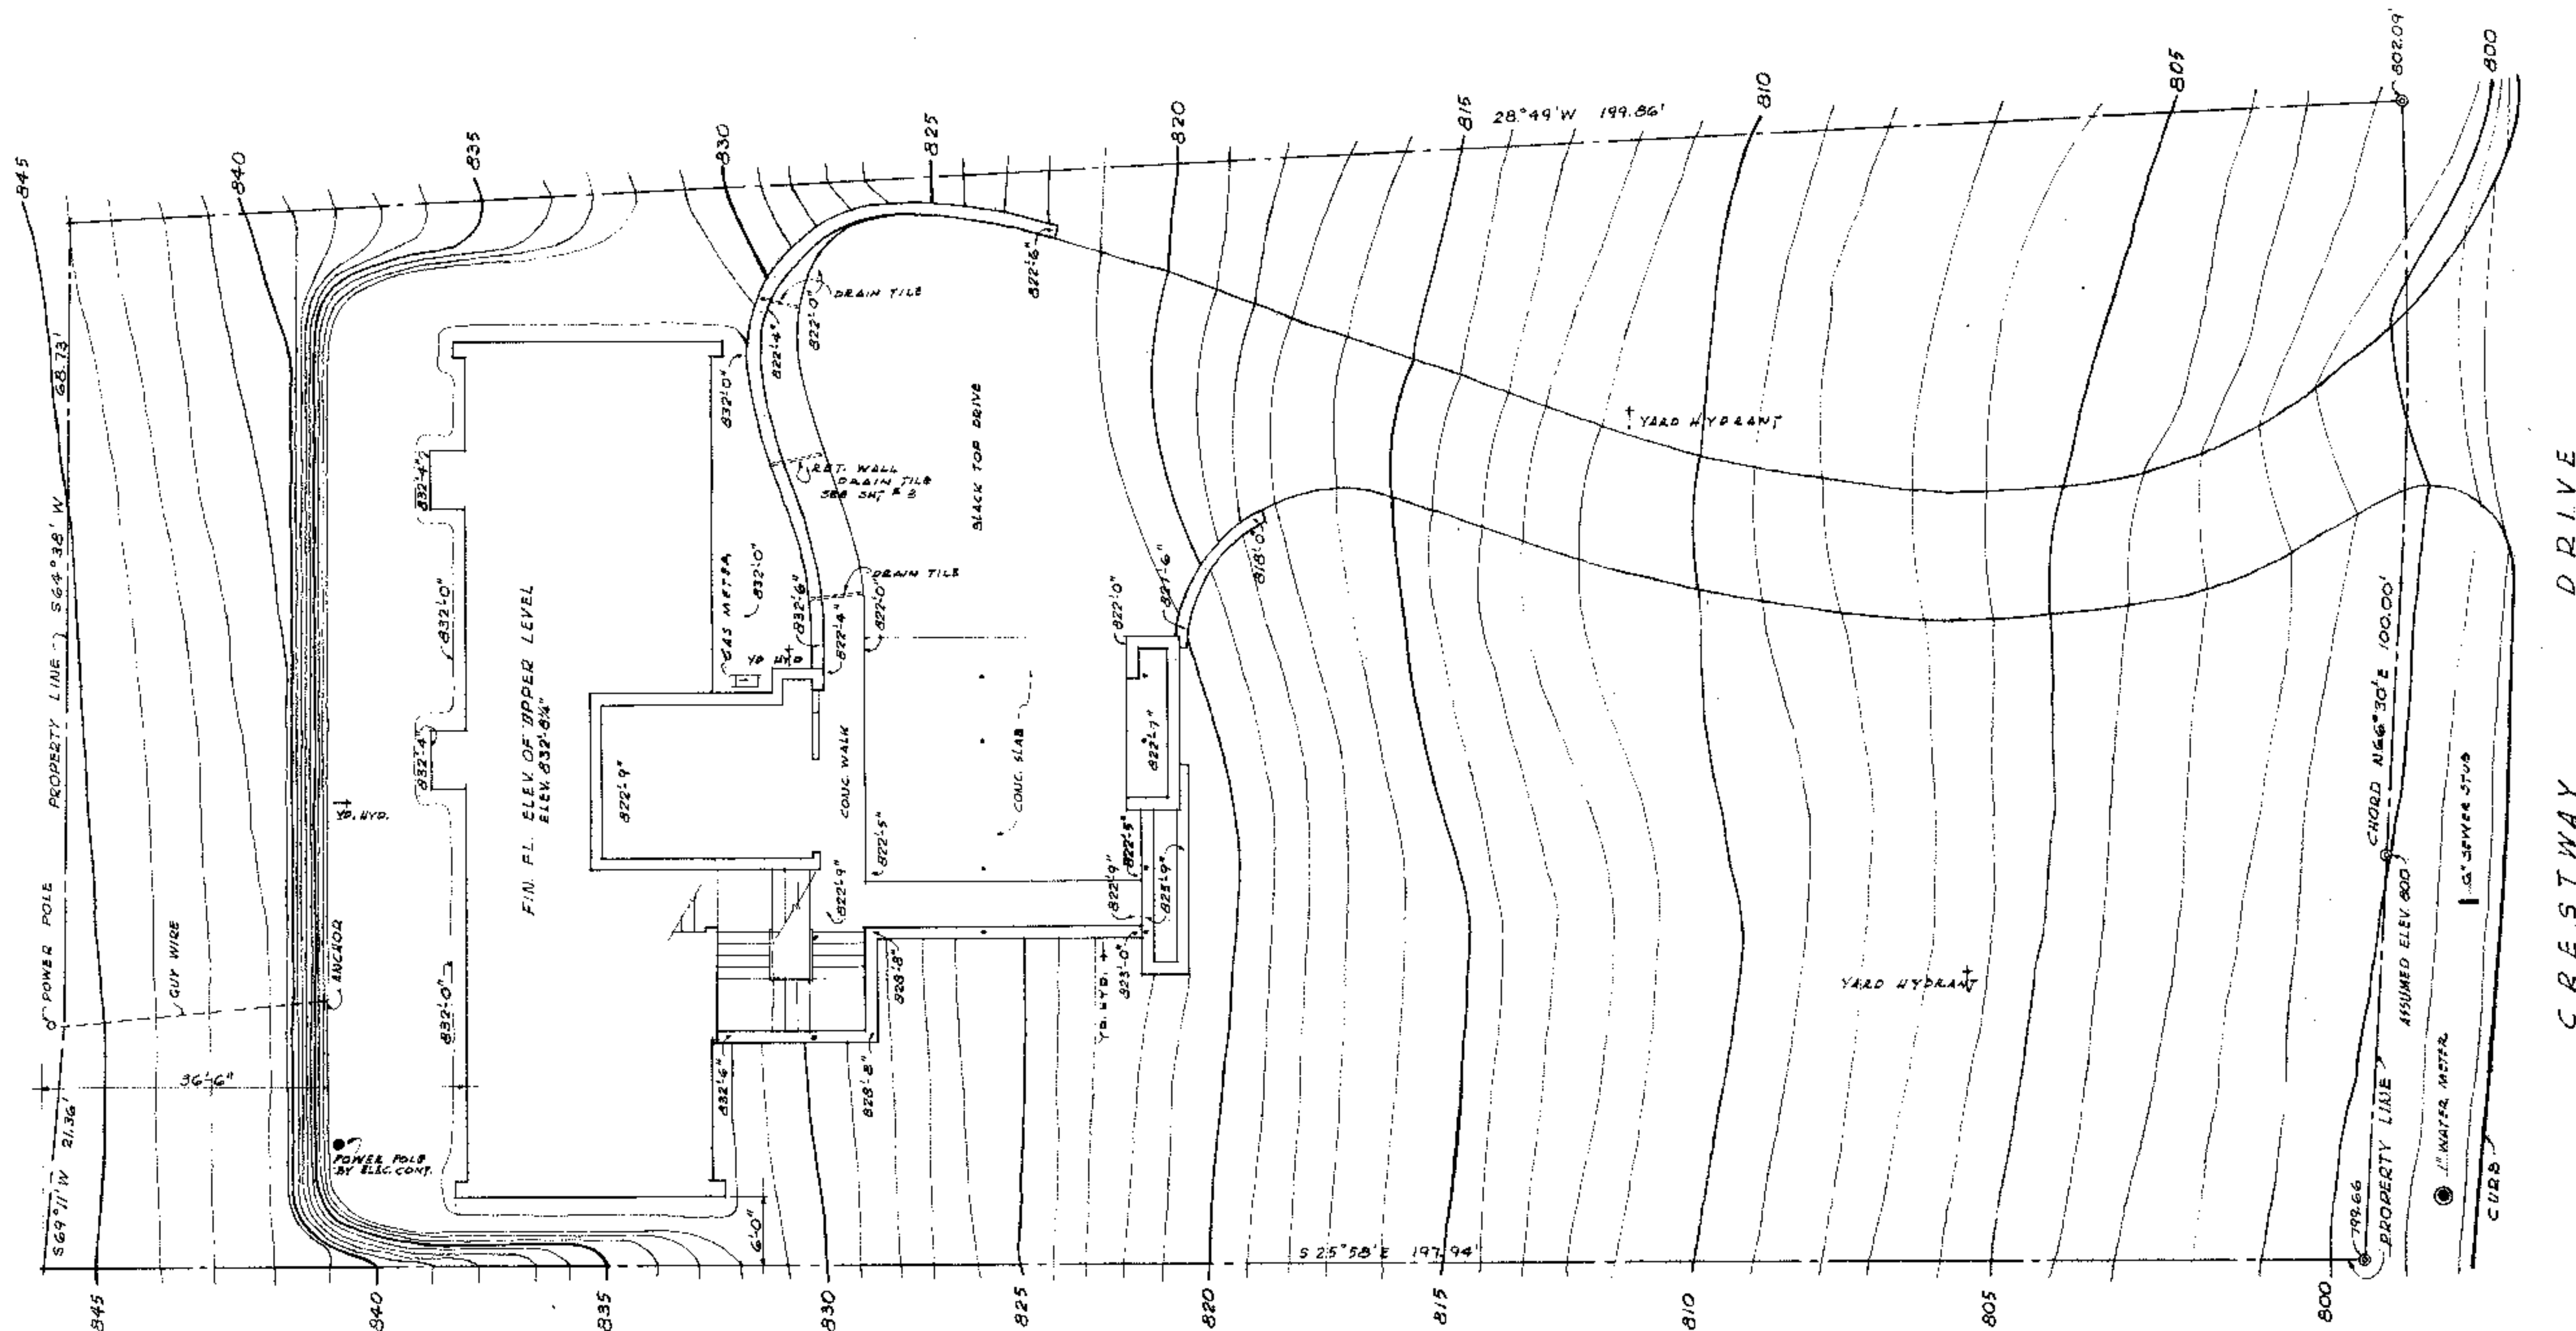

PLOT PLAN

SCALE: 1/8" = 1'-0"

A PORTION OF LOT #3, BLOCK "B"
RESUBDIVIDED HIGHLAND PARK WEST
AUSTIN, TEXAS

SURVEYED DECEMBER 21, 1955
BY OSCAR W. HOLMES
AUSTIN, TEXAS

GENERAL NOTES:

CONTRACTOR SHALL PROTECT ALL GROWTH ON SITE.
BLACKTOP DRIVEWAY TO BE ESTABLISHED & LAYED
OUT AT THE SITE BY OWNER & ARCHITECT.
ELECTRIC POWER IN REAR
GAS LINE IN REAR
TELEPHONE LINE IN REAR










WM. H. HIDEELL, JR.
ARCHITECT
3010 BLACKBURN ST. DALLAS 4, TEXAS
A RESIDENCE FOR
MR. & MRS. R. R. HIDEELL
AUSTIN, TEXAS

JOB NO. DATE DRAWN BY CHECKED BY SHEET NO.
602 9-1-56 A H OF 16




W. H. Hideell, Jr.

SERIAL NO. 2488

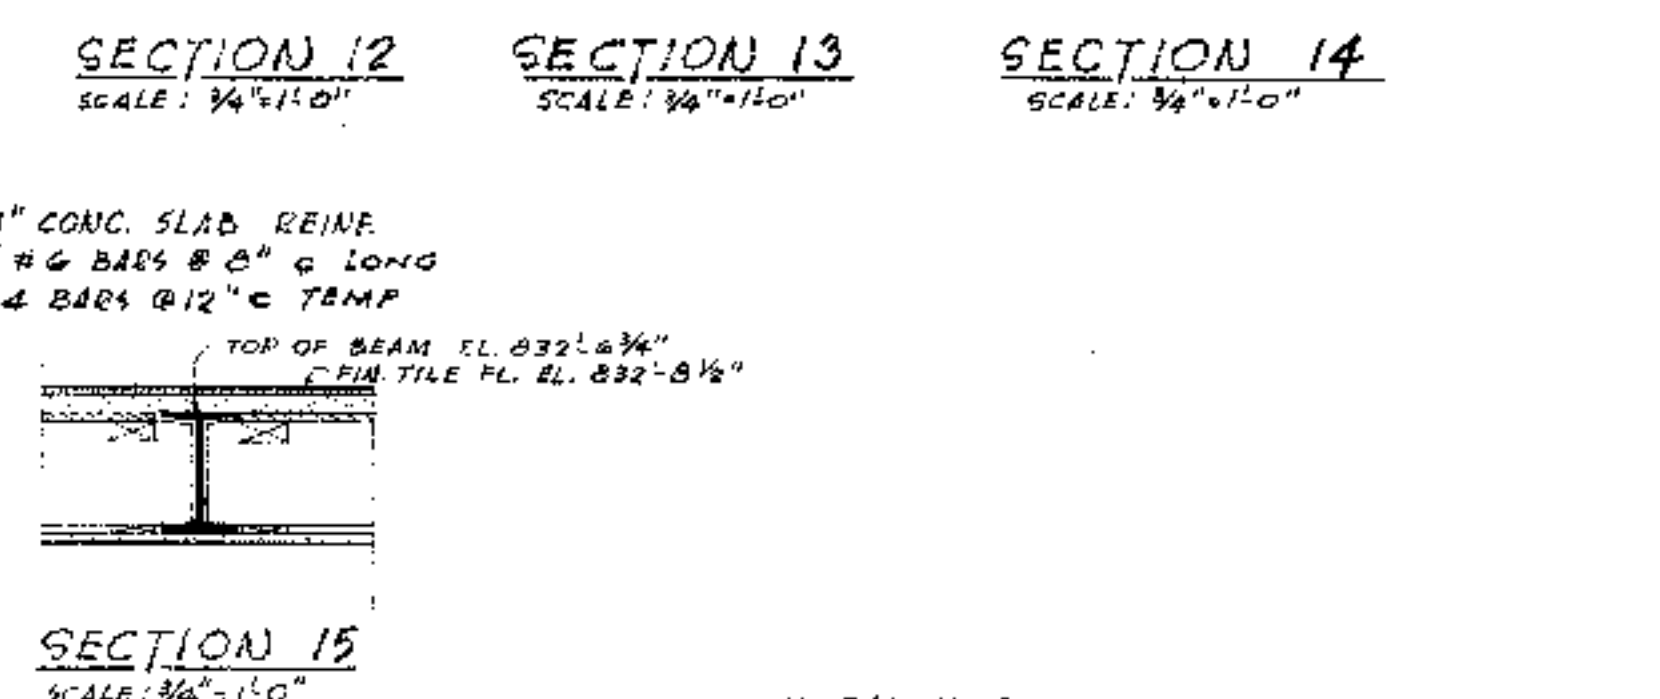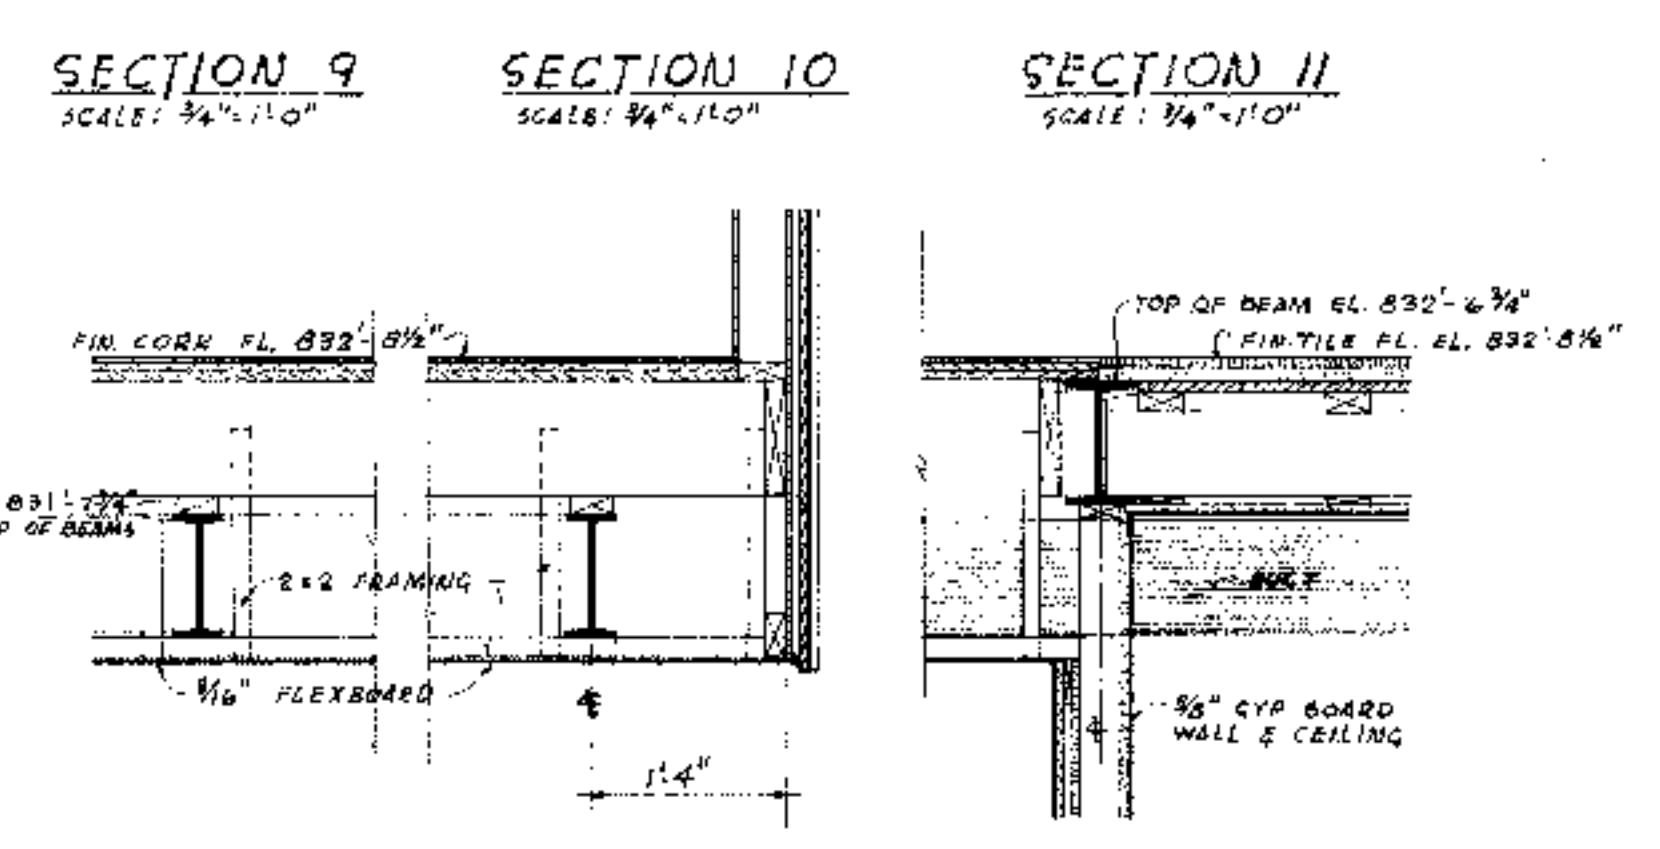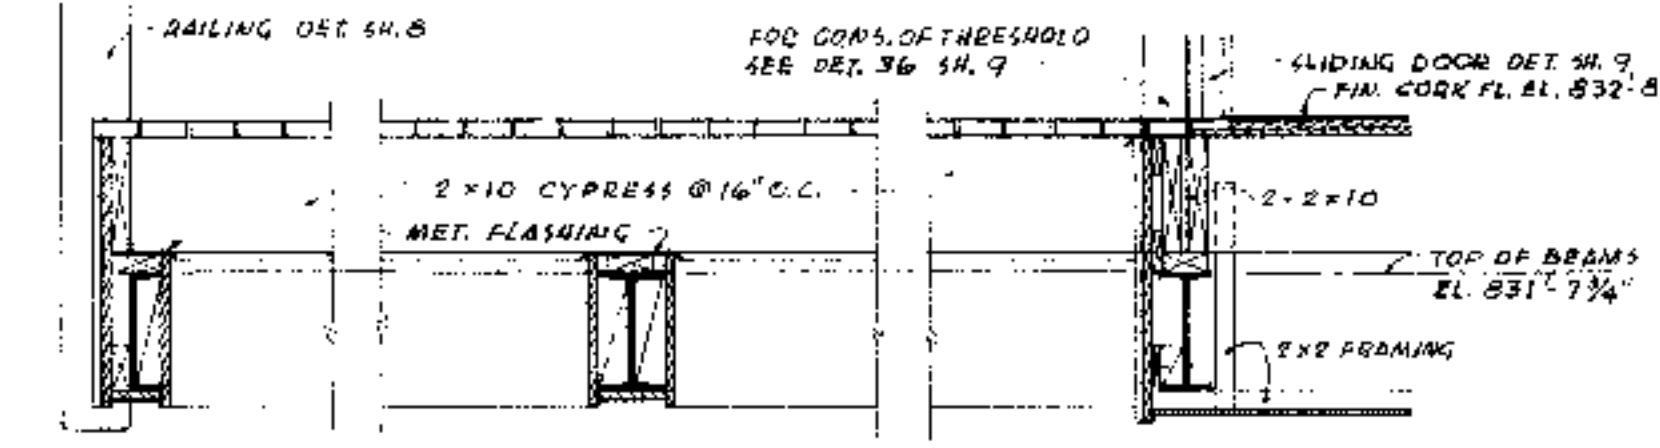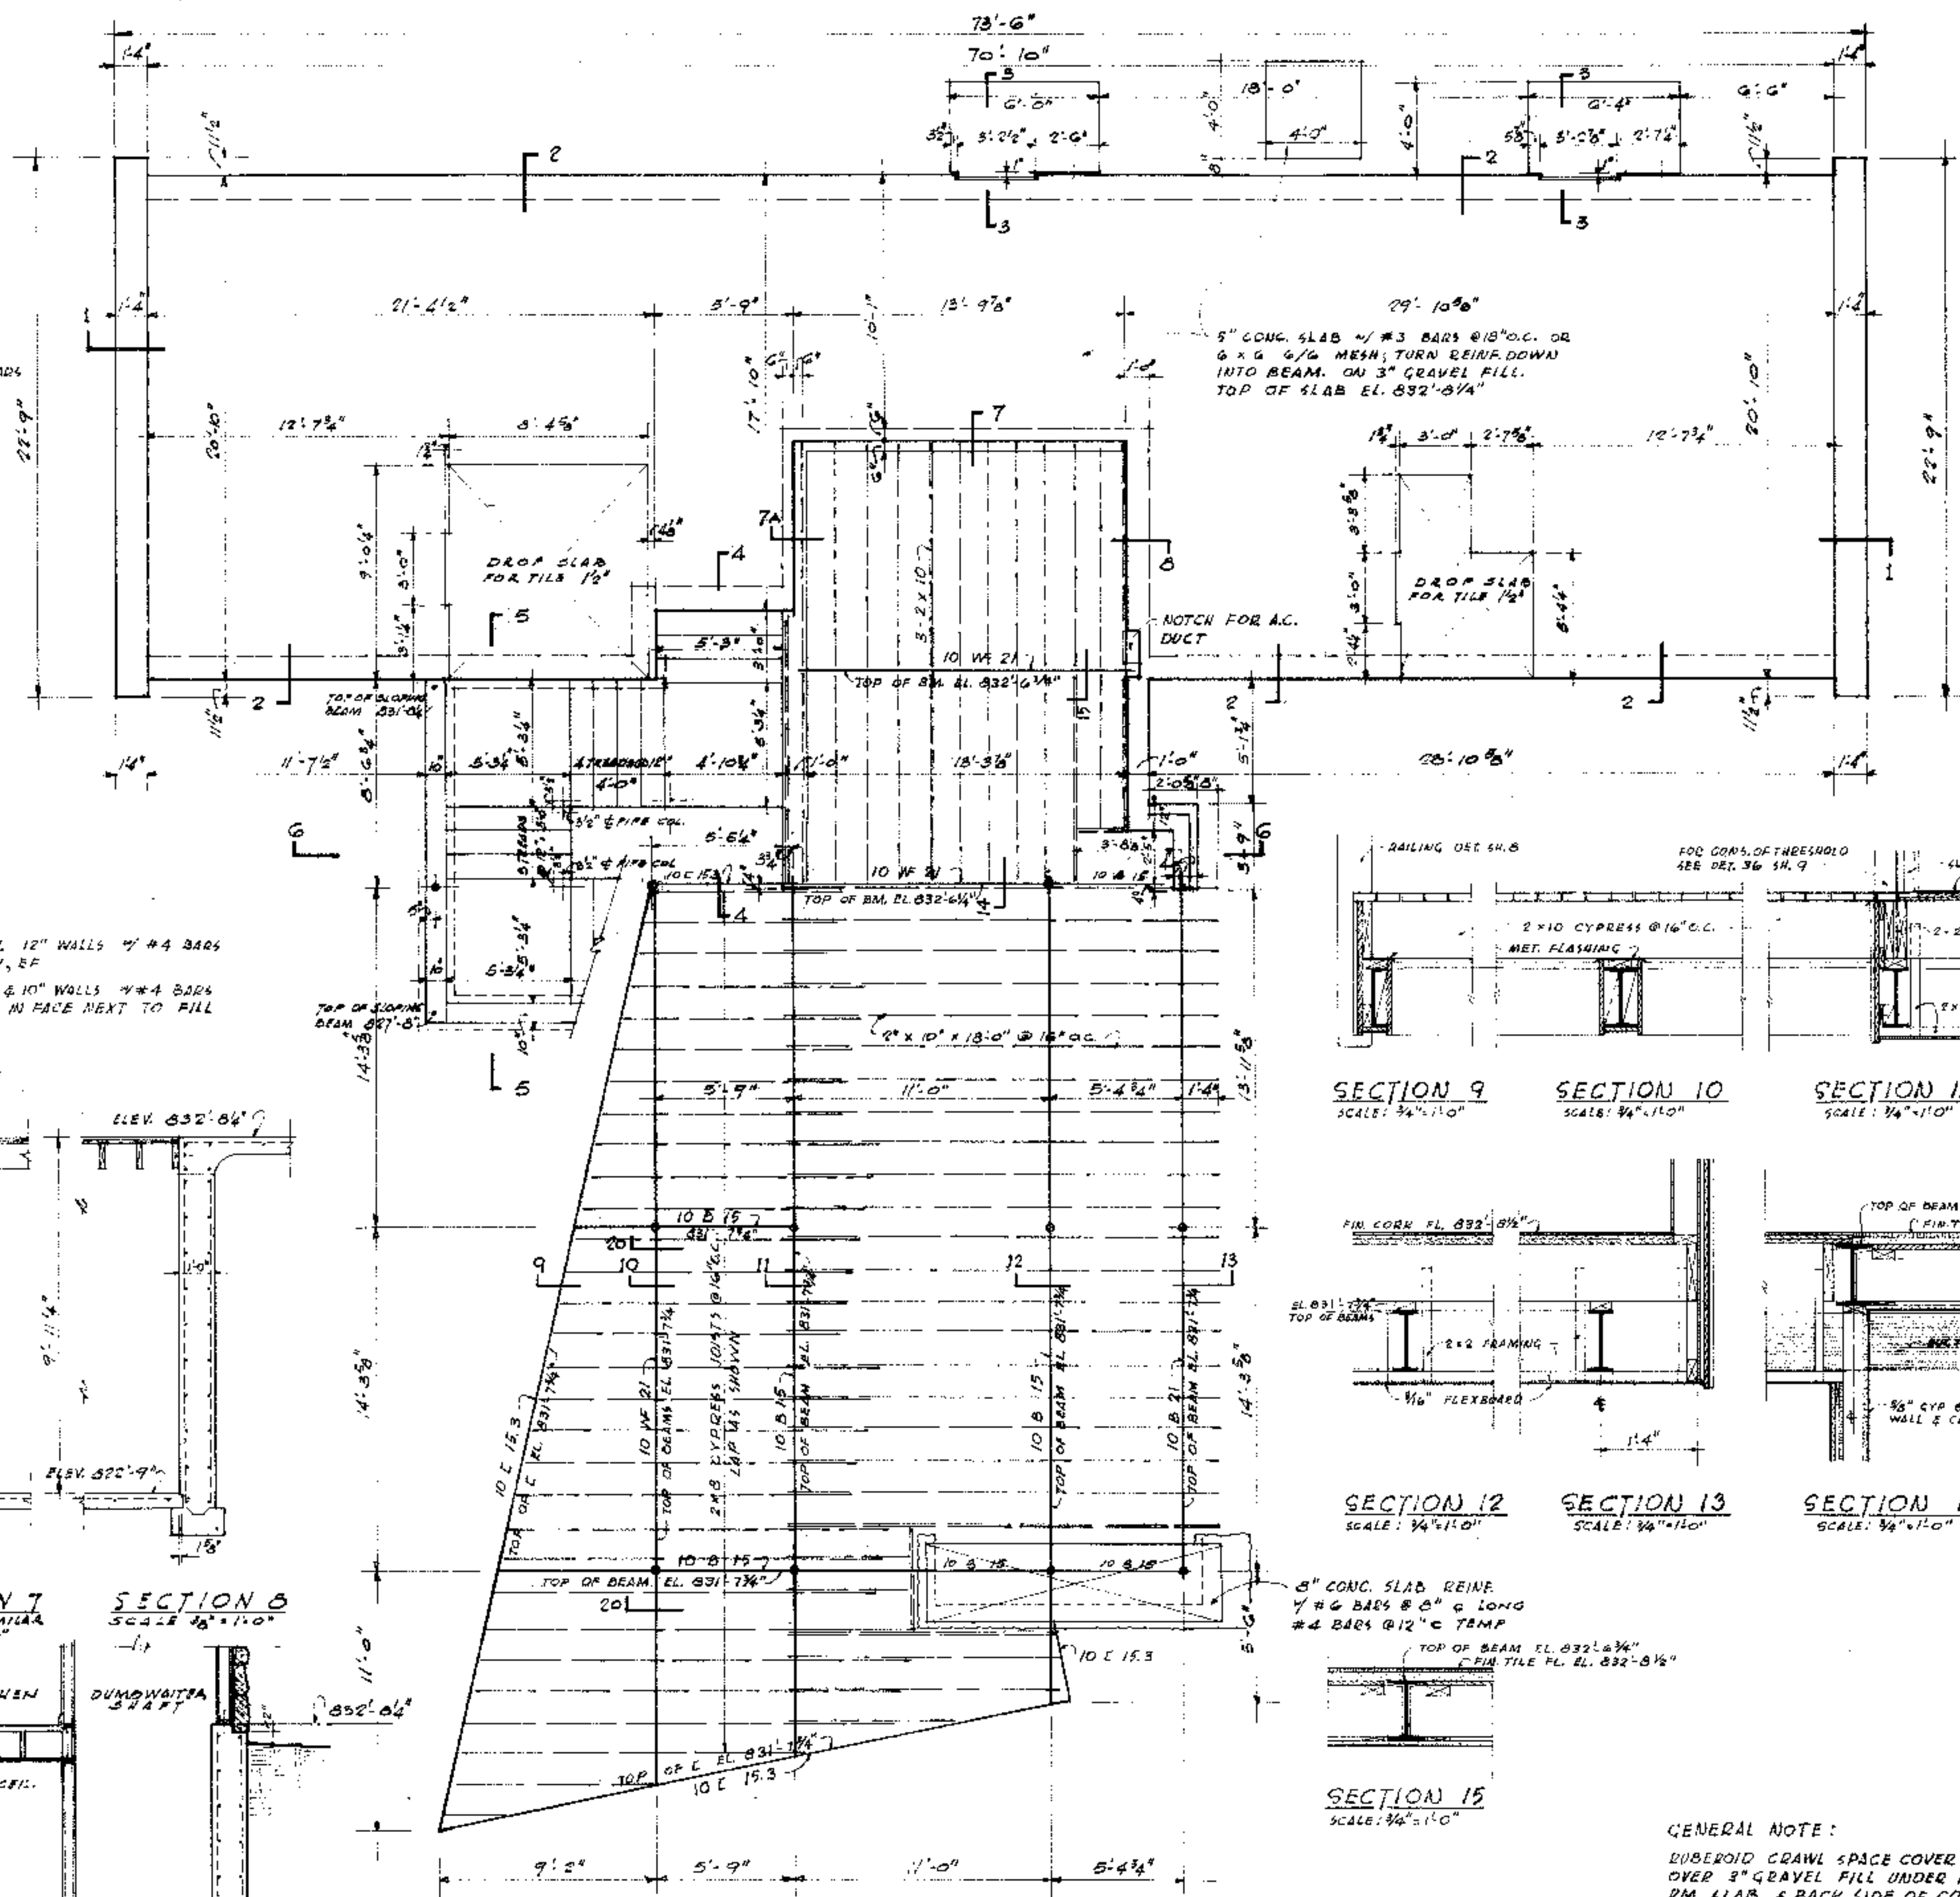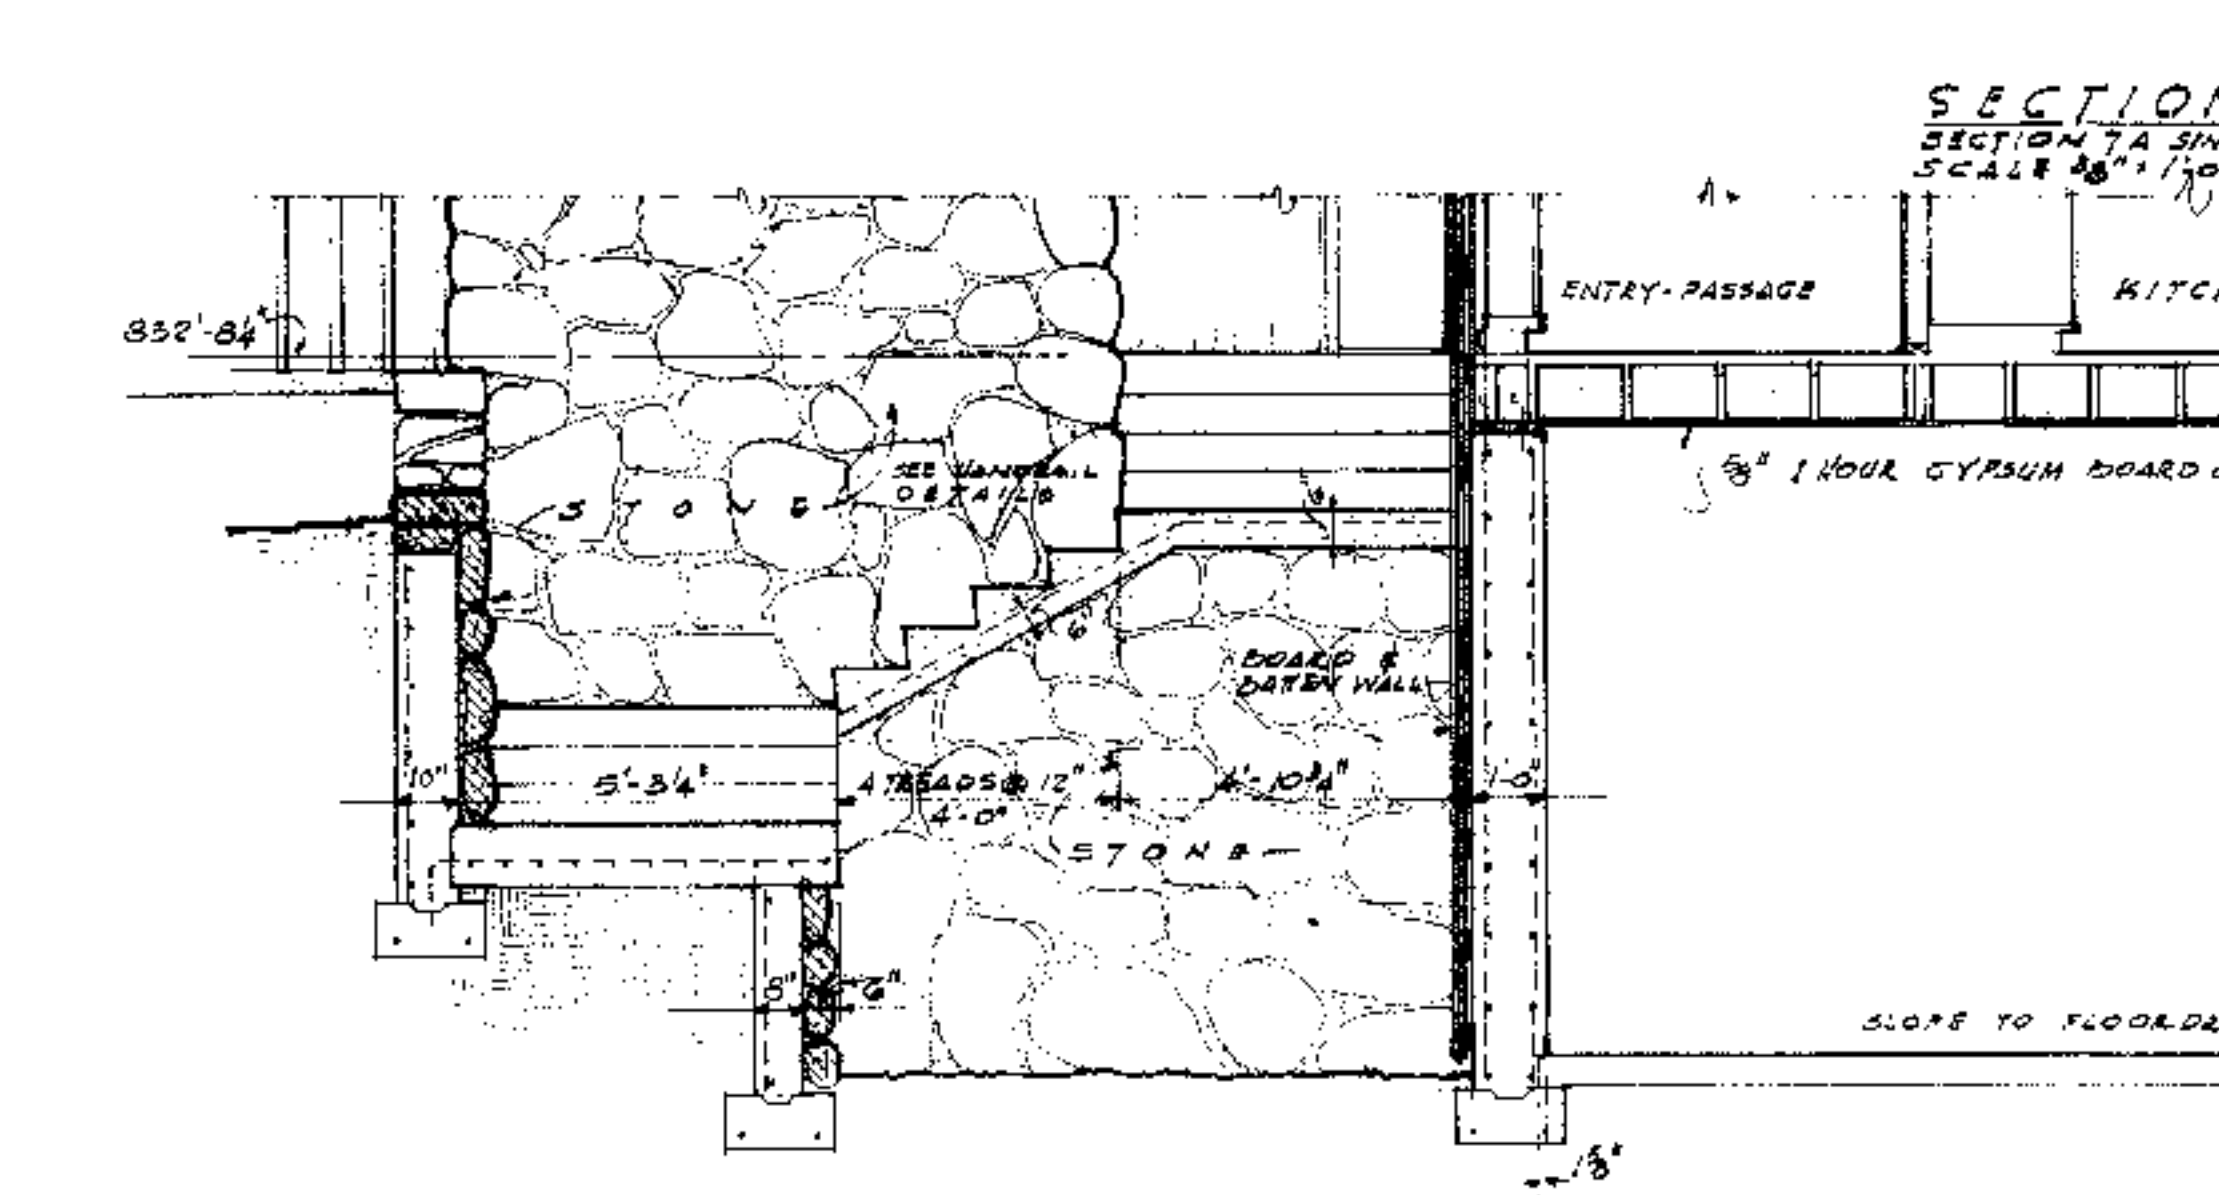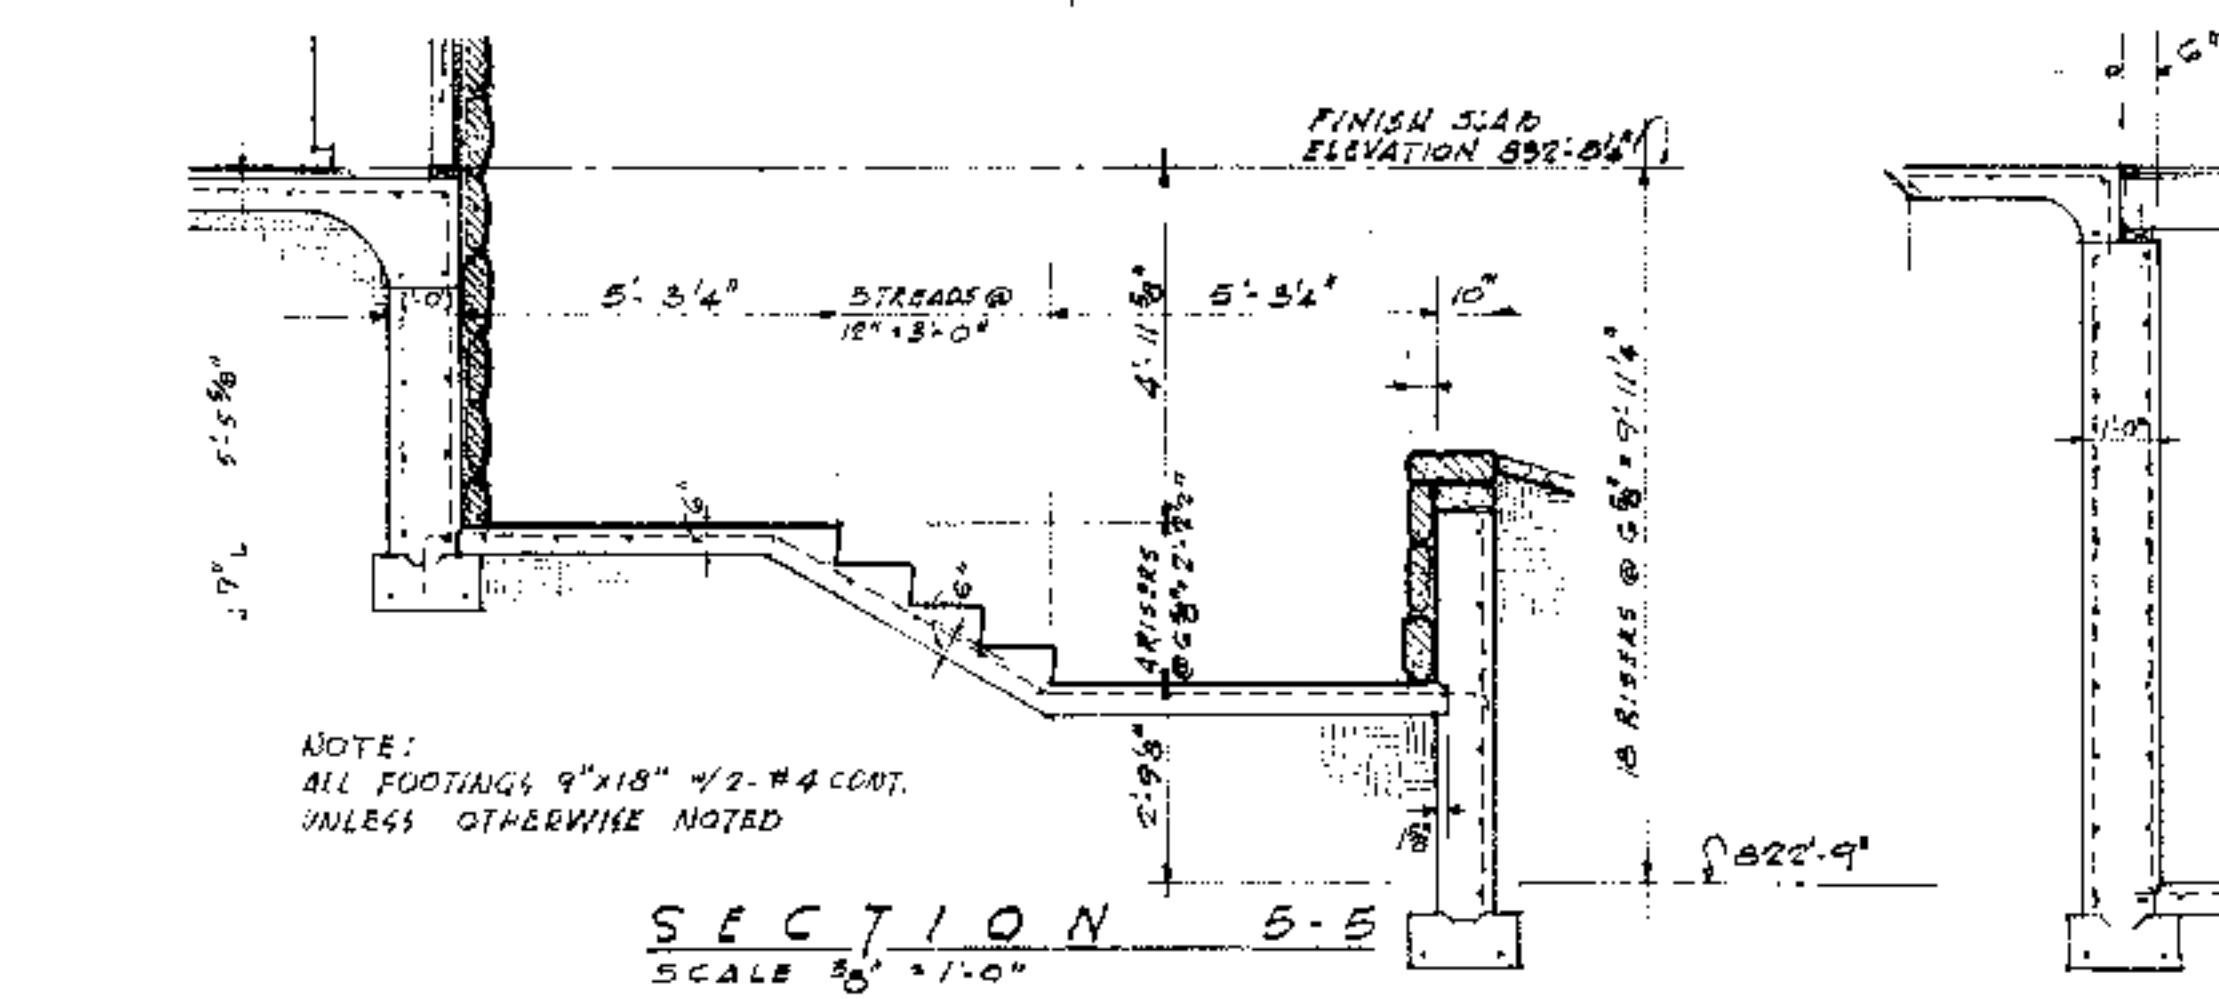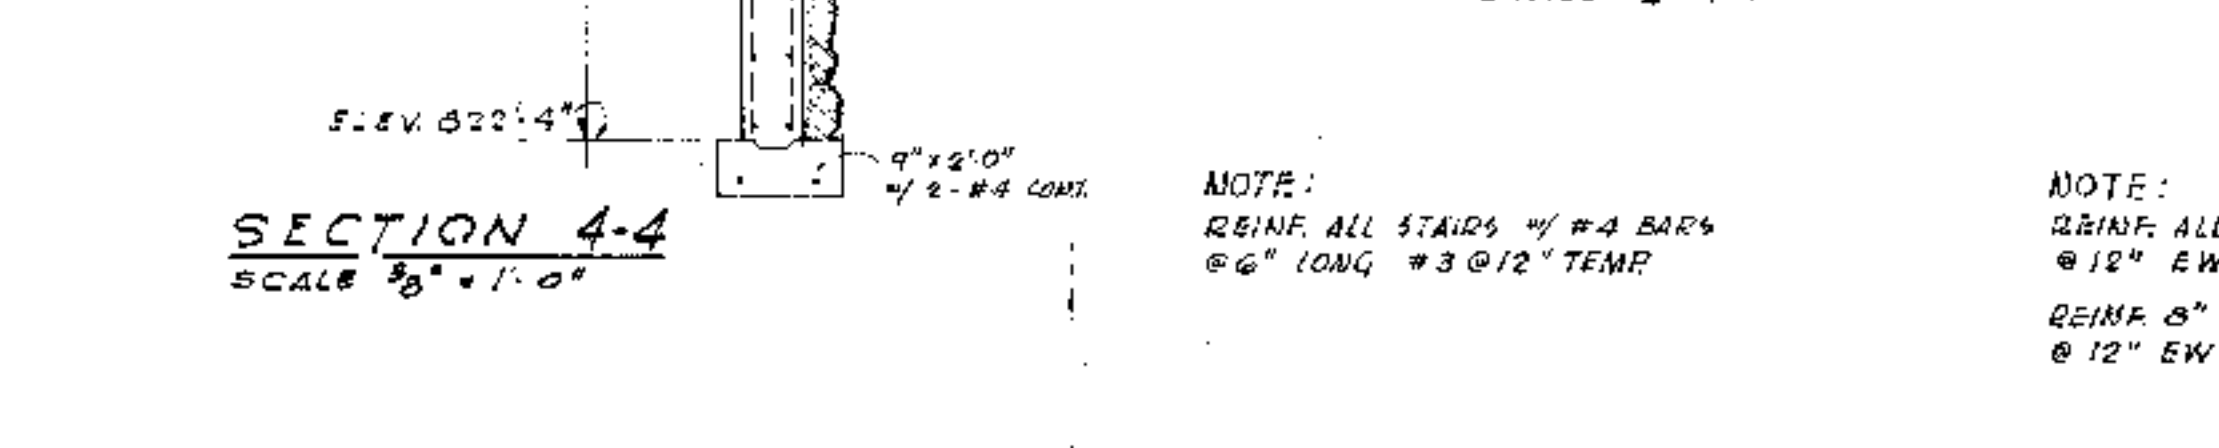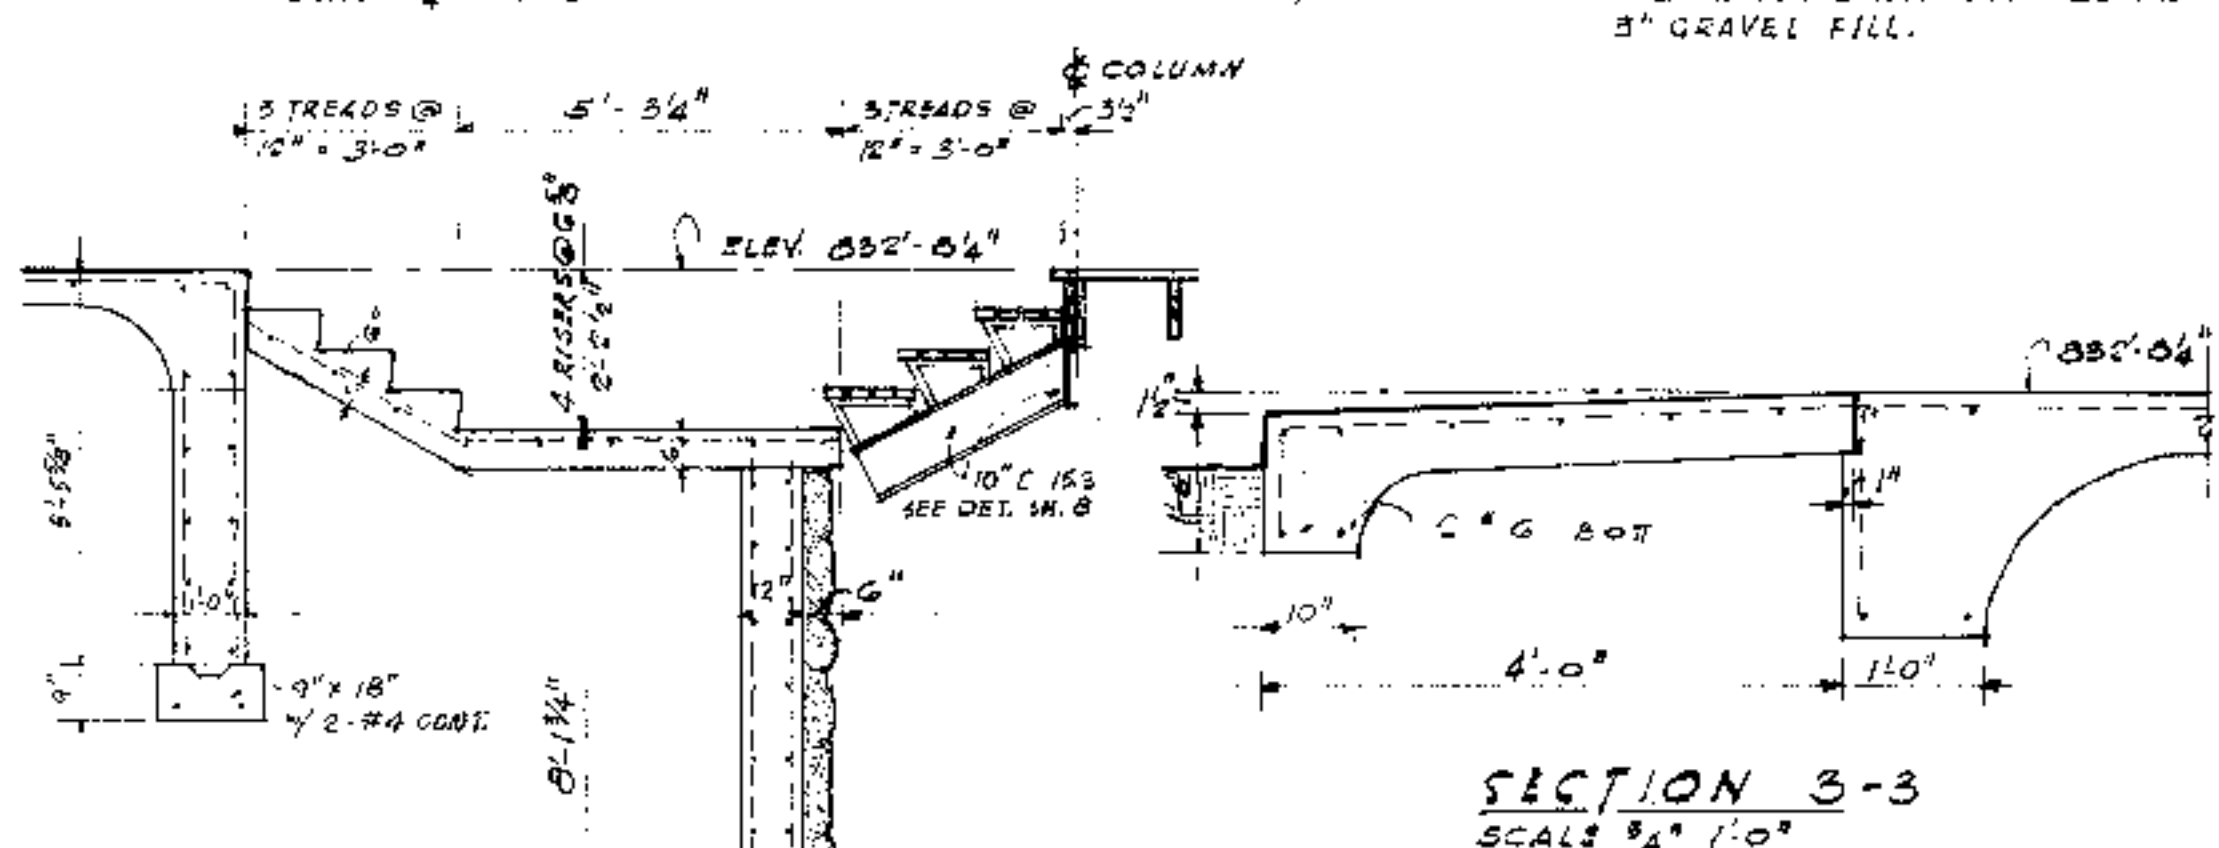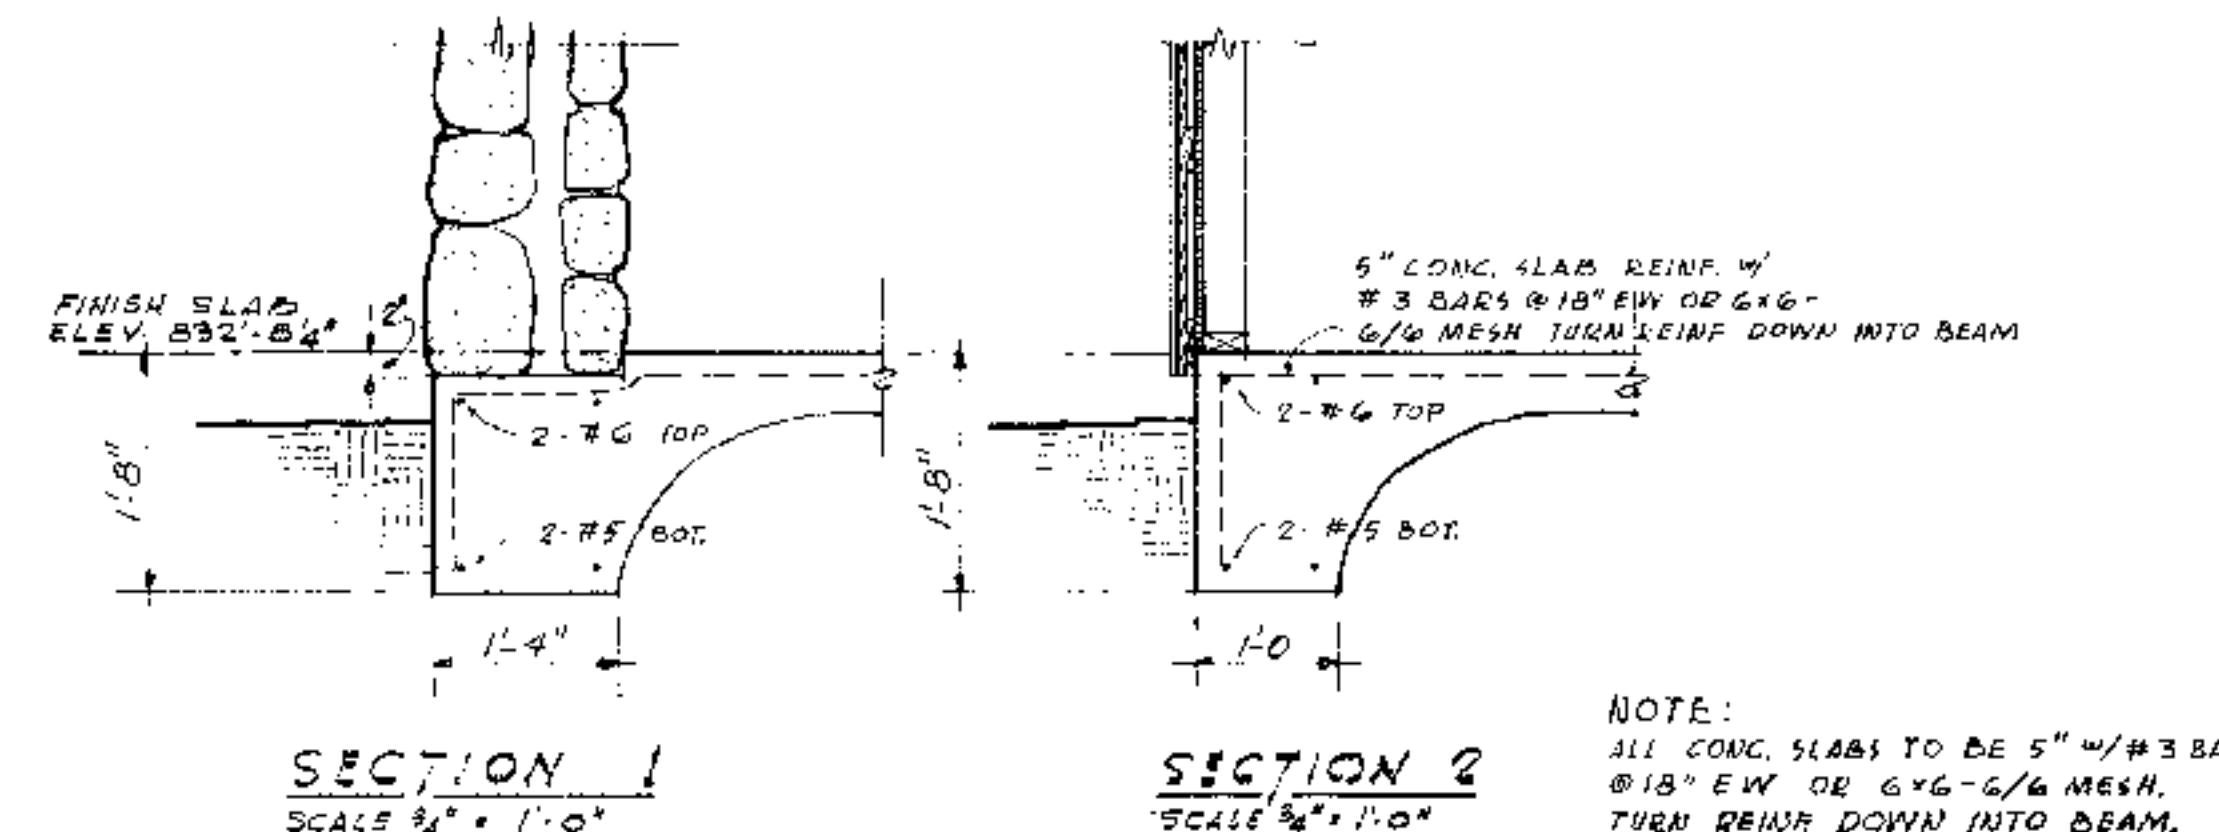


UPPER LEVEL FOUNDATION & FLOOR FRAMING PLAN
SCALE 1/4" = 1'-0"

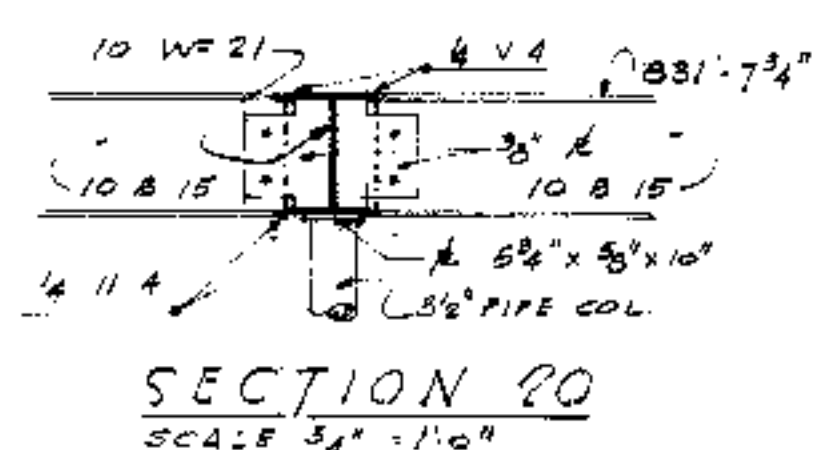


GENERAL NOTE:
ROBERTSON CRAWL SPACE COVER SHALL BE PLACED OVER 3\"/>

WM. H. HIDEALL, JR.
ARCHITECT
3010 BLACKBURN ST. DALLAS 4, TEXAS
A RESIDENCE FOR
MR. & MRS. R. R. HIDEALL
AUSTIN TEXAS
JOB NO. DATE DRAWN BY CHECKED BY SHEET NO.
602 9-1-56 H H OF 16




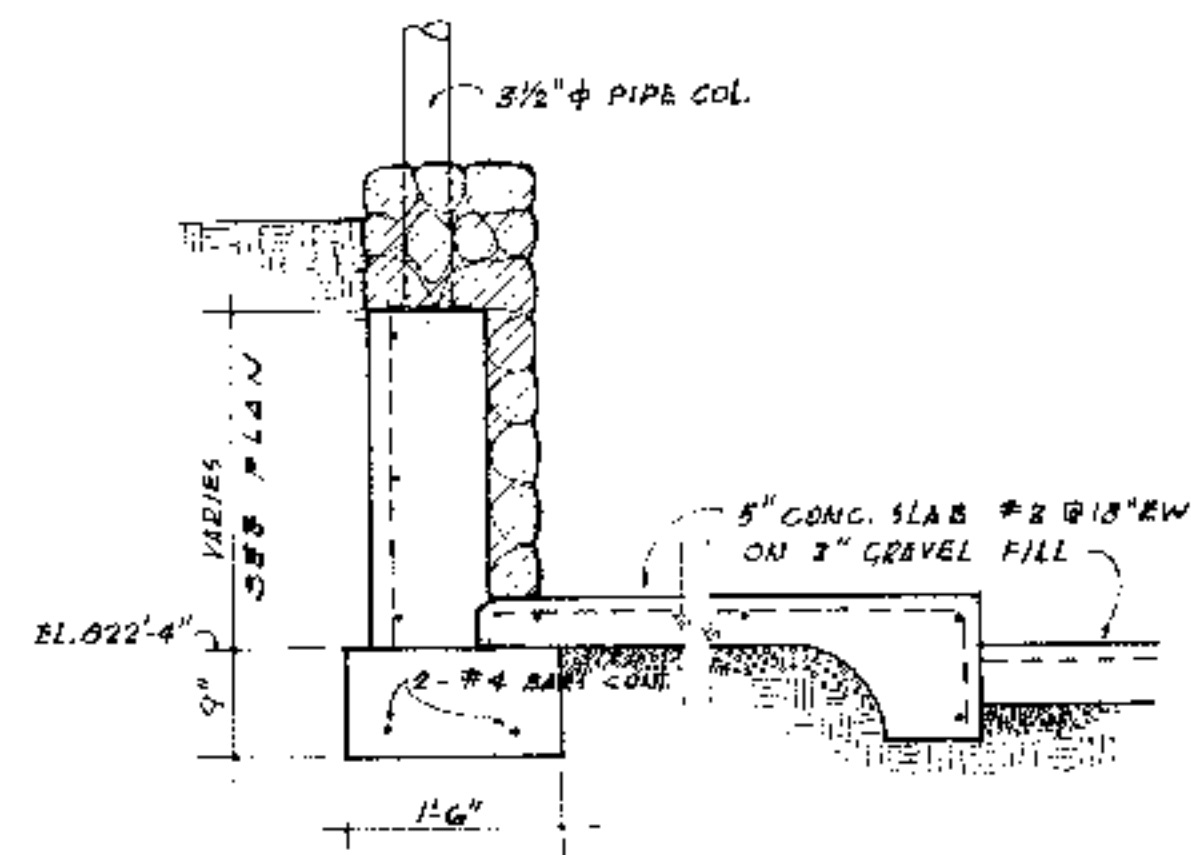


SECTION 16-16
SCALE: 3/4" = 1'-0"

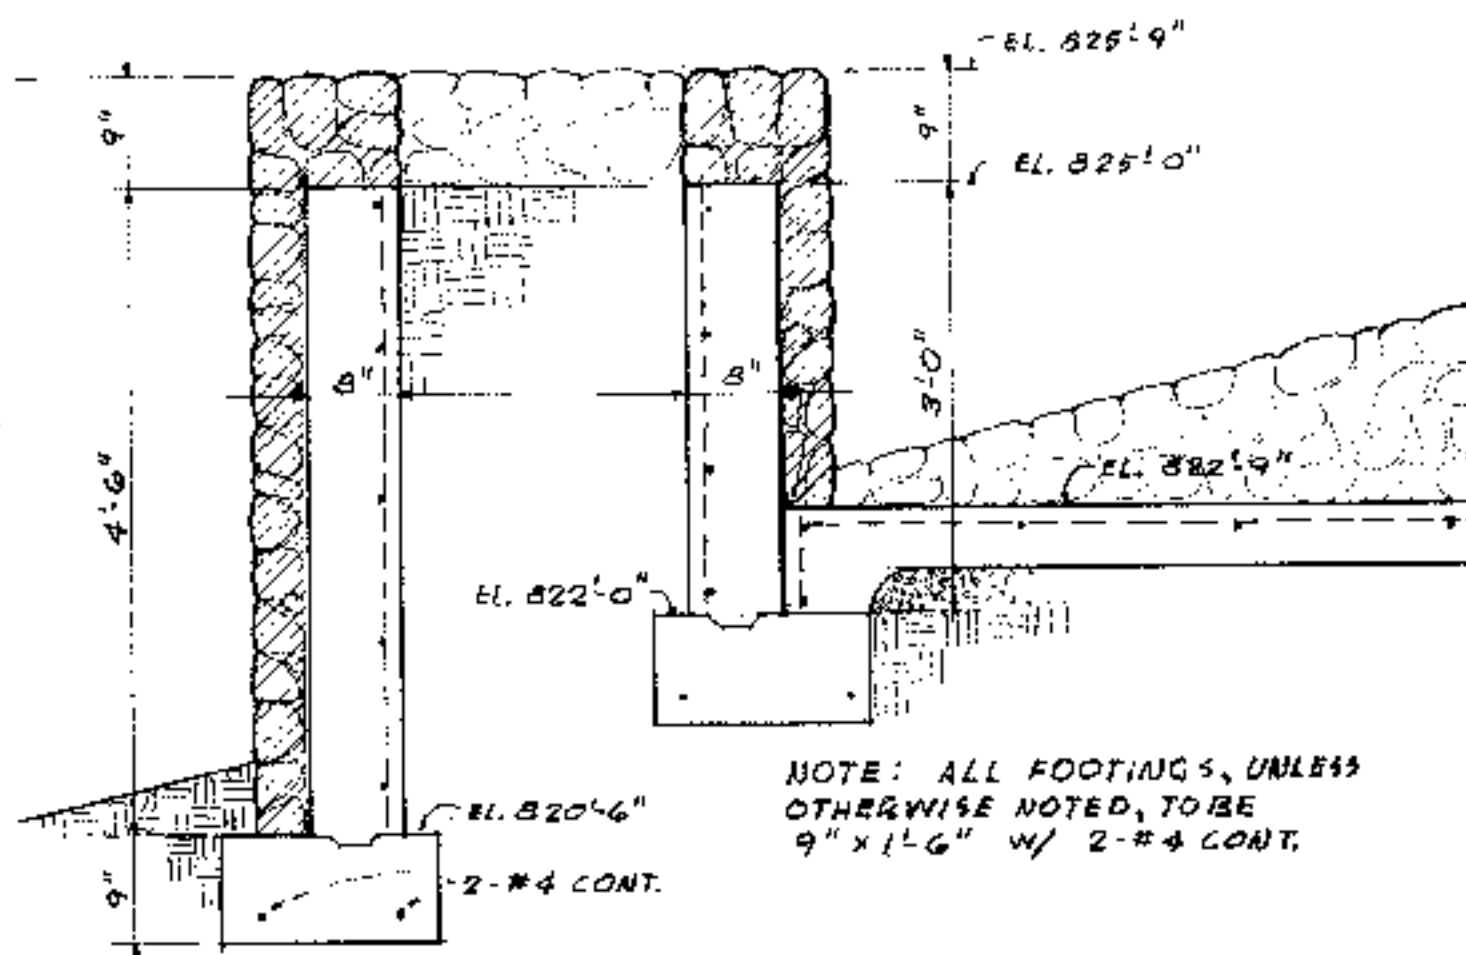


SECTION 17-17
SCALE: 3/4" = 1'-0"

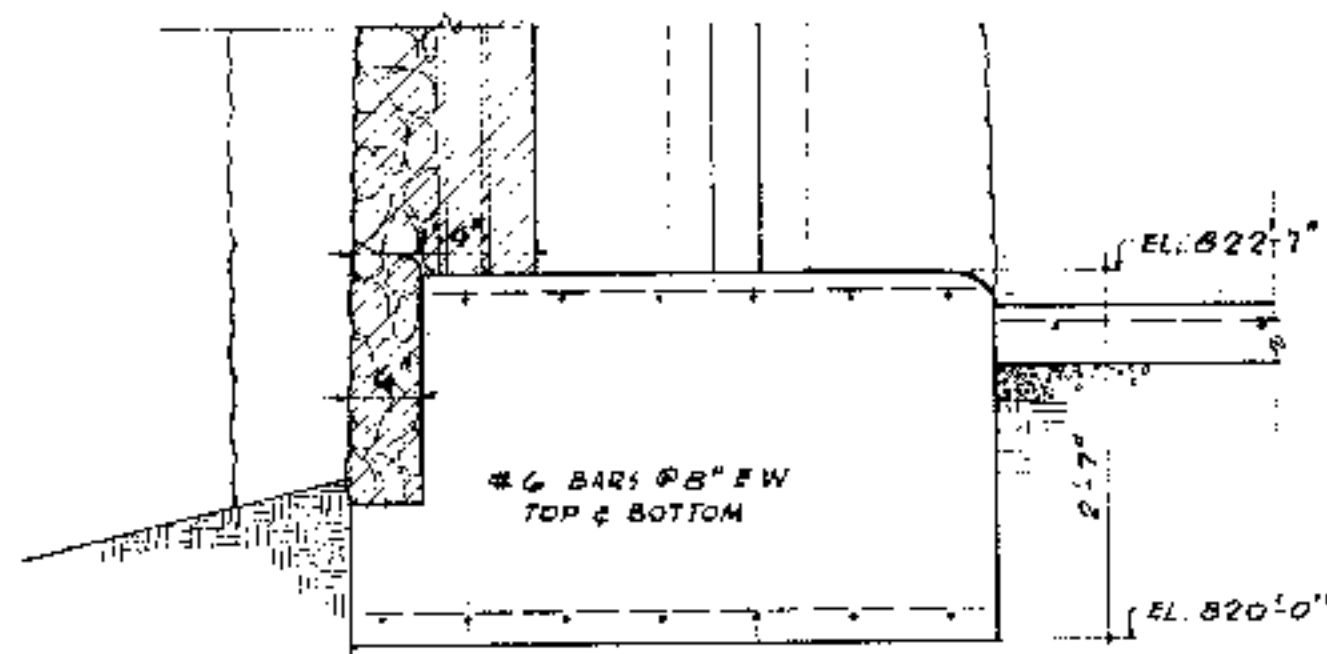


SECTION 18-18
SCALE: 3/4" = 1'-0"

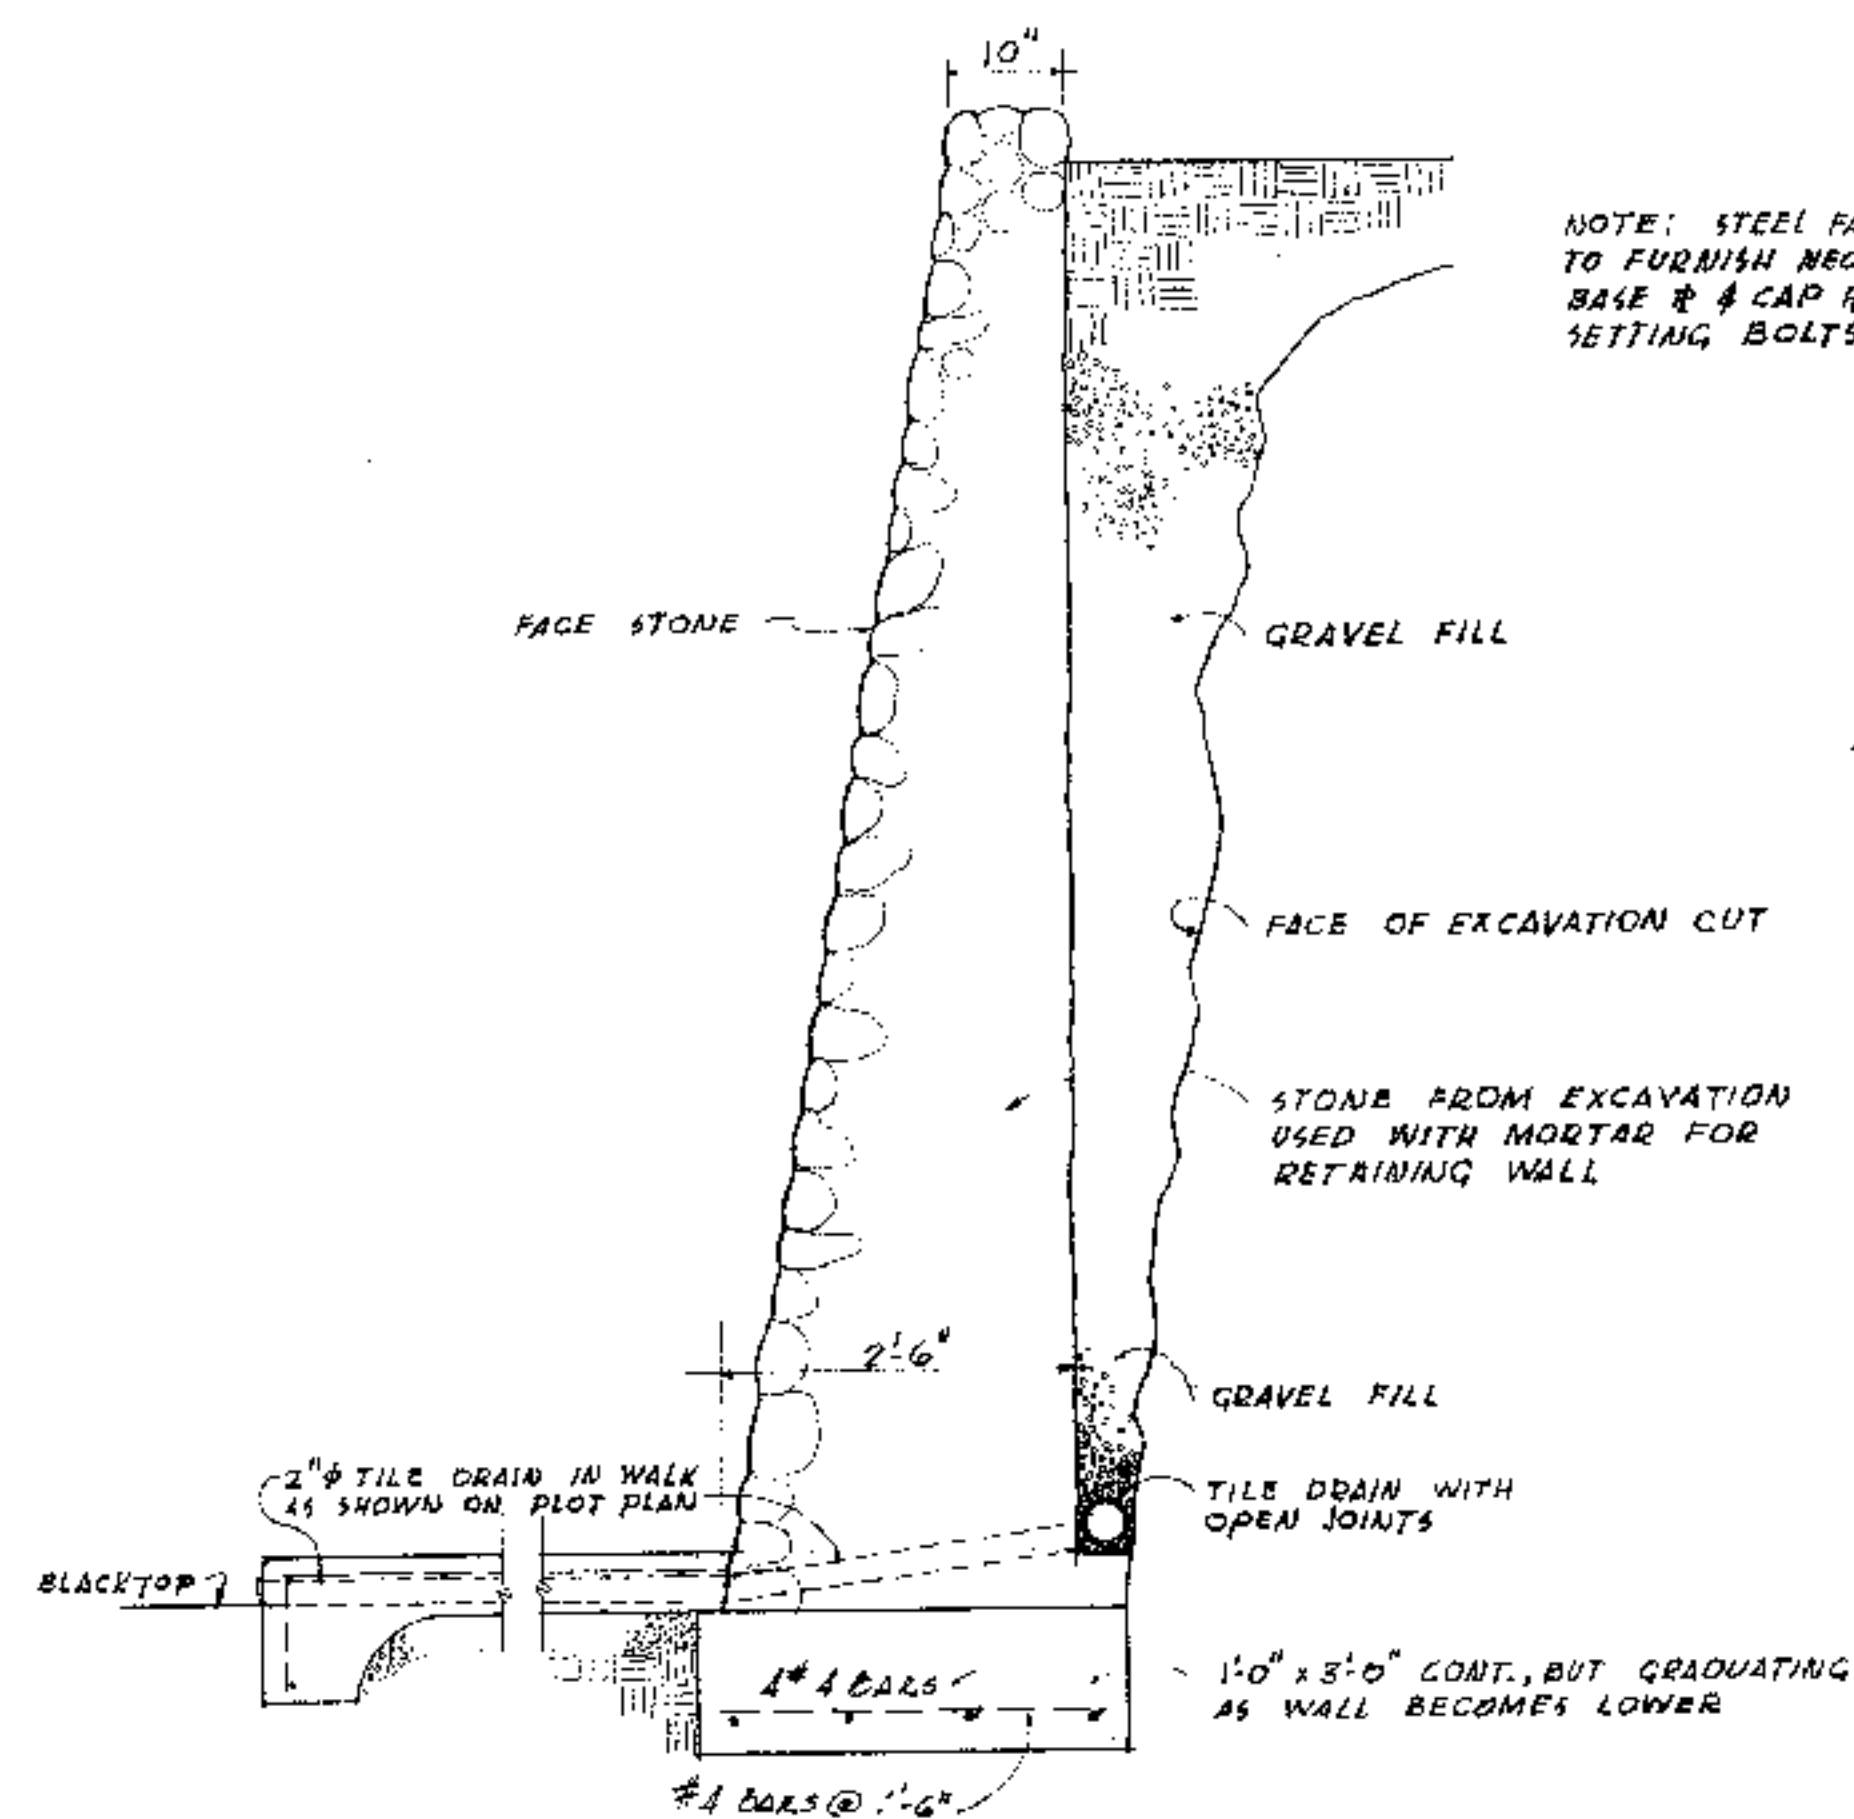

SECTION 19
SCALE: 3/4" = 1'-0"

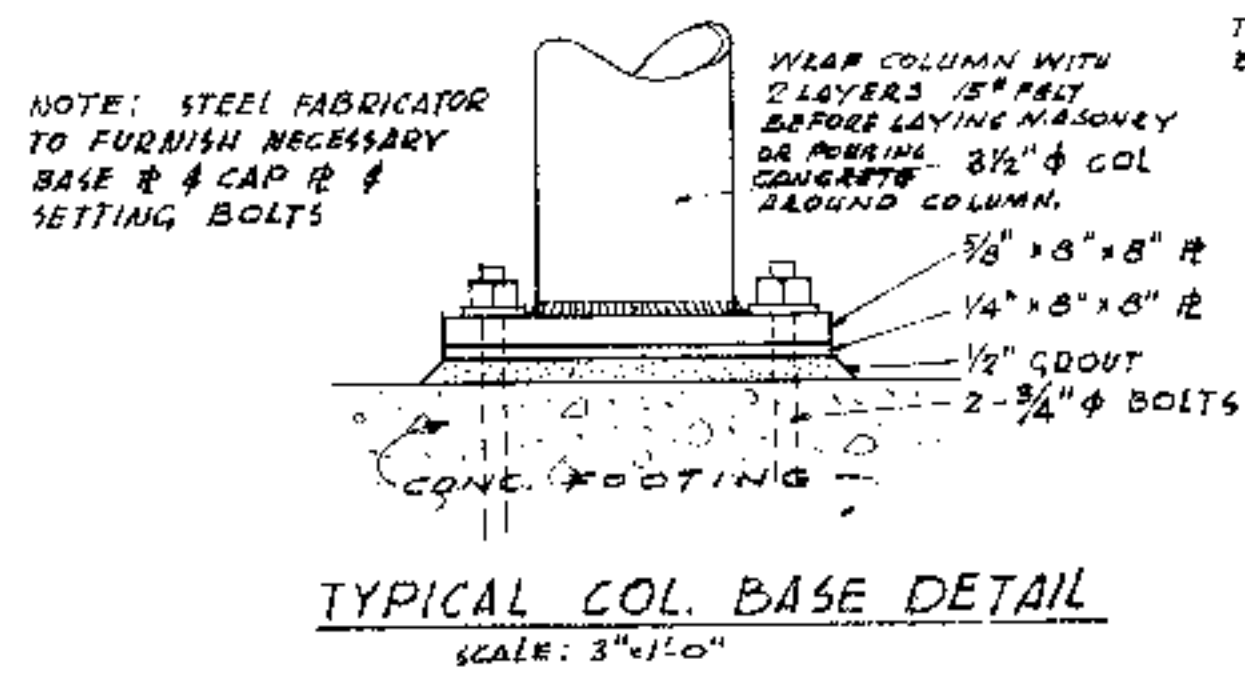

TYPICAL COL. BASE DETAIL
SCALE: 3/4" = 1'-0"

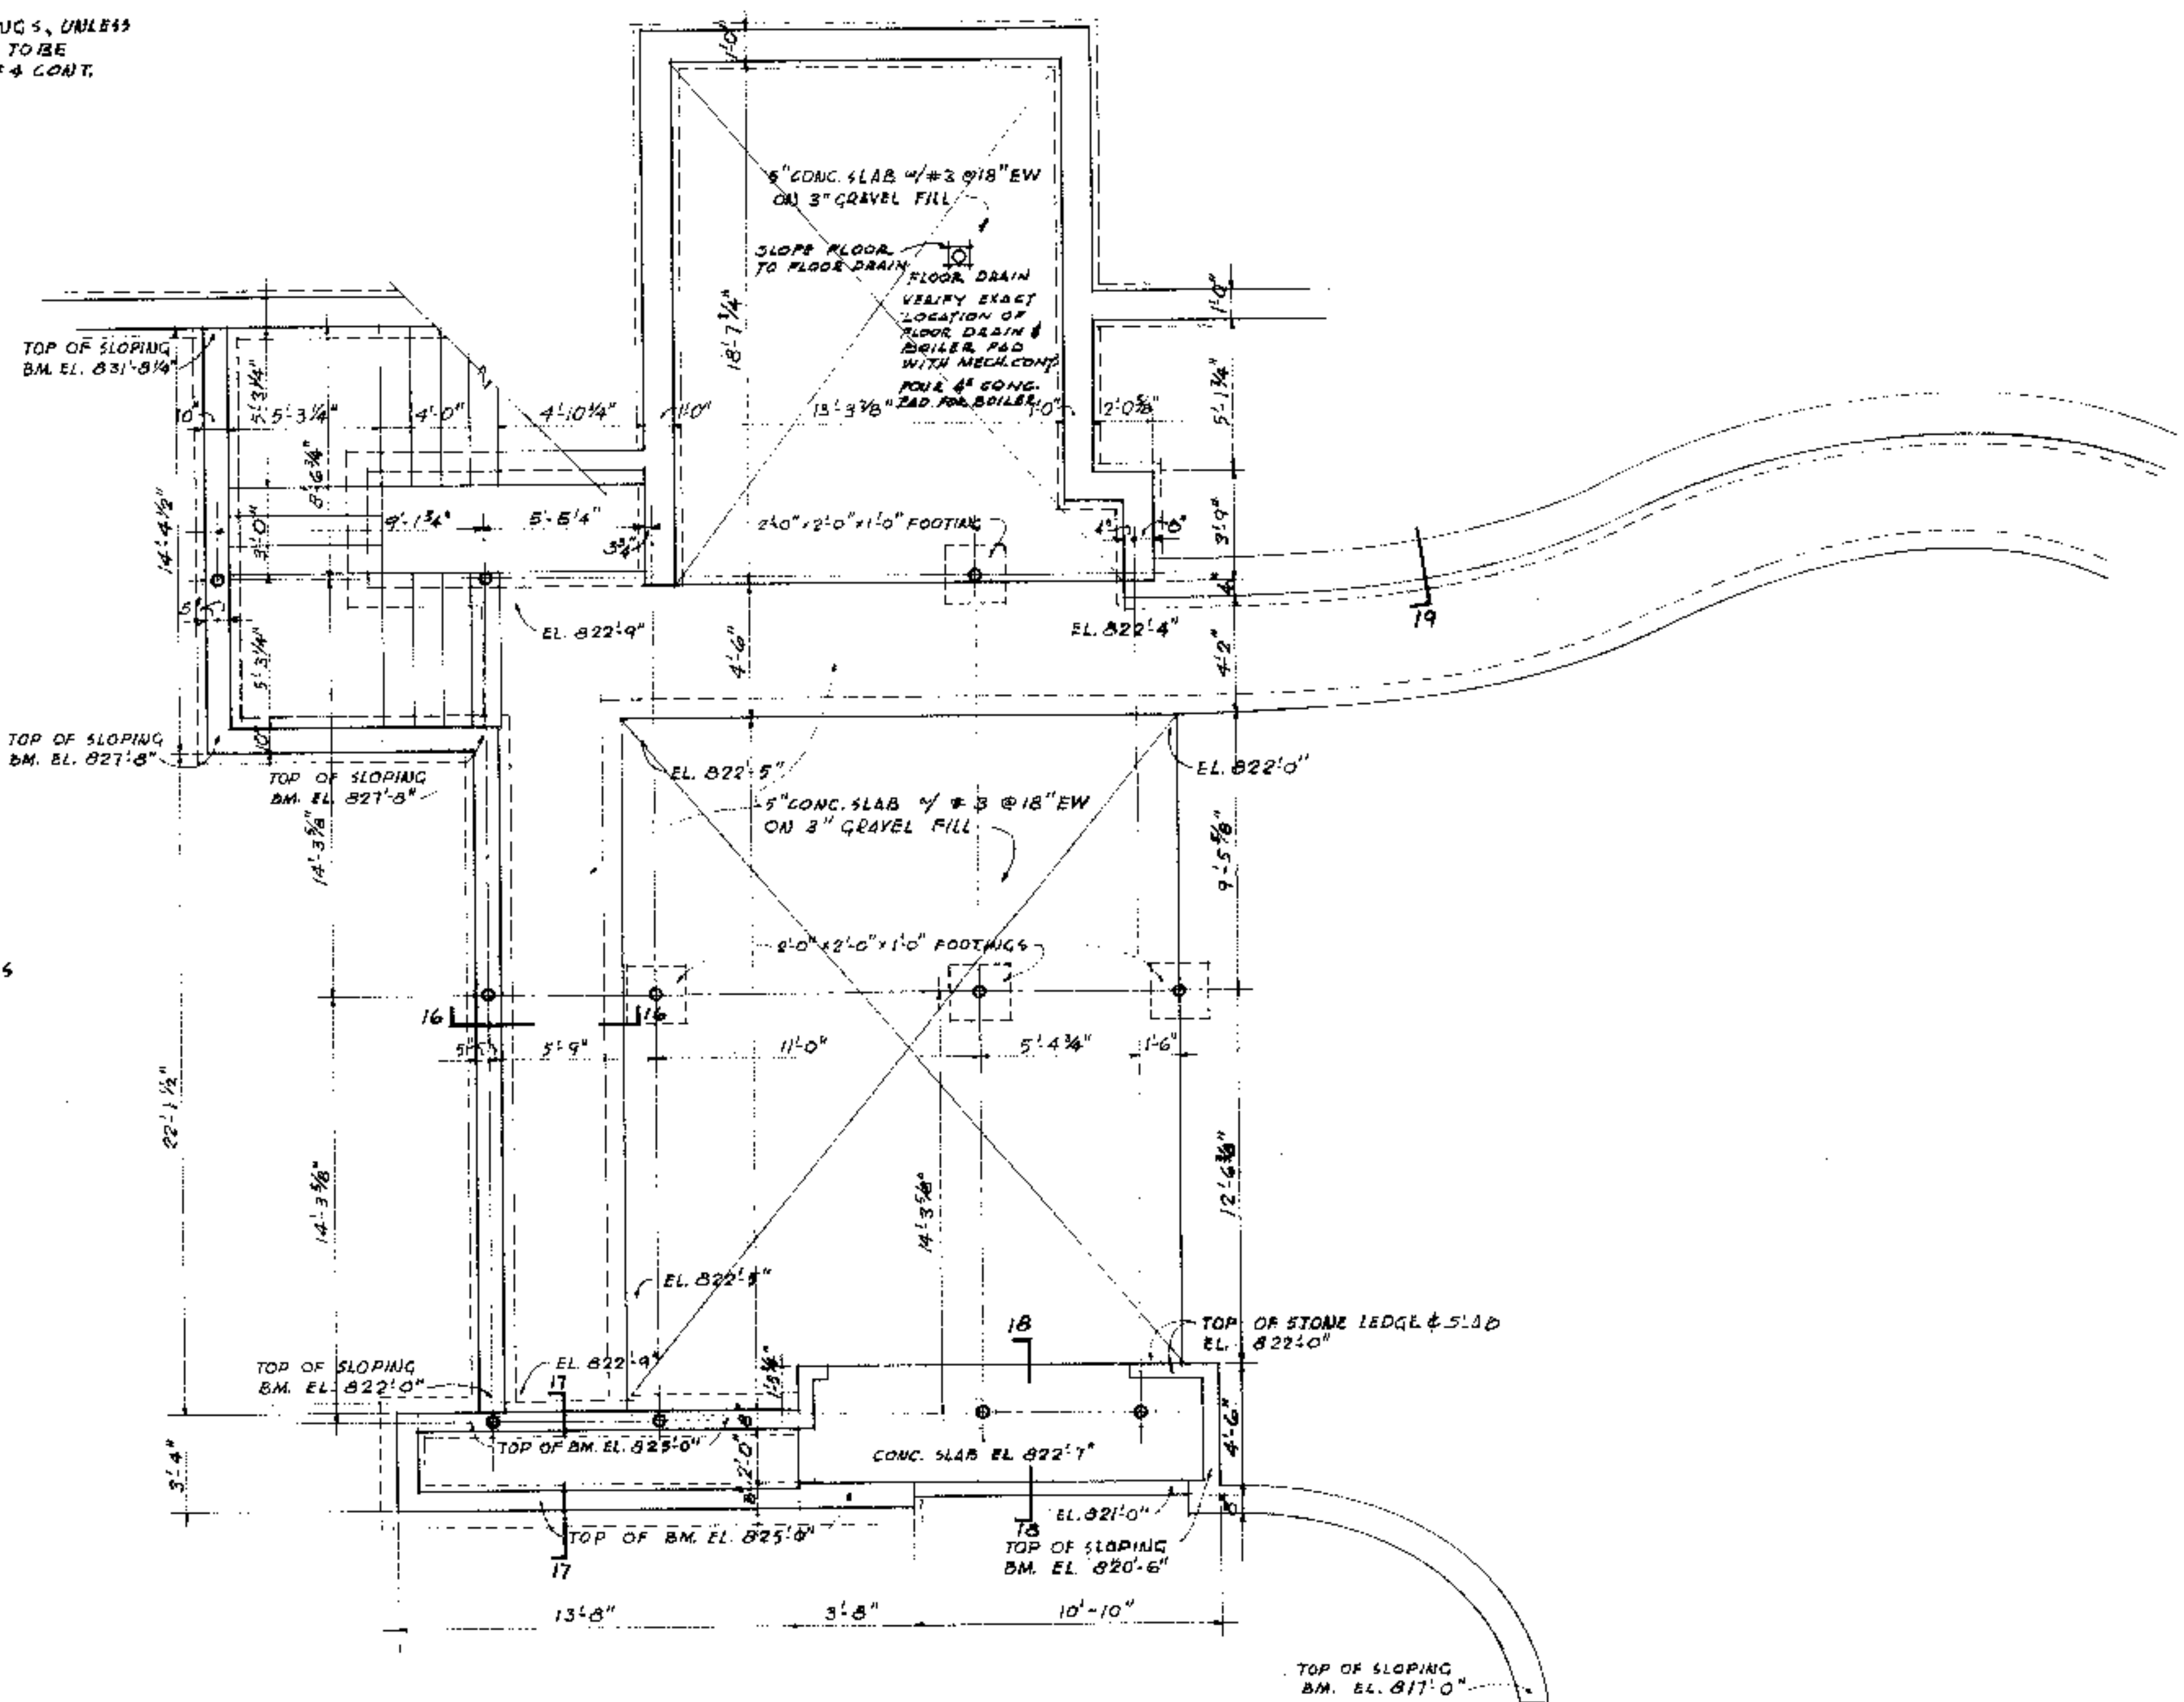


LOWER LEVEL FOUNDATION PLAN
SCALE: 3/4" = 1'-0"

REV: 11-9-56 - REIN. STEEL SEC. 19


WM. H. HIDEELL, JR.,
ARCHITECT
3010 BLACKBURN ST. DALLAS 4, TEXAS
A RESIDENCE FOR
MR. & MRS. R. R. HIDEELL
AUSTIN, TEXAS

JOB NO. DATE DRAWN BY CHECKED BY SHEET NO.
602 7-1-56 A 4 OF 16




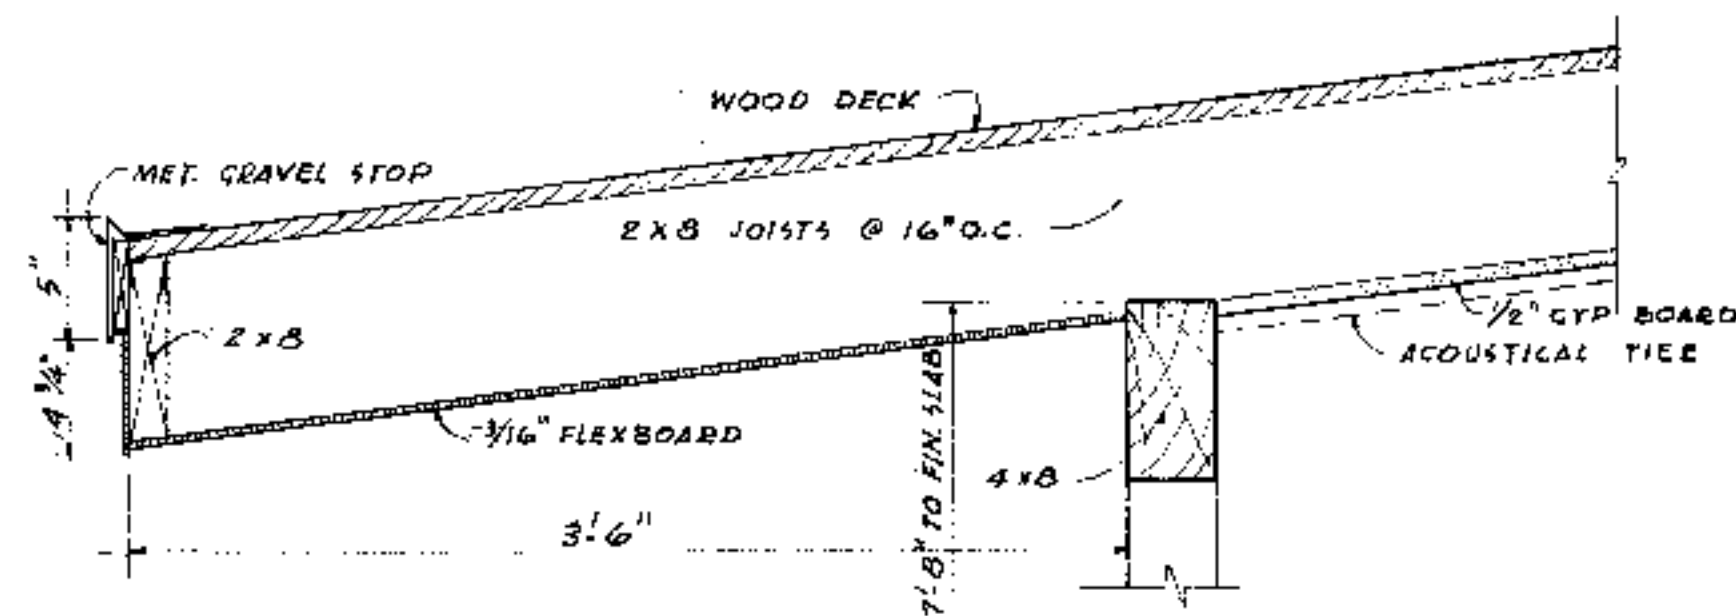


SECTION X-X
SCALE: 1/2" = 1'-0"

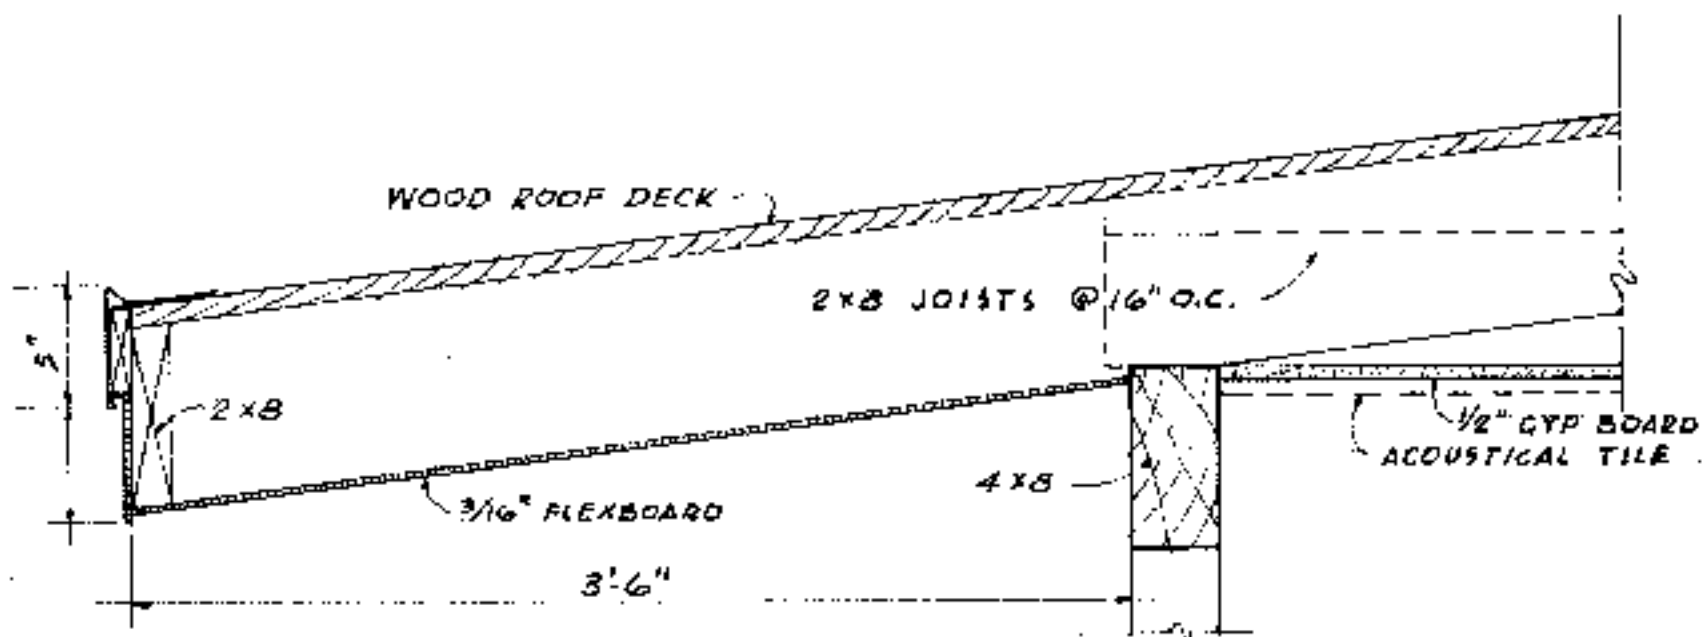

SECTION Y-Y
SCALE: 1/2" = 1'-0"

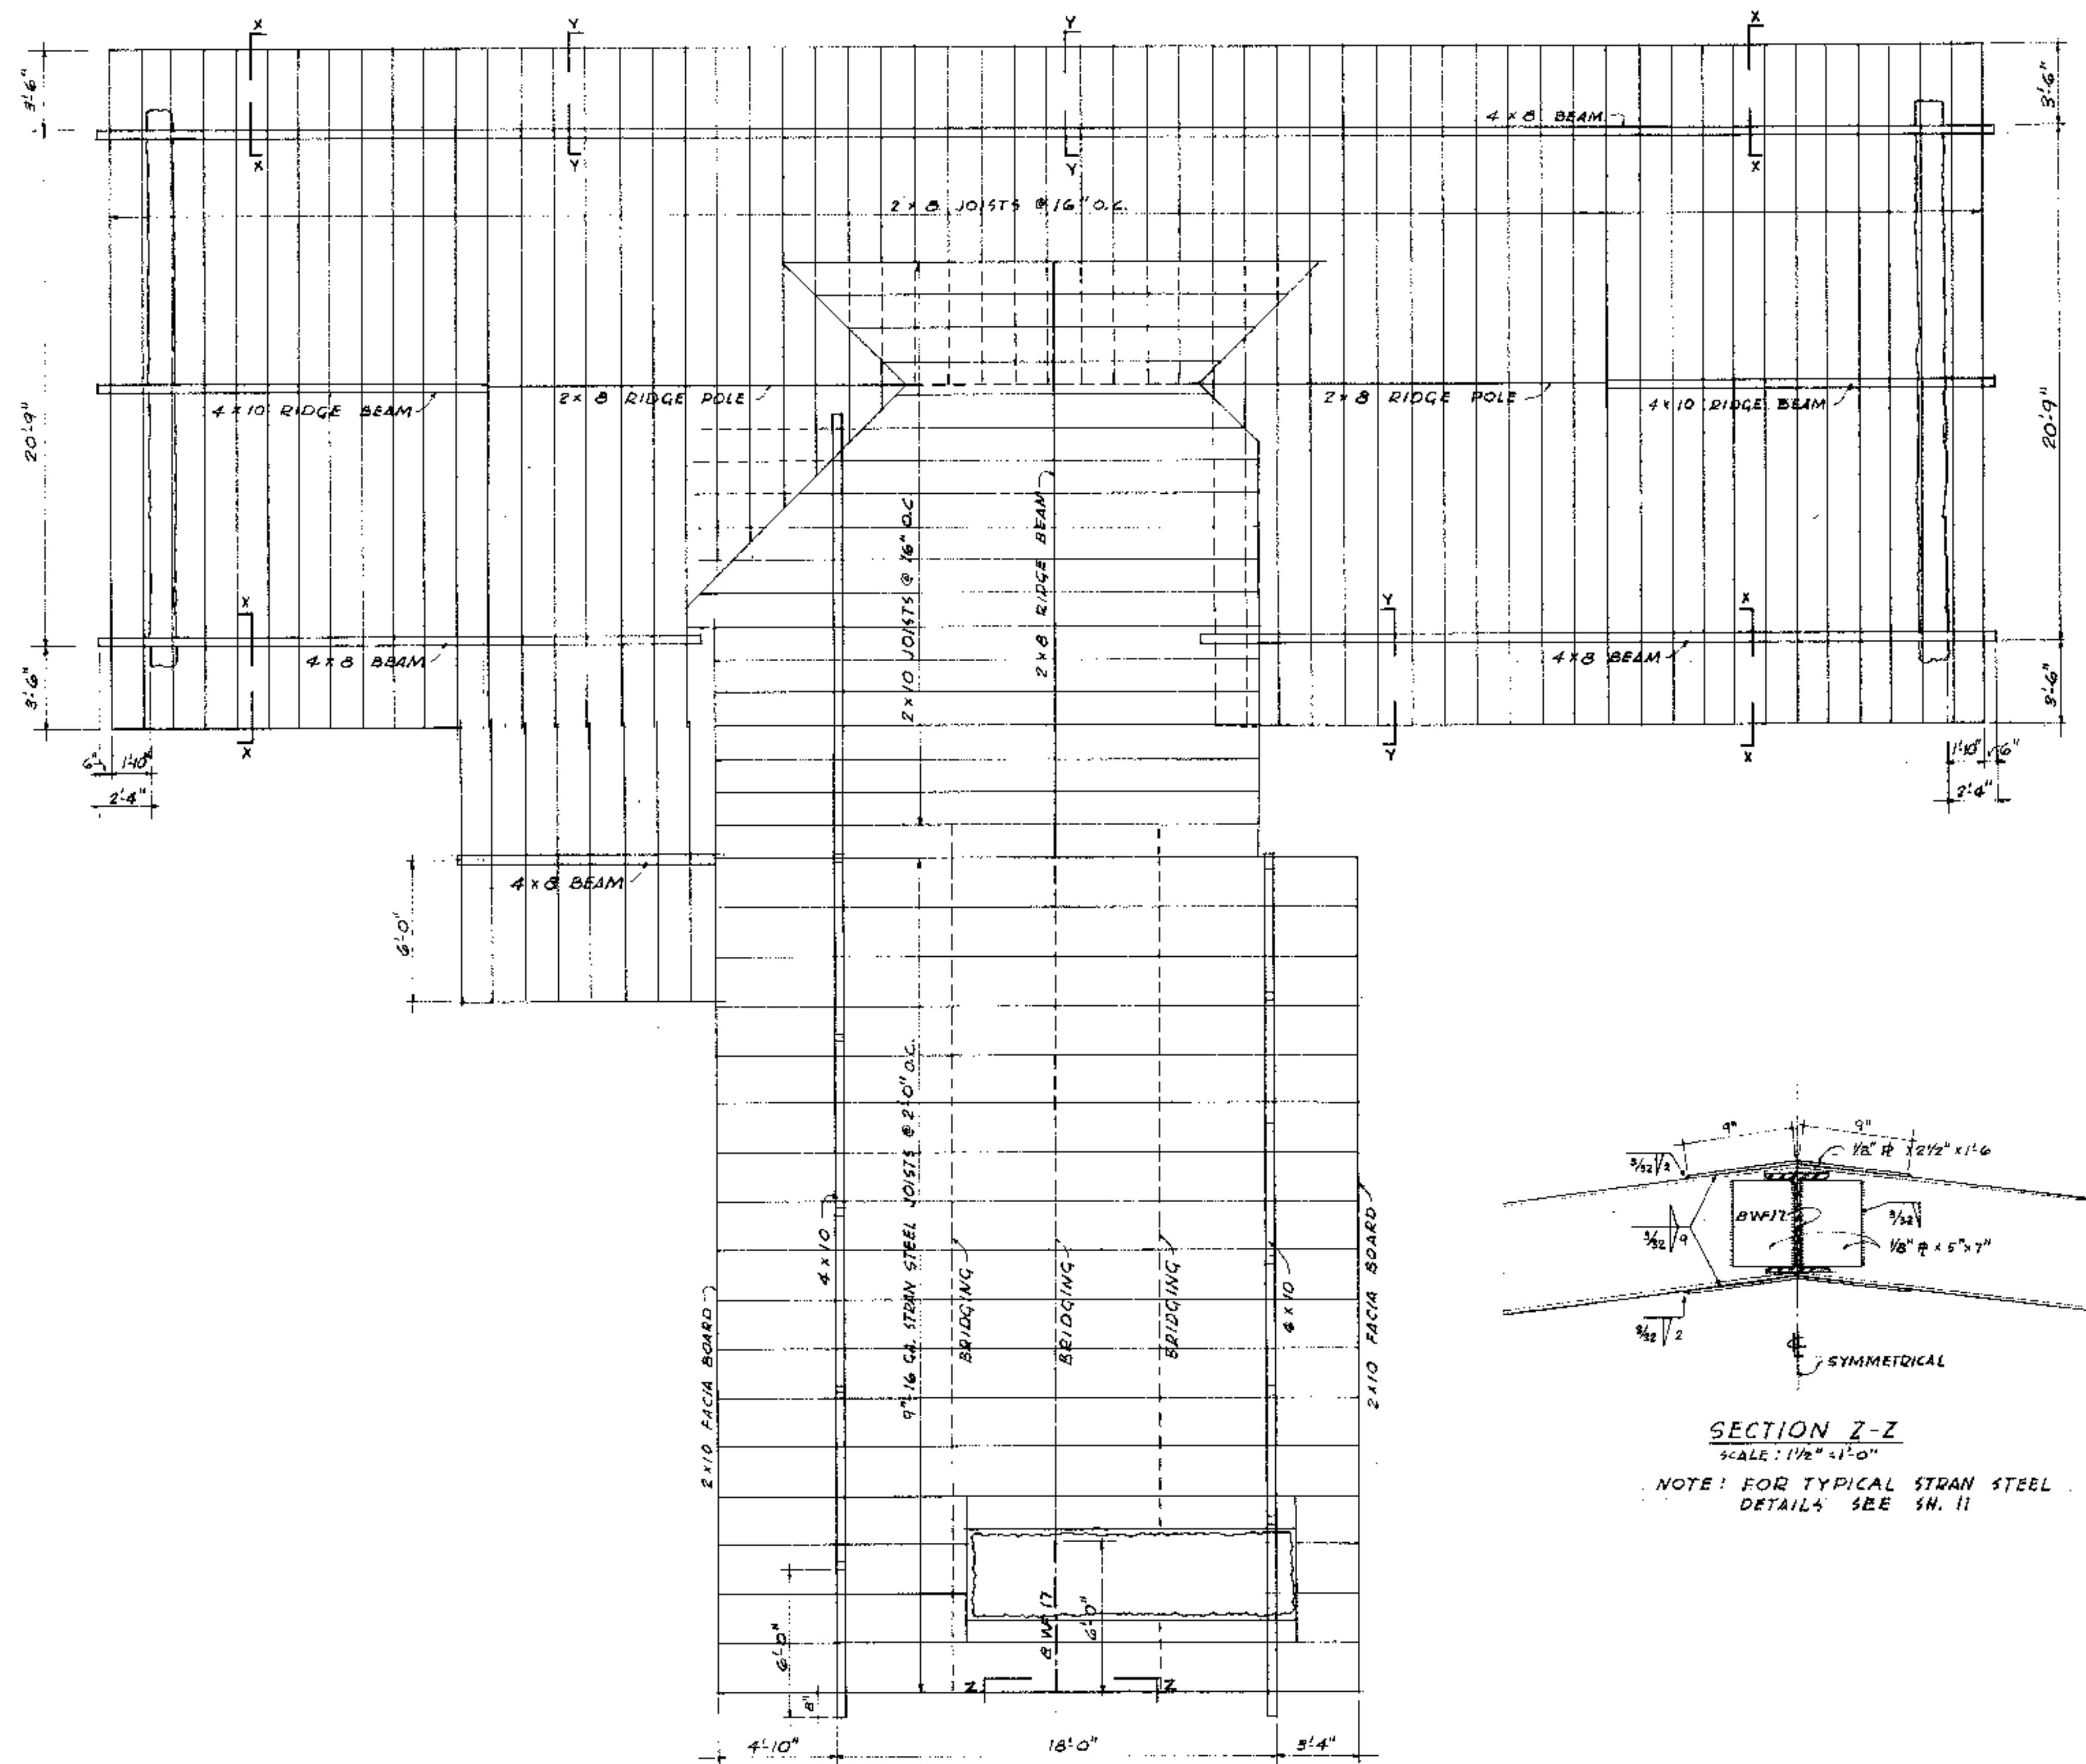

ROOF FRAMING PLAN
SCALE: 1/4" = 1'-0"

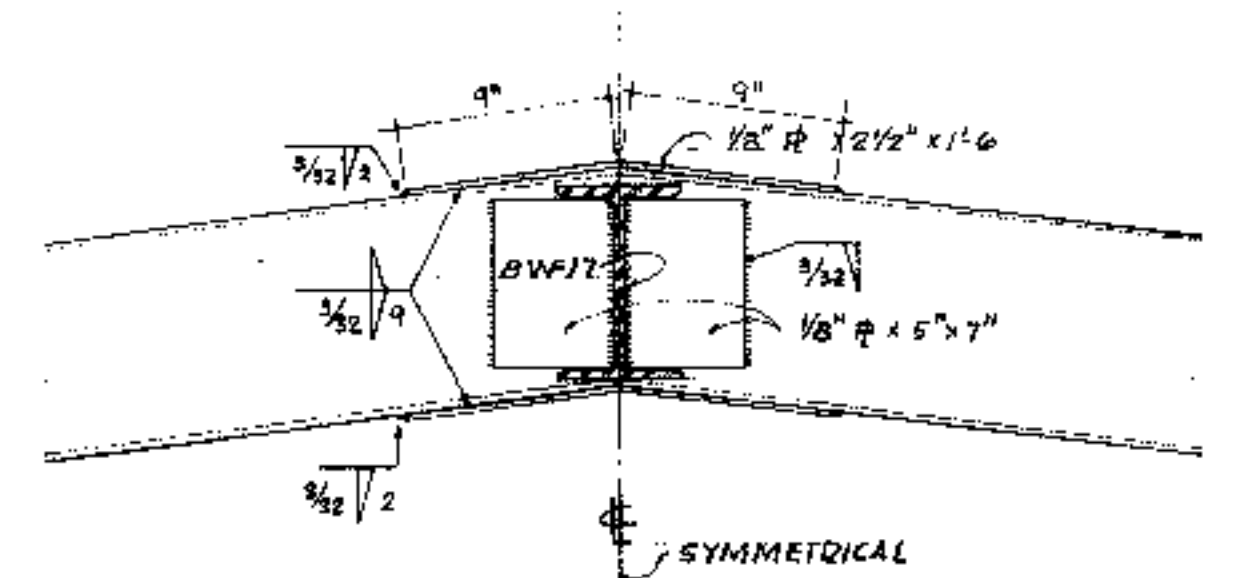

SECTION Z-Z
SCALE: 1/2" = 1'-0"

NOTE: FOR TYPICAL STRAN STEEL
DETAILS SEE SH. 11


WM. H. HIDEELL, JR.
ARCHITECT
3010 BLACKBURN ST. DALLAS 4, TEXAS
A RESIDENCE FOR
MR. & MRS. R. R. HIDEELL
AUSTIN TEXAS

JOB NO. DATE DRAWN BY CHECKED BY SHEET NO.
602 9-1-56 A H OF 16



RECOMMENDED SCHEDULE DECORATION

MARK	DESIGNATION	C.B. HT.	CEILING	WALLS	FLOOR	PASS/SHOE MOOD	TRIM	CABINETS	REMARKS
201	MASTER BEDROOM	SLOPING 7' 11"	ACTIVE/GYP. BD.	WALNUT PLYWD	CORK	WALNUT	WALNUT	WALNUT PLYWD	20" x 6" MARKER LOCATED BY OWNER
202	MASTER WARDROBE	-	PLY WOOD	FIR PLYWOOD	CORK	WALNUT	WALNUT	-	NATURAL NATURAL NATURAL NATURAL
203	MASTER BATH	7' 7"	GYP. BD.	GYP. BOARD	TILE	MAGNOLIA	MAGNOLIA	PINE	ENAMEL ENAMEL NATURAL ENAMEL ENAMEL
204	MASTER SHOWER	7' 6"	TILE	TILE	TILE	-	-	-	-
205	STUDY	SLOPING 7' 11"	ACTIVE/GYP. BD.	WALNUT PLYWD	CORK	WALNUT	WALNUT	WALNUT	WALNUT SHELVING - TOPS & DETAILING
206	STUDY WARDROBE	-	PLY WOOD	FIR PLYWOOD	CORK	WALNUT	WALNUT	-	HANGING ROD BOTH SECTIONS REMOVED
207	FAMILY ROOM	7' 6"	ACTIVE/GYP. BD.	WALNUT PLYWD	CORK	WALNUT	WALNUT	-	HEAVY TIMBER IN EXT. WALL - CYPRESS
208	ENTRY PASSAGE	SLOPING 7' 11"	ACTIVE/GYP. BD.	WALNUT PLYWD	CORK	WALNUT	WALNUT	WALNUT PLYWD	HEAVY TIMBER IN EXT. WALL - CYPRESS
209	LIVING-DINING	SLOPING 7' 11"	ACTIVE/GYP. BD.	WALNUT PLYWD	CORK	WALNUT	WALNUT	WALNUT PLYWD	HEAVY TIMBER IN EXT. WALL - CYPRESS
210	KITCHEN	7' 6"	ACTIVE/GYP. BD.	WALNUT PLYWD	QUARRY TILE	WALNUT	WALNUT	WALNUT PLYWD	-
211	HALL	7' 6"	ACTIVE/GYP. BD.	WALNUT PLYWD	CORK	WALNUT	WALNUT	WALNUT PLYWD	-
212	HALL STORAGE	-	PLY WOOD	FIR PLYWOOD	CORK	WALNUT	WALNUT	-	NATURAL NATURAL NATURAL NATURAL
213	GUEST BEDROOM	7' 6"	ACTIVE/GYP. BD.	WALNUT PLYWD	CORK	WALNUT	WALNUT	-	NATURAL NATURAL NATURAL NATURAL
214	GUEST WARDROBE	7' 11"	GYP. BD.	GYP. BD.	CORK	WALNUT	WALNUT	-	NATURAL NATURAL NATURAL NATURAL
215	BATH	7' 11"	GYP. BD.	GYP. BD.	TILE	WALNUT	WALNUT	-	NATURAL NATURAL NATURAL NATURAL
216	SHOWER	7' 6"	TILE	TILE	TILE	-	-	-	-
217	RIKAY'S BEDROOM	SLOPING 7' 11"	ACTIVE/GYP. BD.	WALNUT PLYWD	CORK	WALNUT	WALNUT	WALNUT PLYWD	-
218	RIKAY'S WARDROBE	7' 11"	GYP. BD.	GYP. BD.	CORK	WALNUT	WALNUT	-	NATURAL NATURAL NATURAL NATURAL
219	MECHANICAL ROOM	8' 11"	GYP. BD.	GYP. BD.	CONCRETE	CYPRESS	CYPRESS	-	POINT NATURAL NATURAL NATURAL
220	CARPENTERS	-	-	-	CONCRETE	CYPRESS	CYPRESS	-	POINT NATURAL NATURAL NATURAL
221	CARPENTERS	-	-	-	CONCRETE	CYPRESS	CYPRESS	-	POINT NATURAL NATURAL NATURAL
222	CARPENTERS	-	-	-	CONCRETE	CYPRESS	CYPRESS	-	POINT NATURAL NATURAL NATURAL

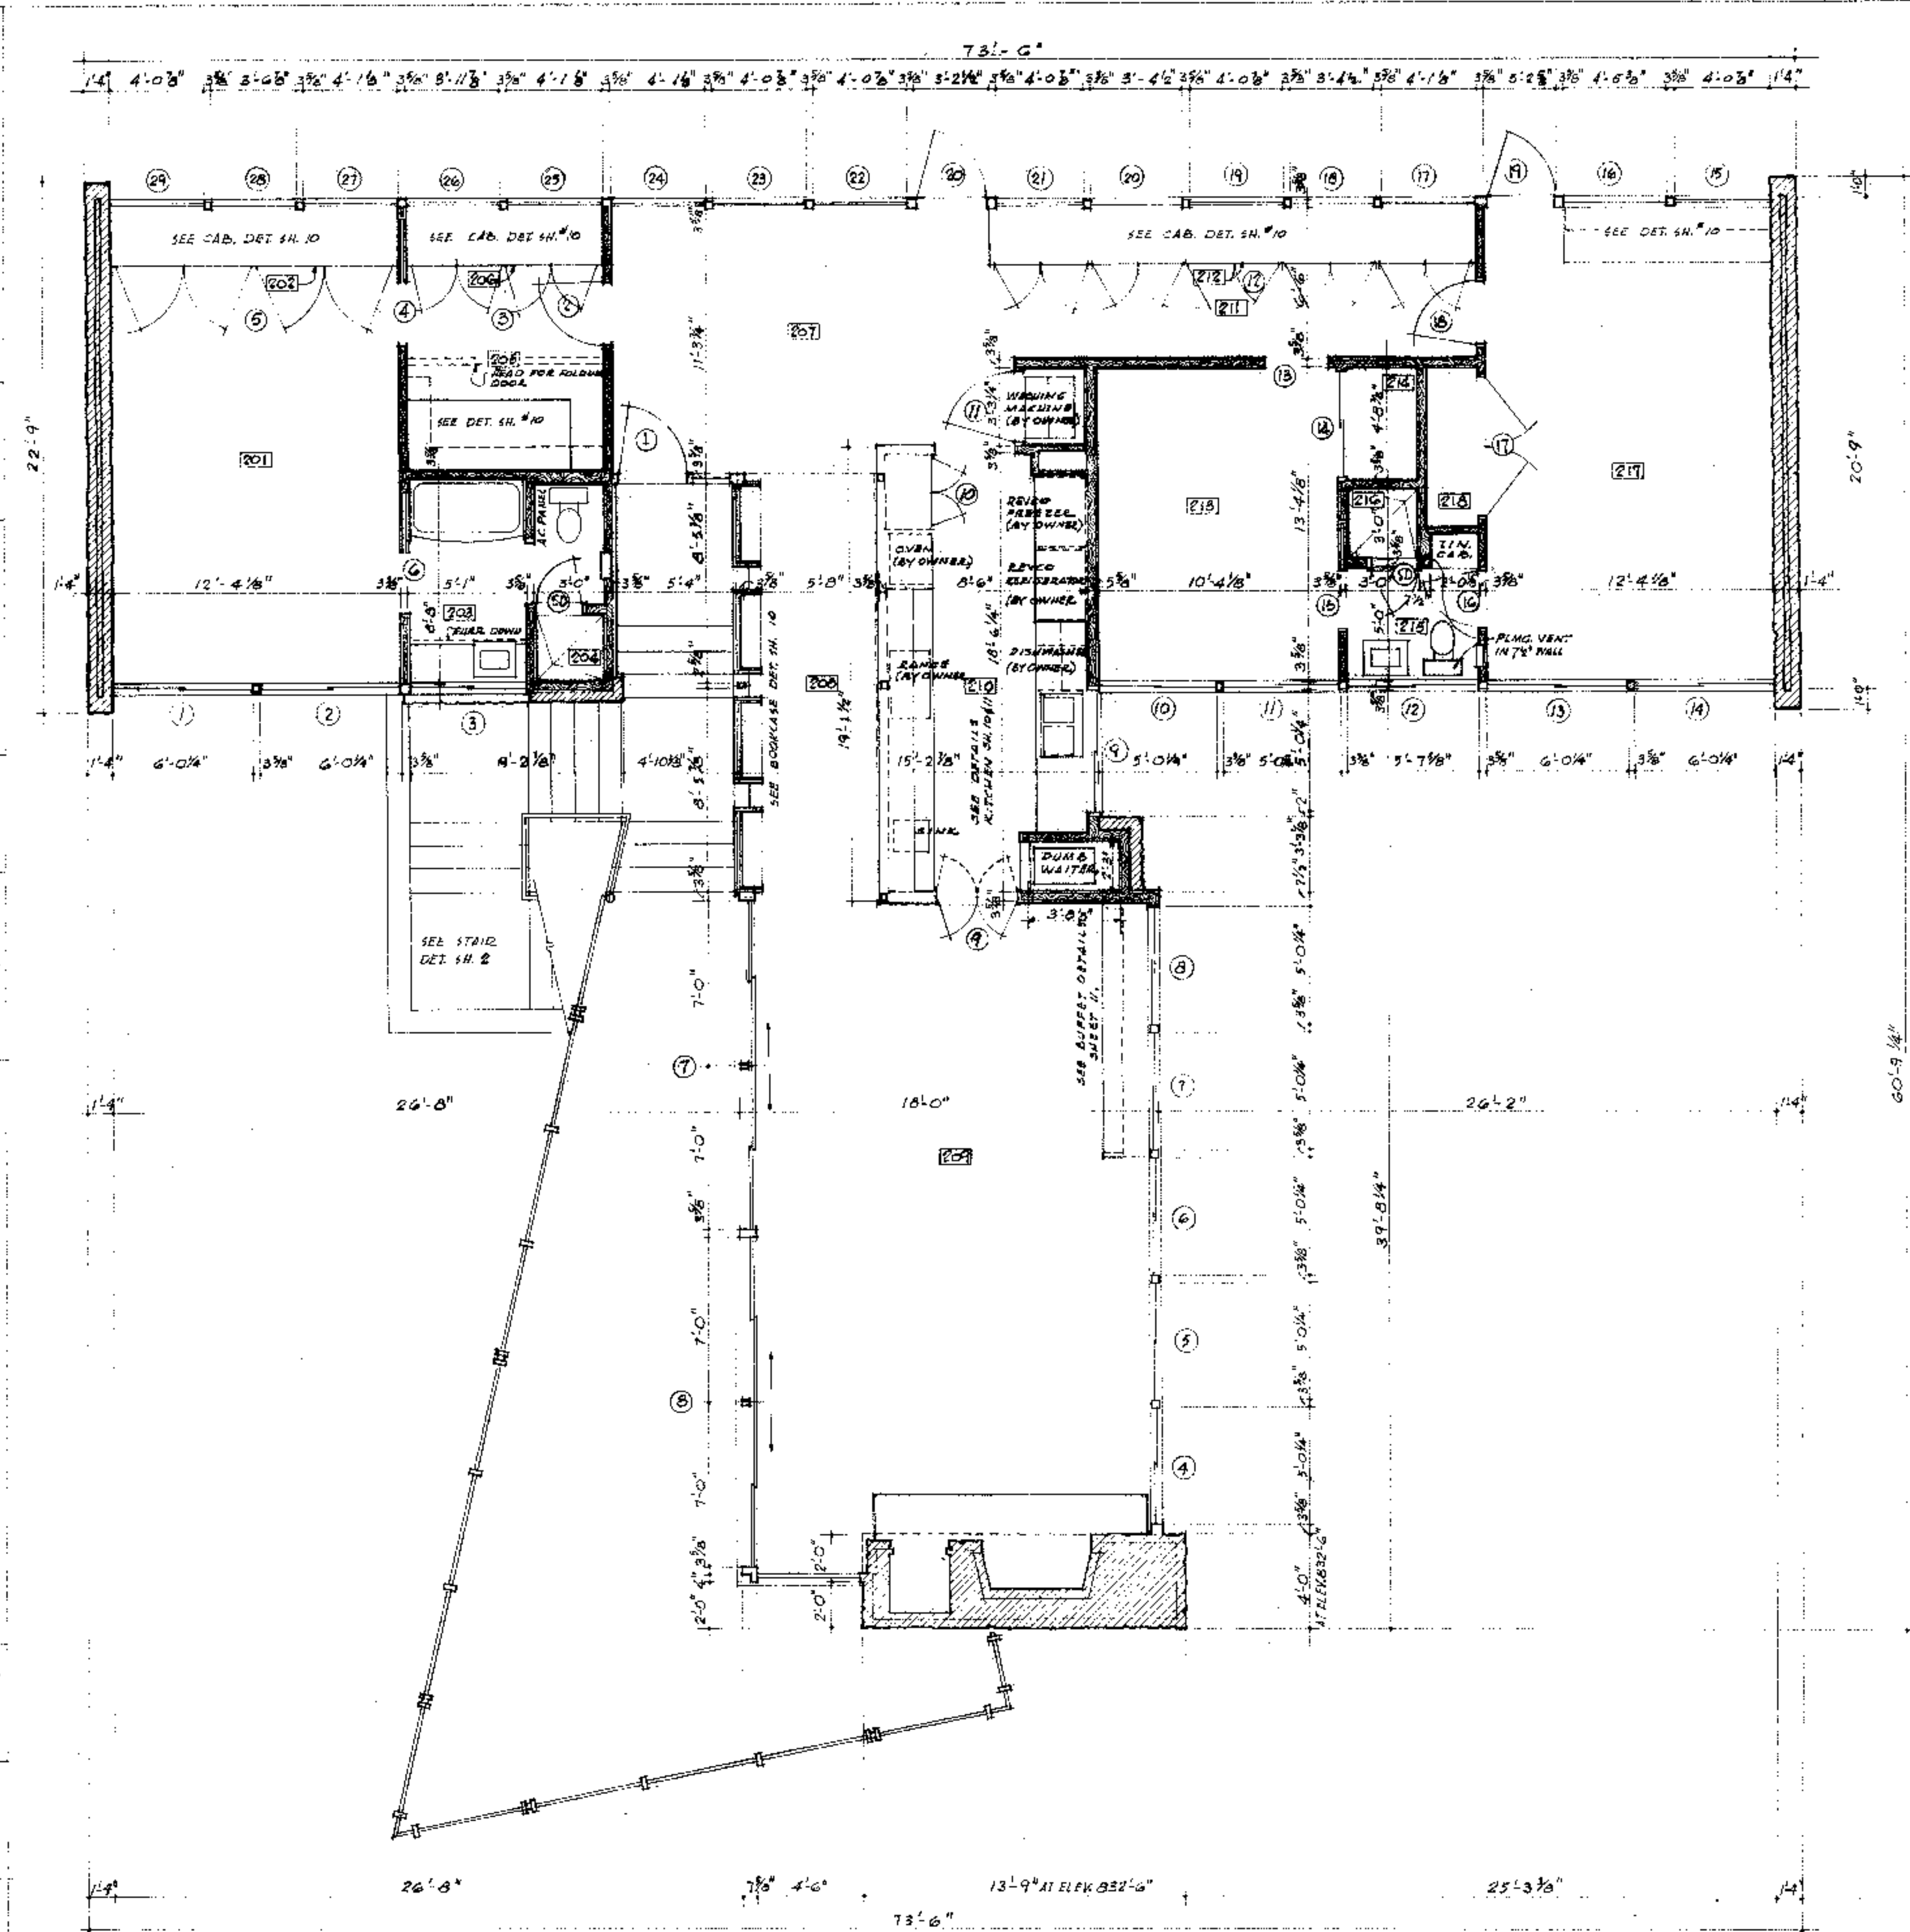[illegible]

UPPER LEVEL FLOOR PLAN

SCALE $\frac{1}{4}" = 1'-0"$

NOTE:
ITEMS INDICATED AS BEING FURNISHED BY THE OWNER SHALL BE RECEIVED, STORED & INSTALLED BY THE GENERAL CONTRACTOR. ITEMS REQUIRING ELECTRICAL OR PLUMBING CONNECTIONS SHALL BE PROPERLY CONNECTED BY THAT CONTRACTOR.

WM. H. HIDE LL, JR.
A R C H I T E C T
3010 BLACKBURN ST. DALLAS 4, TEXAS
A RESIDENCE FOR
MR. & MRS. R. R. HIDE LL
AUSTIN TEXAS

JOB NO.	DATE	DRAWN BY	CHECKED BY	SHEET NO.
602	9-1-56	A	H	OF 16




SERIAL NO. 368

5

(Roof Framing 4)

5

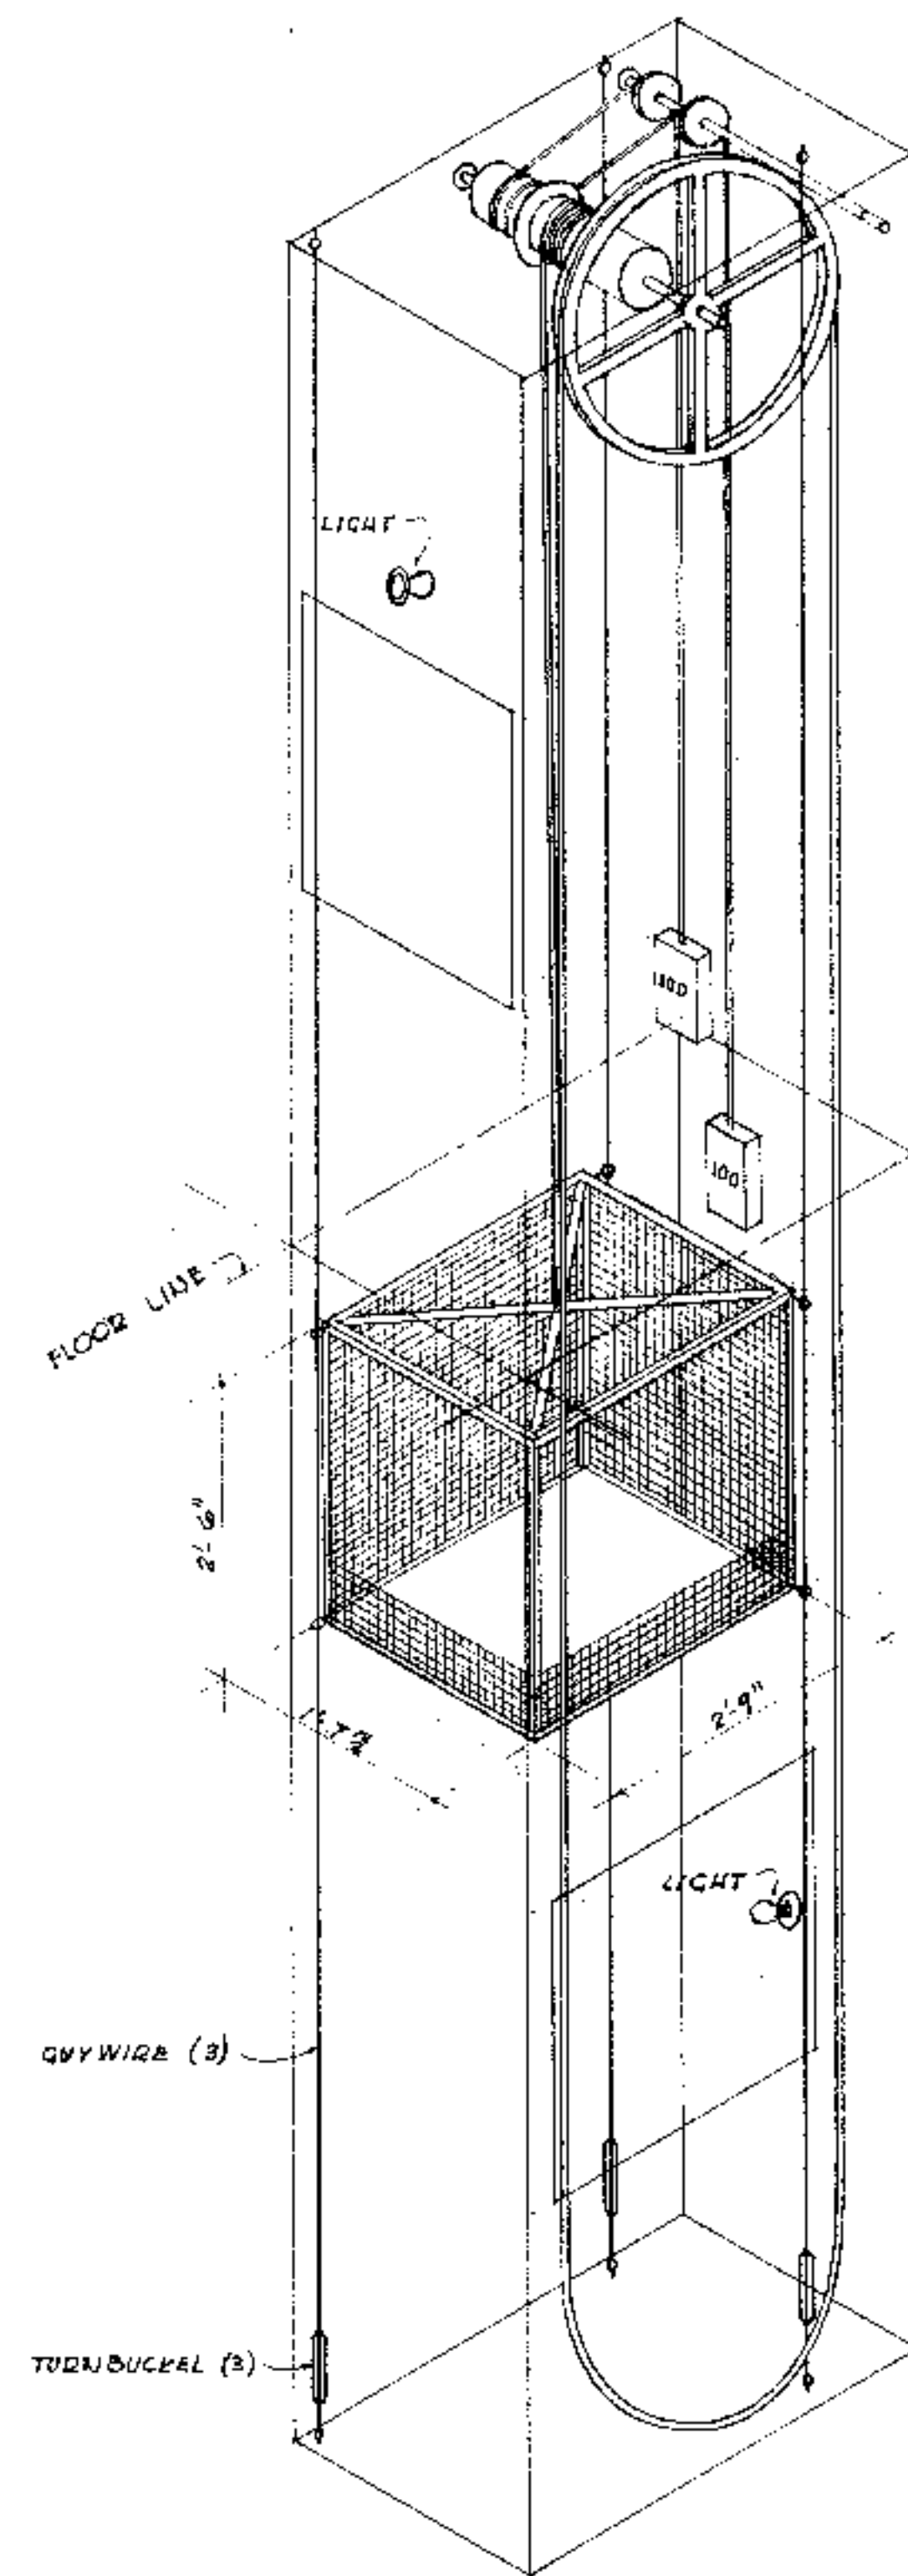

PULLEY'S FOR COUNTER WEIGHTS TO BE FREE TO ROTATE INDEPENDENTLY.


NOTE: WEIGHTS TO BE 100 LBS. EACH. USE 1/8" AIRPLANE CABLES FOR HANGING.

NOTE: CAGE TO BE CONSTRUCTED OF 1"x1" L² TO FORM THE FRAME. BOTTOM TO BE 3/4" PLYWOOD. SIDES, AS SHOWN, TO BE OF HARDWARE CLOTH.

PULLEY ROPE TO BE OF HEAVY HEMP


GENERAL NOTE: DETAILS OF CONSTRUCTION TO BE DETERMINED BY ARCHITECT AT JOB.

SCHEMATIC ISOMETRIC DIAGRAM OF DUMB WAITER MECHANISM
SCALE: 3/4" = 1'-0"

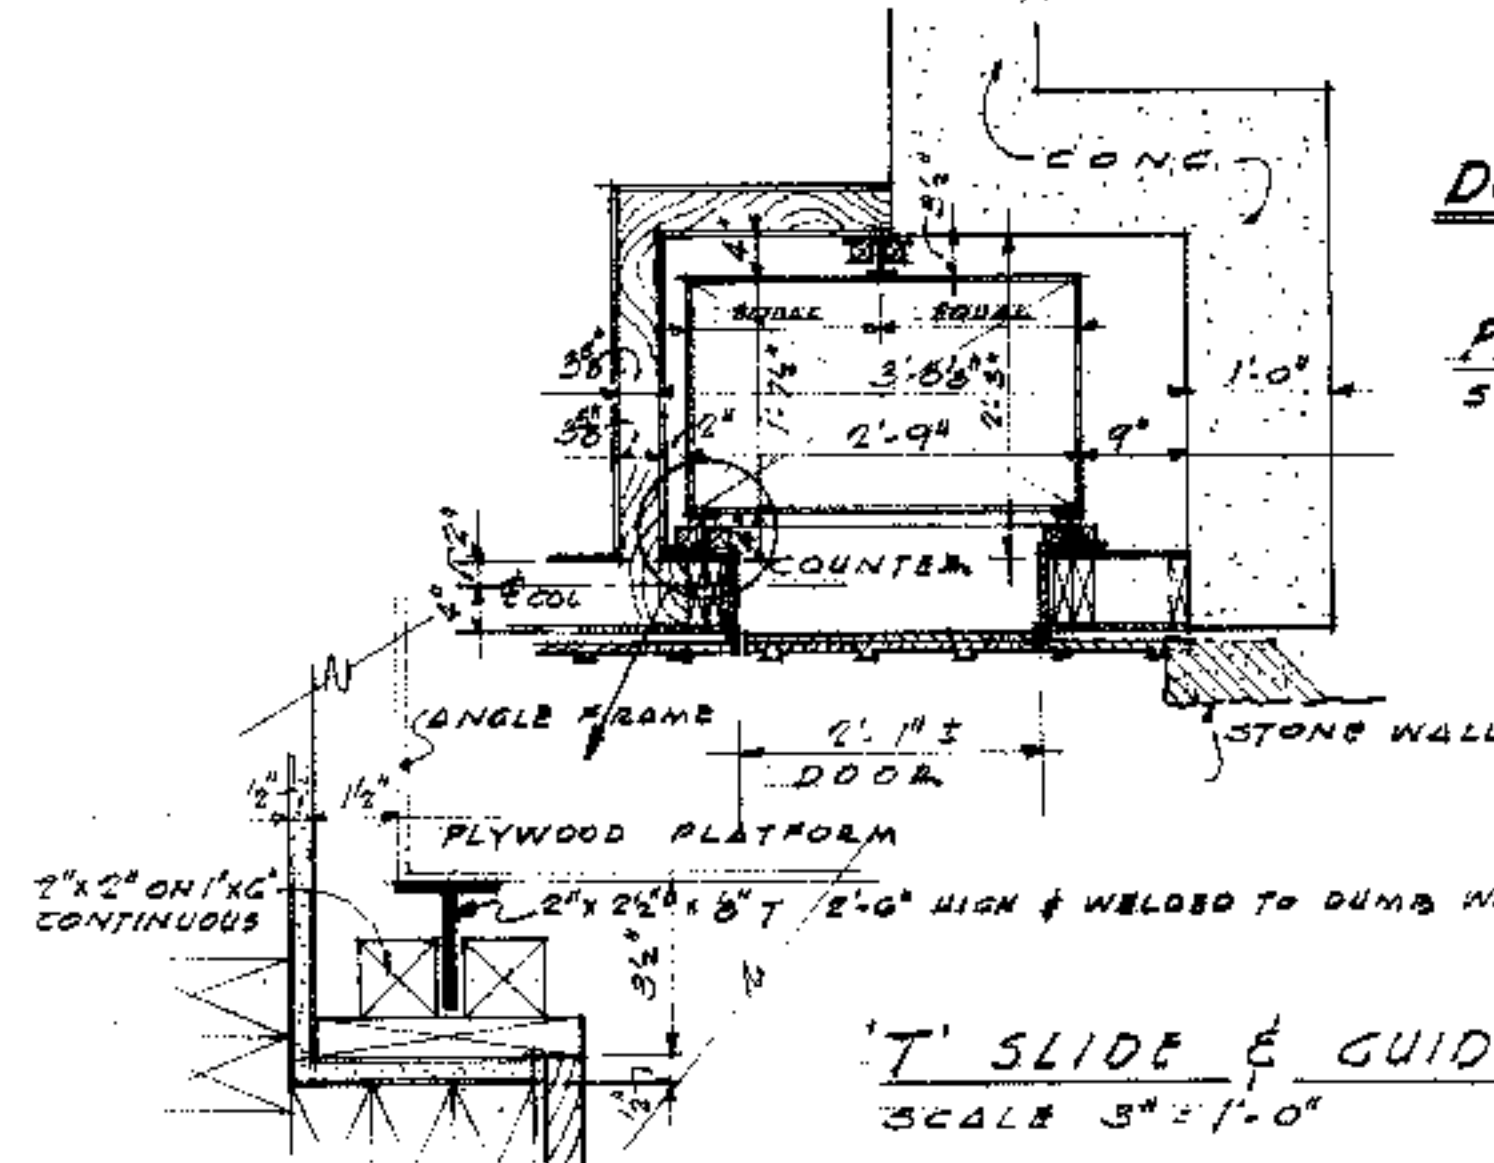

DUMB WAITER DETAILS

PLAN AT LOWER DOOR
SCALE 5/8" = 1'-0"

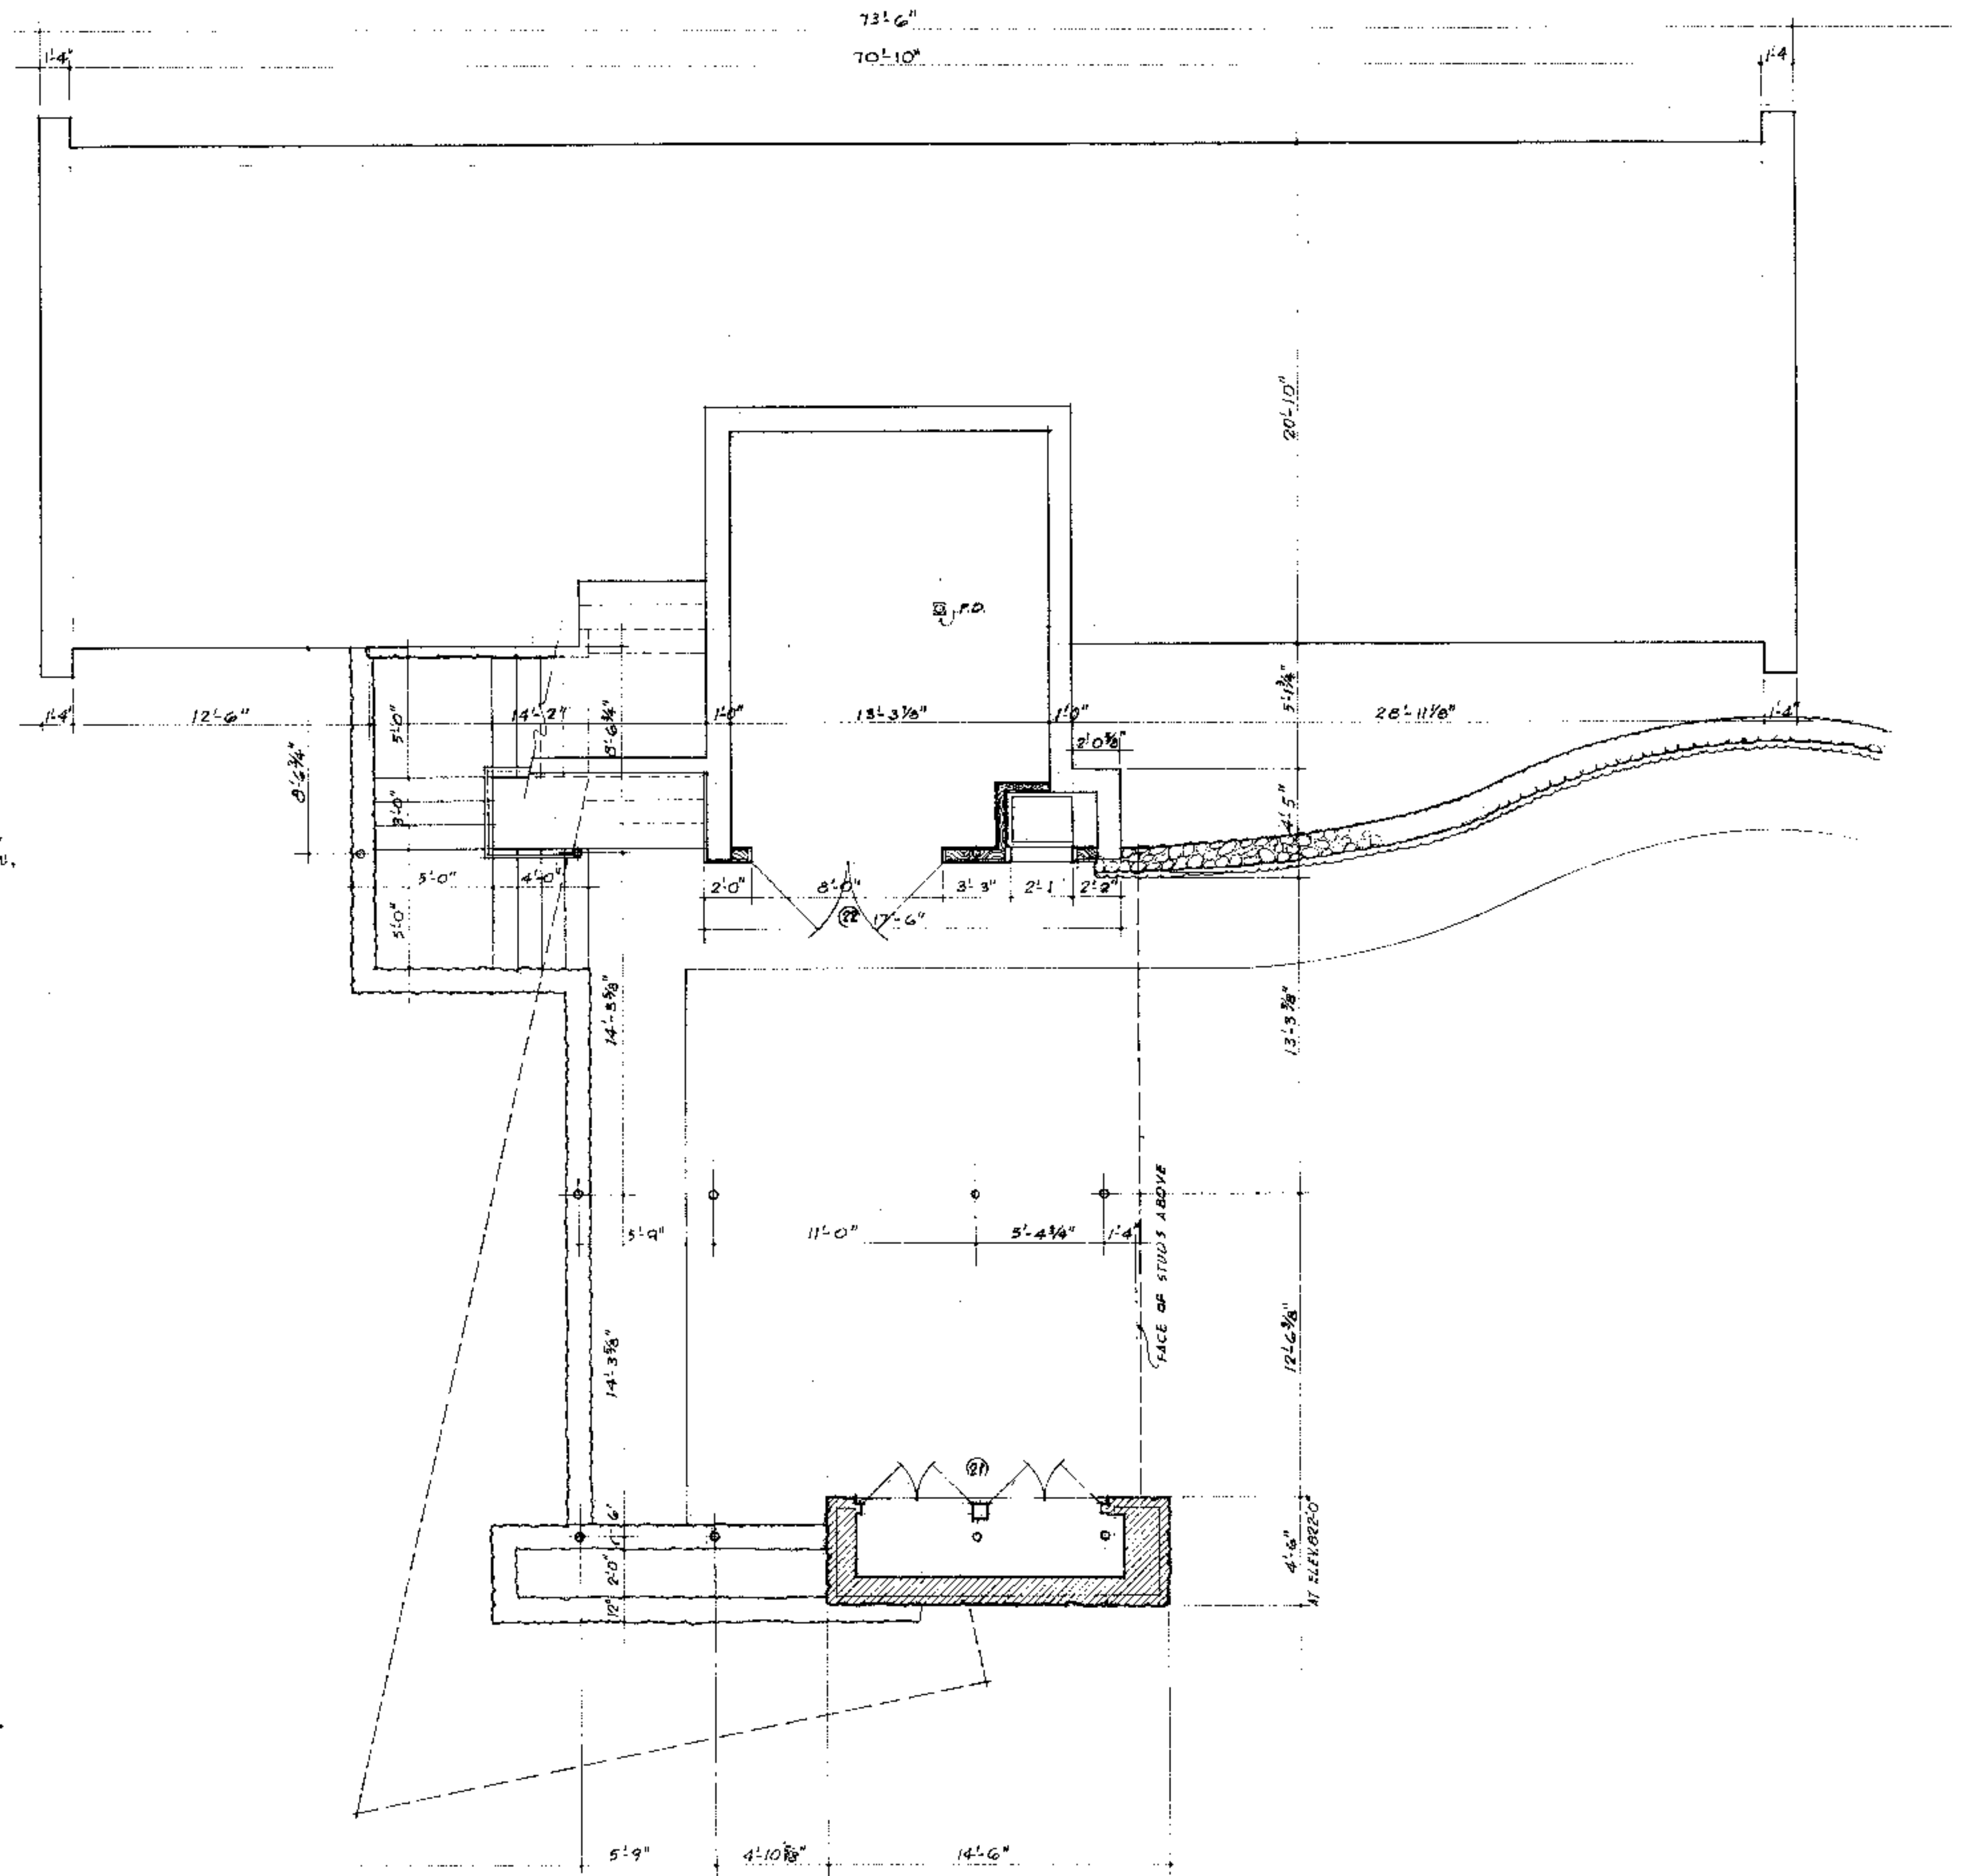


LOWER LEVEL FLOOR PLAN
SCALE: 1/4" = 1'-0"


WM. H. HIDEELL, JR.
ARCHITECT
3010 BLACKBURN ST. DALLAS 4, TEXAS
A RESIDENCE FOR
MR. & MRS. R. R. HIDEELL
AUSTIN TEXAS

JOB NO. DATE DRAWN BY CHECKED BY SHEET NO.
G02 9-1-56 A H OF 16




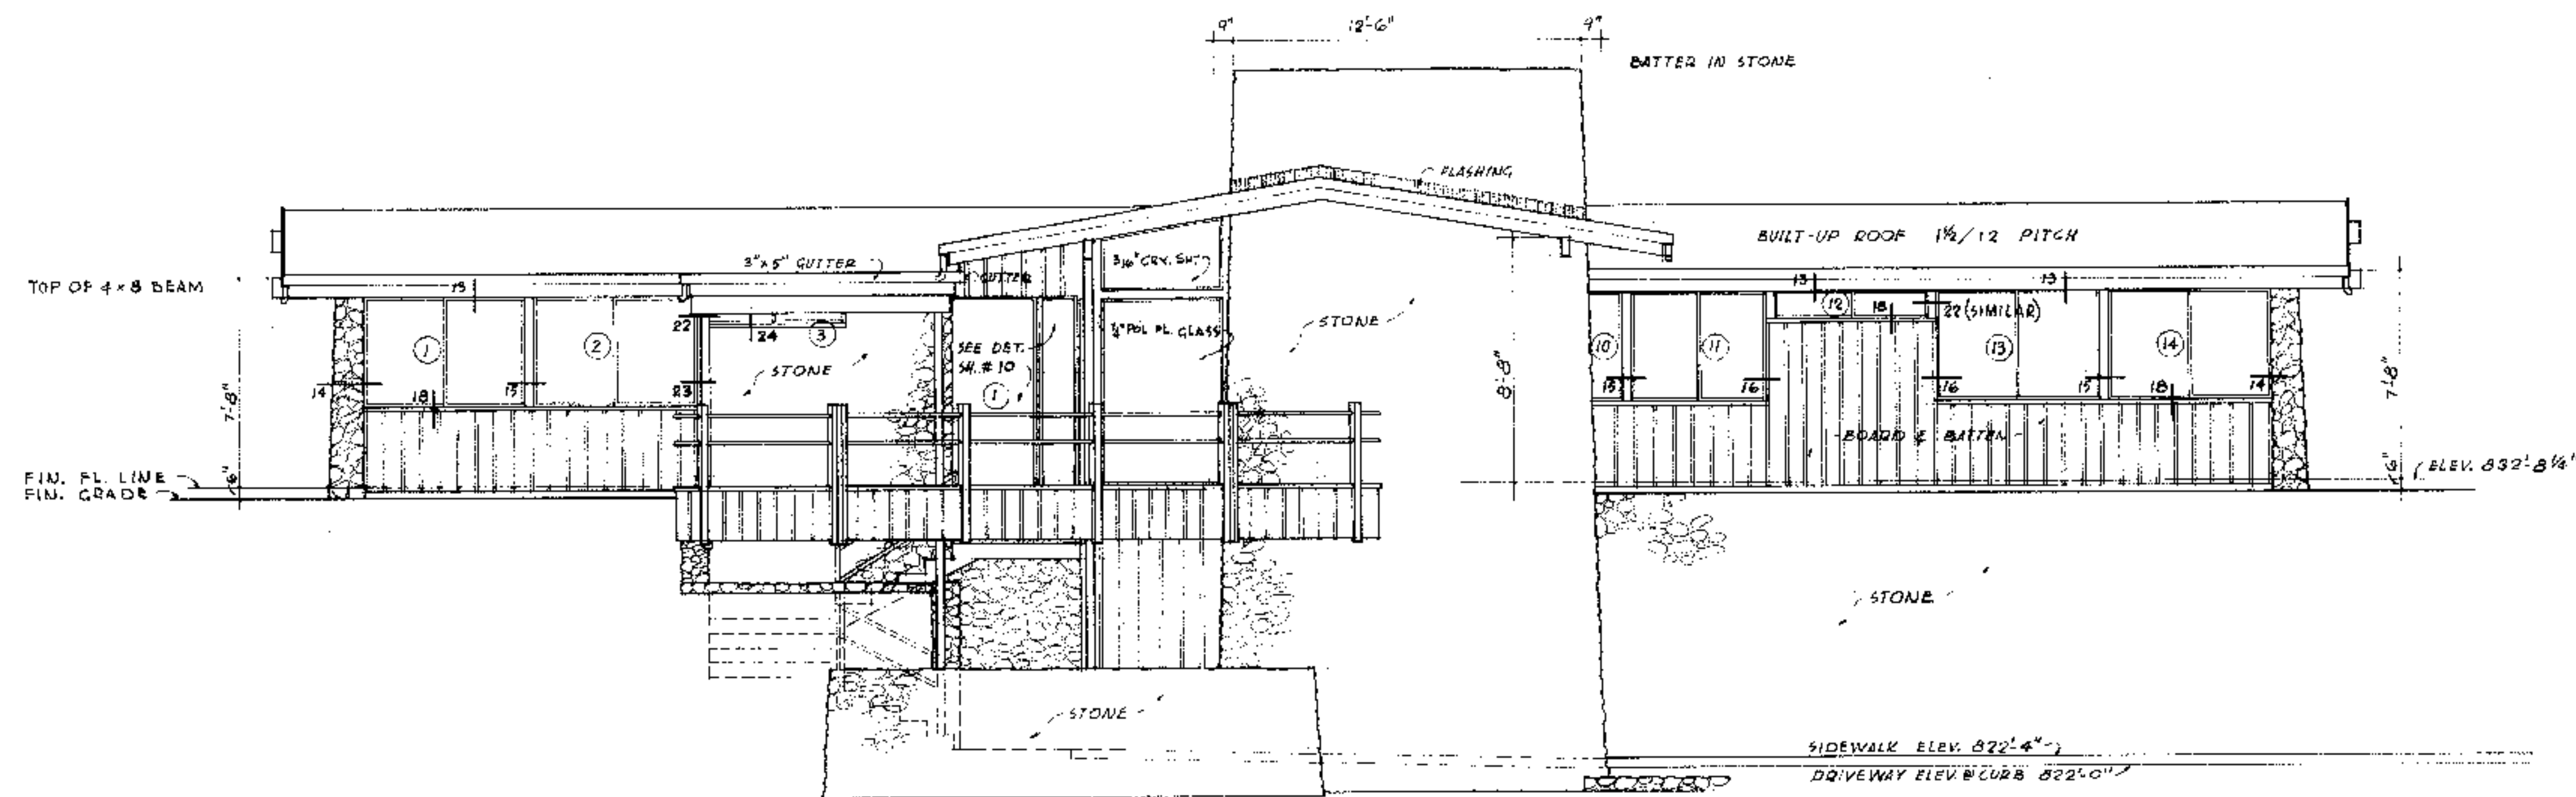


SOUTH ELEVATION
SCALE: 1/4" = 1'-0"

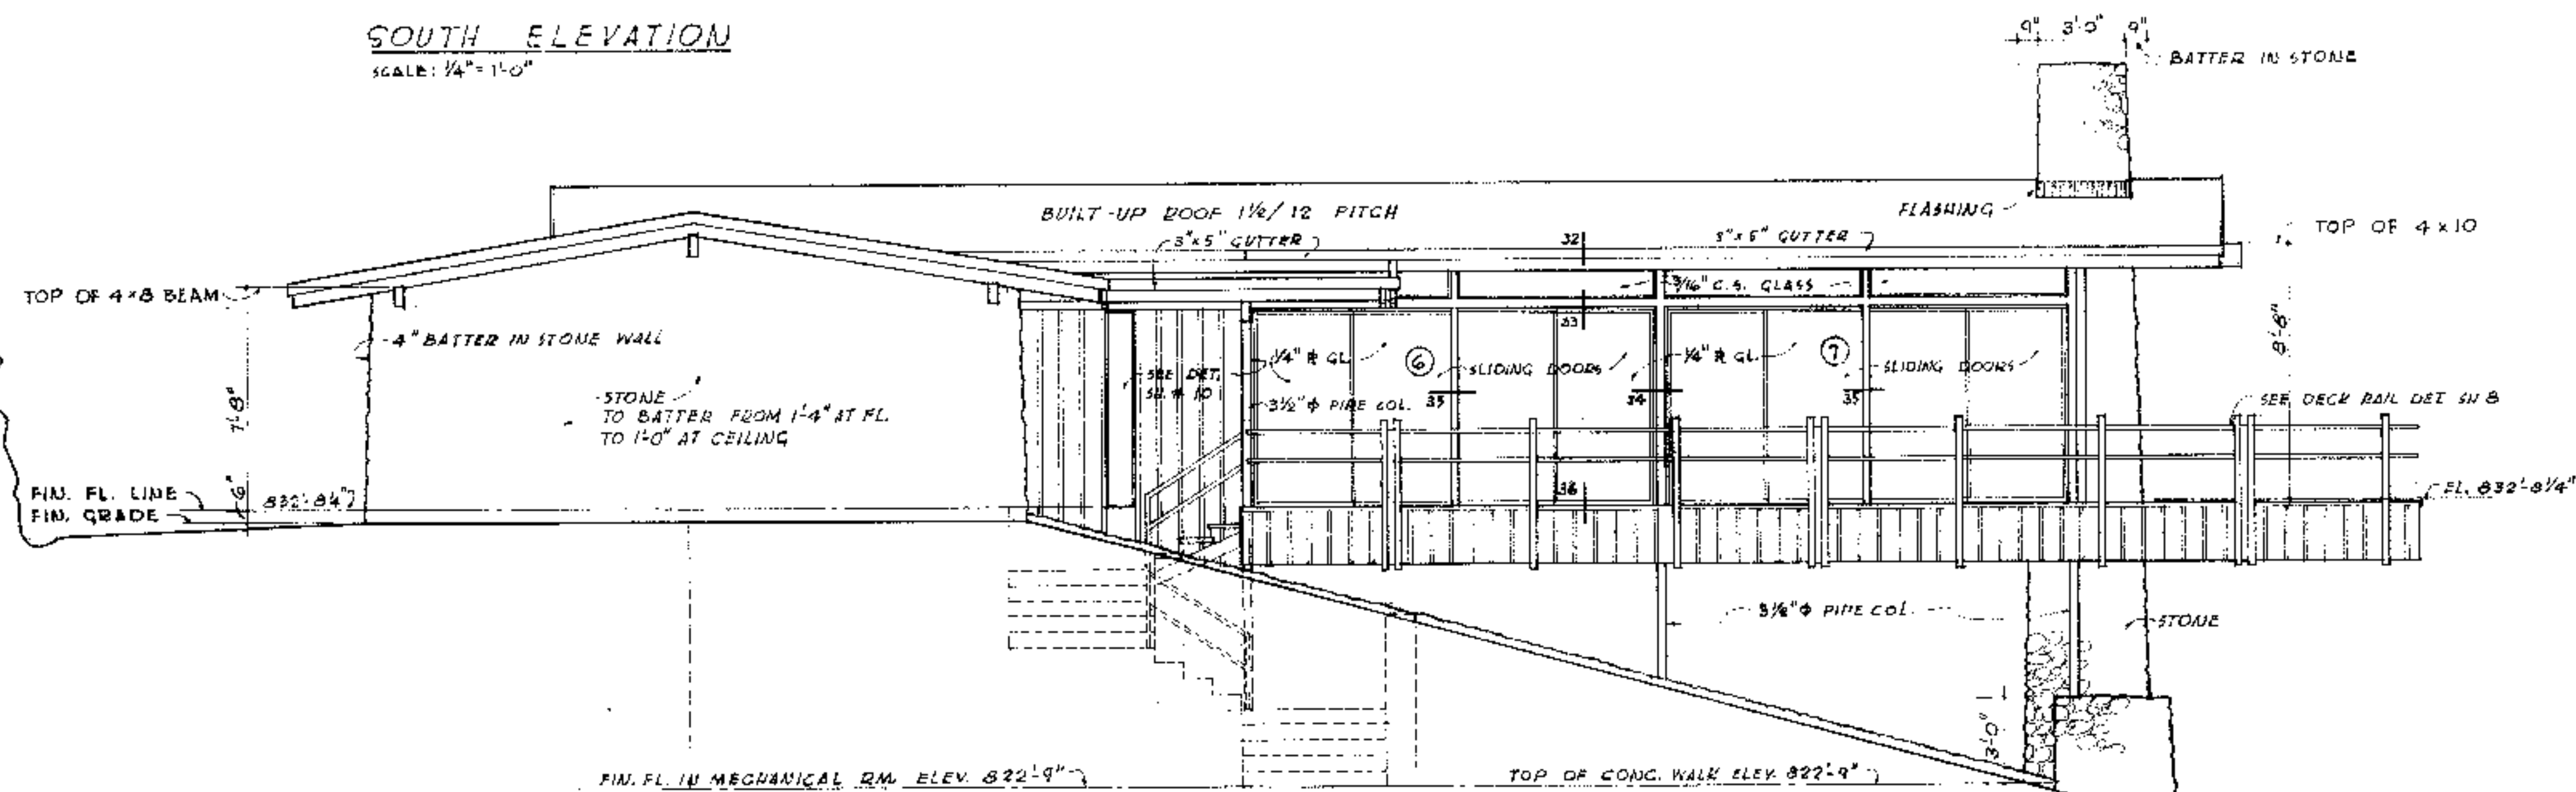

WEST ELEVATION
SCALE: 1/4" = 1'-0"

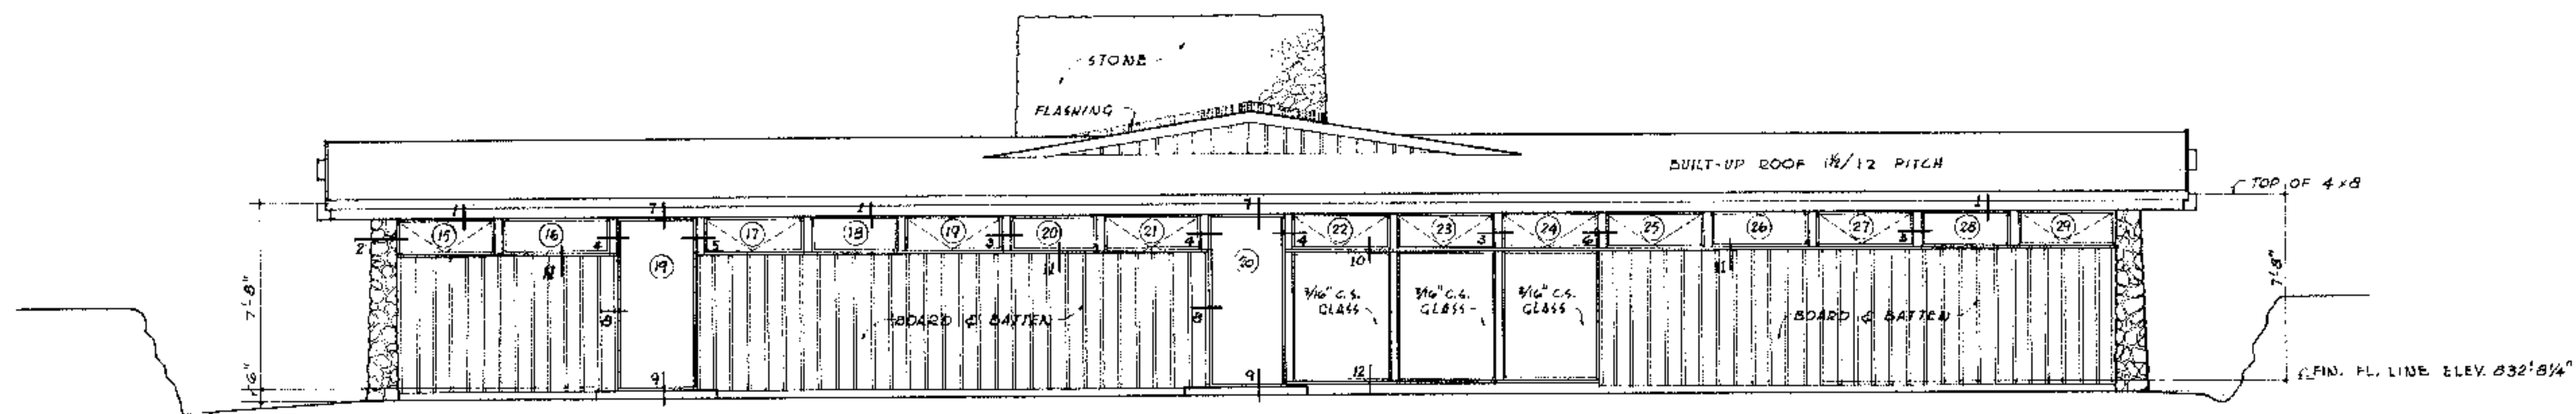

NORTH ELEVATION
SCALE: 1/4" = 1'-0"

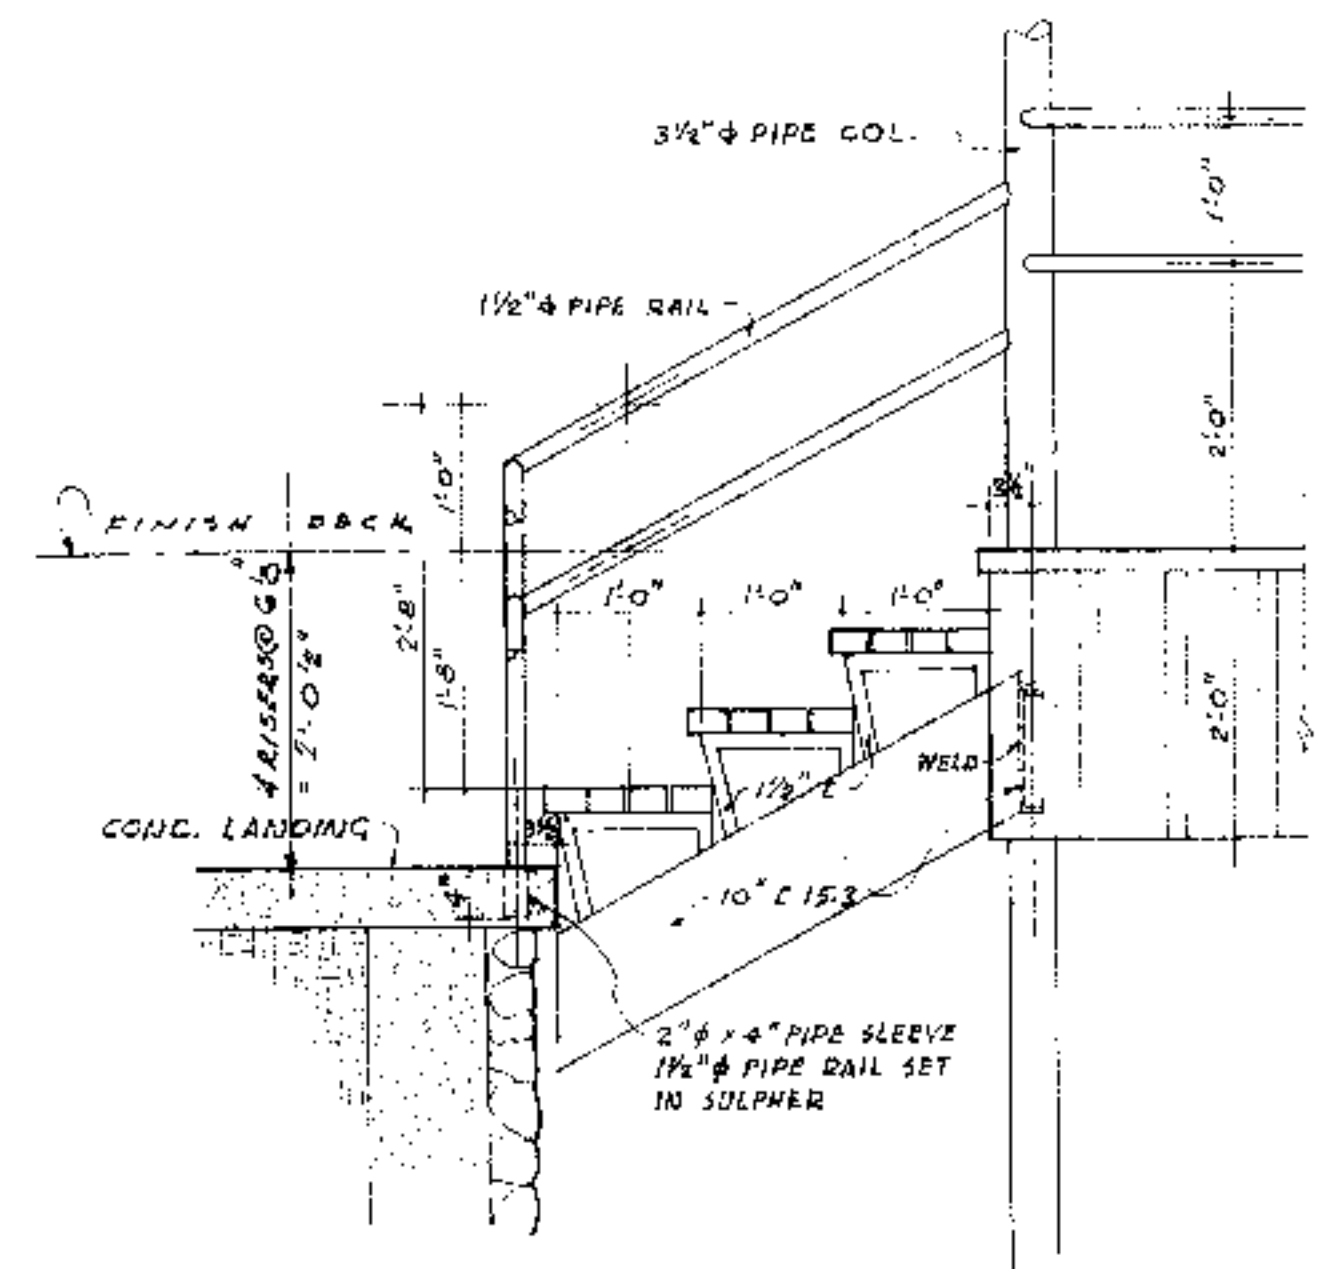


WOOD STAIR RISER DETAIL
SCALE: 3/4" = 1'-0"

WM. H. HIDEELL, JR.
ARCHITECT
3010 BLACKBURN ST. DALLAS 4, TEXAS
A RESIDENCE FOR
MR. & MRS. R. R. HIDEELL
AUSTIN, TEXAS




JOB NO. DATE DRAWN BY CHECKED BY SHEET NO.
COR 9-1-56 4 4 OF 16


W. H. Hideell, Jr.

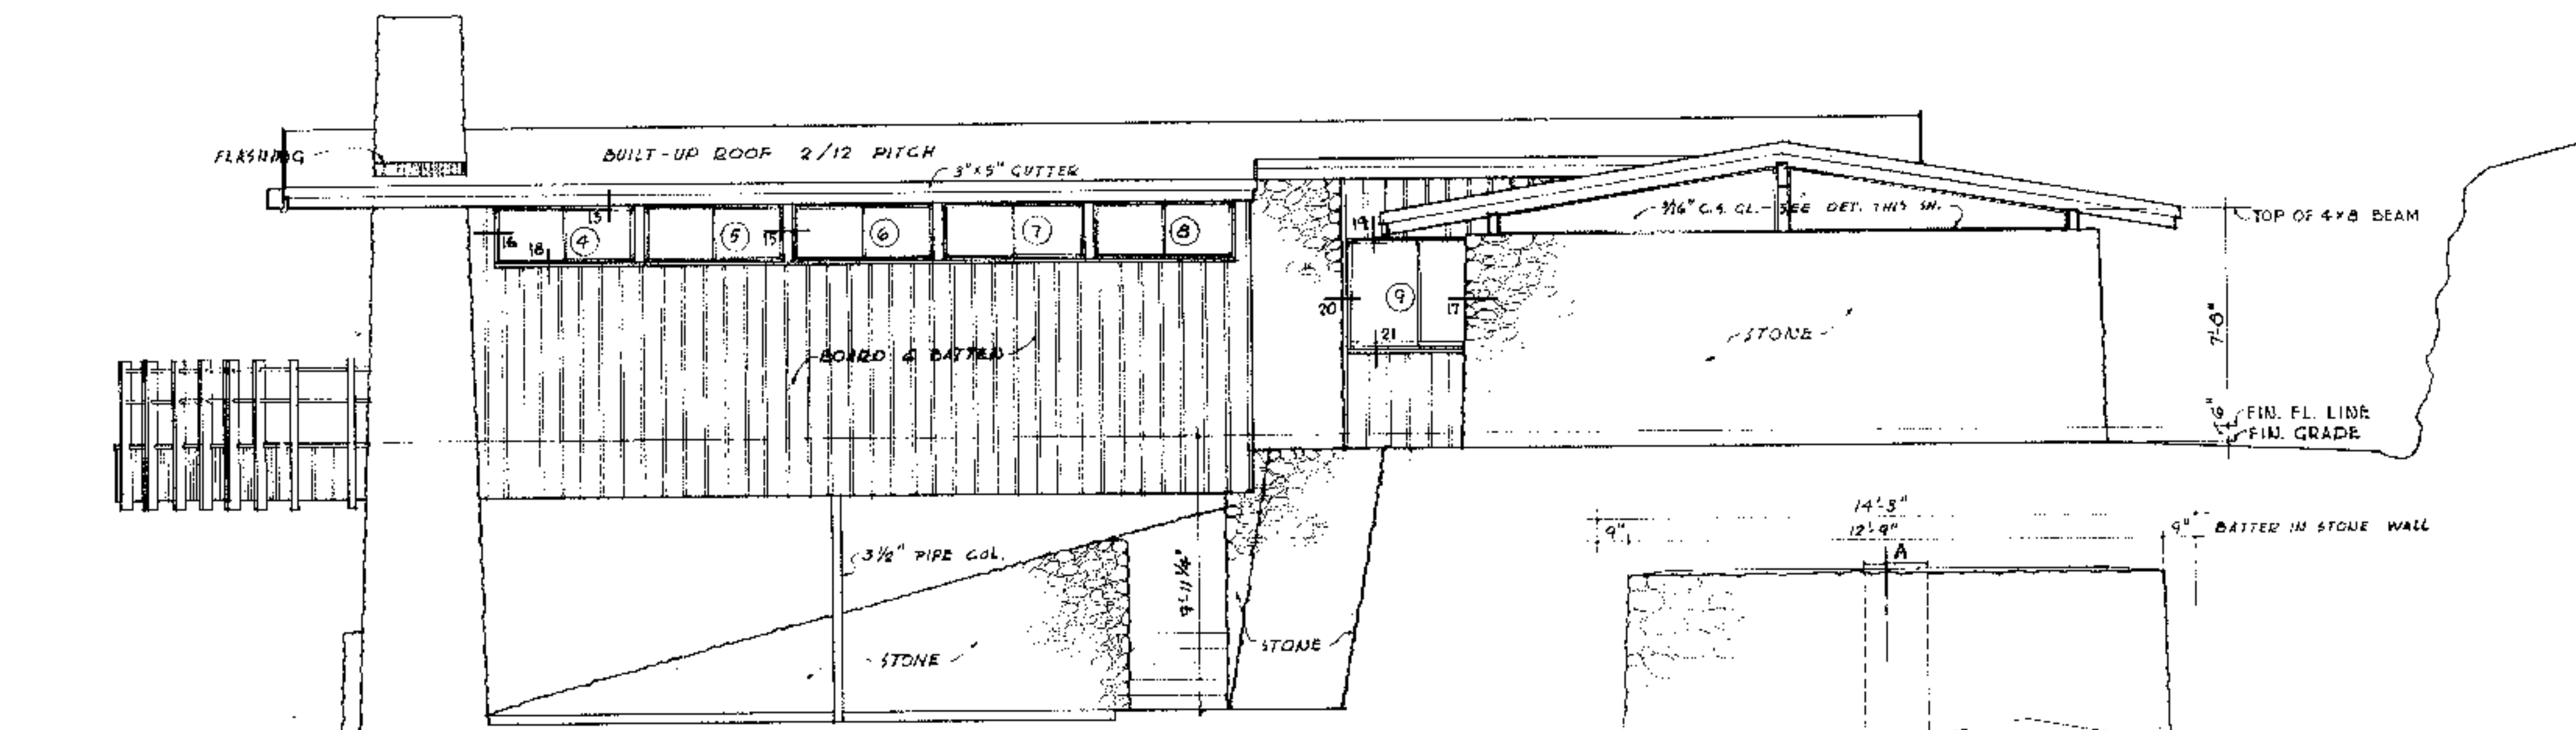


EAST ELEVATION

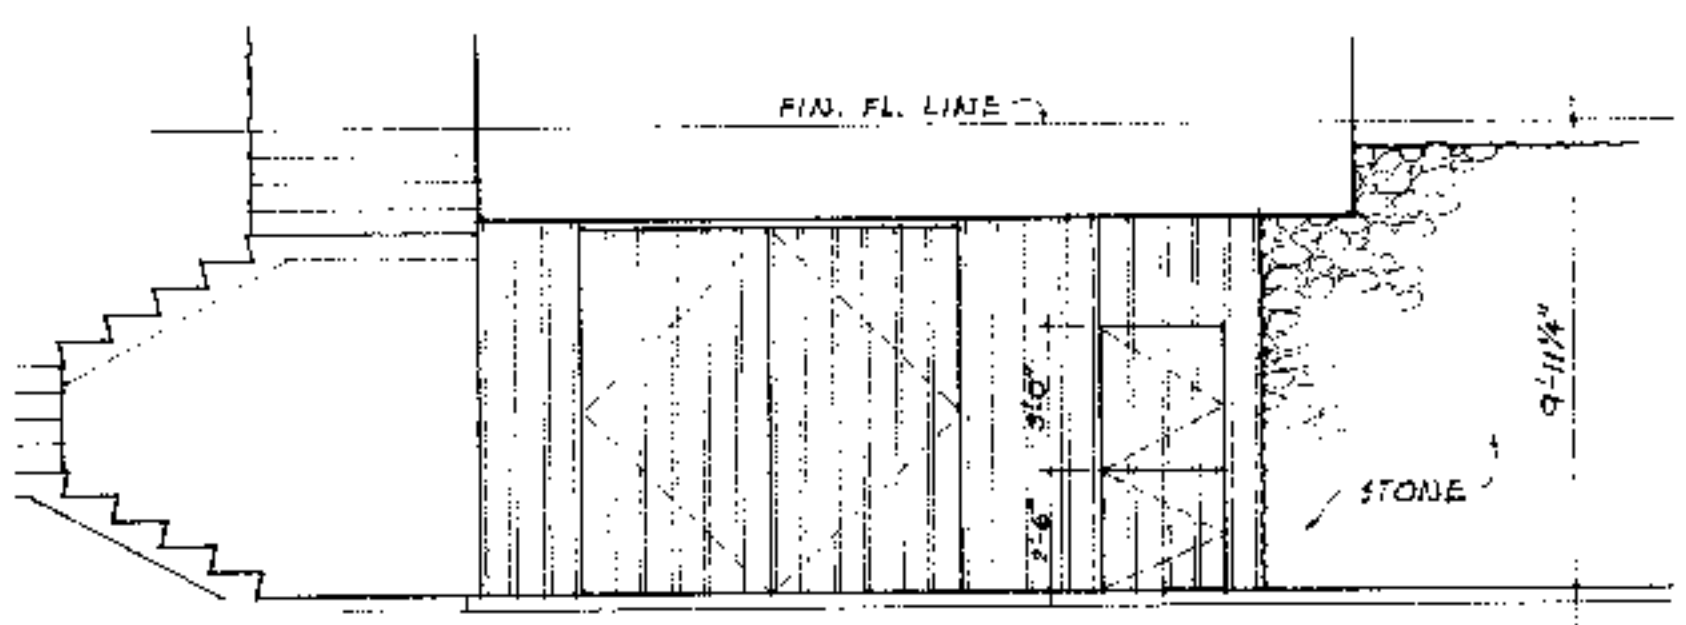


NORTH ELEVATION IN CARPORT
SCALE 1/4" = 1'-0"

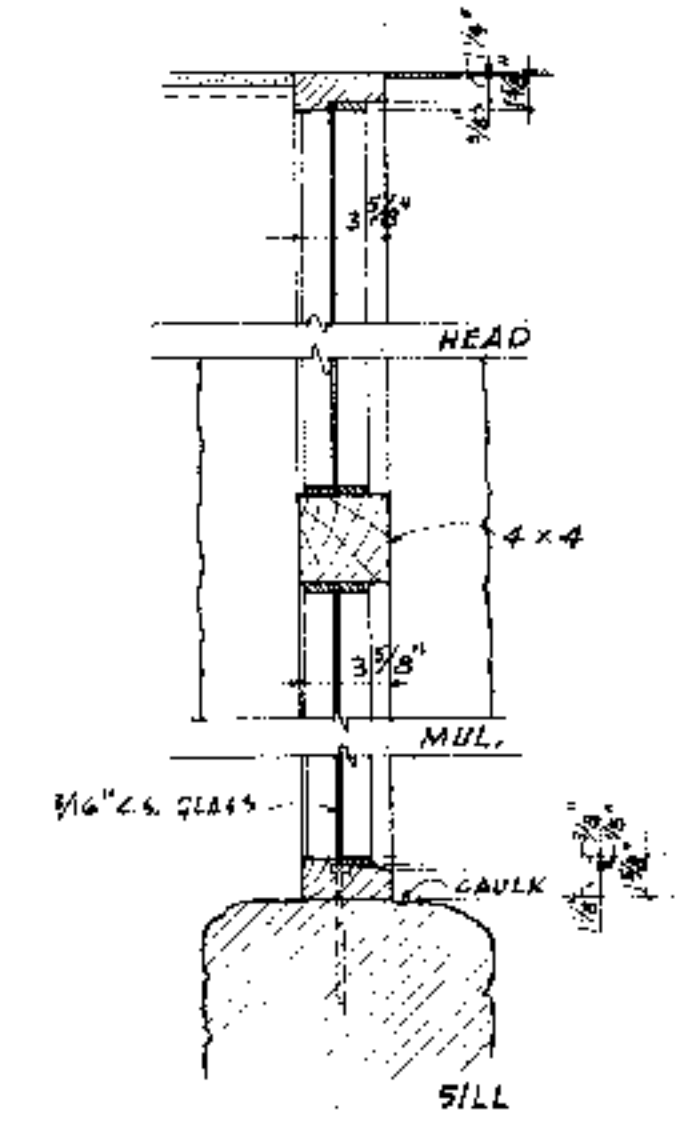



DET. OF FIXED GLASS
IN EAST GABLE
SCALE 1/2" = 1'-0"

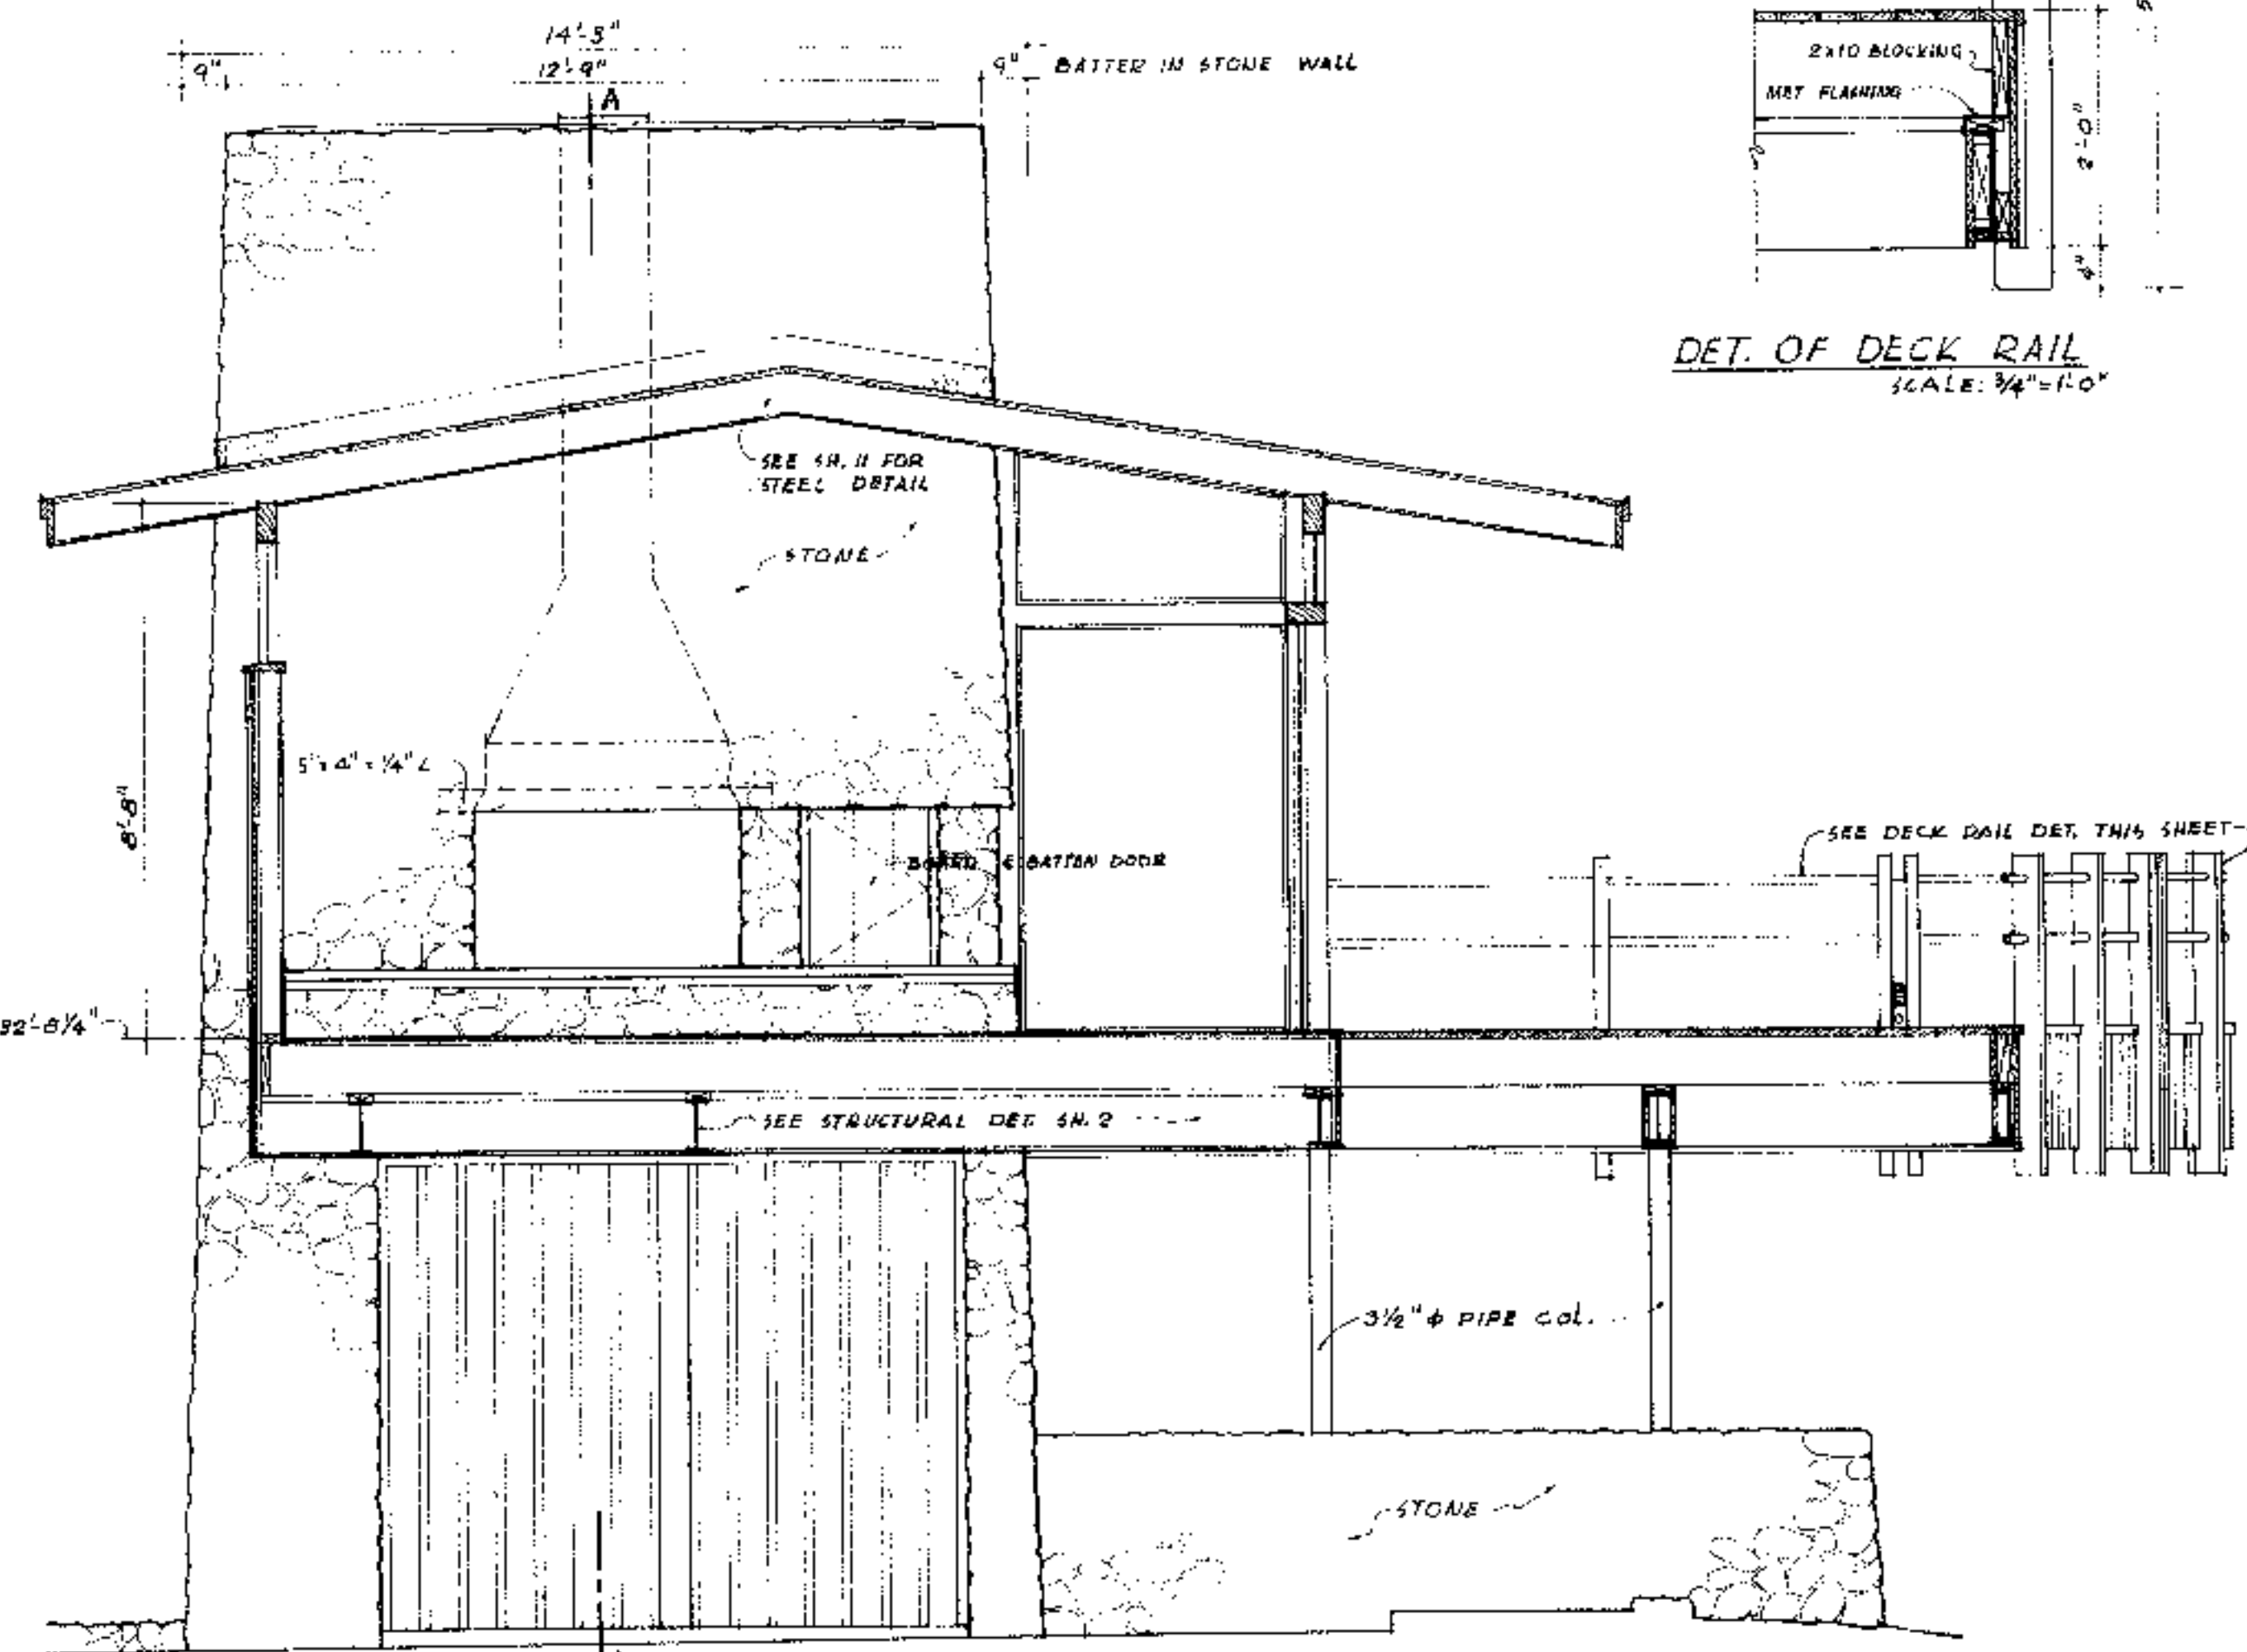

ELEVATION OF FIREPLACE & STORAGE
SCALE 3/8" = 1'-0"

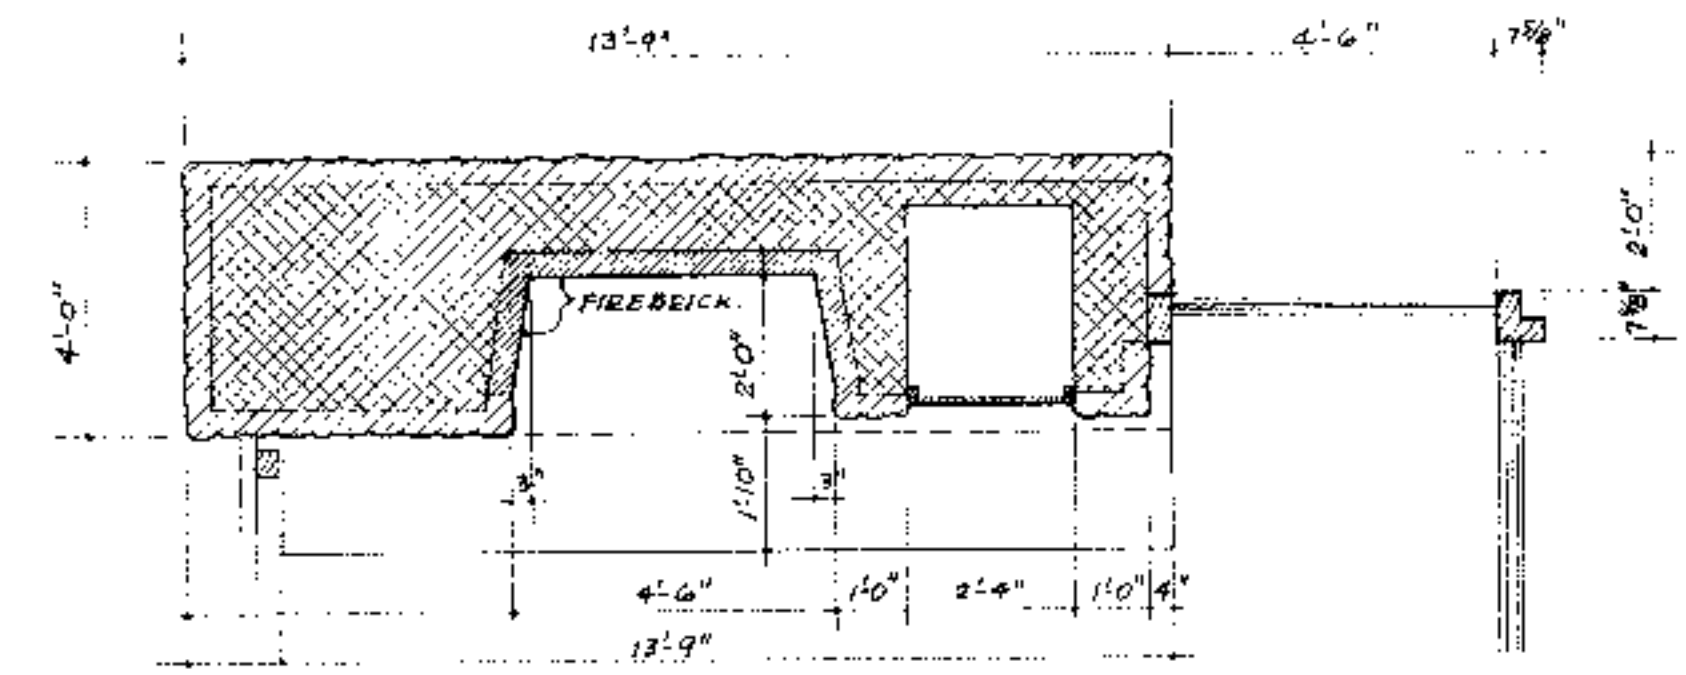

PLAN OF FIREPLACE
FIREPLACE DETAILS
SCALE 3/8" = 1'-0"

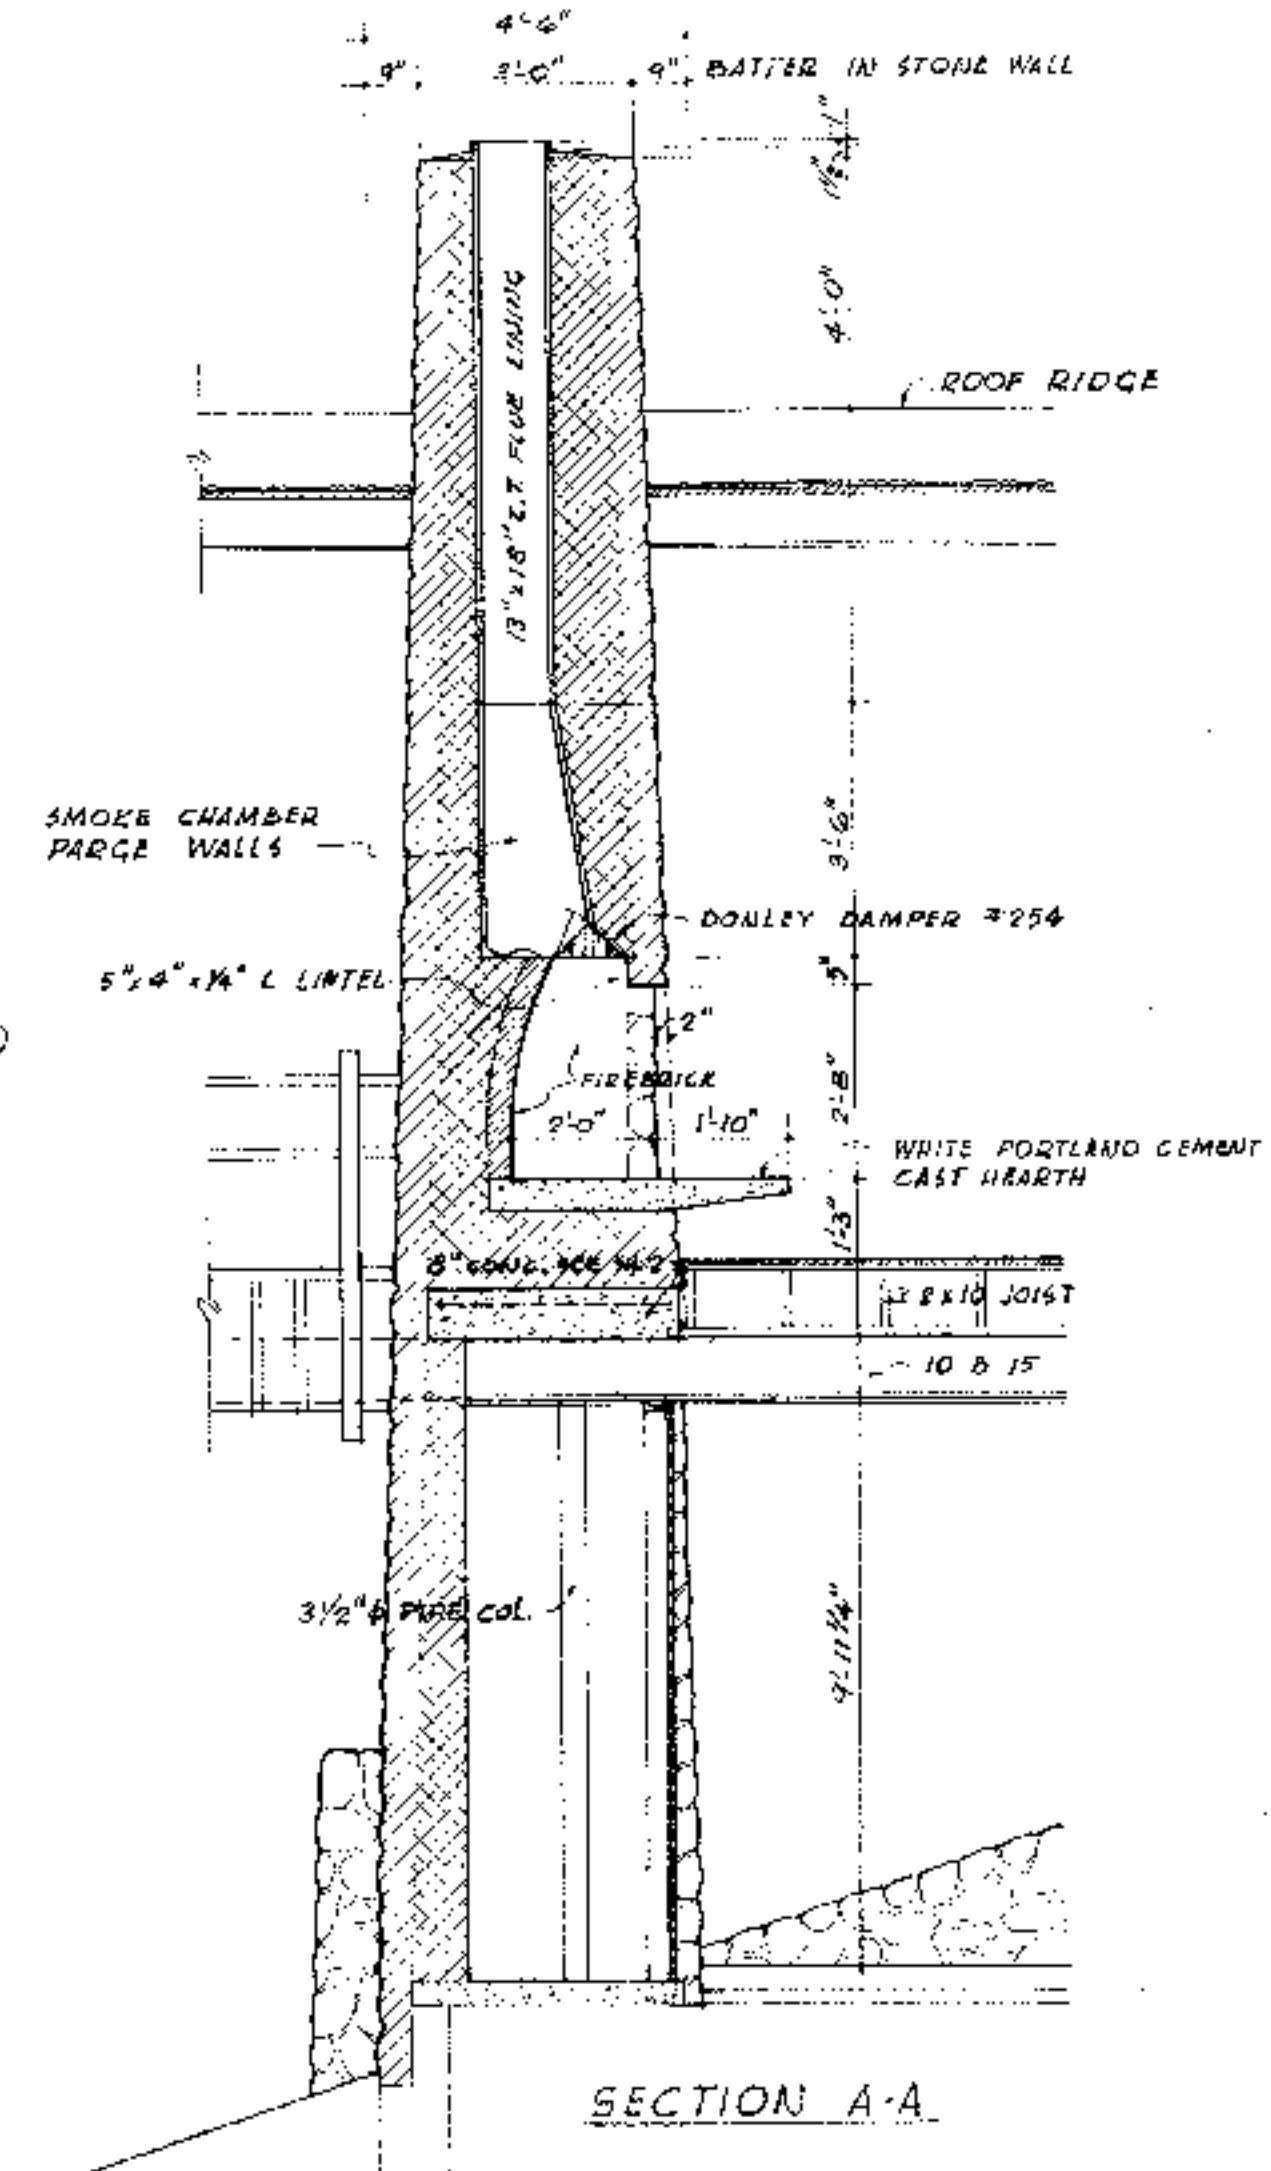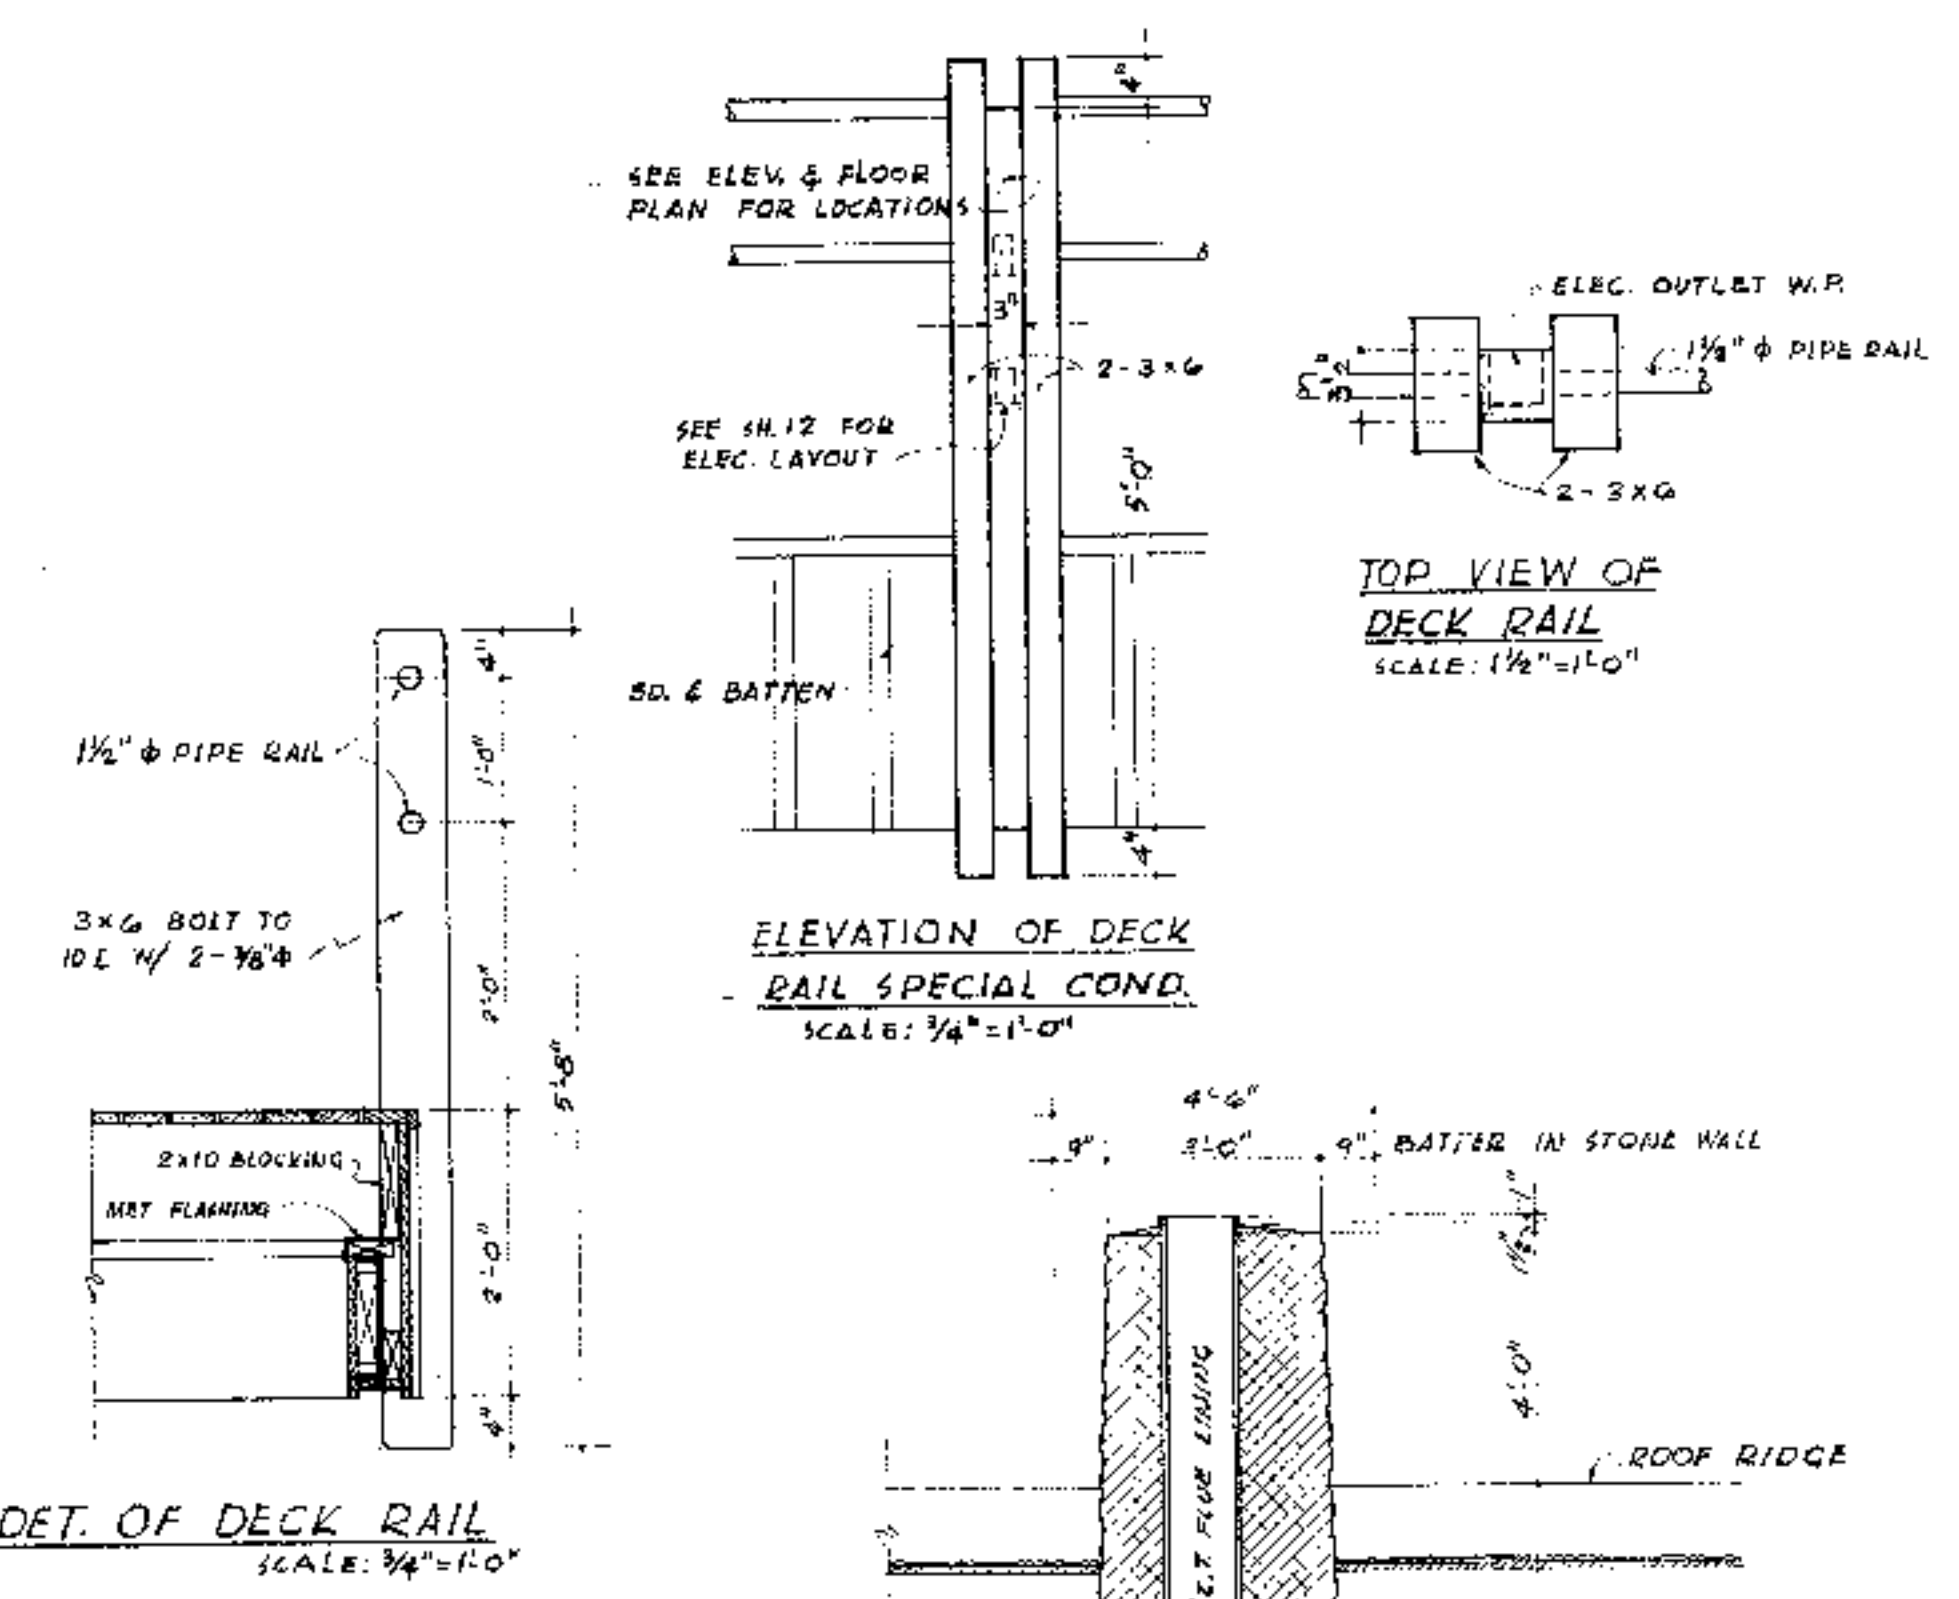

WINDOW SCHEDULE					
MARK	SIZE	TYPE	MATERIAL	GLASS	REMARKS
1, 2, 13 & 14	6'-0" x 4'-0"	SLIDING	ALUM.	D.S.A.	
9, 10 & 11	5'-0" x 4'-0"	SLIDING	ALUM.	D.S.A.	
4, 5, 6, 7 & 8	5'-0" x 2'-0"	SLIDING	ALUM.	D.S.A.	
15, 17, 19, 21, 22, 23, 24, 25, 27 & 29	4'-0 3/8" x 1'-5"	INT. PROJ.	ALUM.	D.S.B.	
3	5'-0" x 1'-0"	SLIDING	ALUM.	D.S.B.	
12	5'-7 3/8" x 1'-0"	SLIDING	ALUM.	D.S.B.	
16	4'-5 3/8" x 1'-5"	FIXED	ALUM.	D.S.B.	INT. PROJ. SECTION
18 & 20	3'-4 1/2" x 1'-5"	FIXED	ALUM.	D.S.B.	" " "
26	3'-11 3/8" x 1'-5"	FIXED	ALUM.	D.S.B.	" " "
28	3'-0 1/8" x 1'-5"	FIXED	ALUM.	D.S.B.	" " "





































DIMENSIONS ARE TO WINDOW SCHEDULE DIMENSIONS

WM. H. HIDEELL, JR.
ARCHITECT
3010 BLACKBURN ST. DALLAS 4, TEXAS
A RESIDENCE FOR
MR. & MRS. R. R. HIDEELL
AUSTIN TEXAS



Handwritten signature

JOB NO. DATE DRAWN BY CHECKED BY SHEET NO.
602 9-1-58 A H OF 16

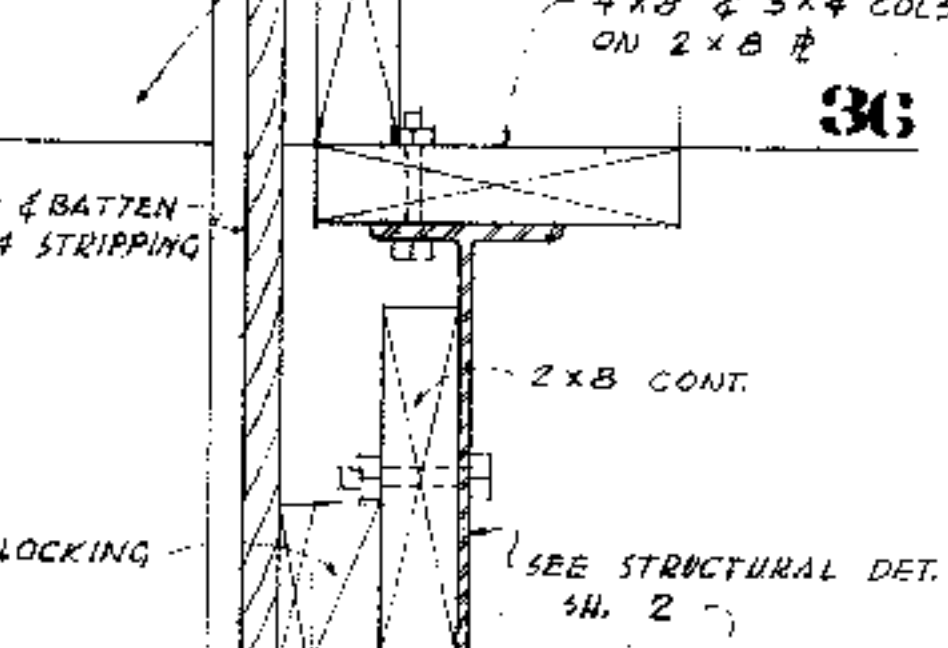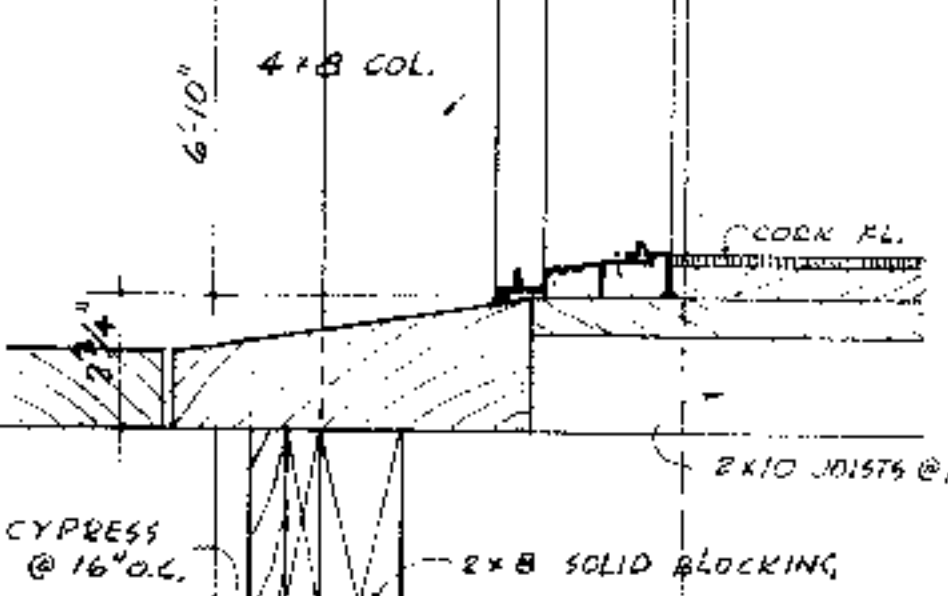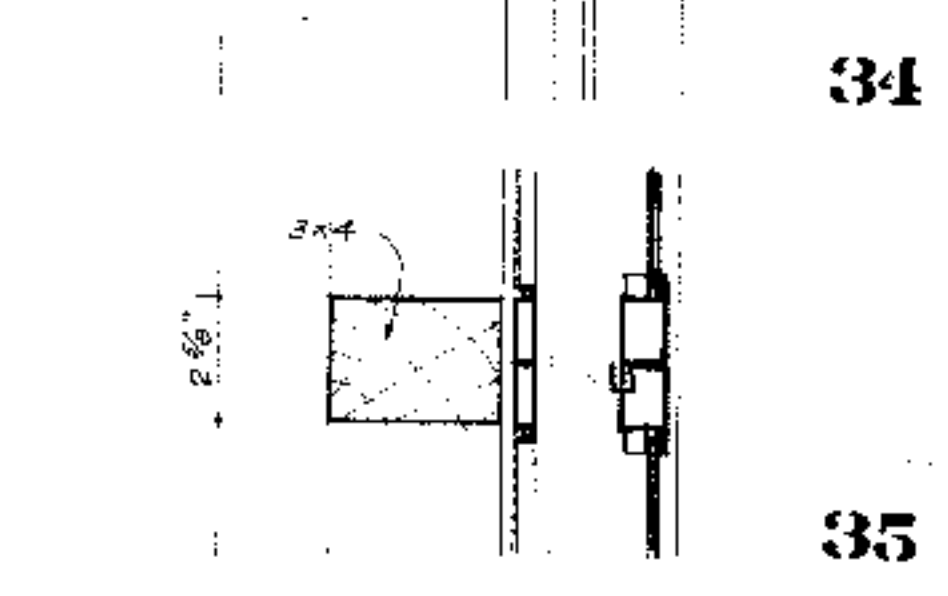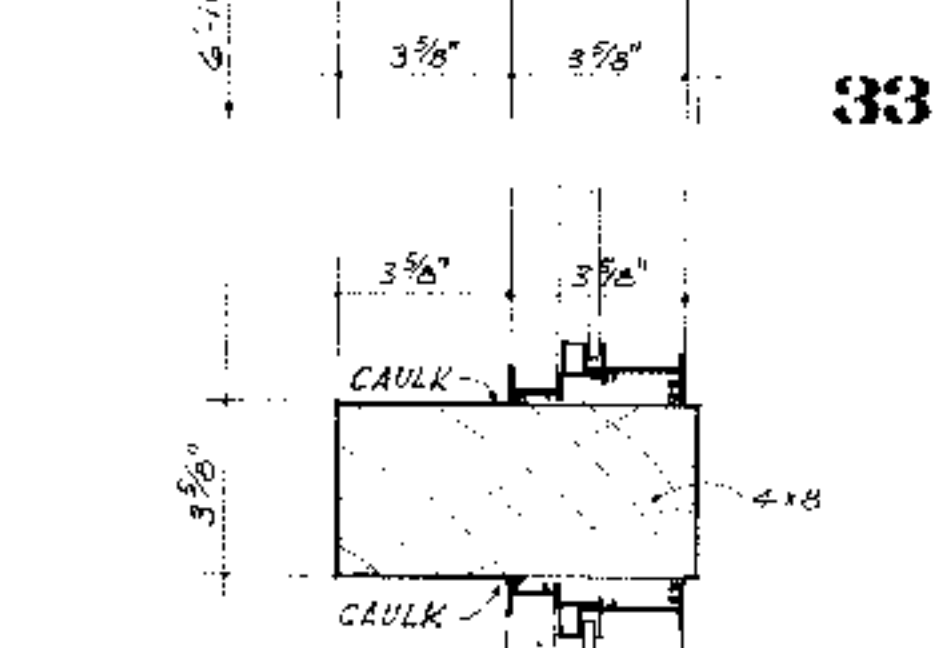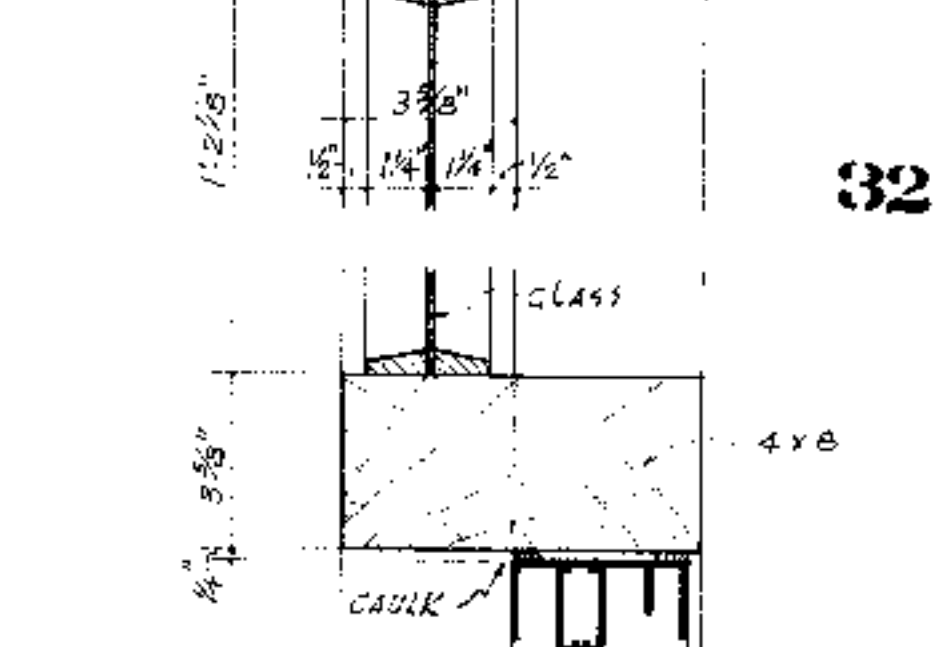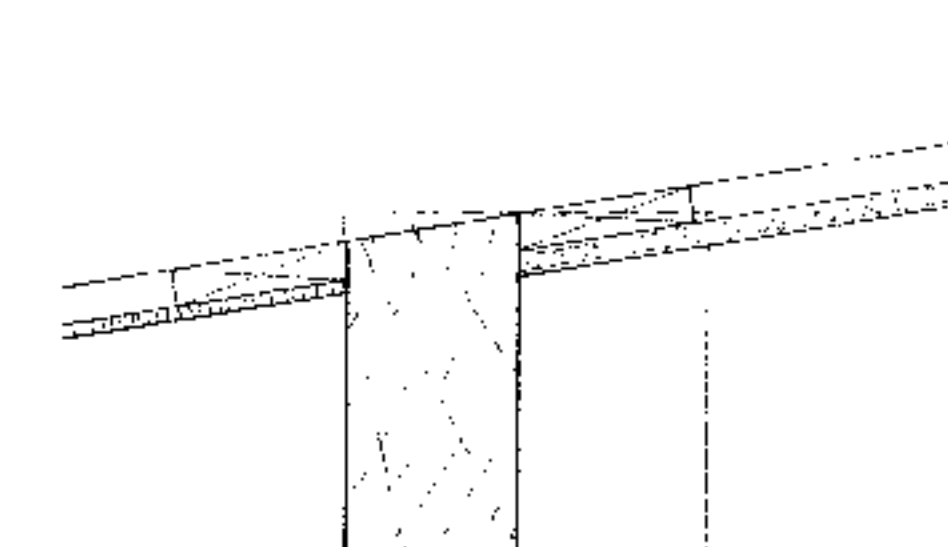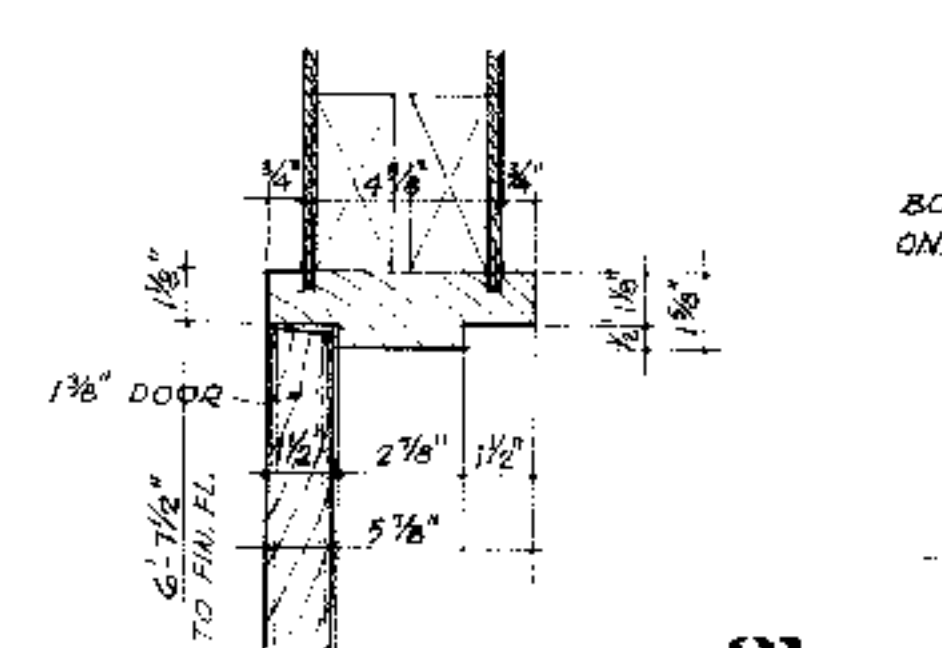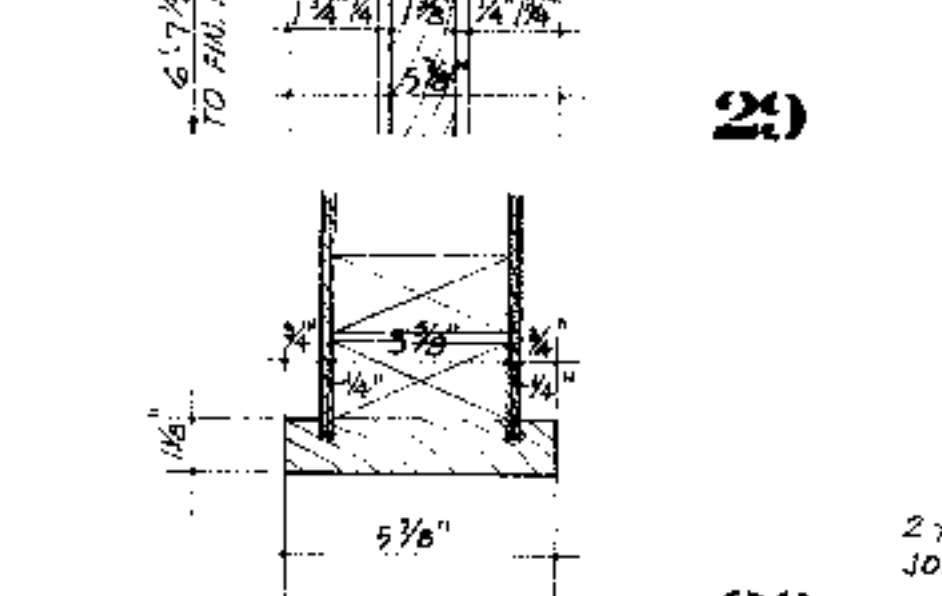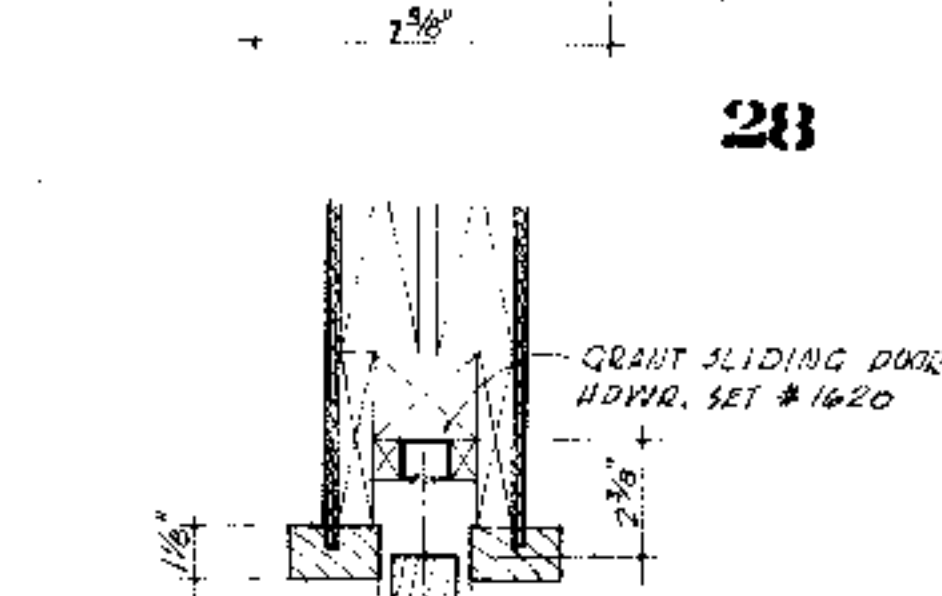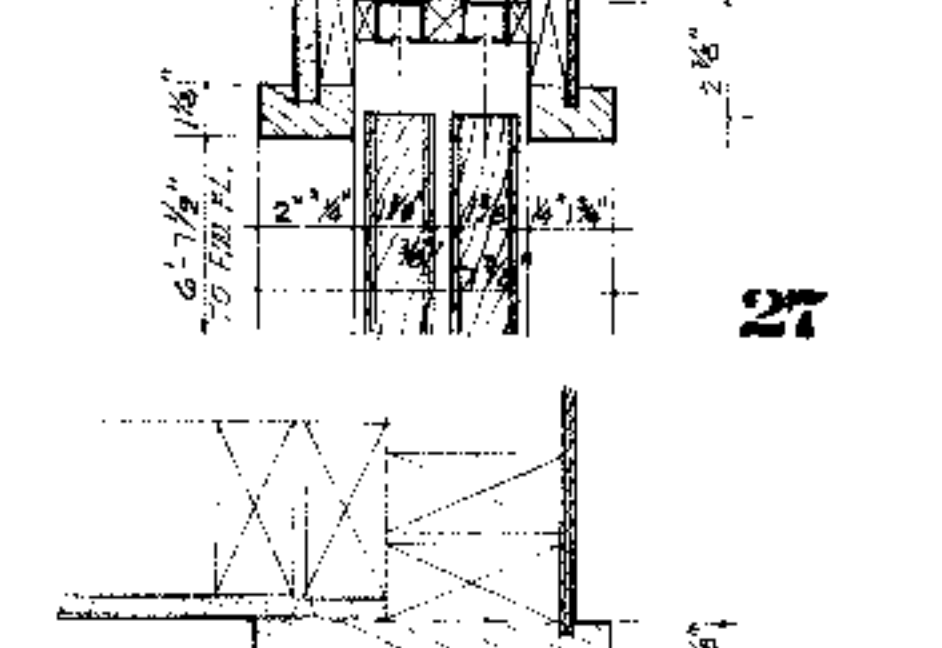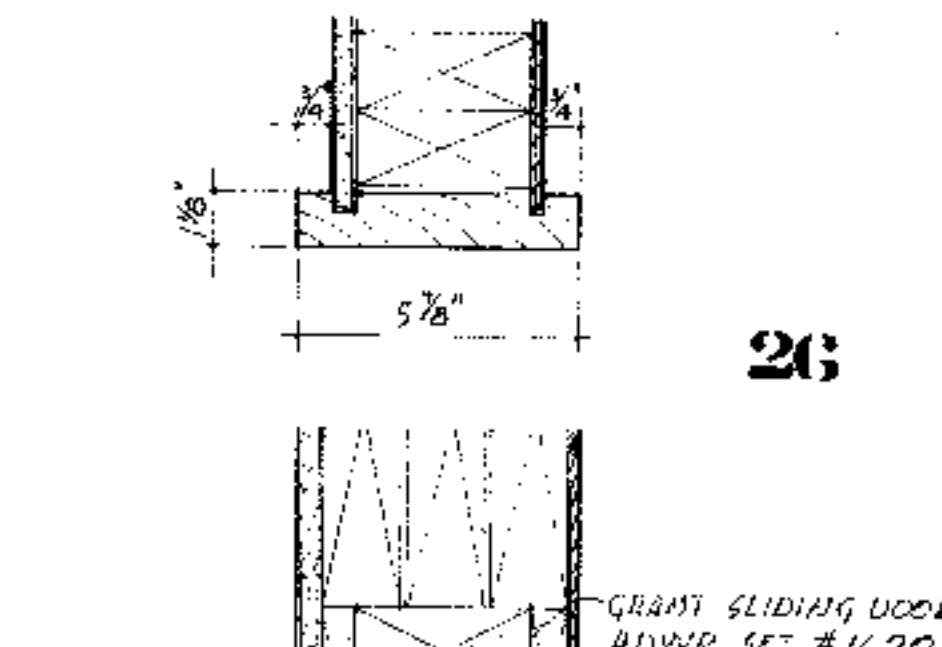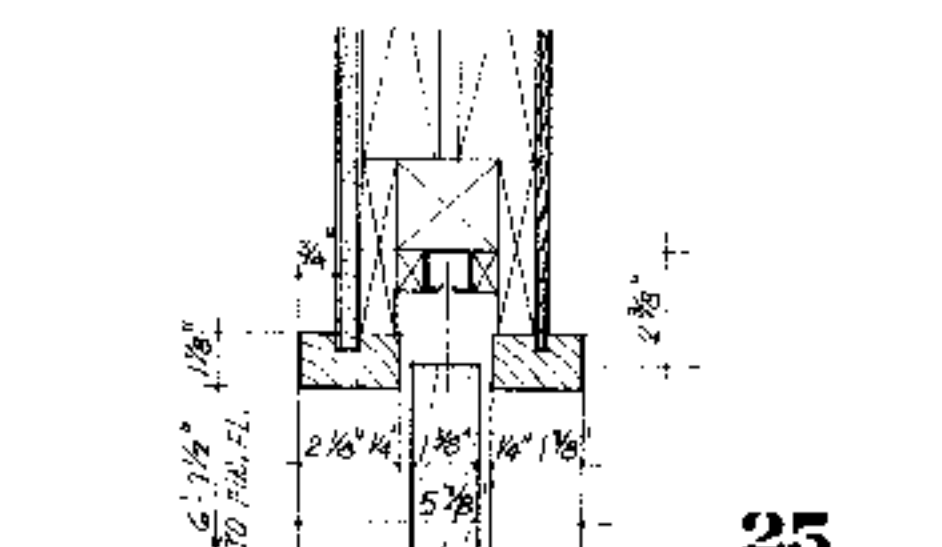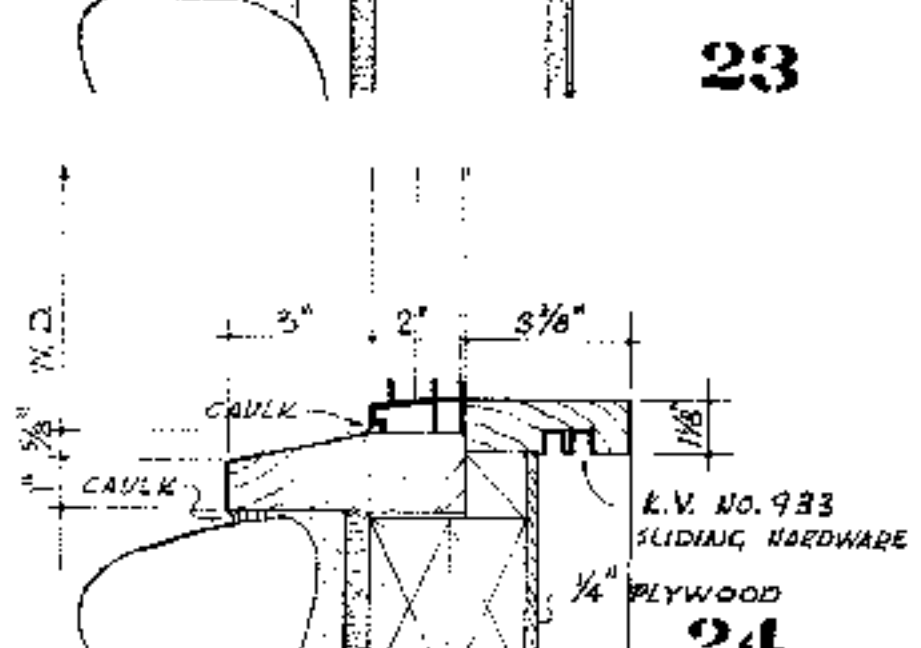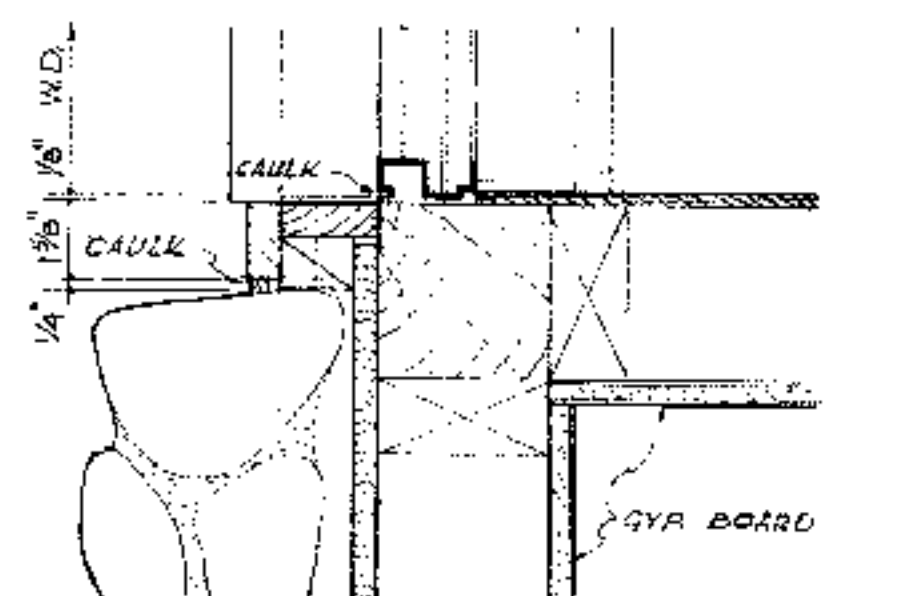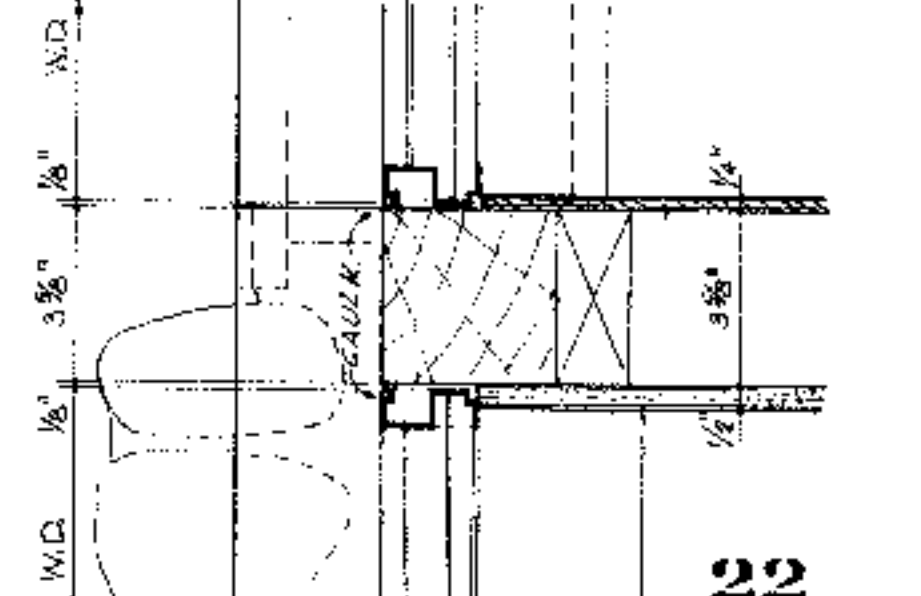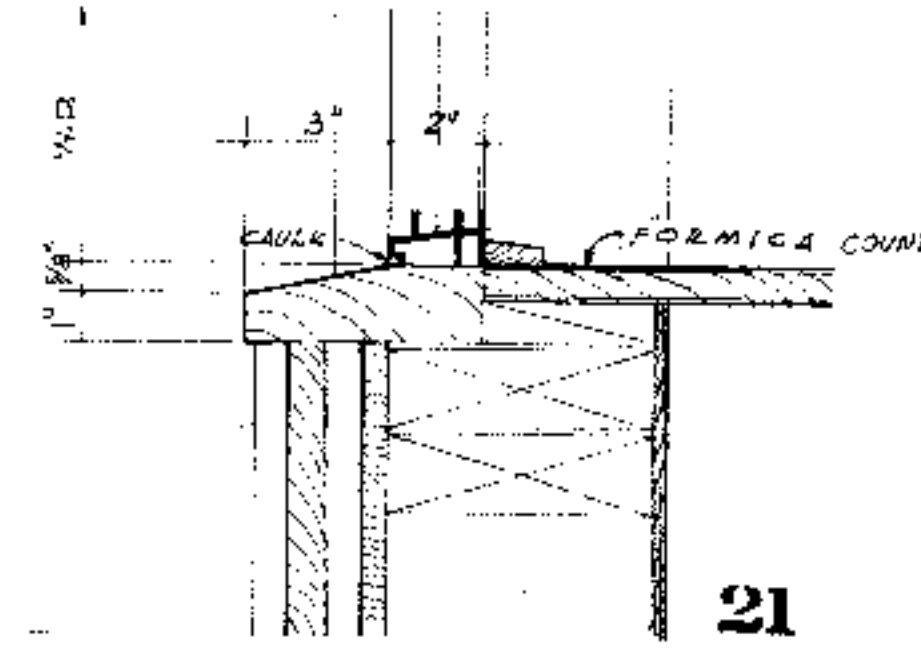
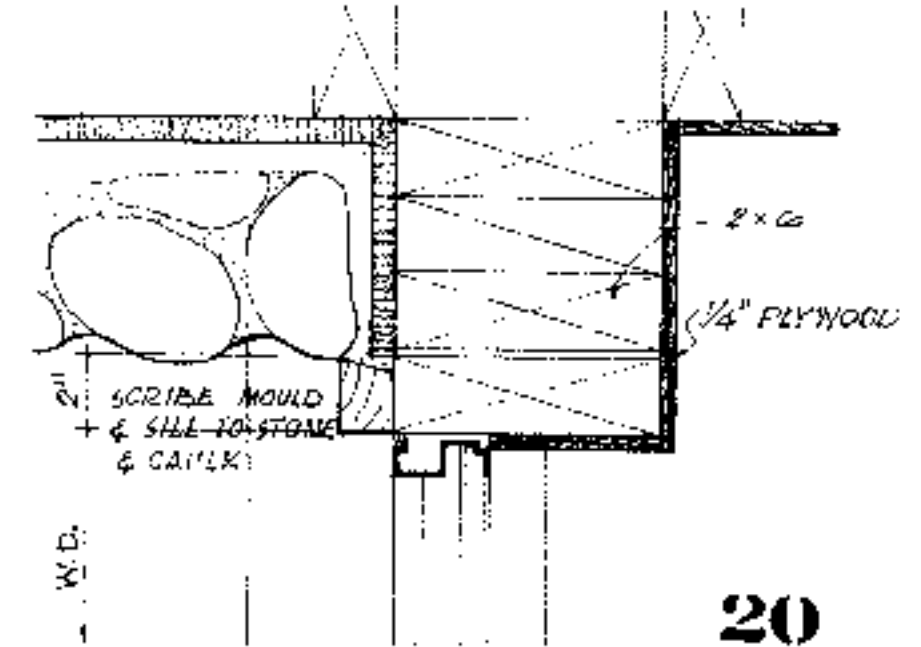
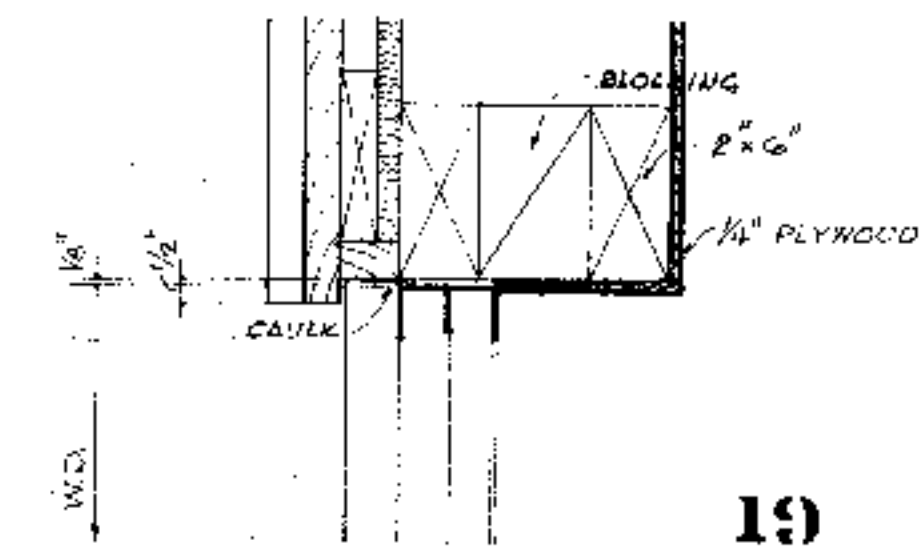
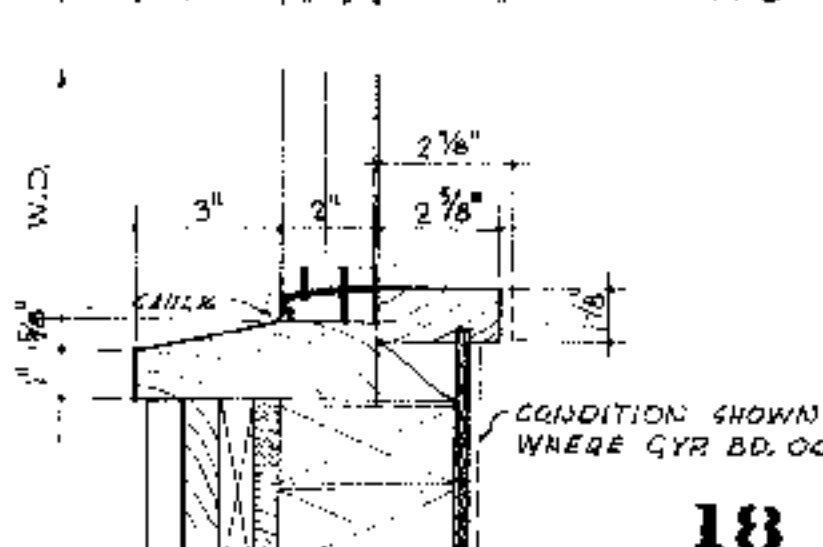
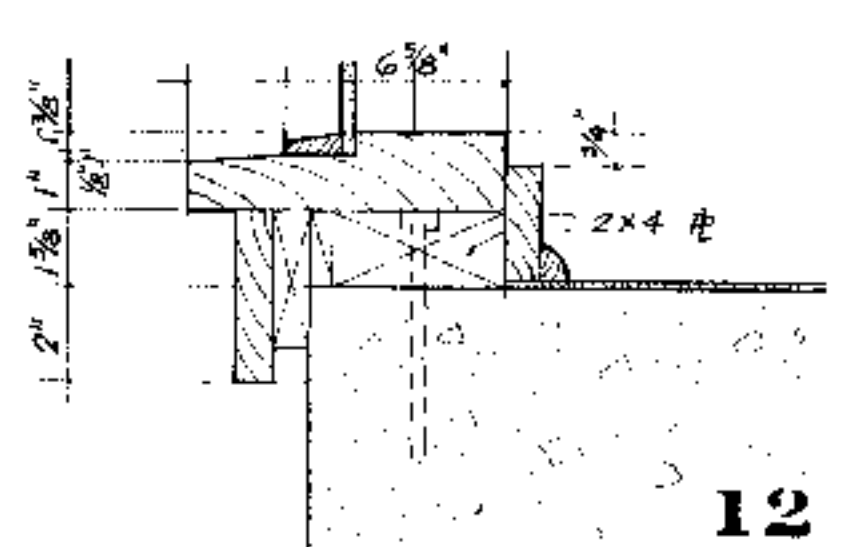
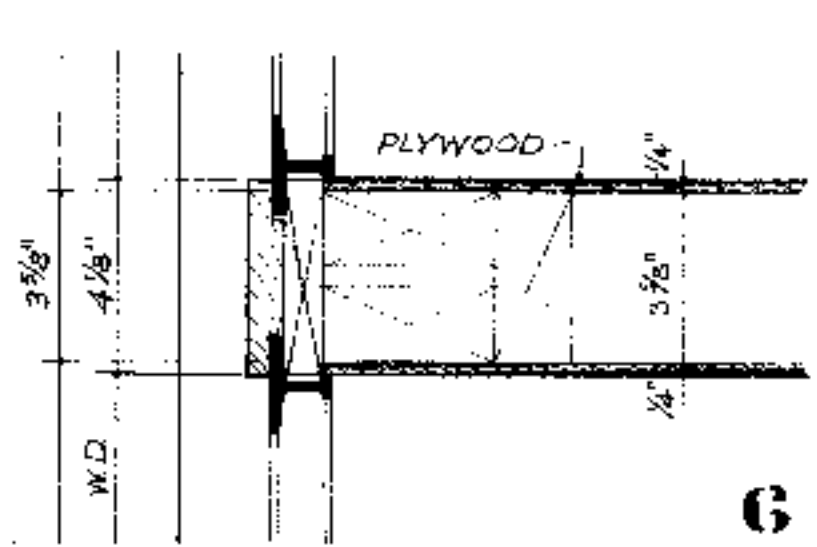
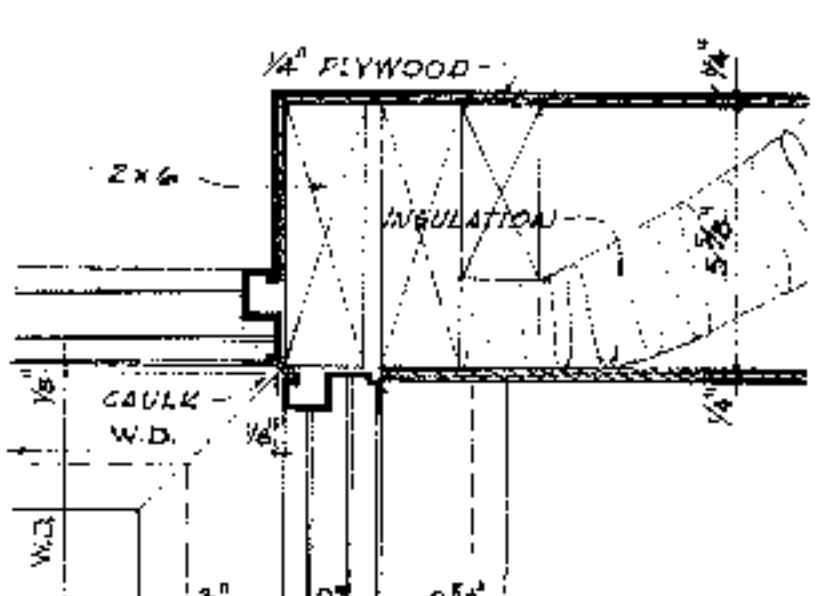
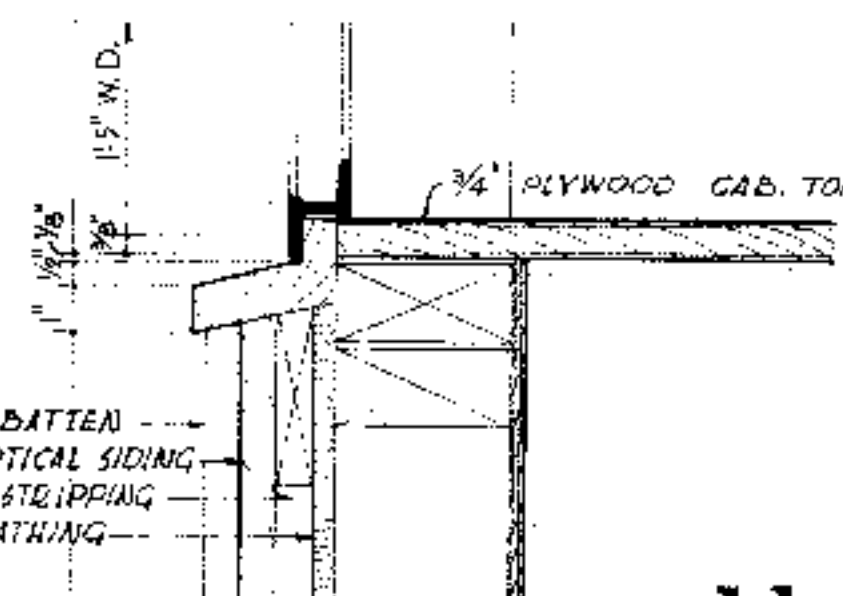
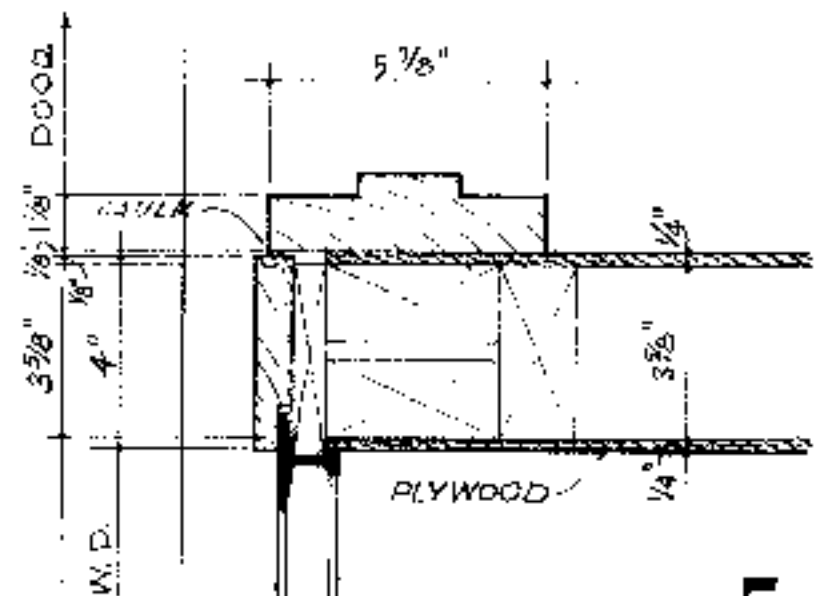
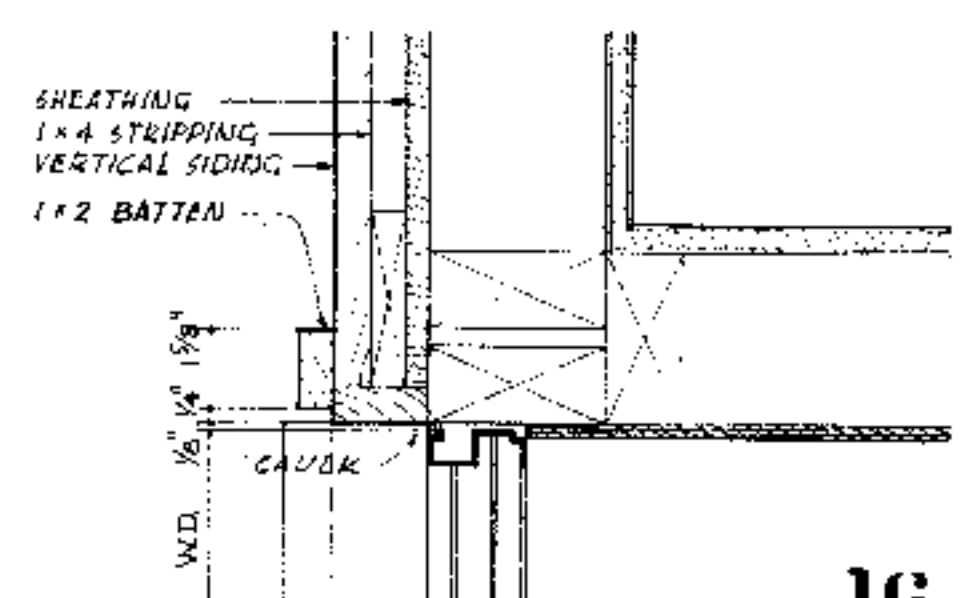
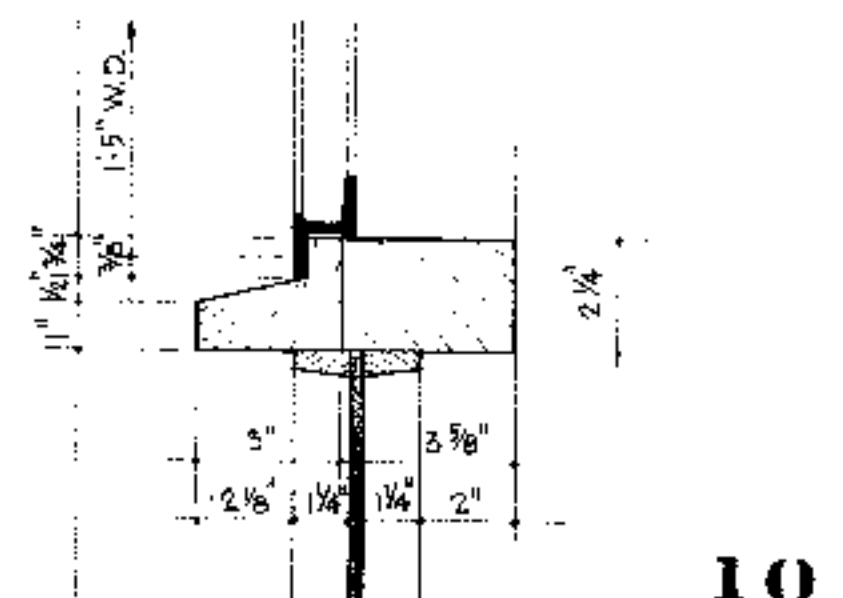
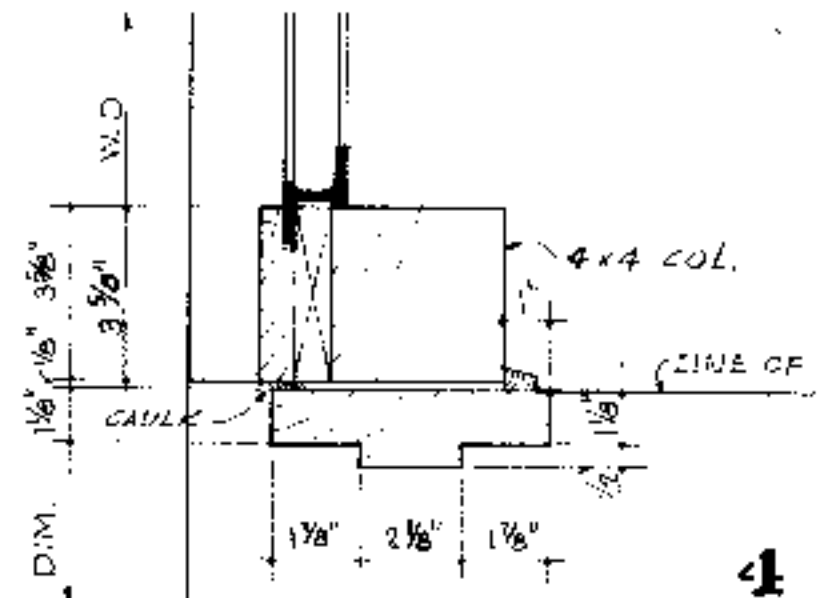
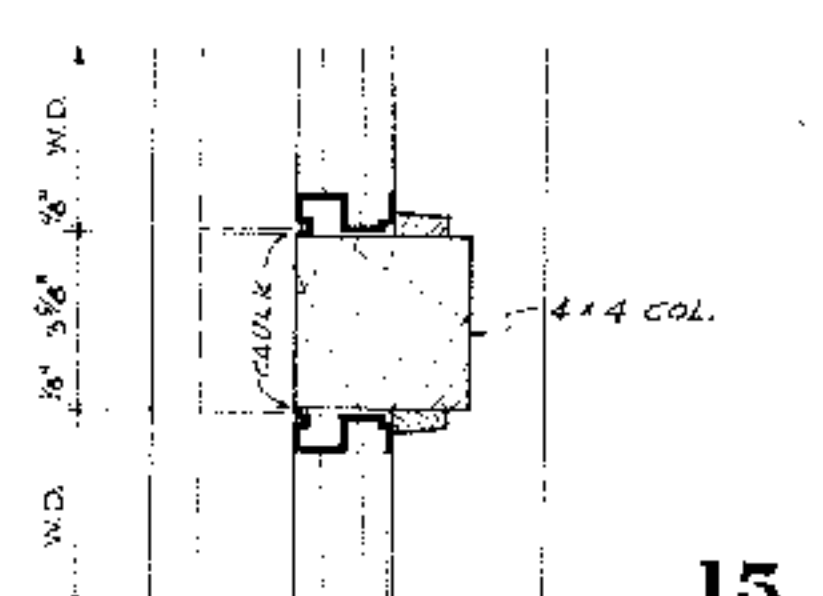
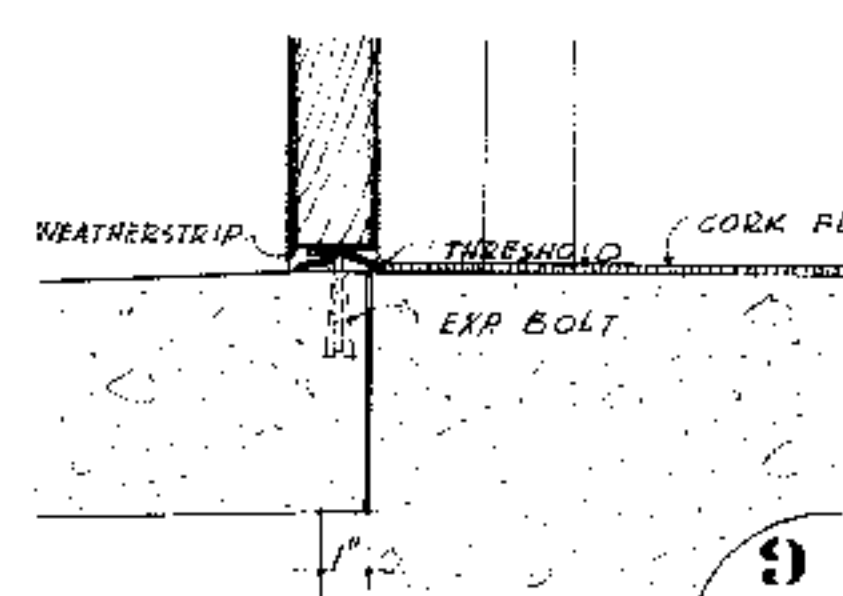
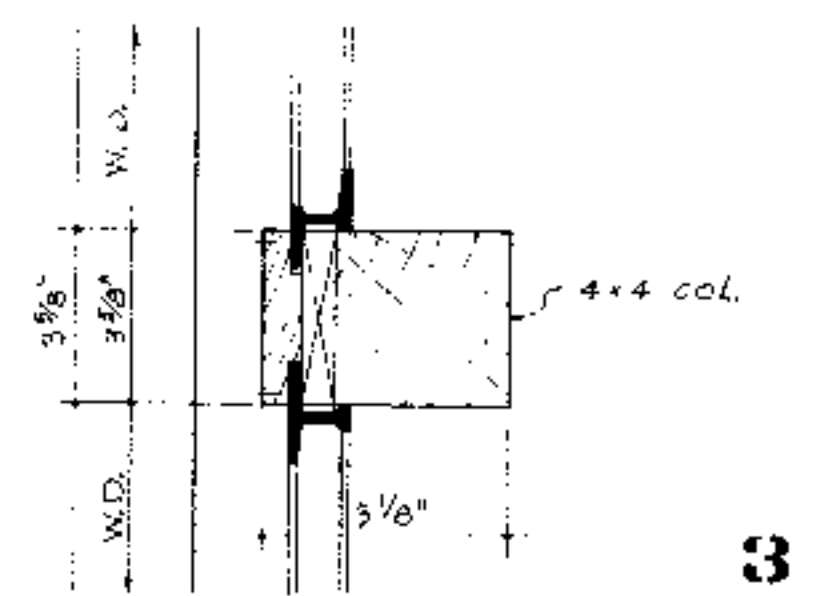
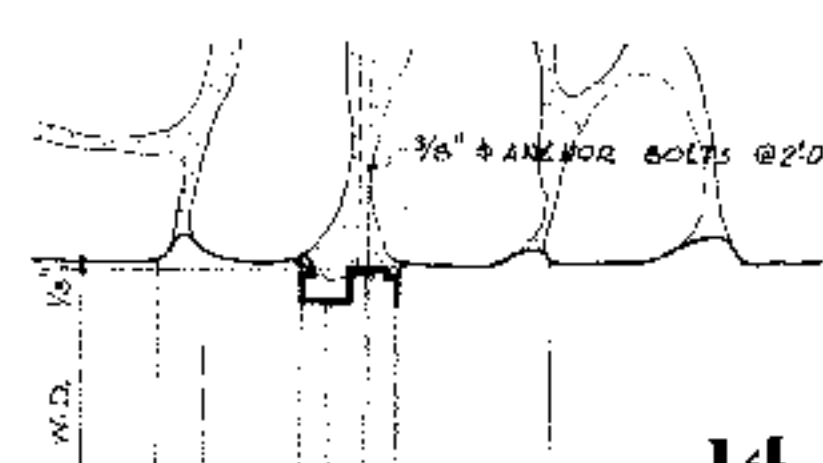
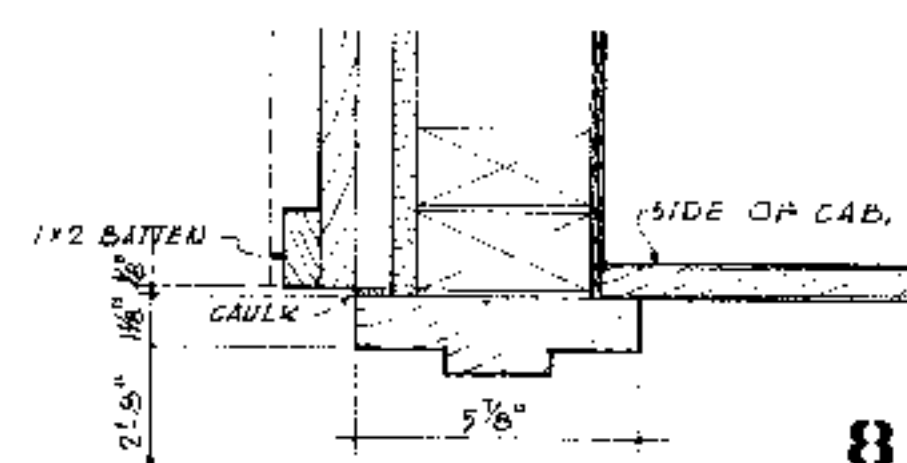
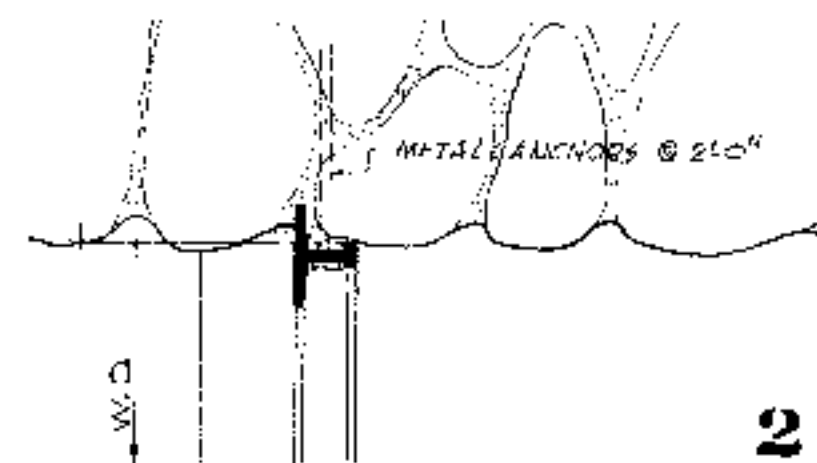
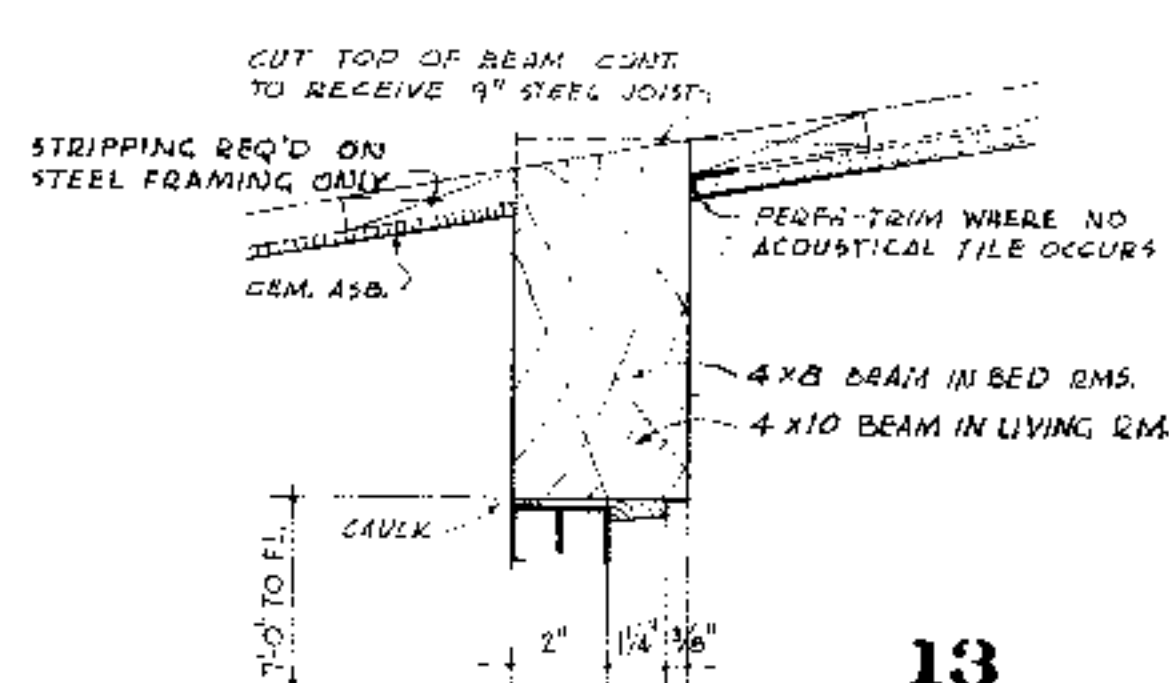
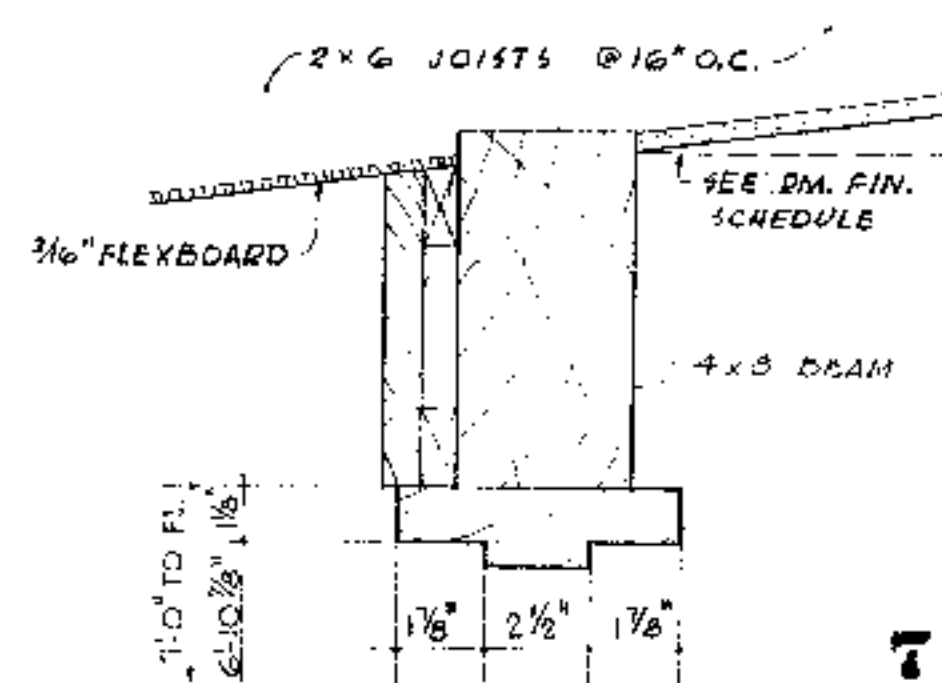
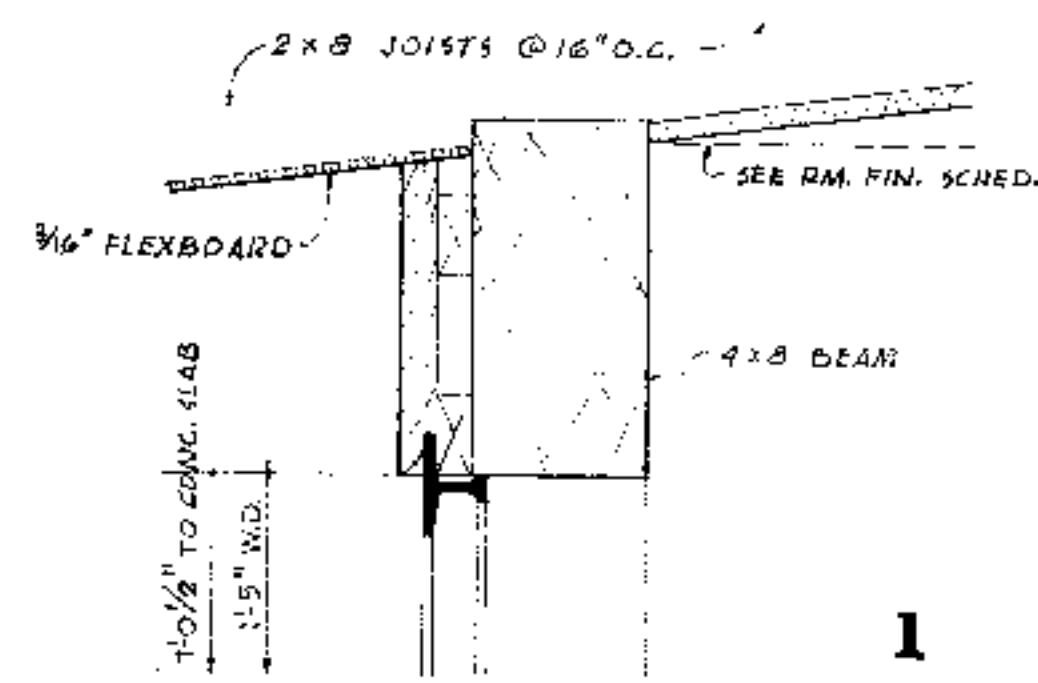


WM. H. HIDEELL, JR.
ARCHITECT
3010 BLACKBURN ST. DALLAS 4, TEXAS
A RESIDENCE FOR
MR. & MRS. R. R. HIDEELL
AUSTIN TEXAS



JOB NO. DATE DRAWN BY CHECKED BY SHEET NO.
602 9-1-56 4 11 OF 16


Wm. H. Hideell, Jr.

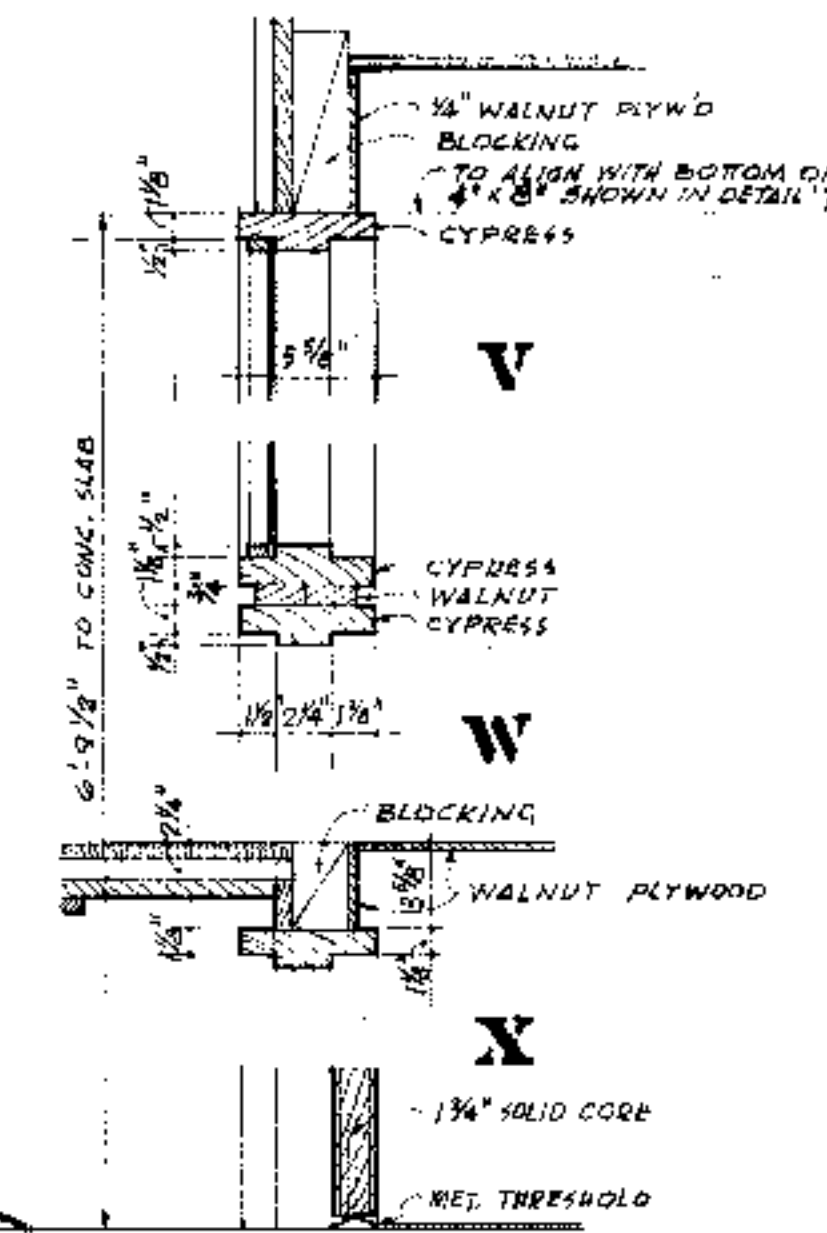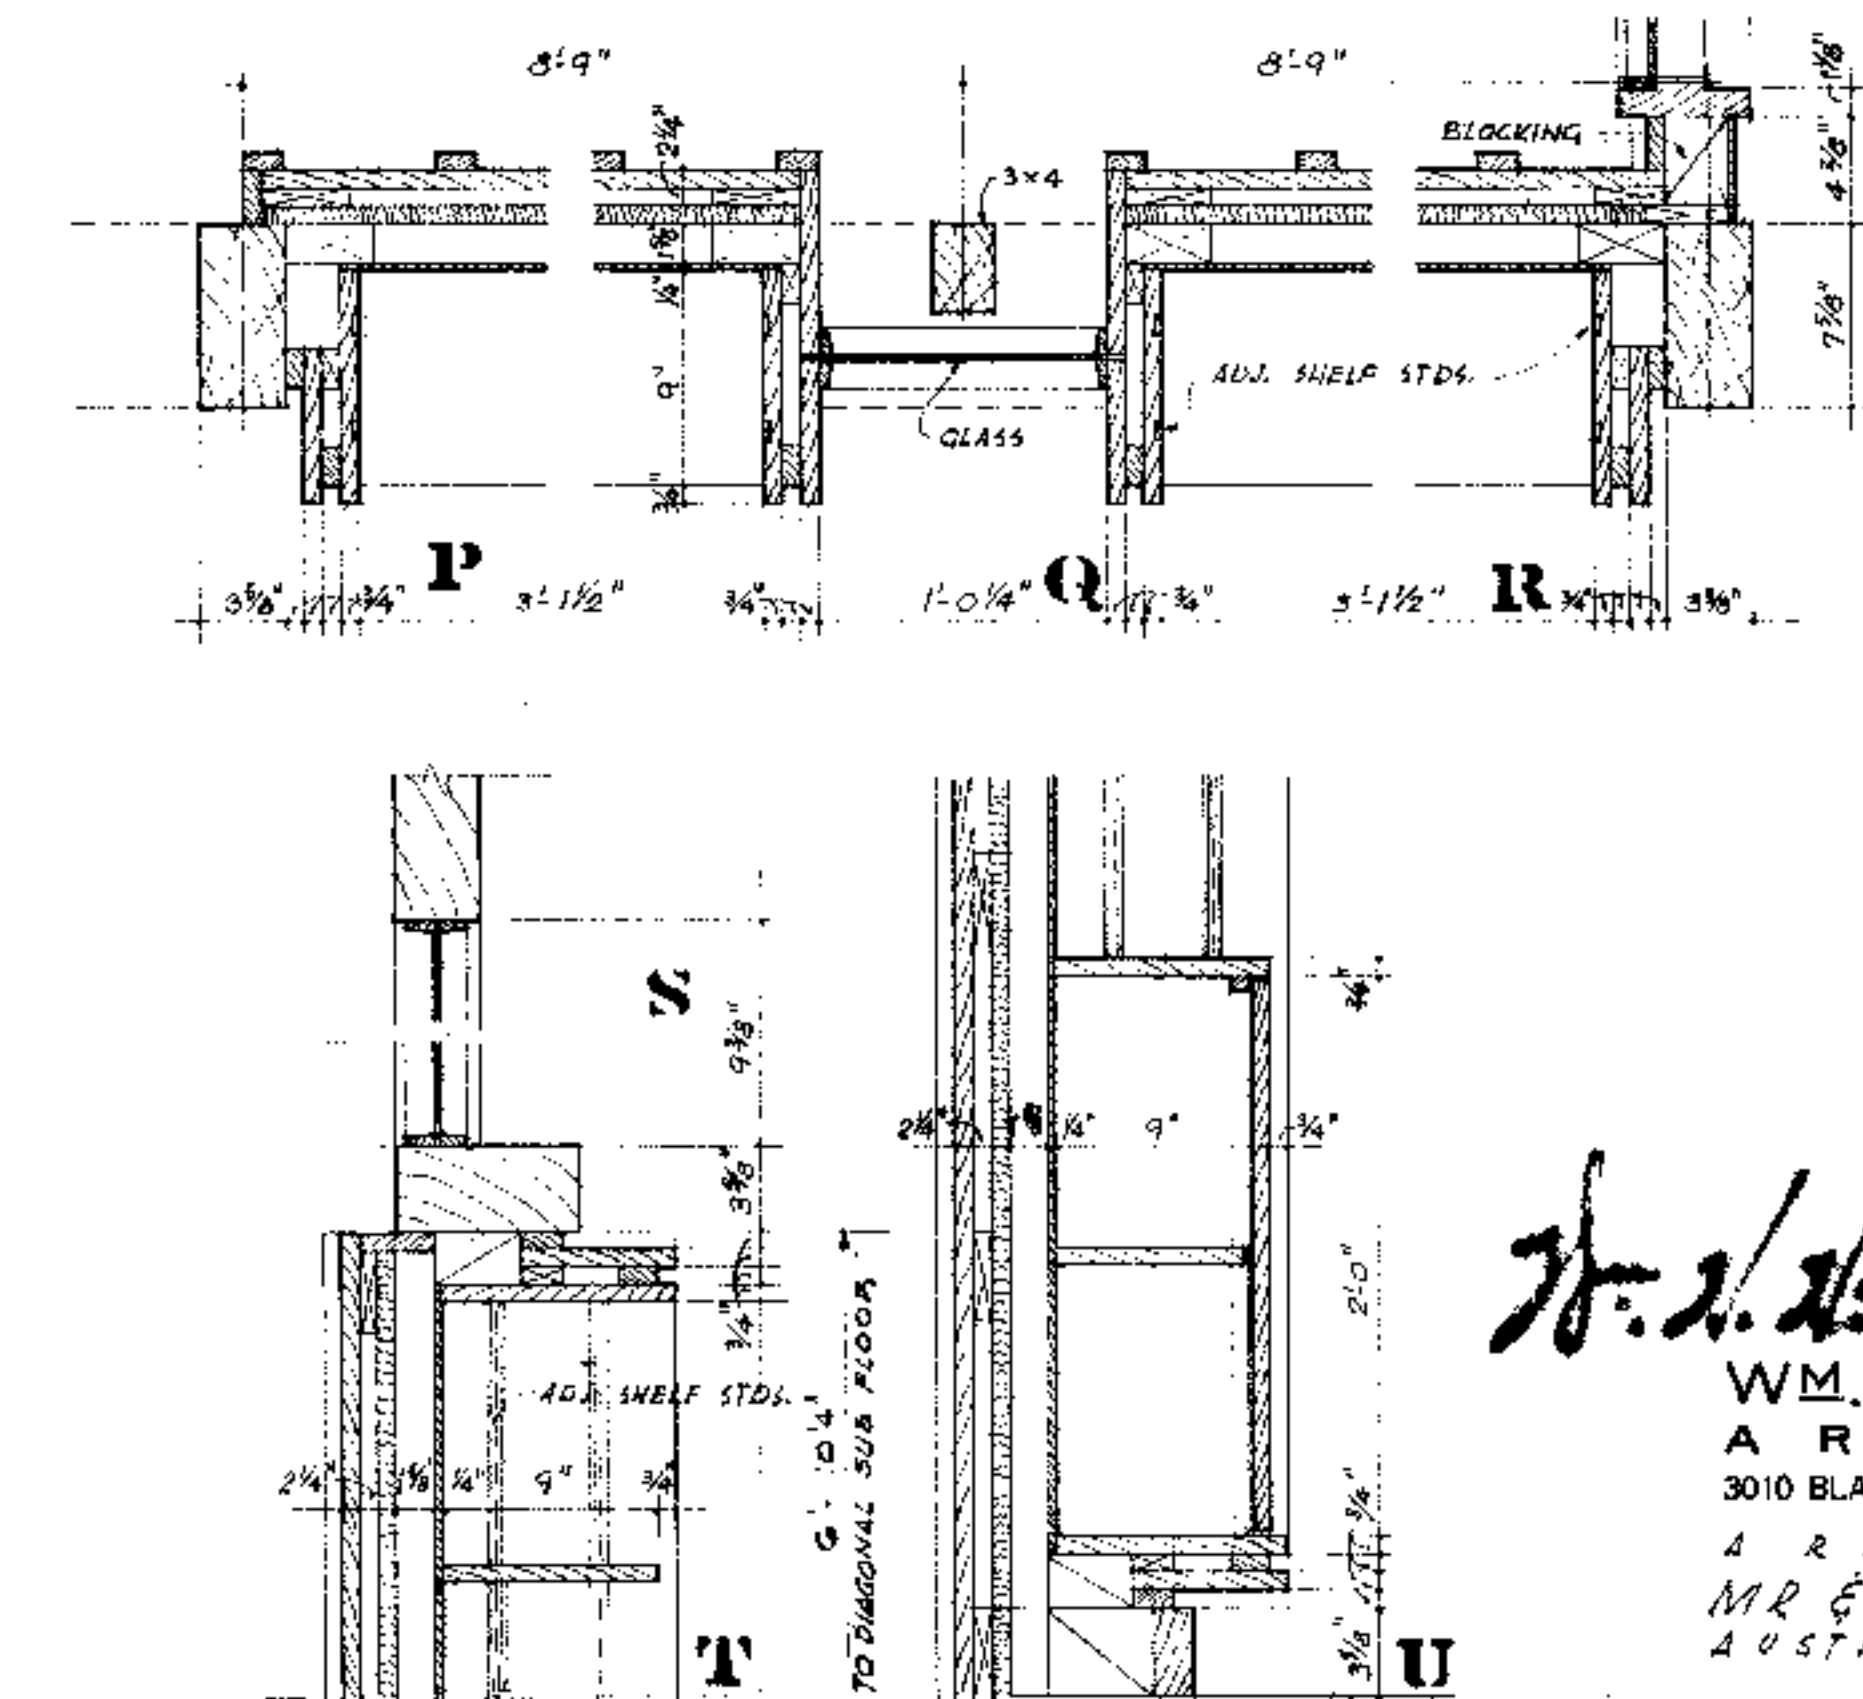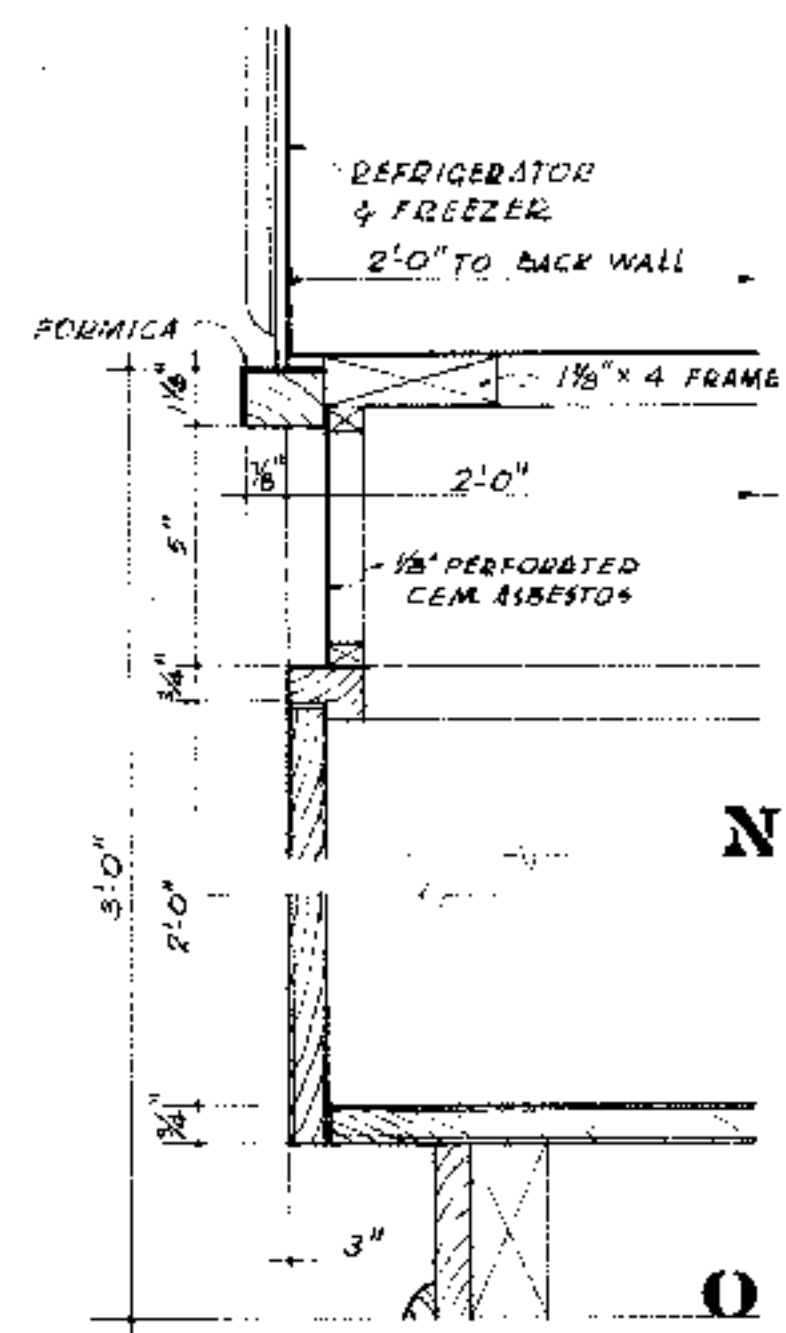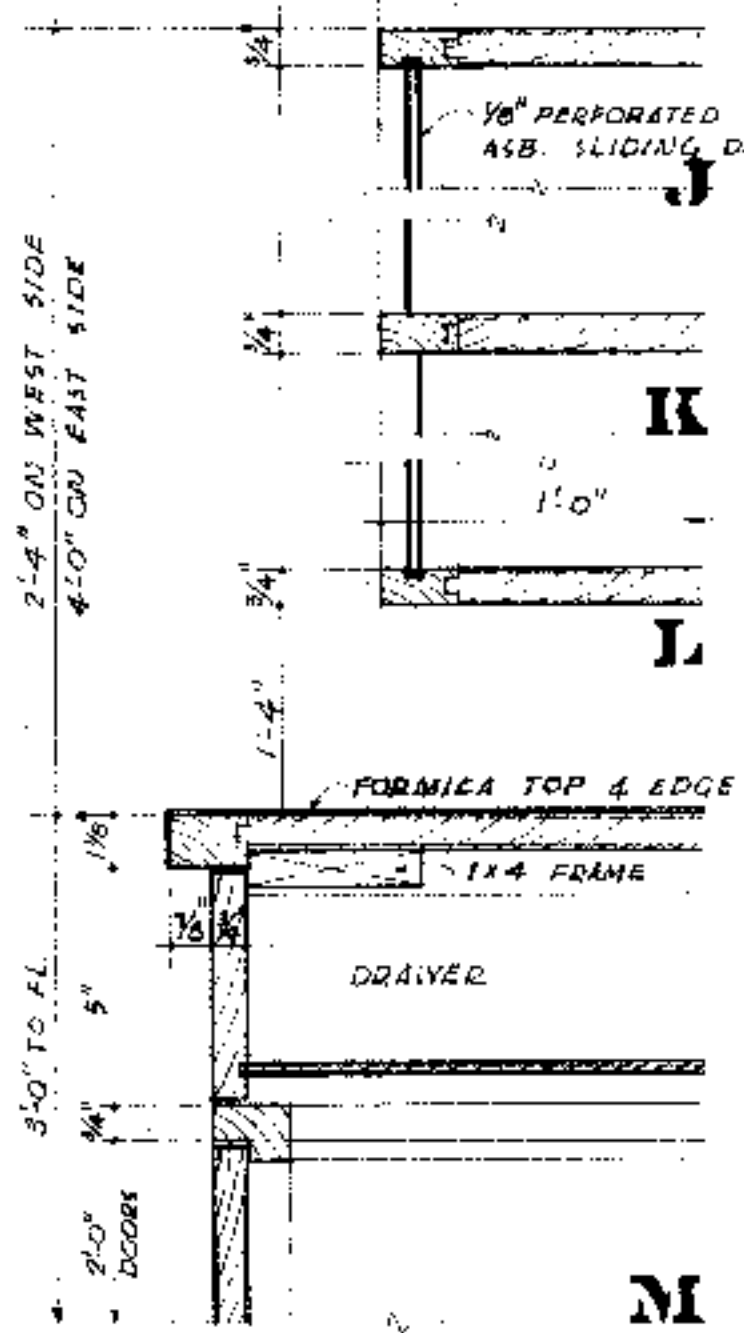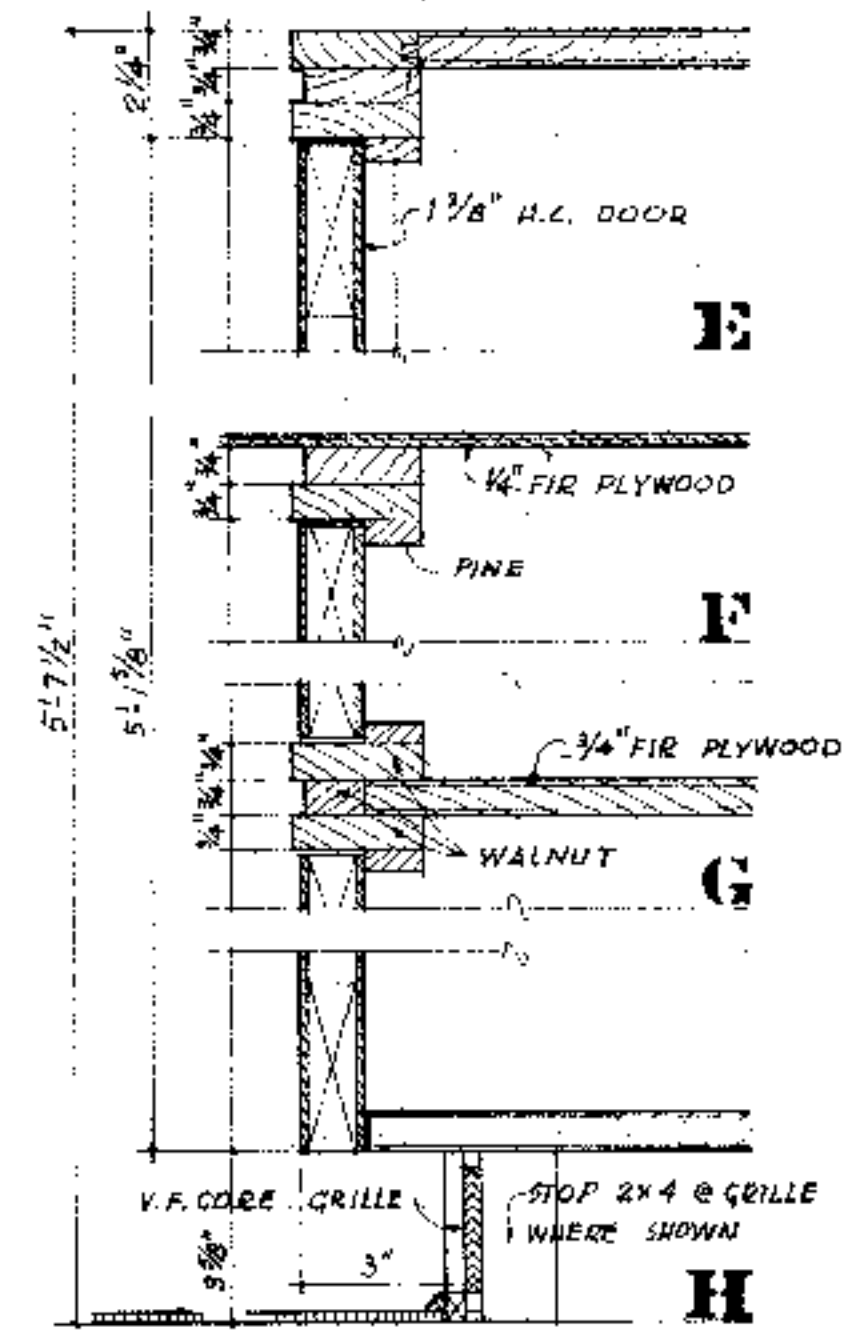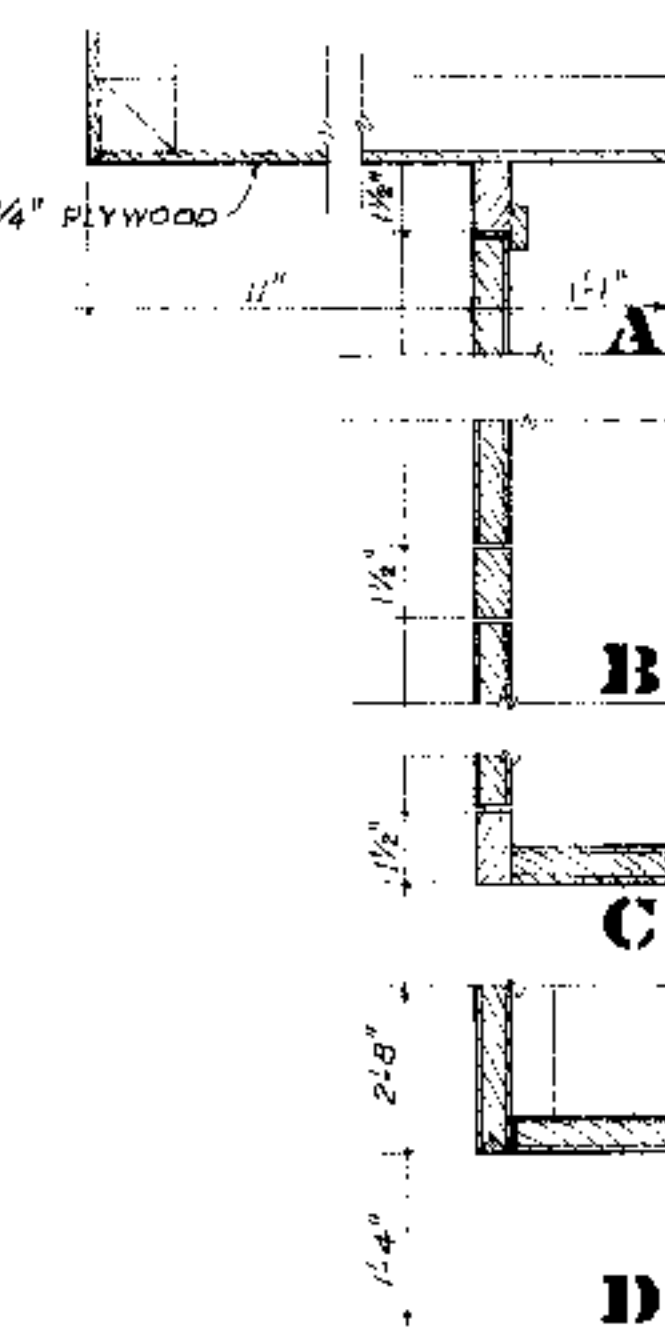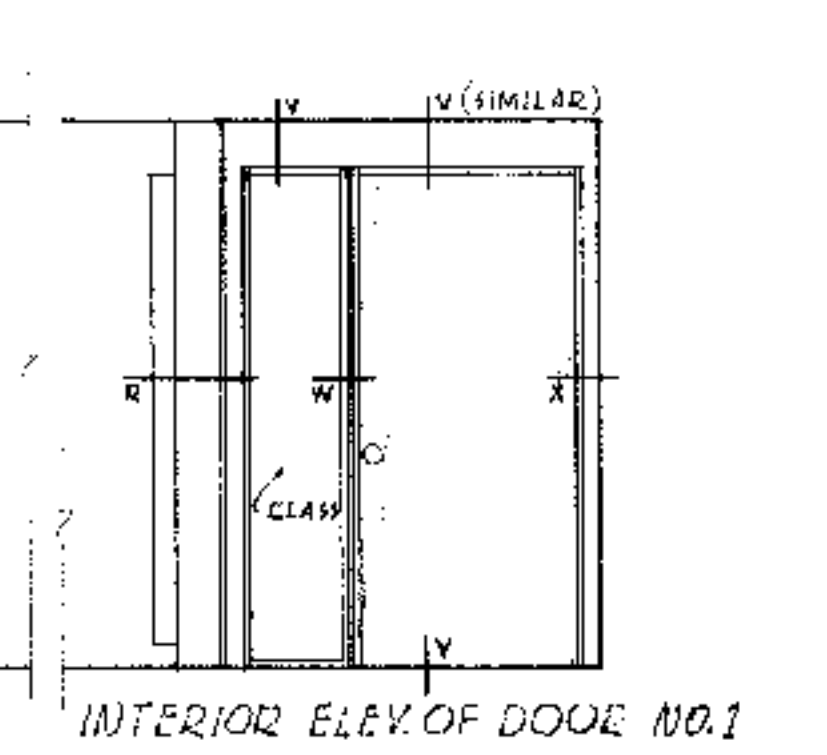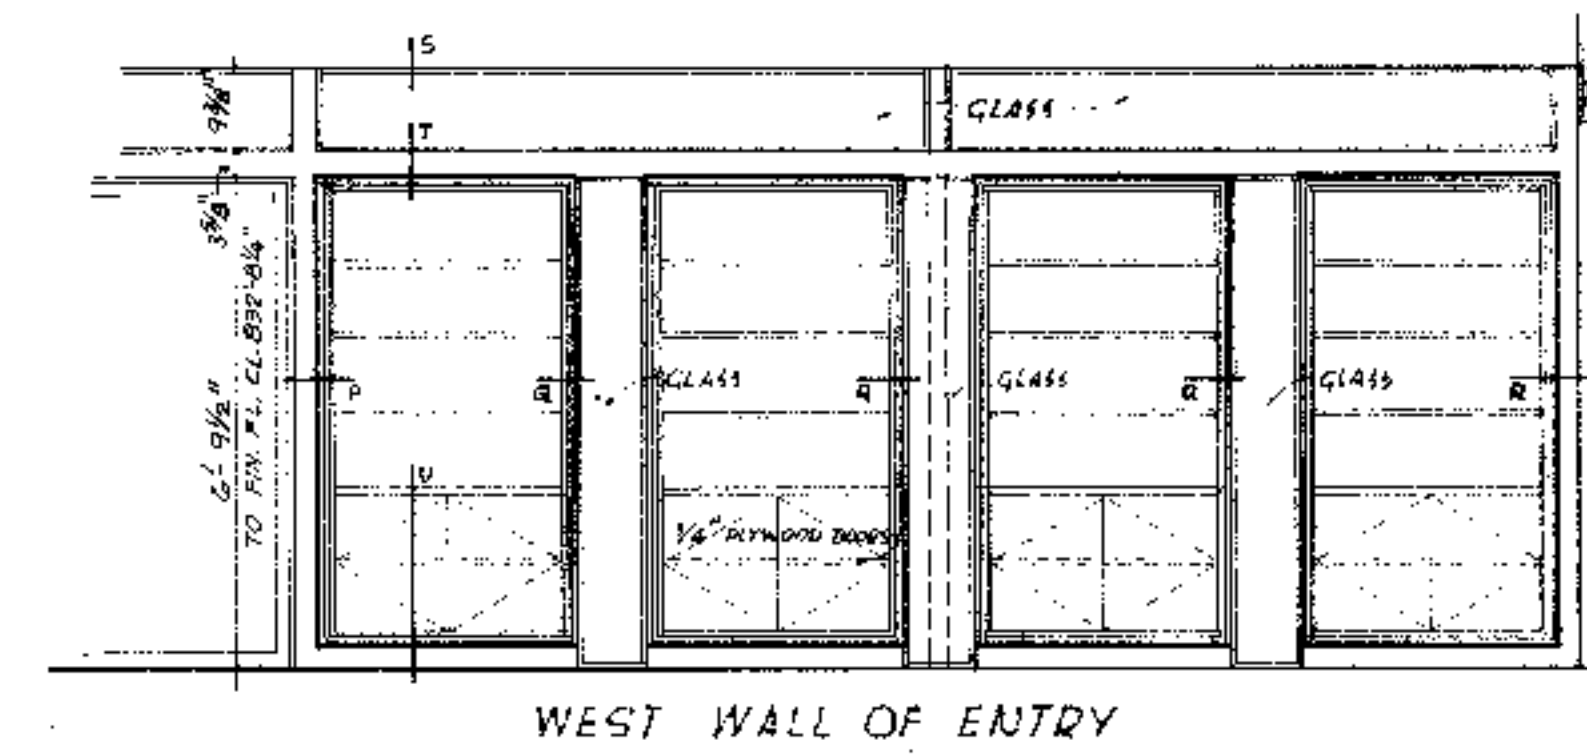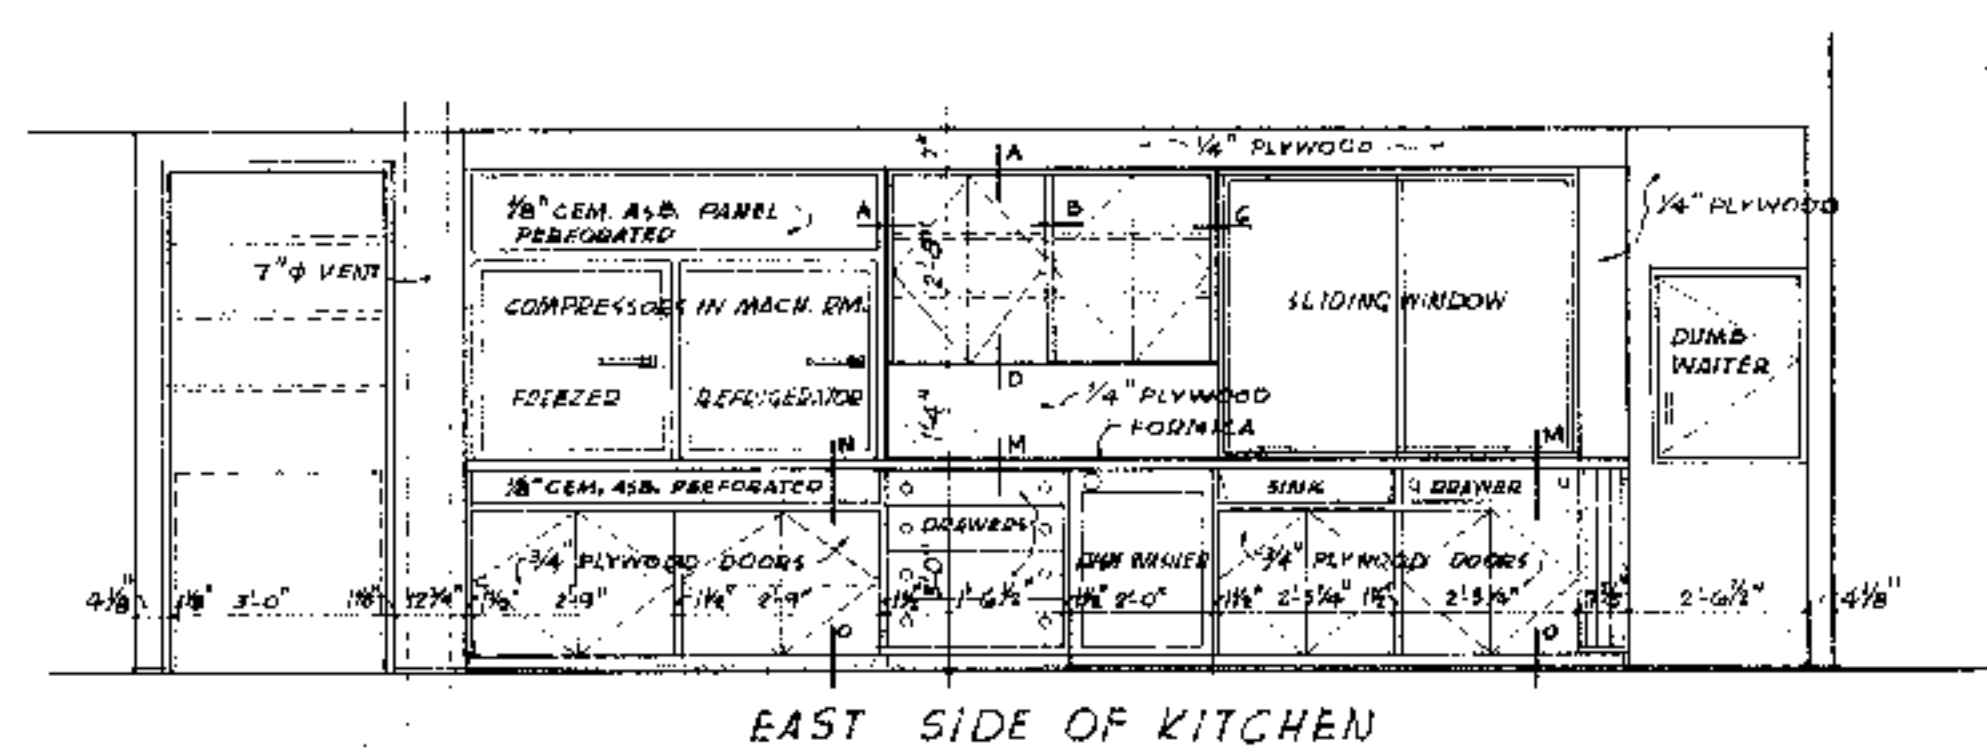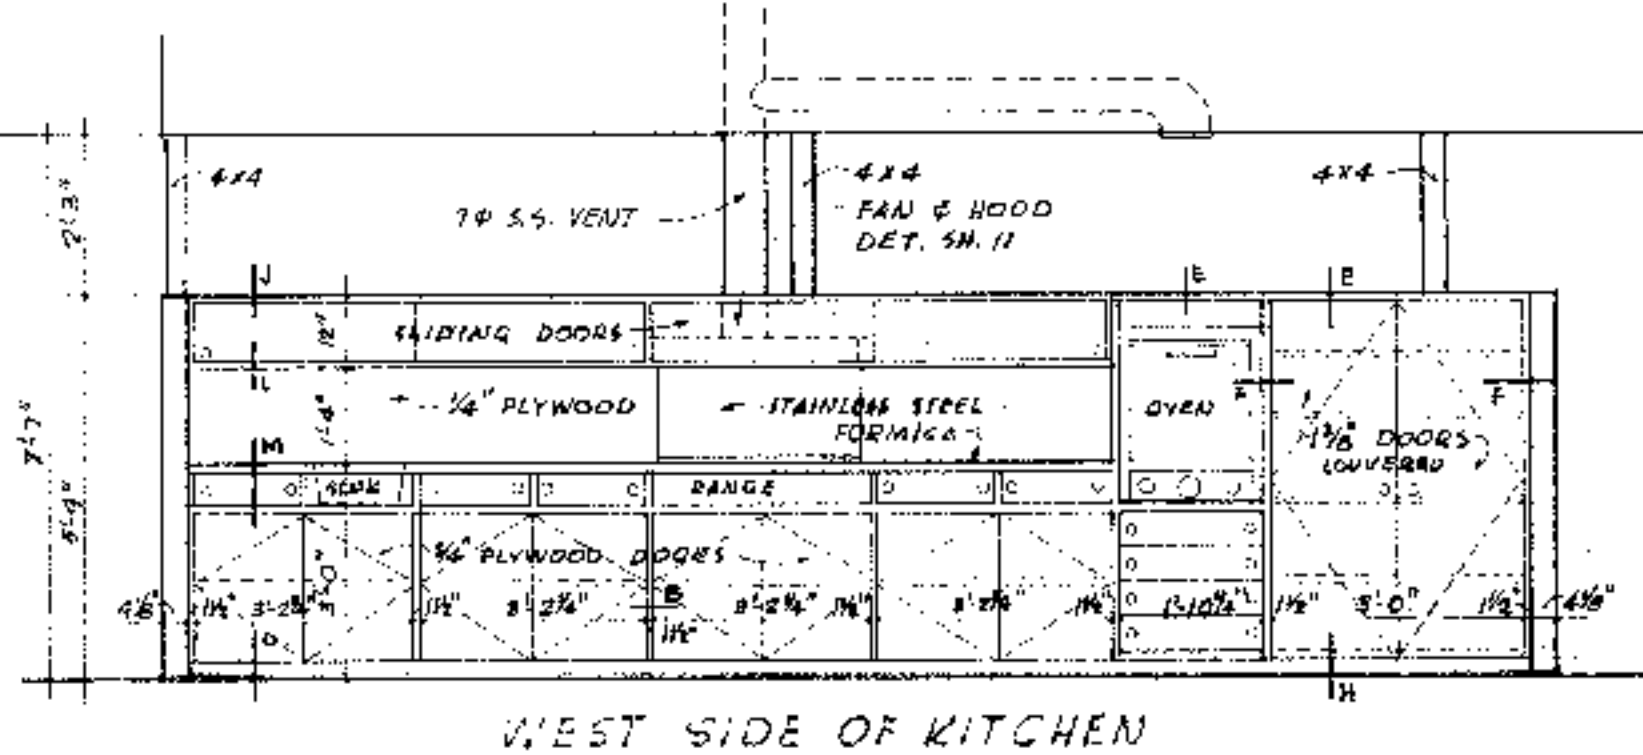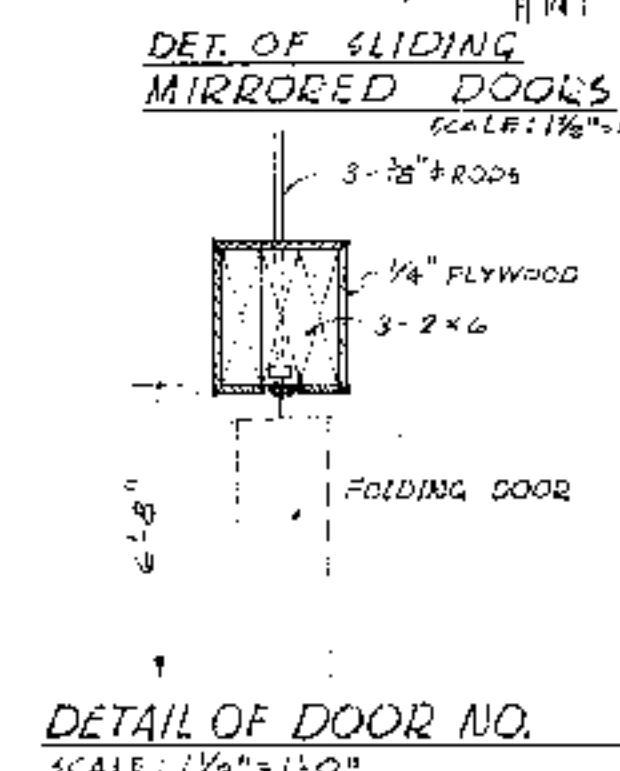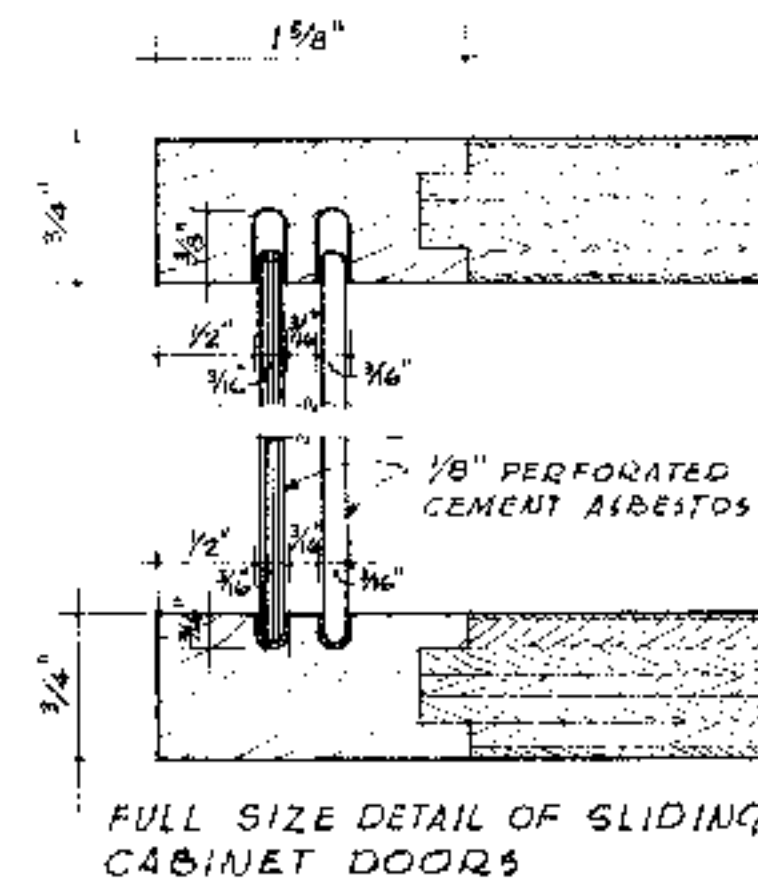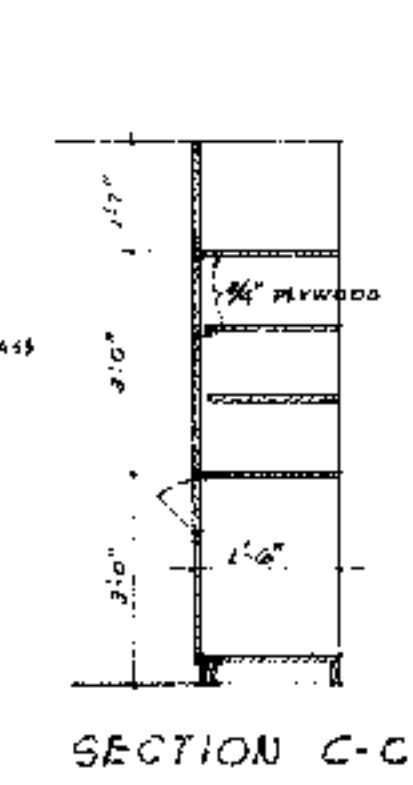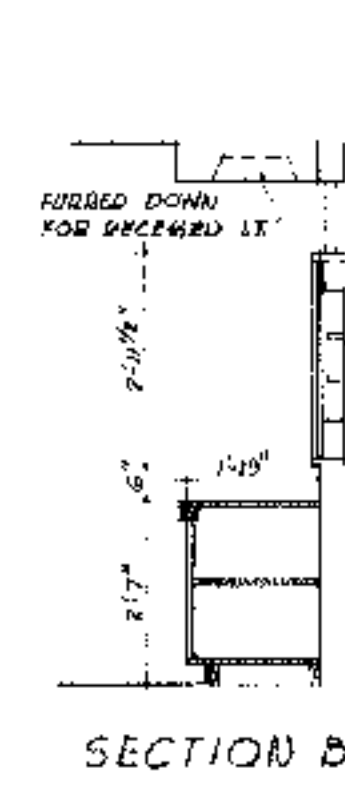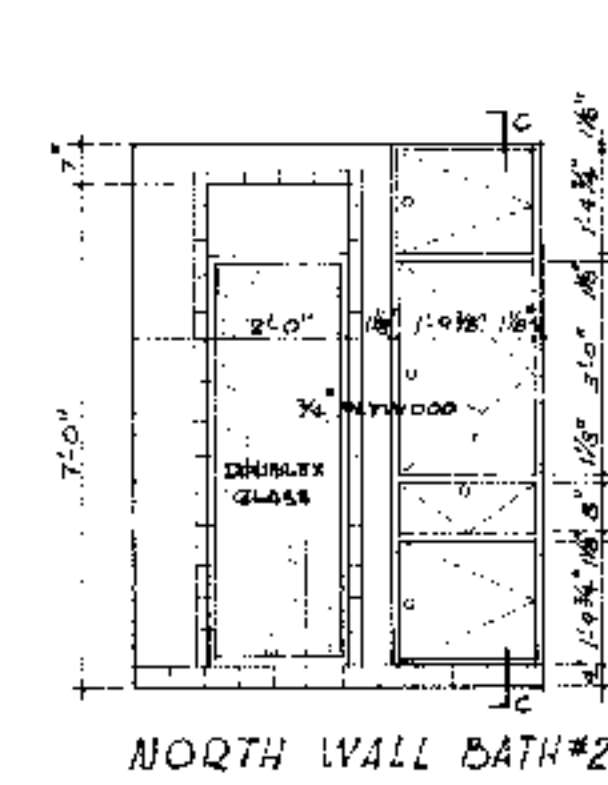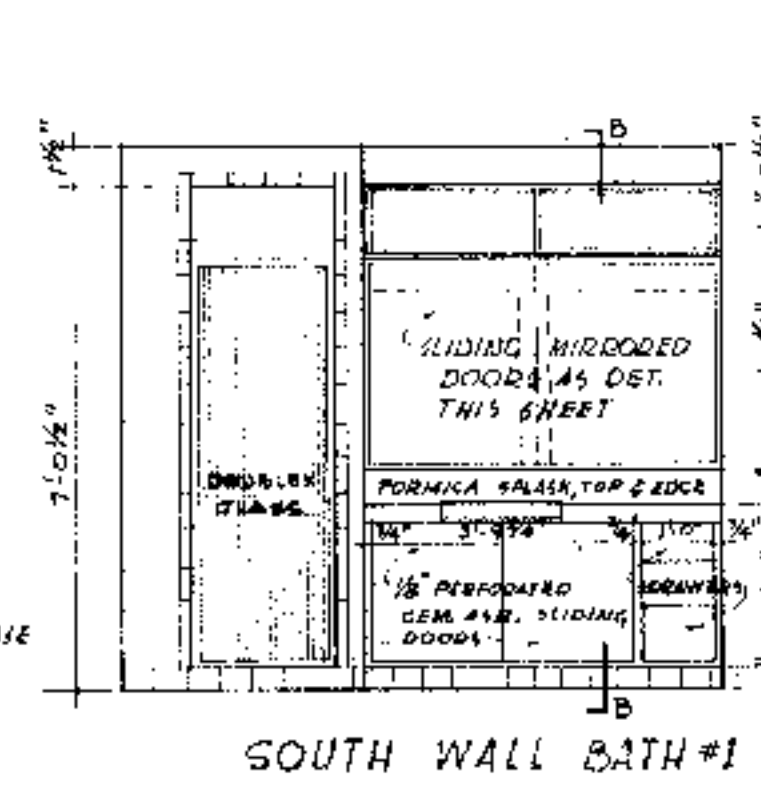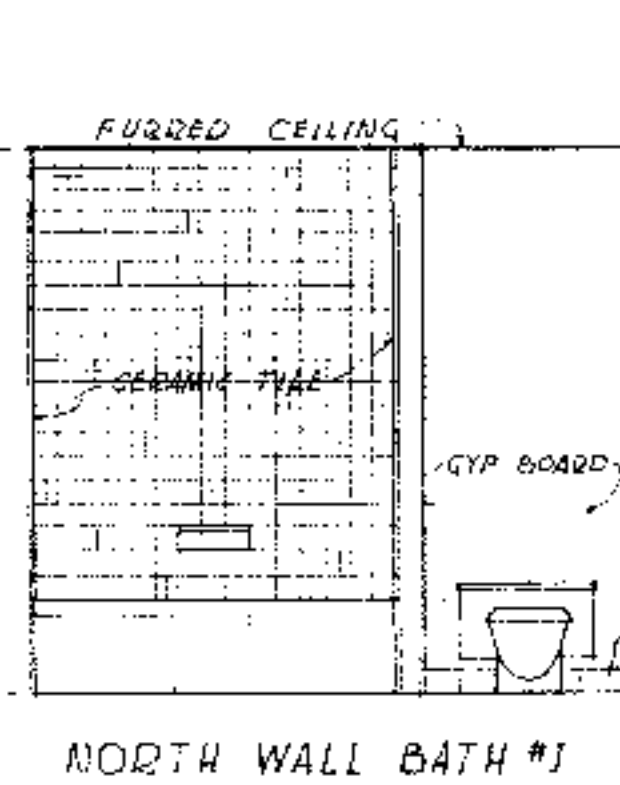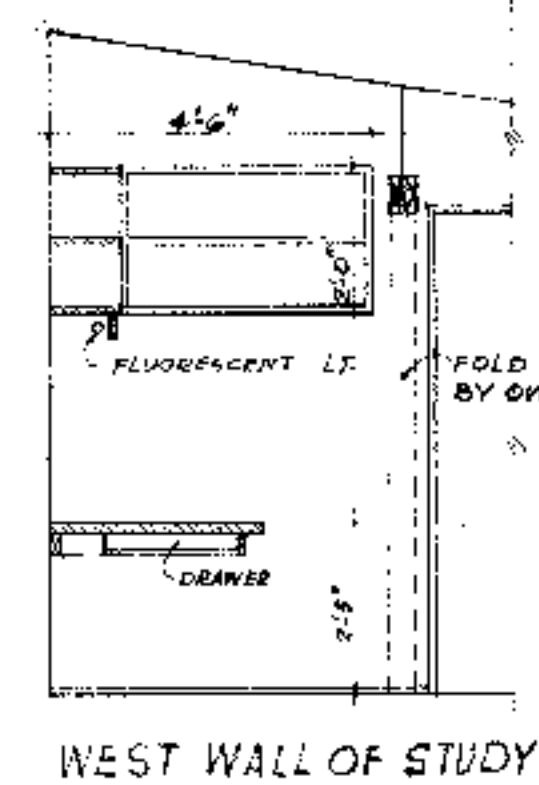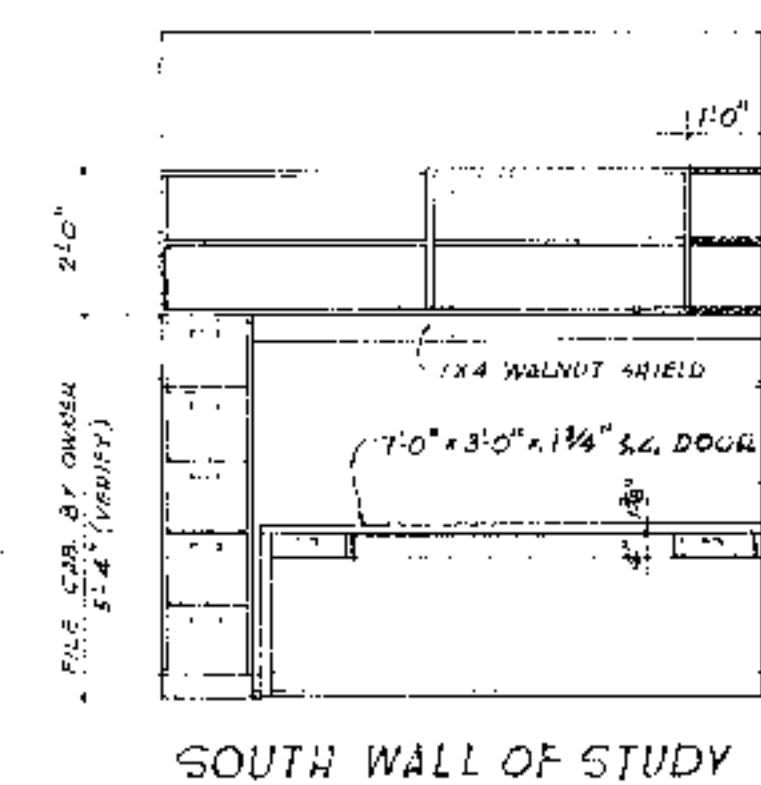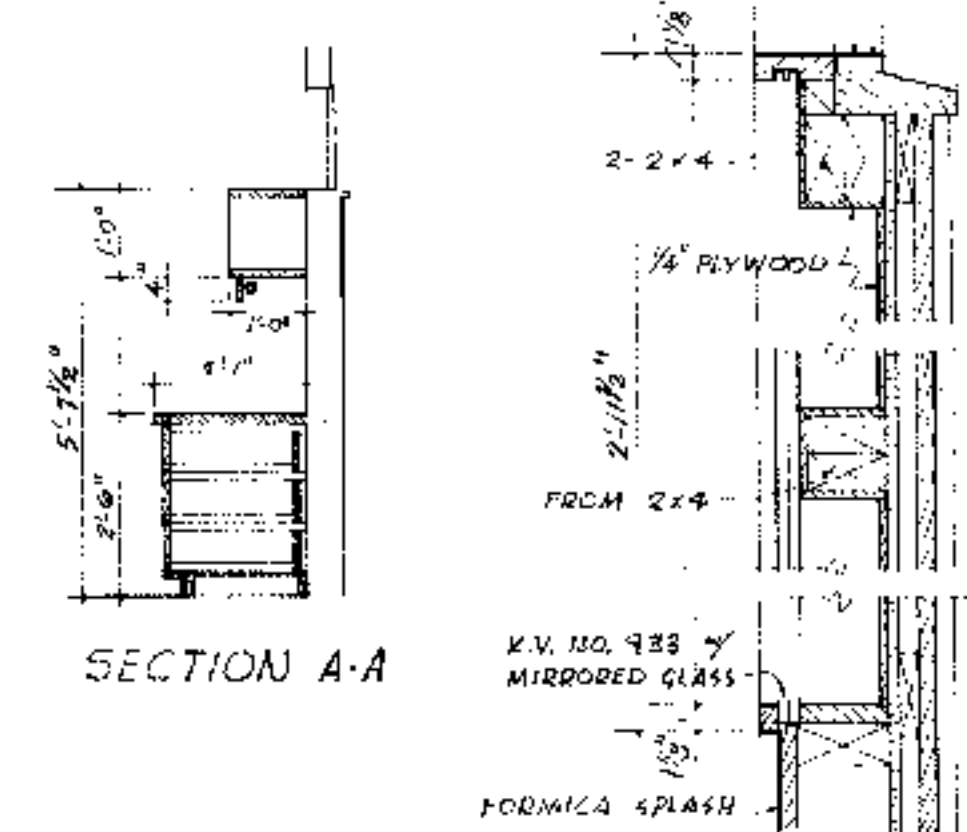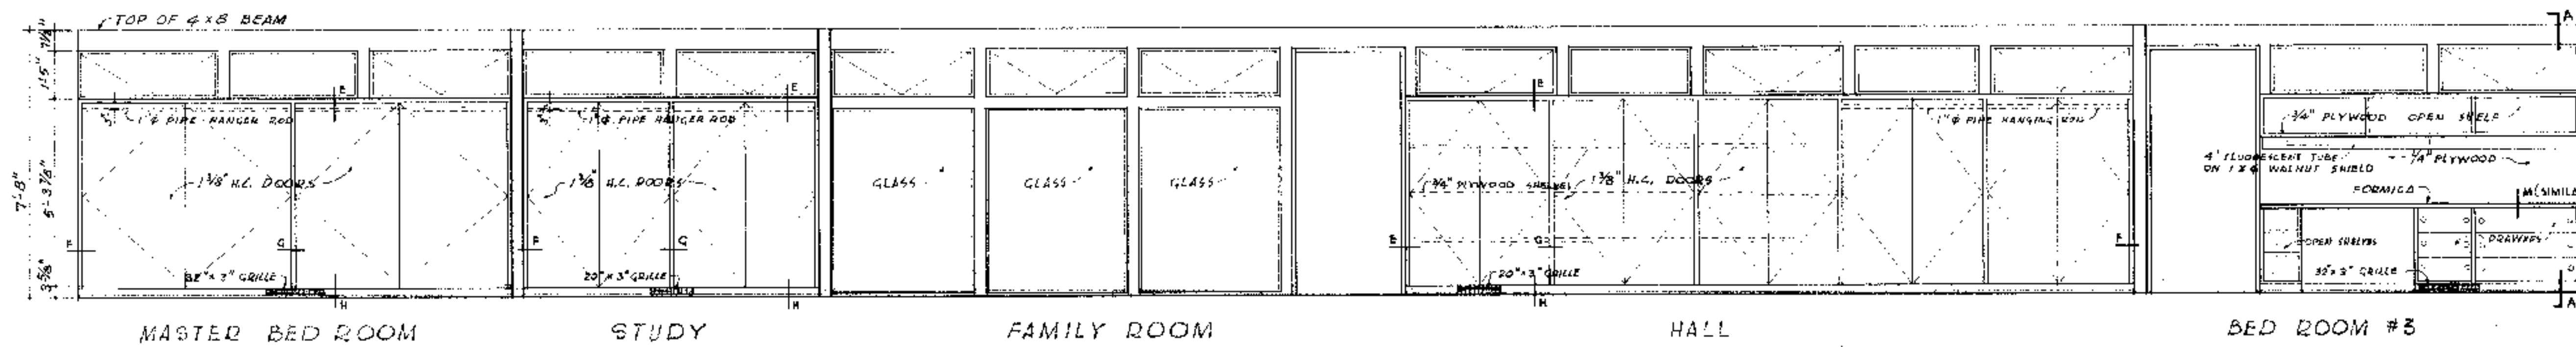


WM. H. HIDEELL, JR.
 ARCHITECT
 3010 BLACKBURN ST. DALLAS 4, TEXAS
 A RESIDENCE FOR
 MR & MRS R. R. HIDEELL
 AUSTIN TEXAS




JOB NO. DATE DRAWN BY CHECKED BY SHEET NO.
 602 9-1-56 4 H OF 16

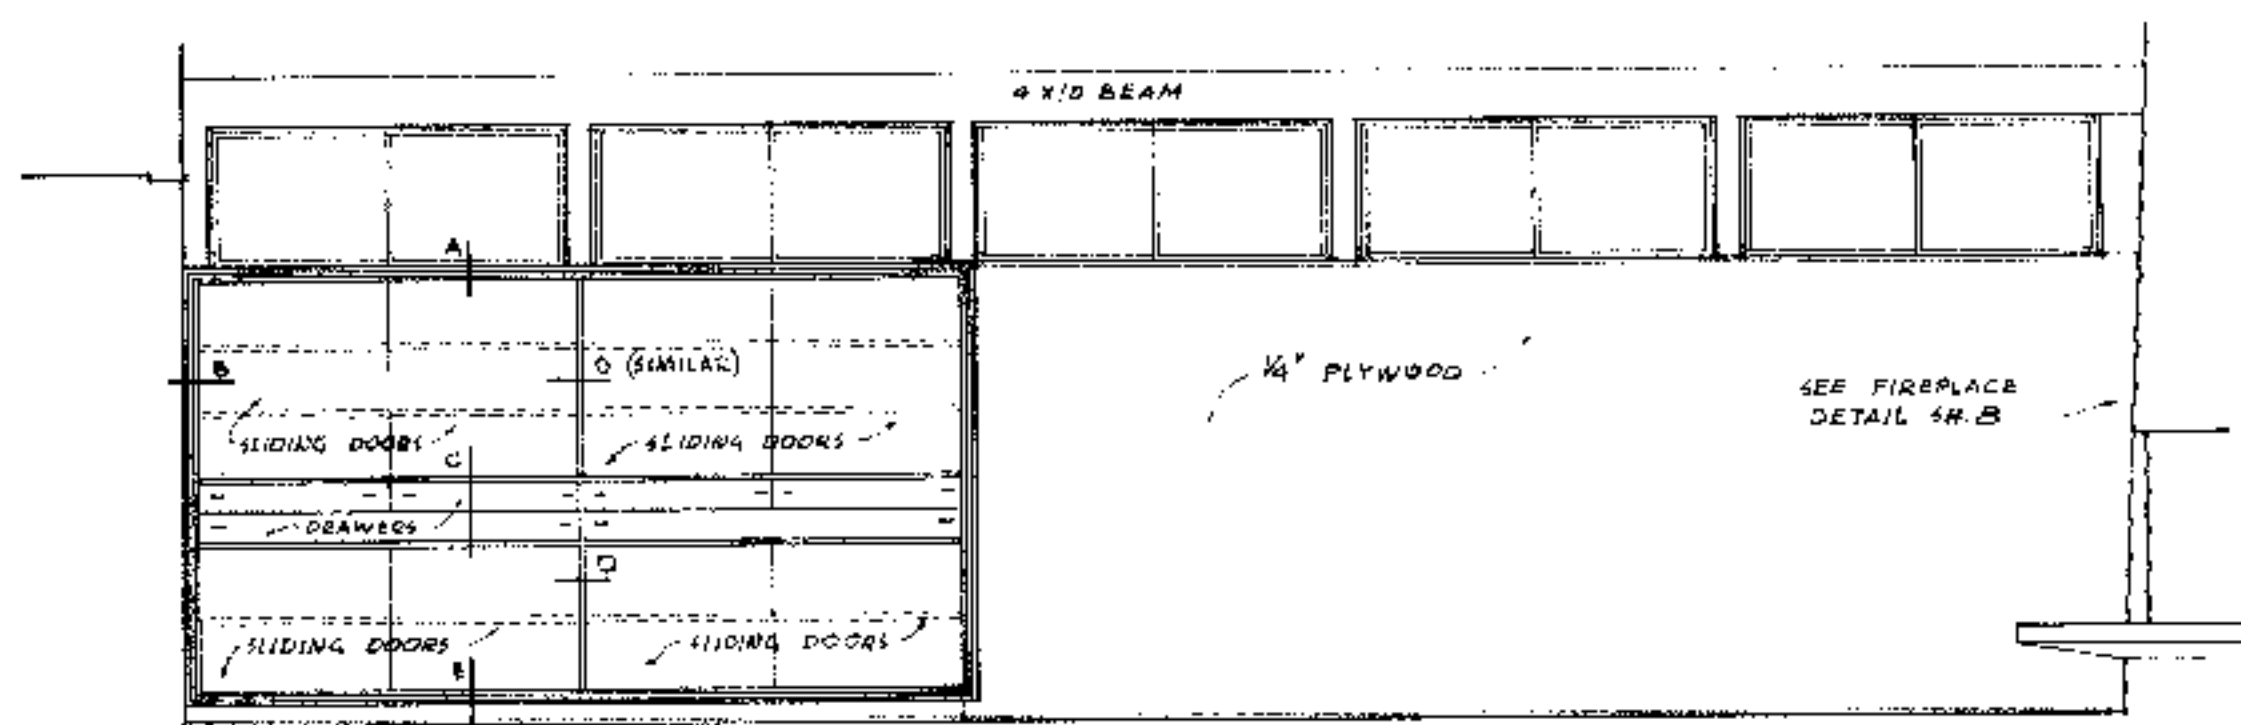

EAST ELEVATION LIVING-DINING ROOM
SCALE: 1/8" = 1'-0"

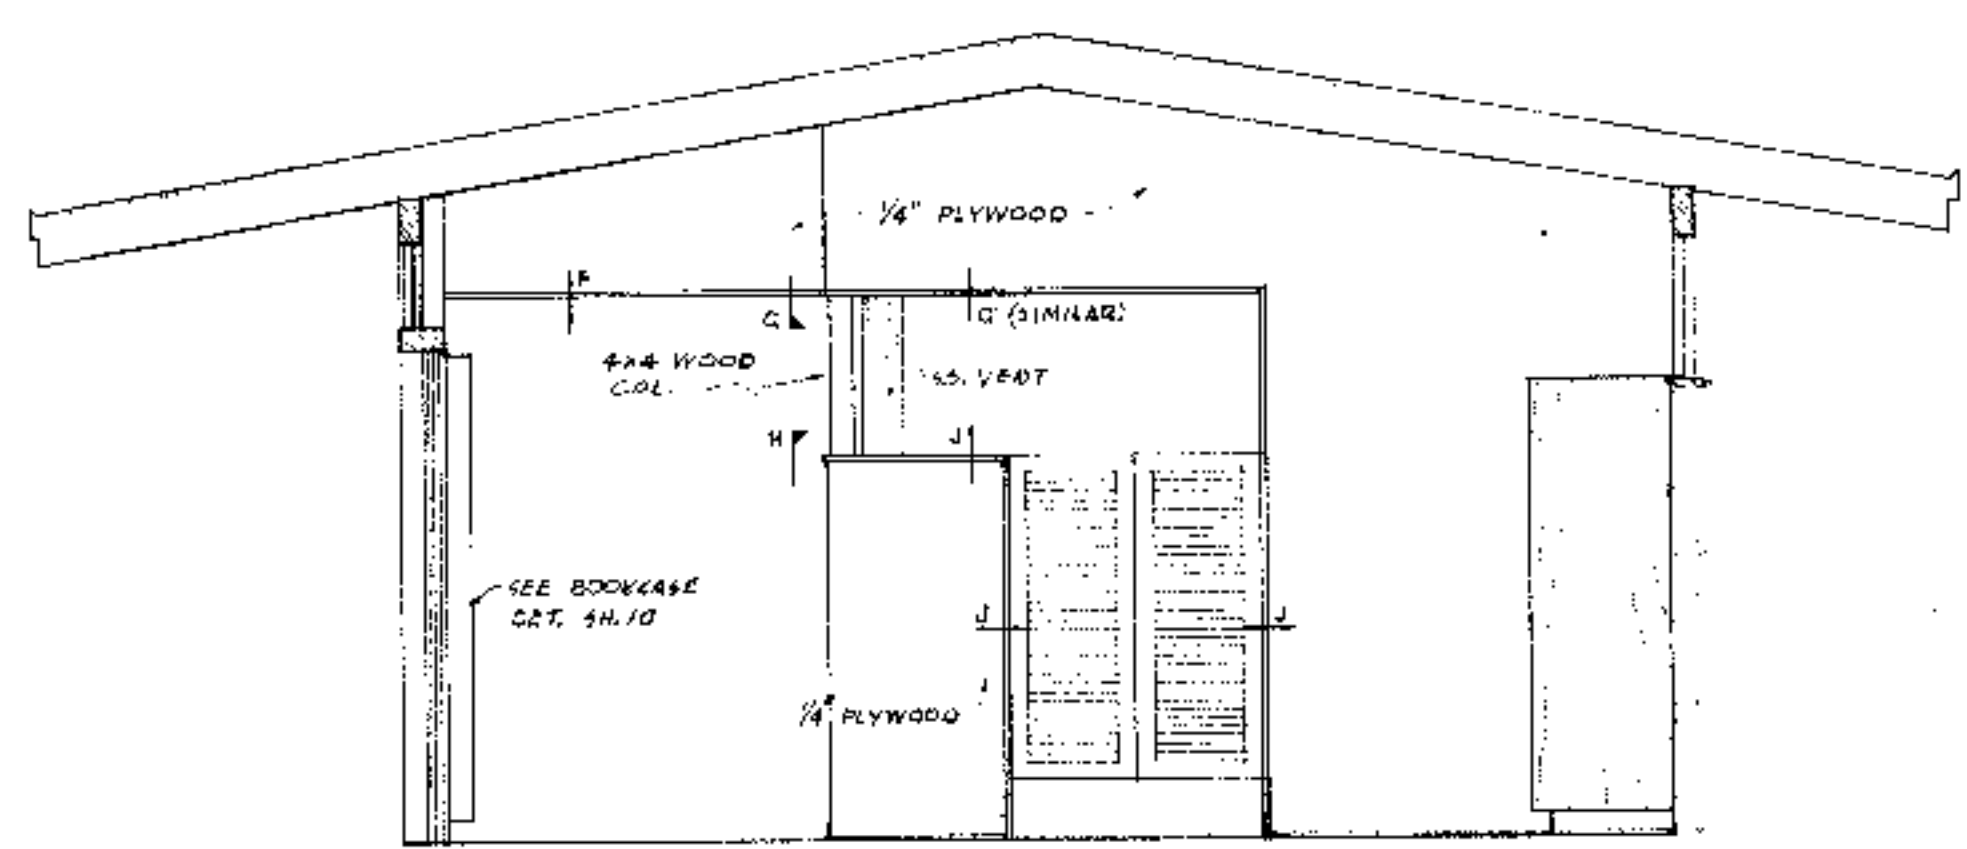


NORTH ELEVATION LIVING-DINING ROOM
SCALE: 1/8" = 1'-0"

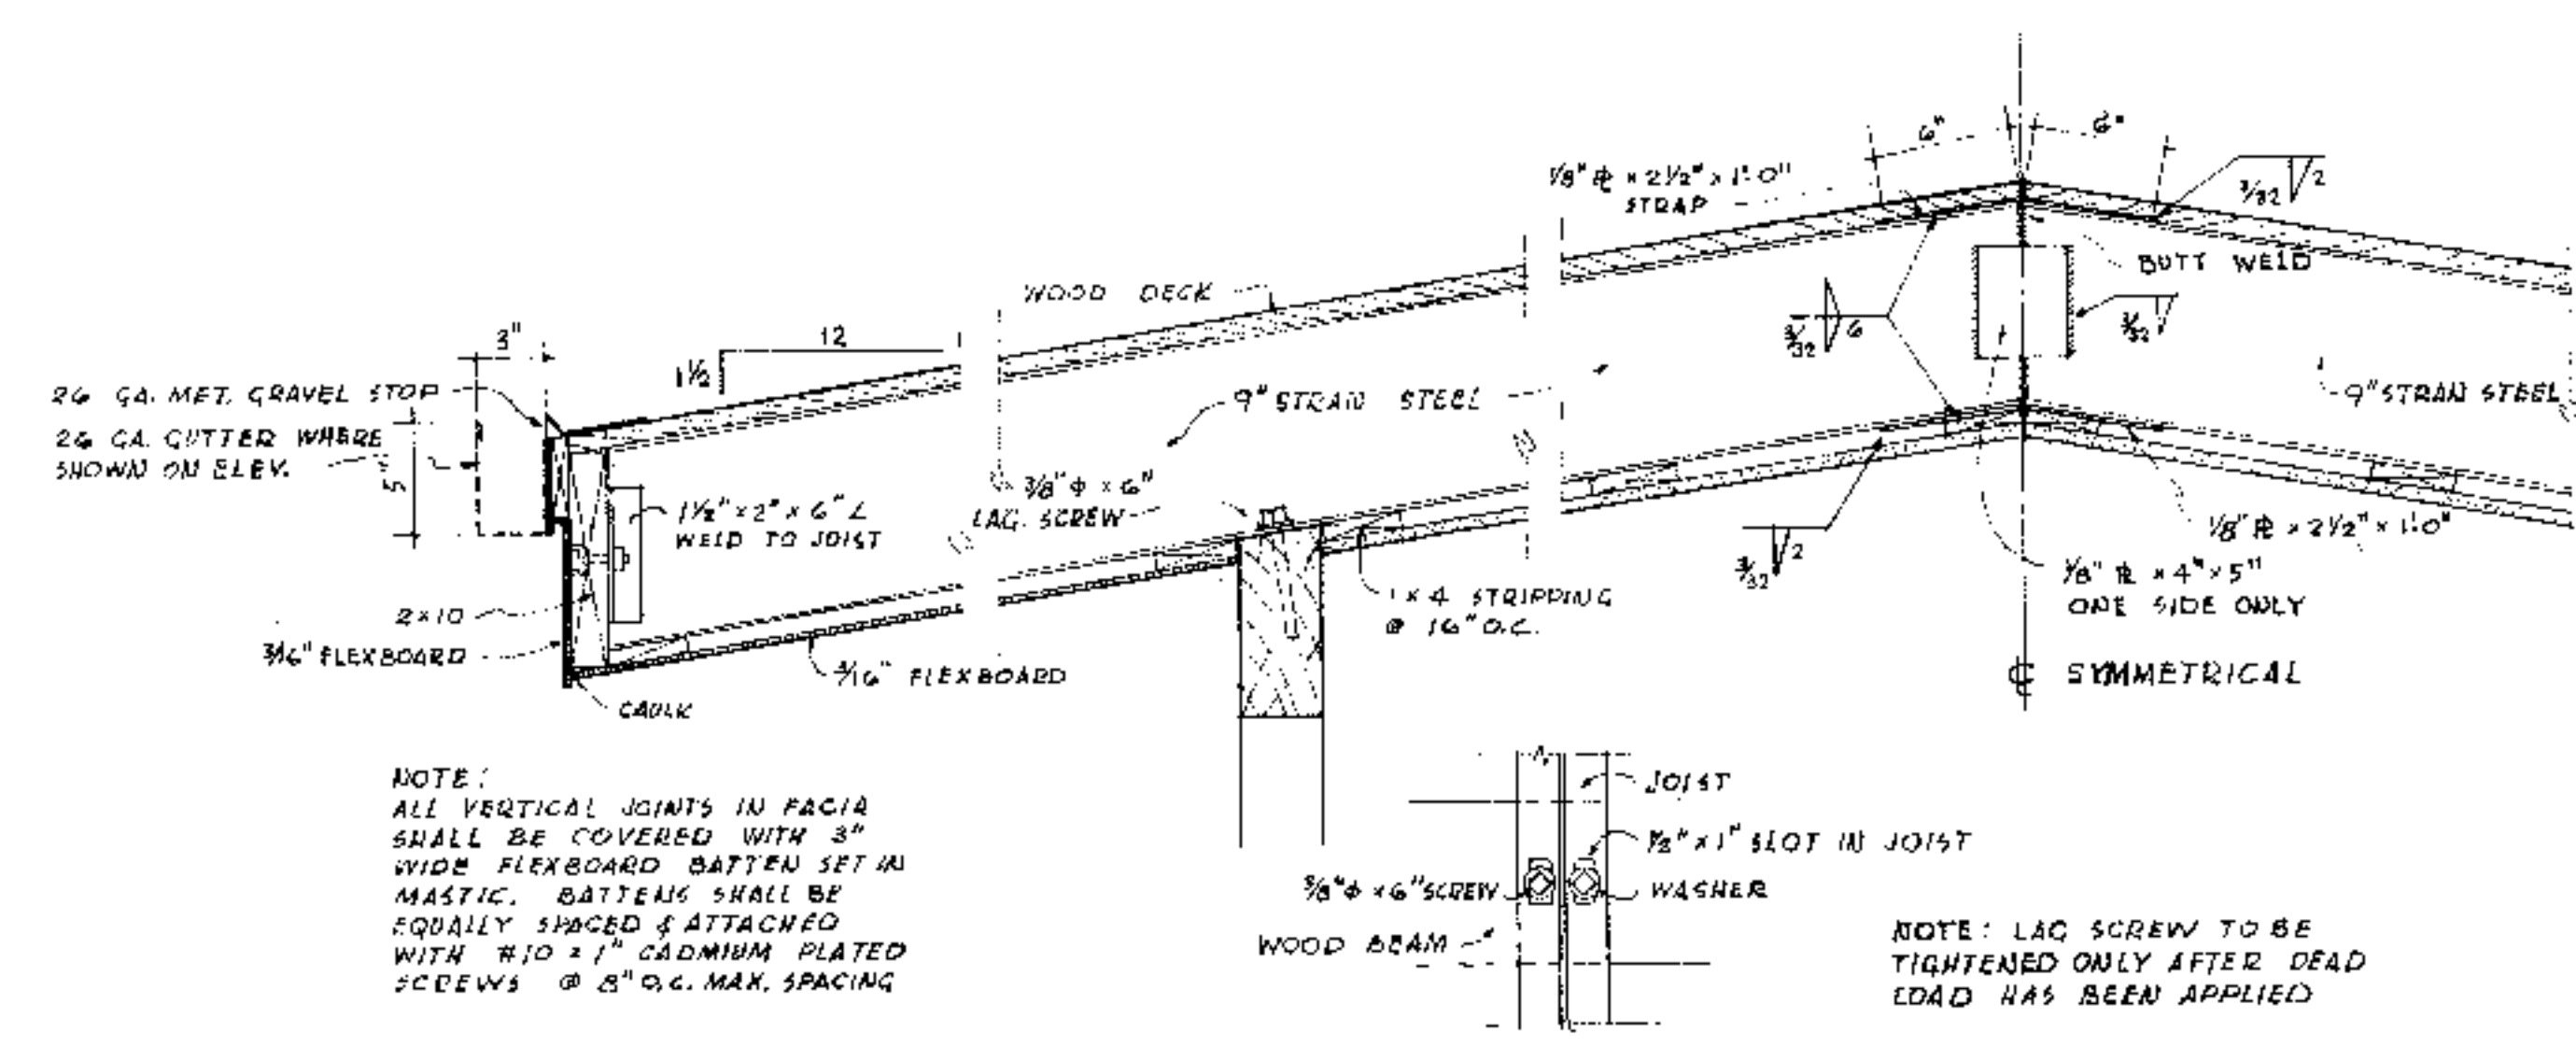


PLAN OF CONNECTION
SCALE: 3/8" = 1'-0"

DETAILS OF STEEL JOISTS
SCALE: 1/2" = 1'-0"


NOTE:
USE 9"-14 GA. JOIST @ 2'-0" O.C. FOR
20'-9" SPAN
USE 9"-16 GA. JOIST @ 2'-0" O.C. FOR
18'-0" SPAN
3 ROWS BRIDGING EA. SPAN

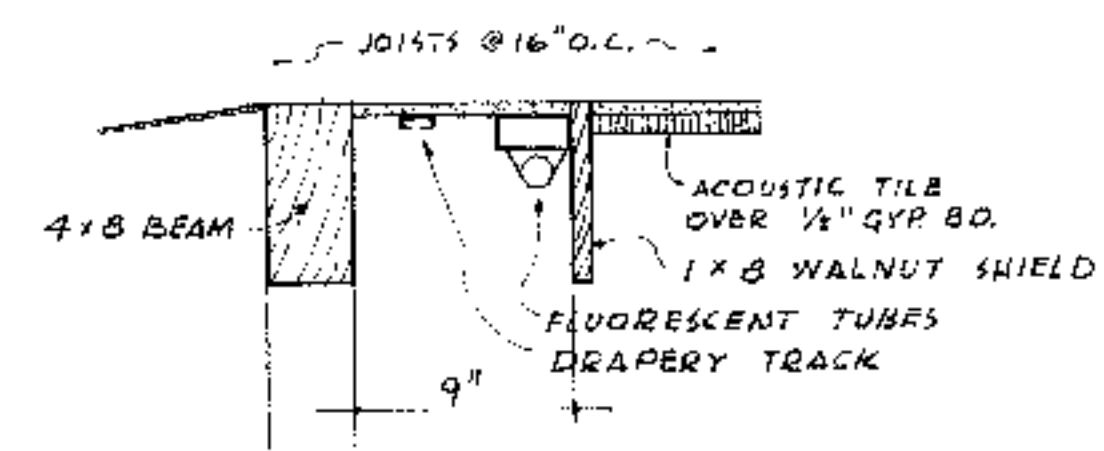


LIGHT TROUGH IN FAMILY RM.
SCALE: 1/2" = 1'-0"

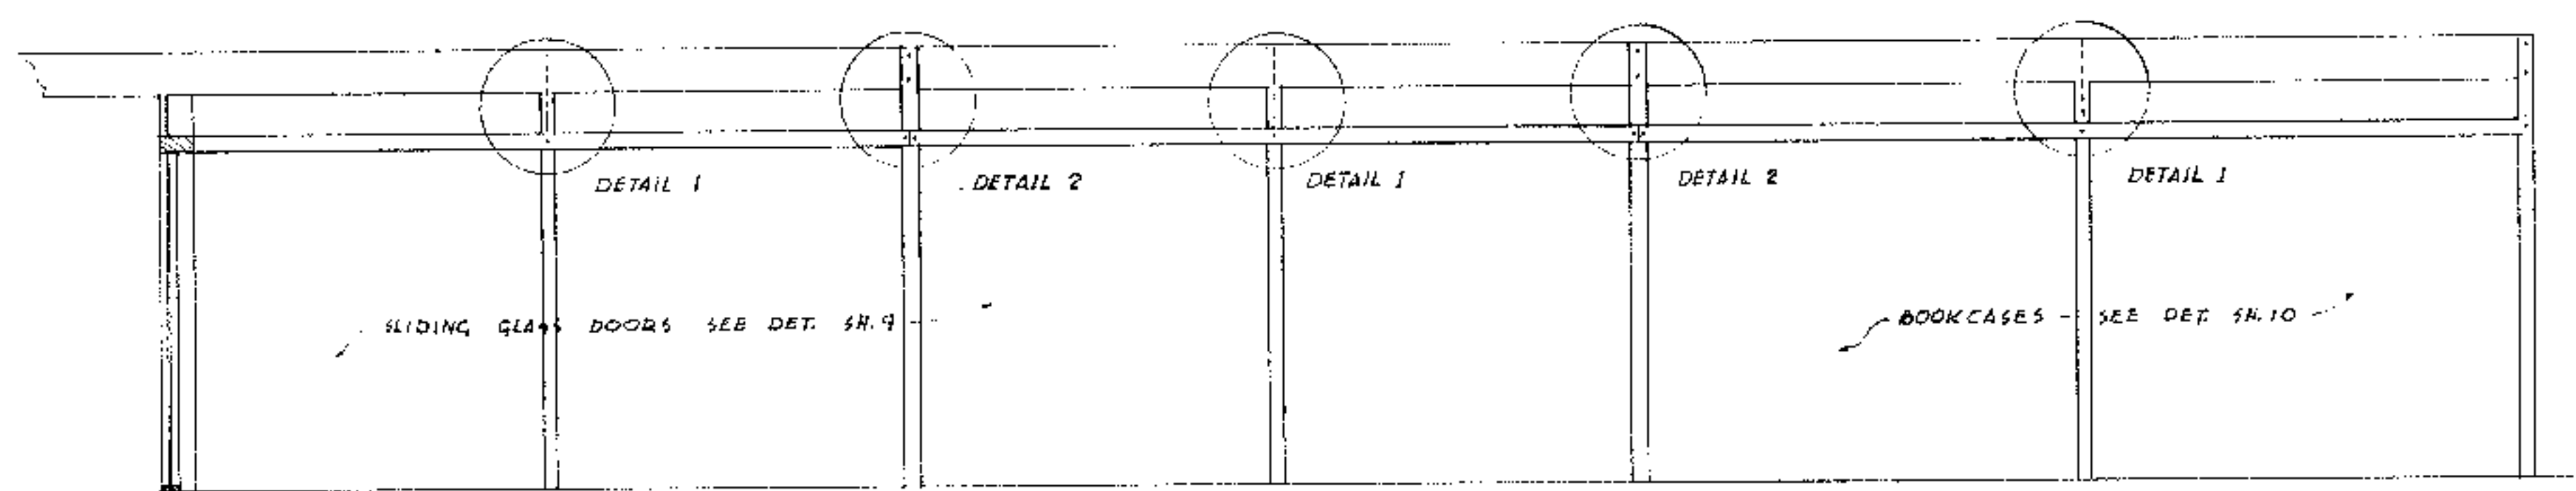


ELEVATION OF WEST WALL IN LIVING RM.
SCALE: 3/8" = 1'-0"

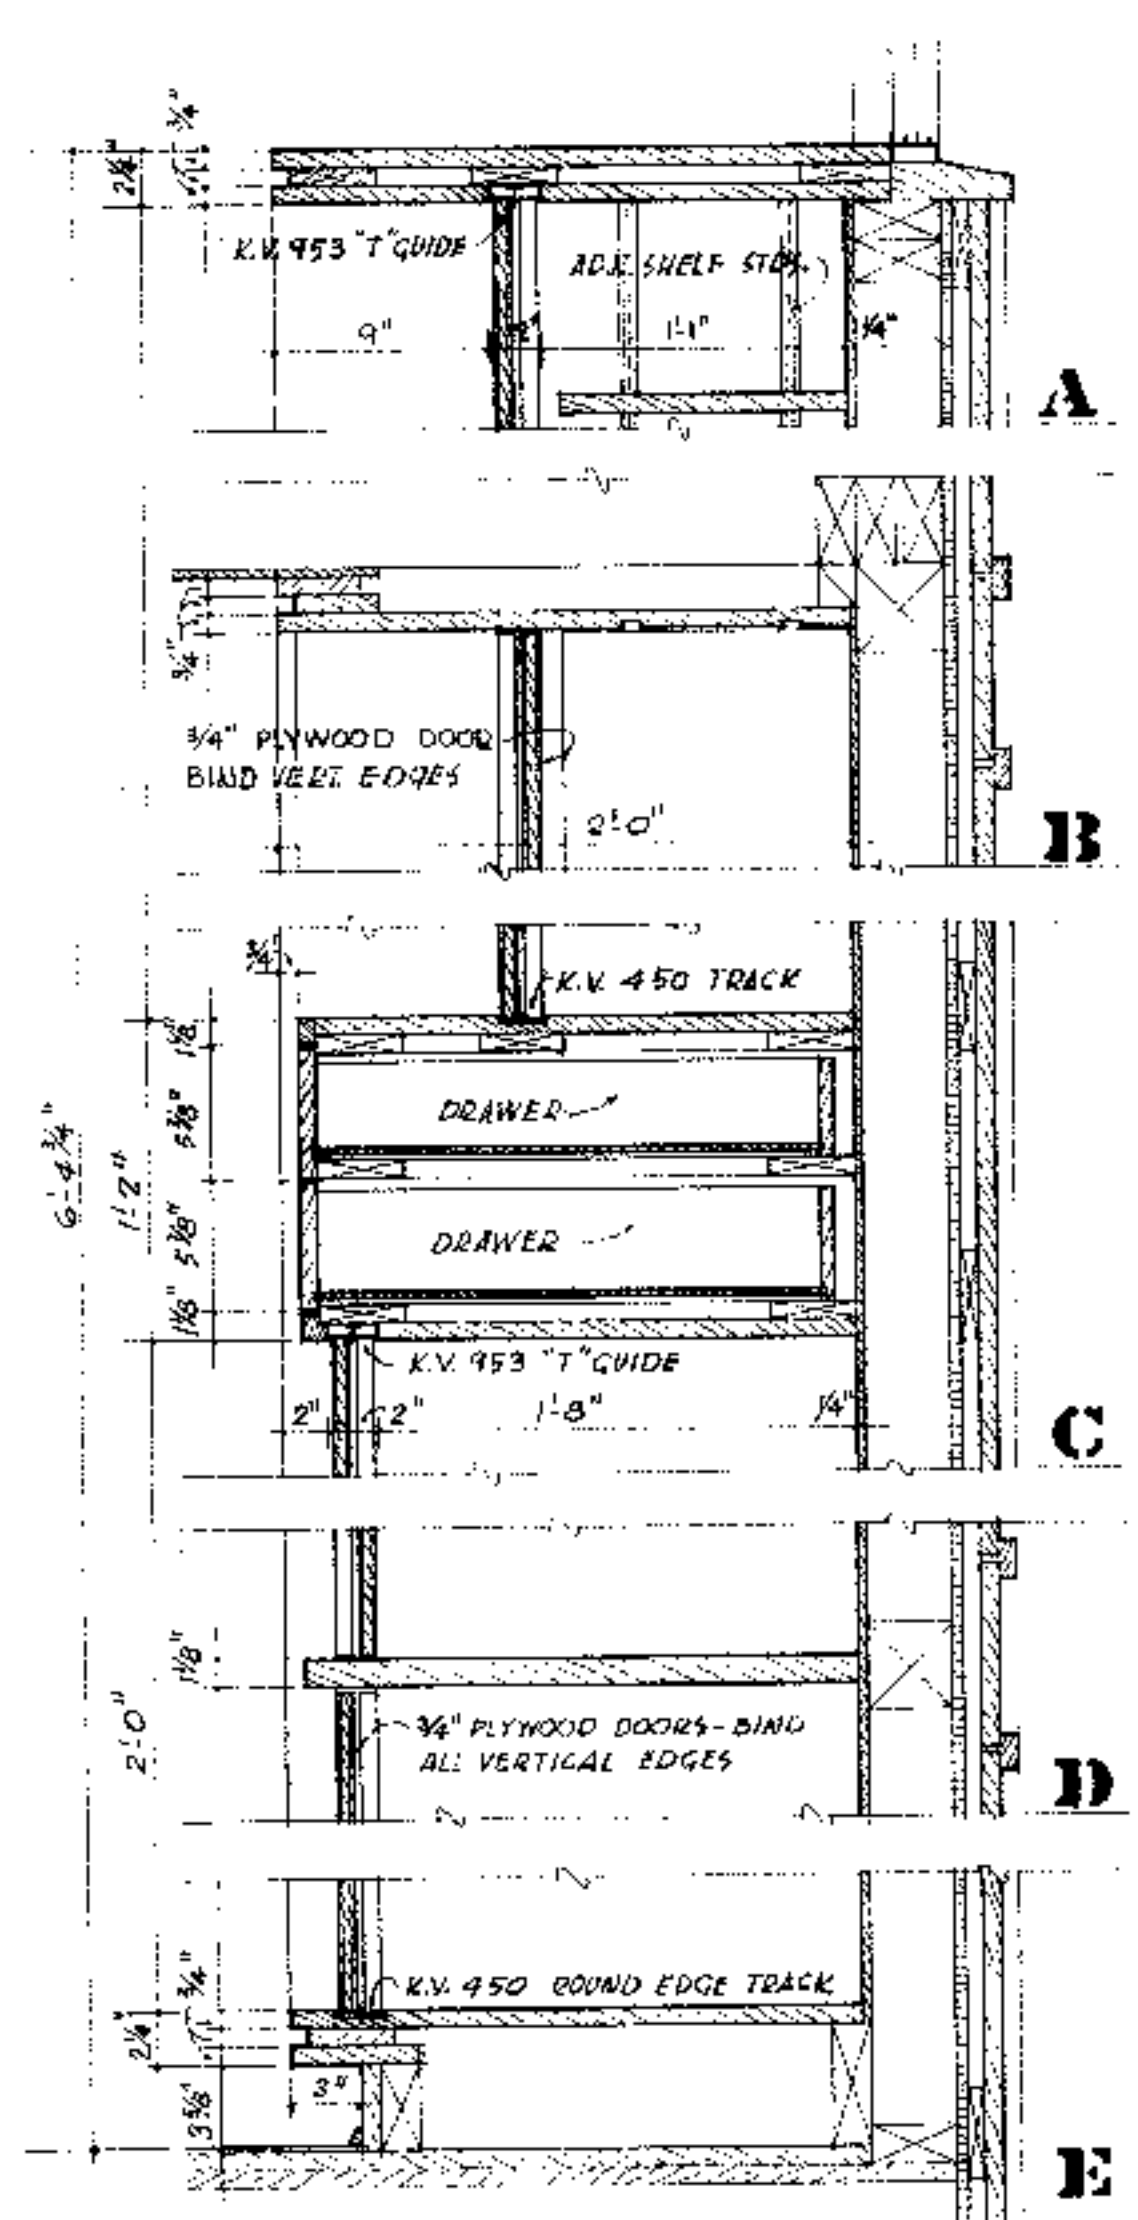


LIVING-DINING DETAILS
SCALE: 1/2" = 1'-0"

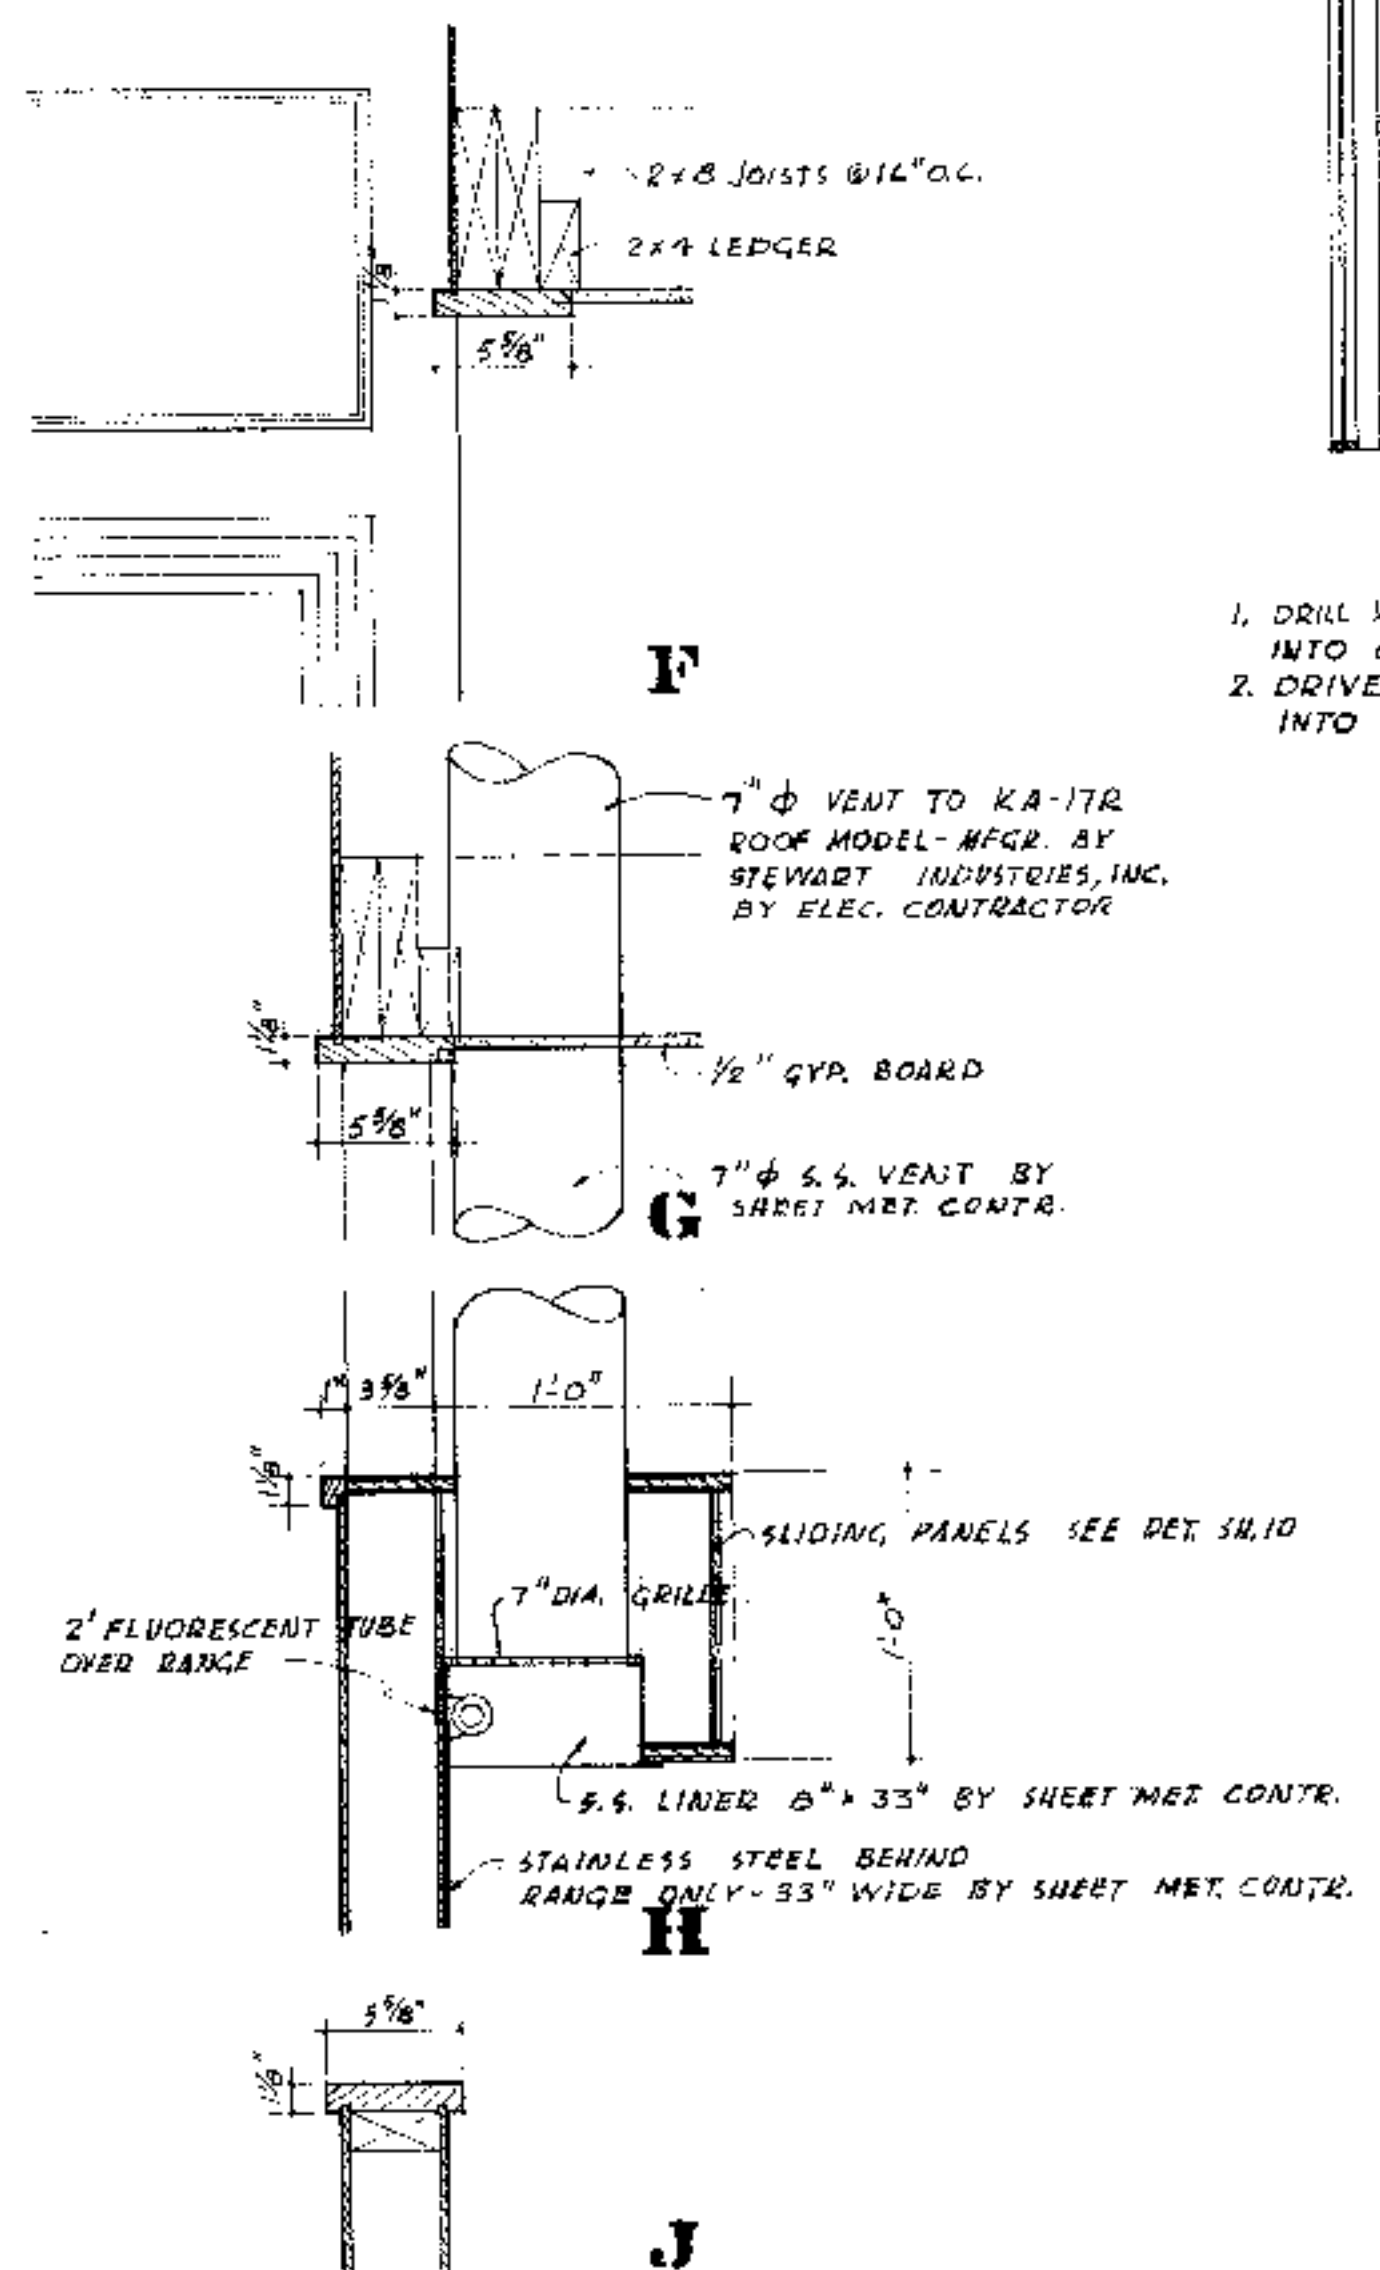

1. DRILL 1/4" TO 3/8" HOLE THROUGH BEAM & INTO COLUMN 9"
2. DRIVE 18"-36" 3/8" 4 DEFORMED ROD INTO HOLE

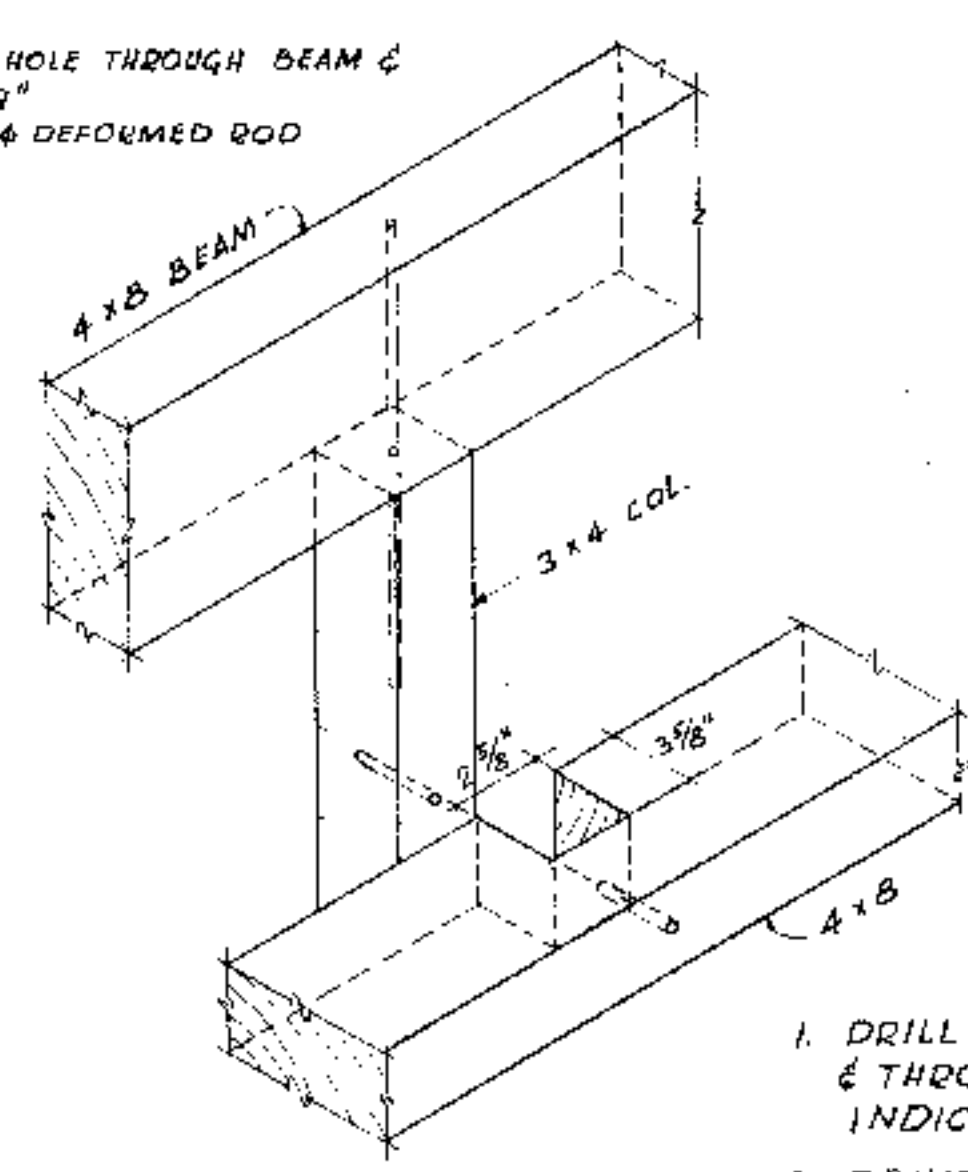


DETAIL 1

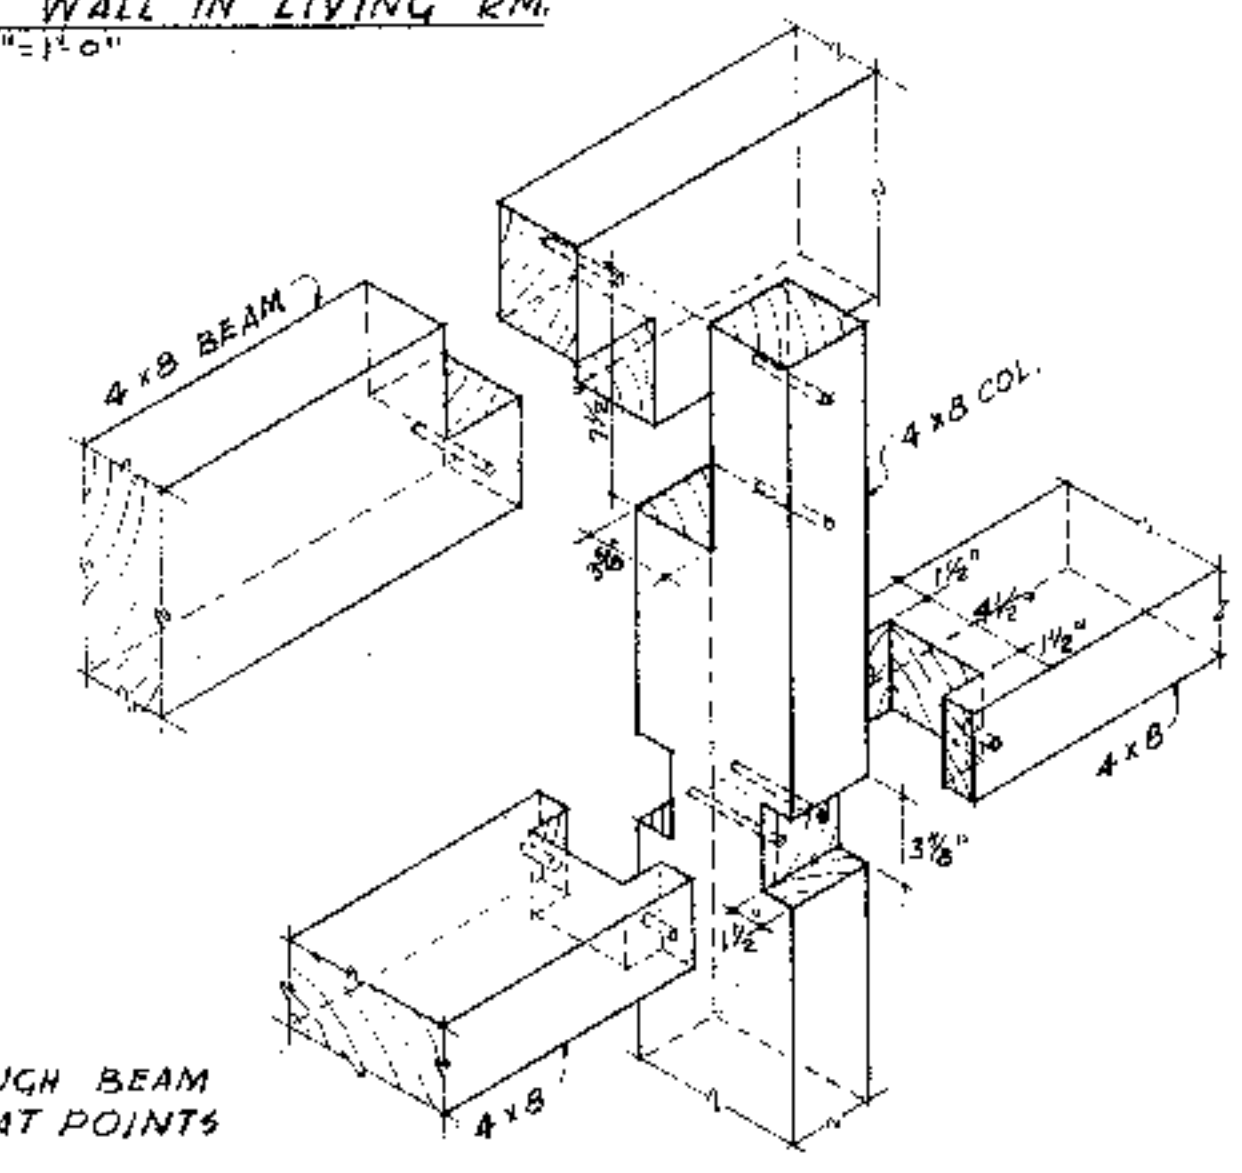

DETAIL 2

1. DRILL 3/8" HOLE THROUGH BEAM & THROUGH COLUMN AT POINTS INDICATED.
2. DRIVE GLUE COATED 1/2" 4 x 7 1/2" WOOD DOWEL INTO HOLE

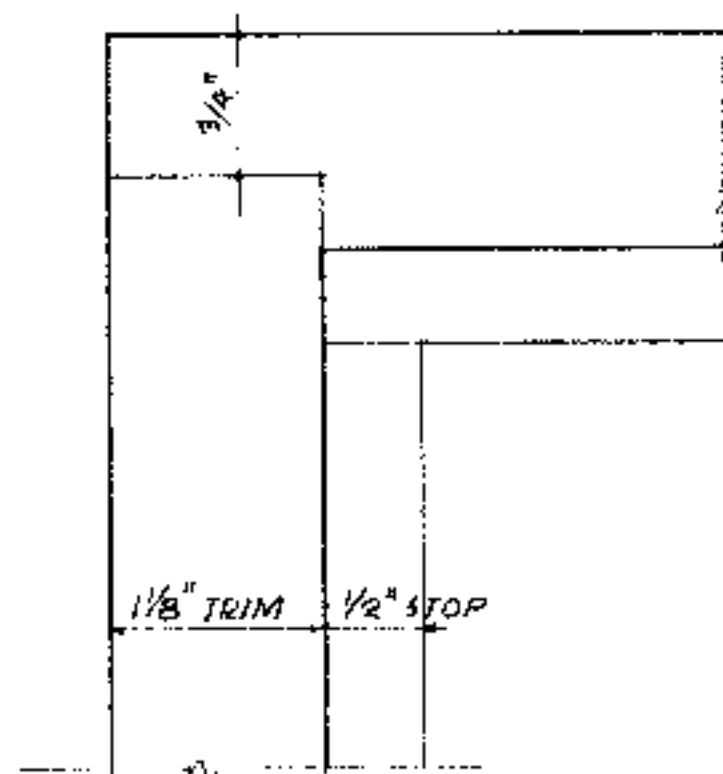


TYPICAL DOOR TRIM
CORNER F.S. DETAIL

WM. H. HIDEELL, JR.
ARCHITECT
3010 BLACKBURN ST. DALLAS 4, TEXAS

A RESIDENCE FOR
MR. & MRS. R. R. HIDEELL
AUSTIN, TEXAS


JOB NO. DATE DRAWN BY CHECKED BY SHEET NO.
602 9-1-56 AA H OF 16



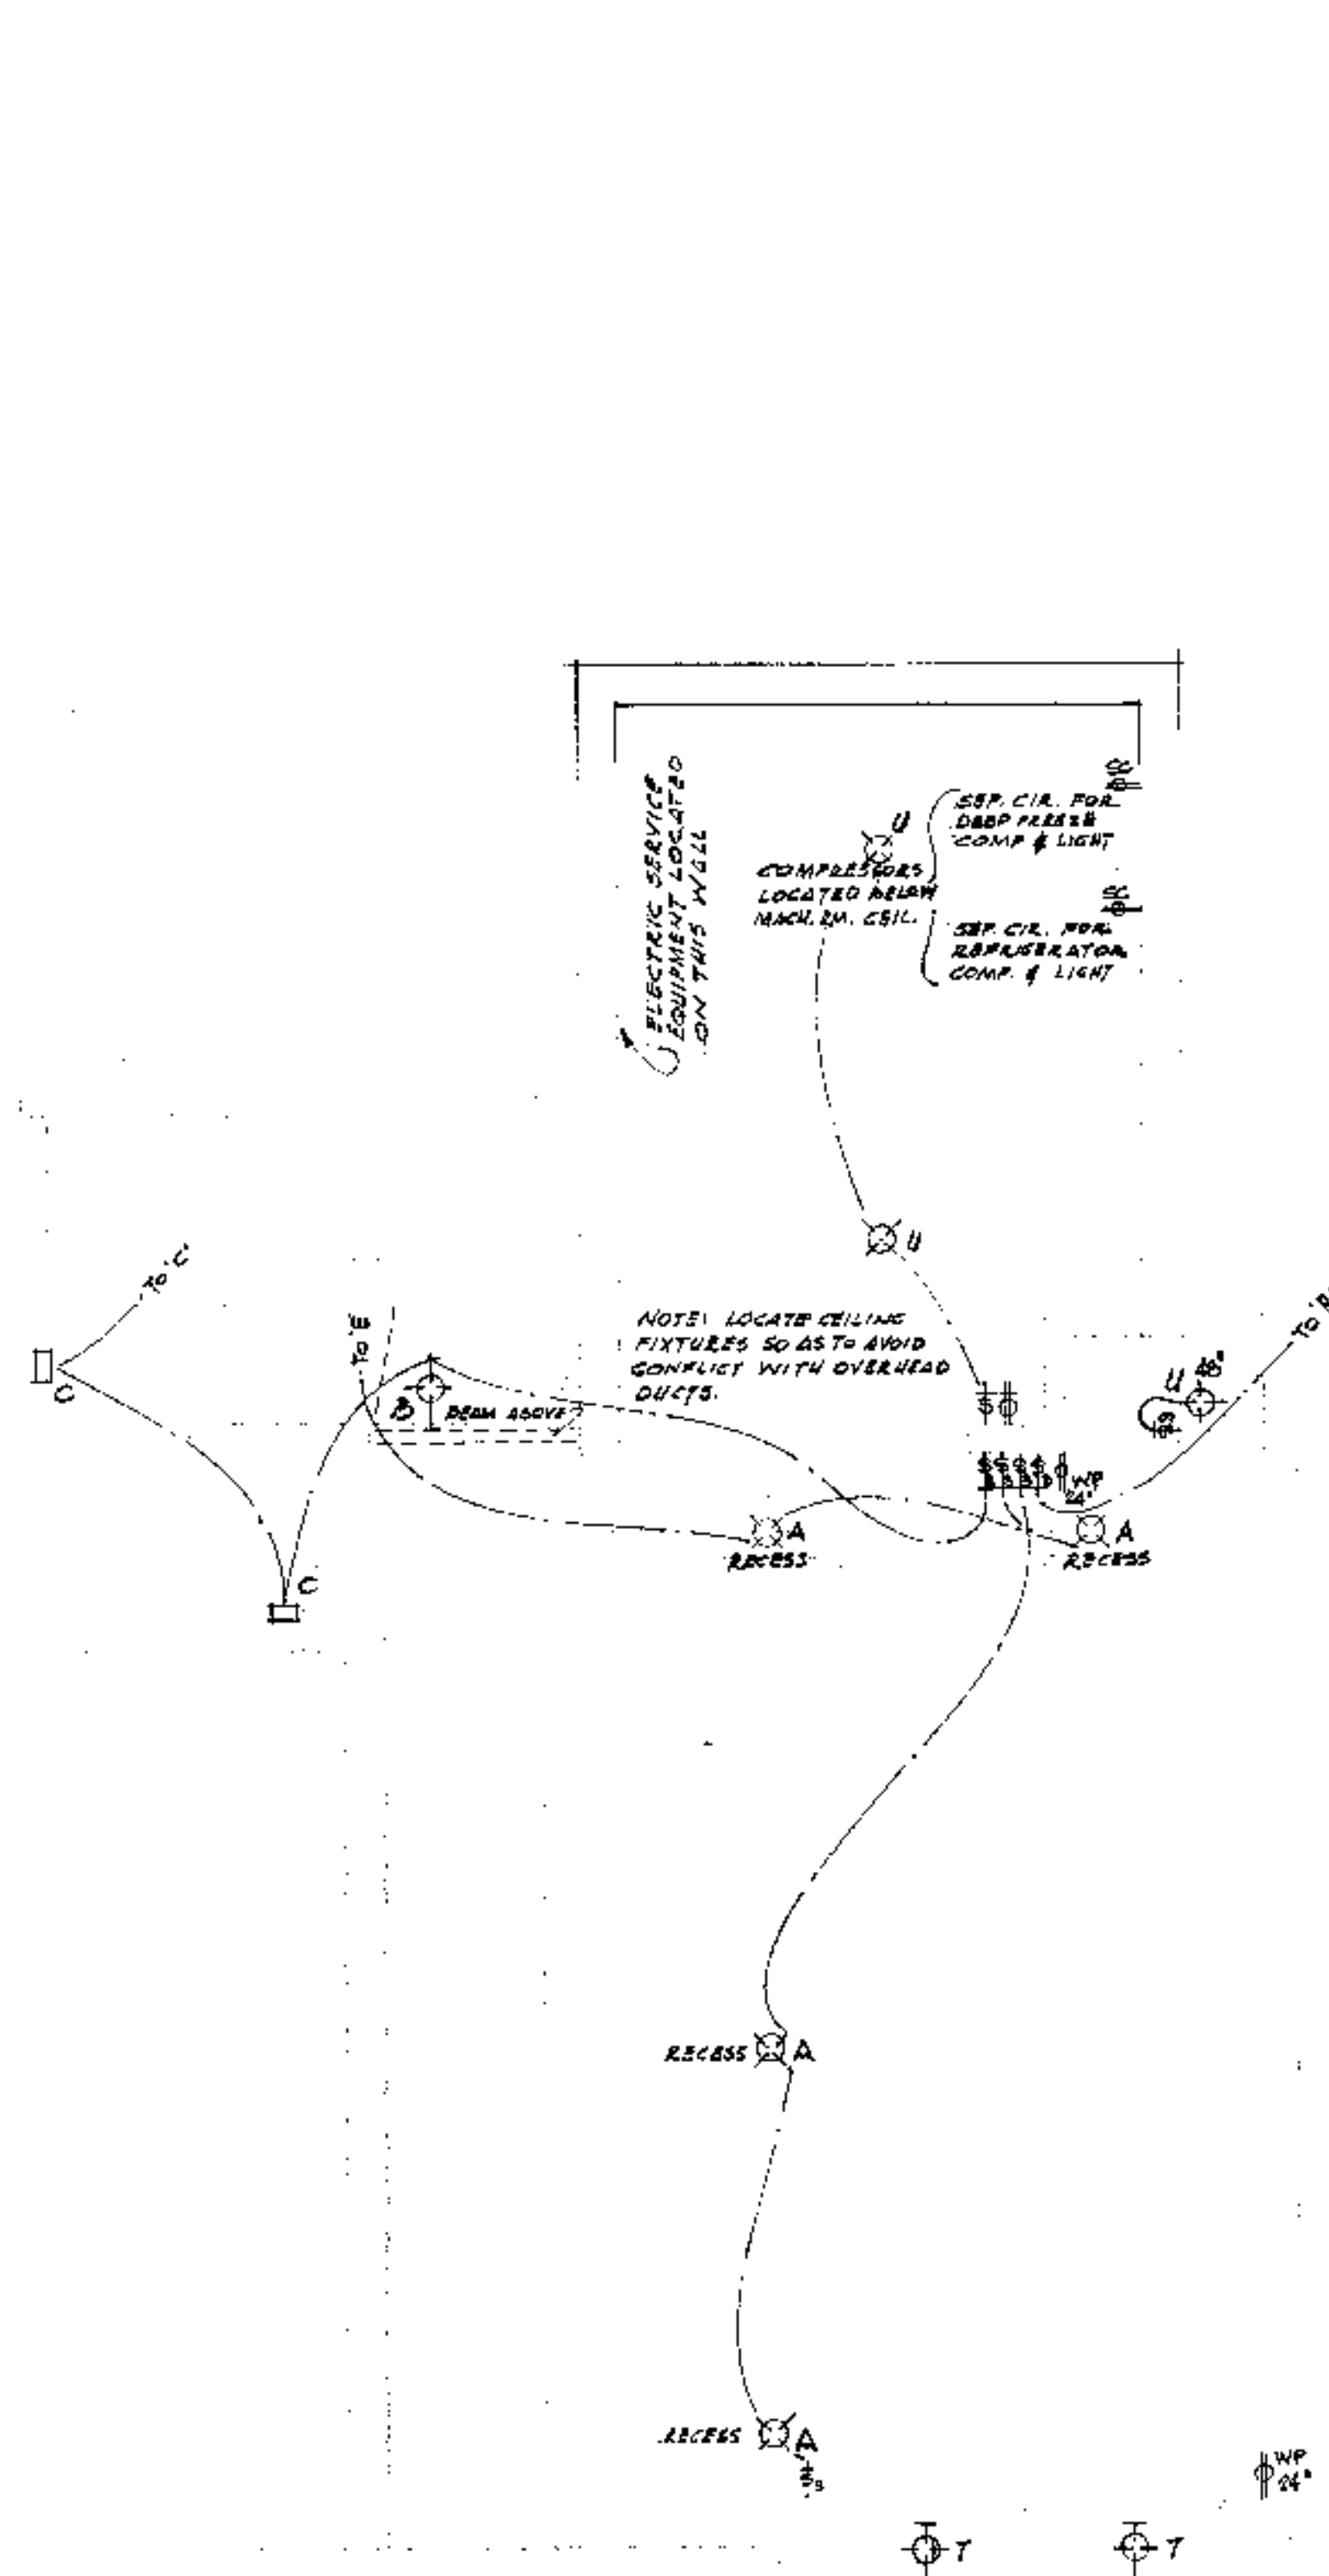

LOWER LEVEL
ELECTRICAL PLAN
SCALE 1/4" = 1'-0"

MARK	DESCRIPTION	LAMPS
A	LIGHTOLIER No. 7924 PAINT GRAY	1 75W A
B	LITECRAFT No. H6418 SATIN BRASS WITH G99 LOUVER	2 75W A30 FLOOD
C	LITECRAFT No. E672 SATIN BRASS 24" ABOVE STAIRHEAD	1 60W A
D	LITECRAFT No. F364 SATIN BRASS	1 150W PAR SPOT
E	LITECRAFT No. H6378 SATIN BRASS WITH G99 LOUVER	1 75W A30 FLOOD
F	LITECRAFT No. H6378 SATIN BRASS WITH G99 LOUVER	1 75W A30 SPOT
G	LIGHTOLIER No. 40626 POLISHED BRASS	1 100W A
H	LIGHTOLIER No. 4127 POLISHED BRASS	1 150W A
I	LITECRAFT No. H6378 SATIN BRASS WITH G99 LOUVER	1 150W PAR 38 FLOOD
J	ARROW No. G411 BRUSHED BRASS	1 75W A
K	LIGHTOLIER No. 7971/7975 WHITE ENAMEL	1 200W RS
L	LIGHTOLIER No. 7904 WHITE ENAMEL	1 100W A
M	LIGHTOLIER No. 4417 POLISHED BRASS	1 75W R30 FLOOD
N	SUNBEAM No. 201-40 RS WHITE ENAMEL	1 40W RS
O	SUNBEAM No. 201-24 TS WHITE ENAMEL	1 20W TS
P	SUNBEAM No. HPLM 5802-46 RS WHITE ENAMEL	2 40W RS
Q	MARCO No. JG-101 SS GASKETED WATER-TIGHT	1 100W A
R	REVERE No. 9266F COST ALUMINUM	1 150W PAR 38 FLOOD
S	LIGHTOLIER No. 4313 SATIN ALUMINUM	1 75W A
T	DRYANT No. 8265 WHITE PORCELAIN - FULL CHAIN	1 75W A
U	DRYANT No. 8228 WHITE PORCELAIN	1 75W A
KITCHEN FAN	KITCHENAID No. KA 17R ROOF MODEL 1/3 SPEED SWITCH - MFG BY STEWART INDUSTRIES, INDIANAPOLIS, INDIANA.	

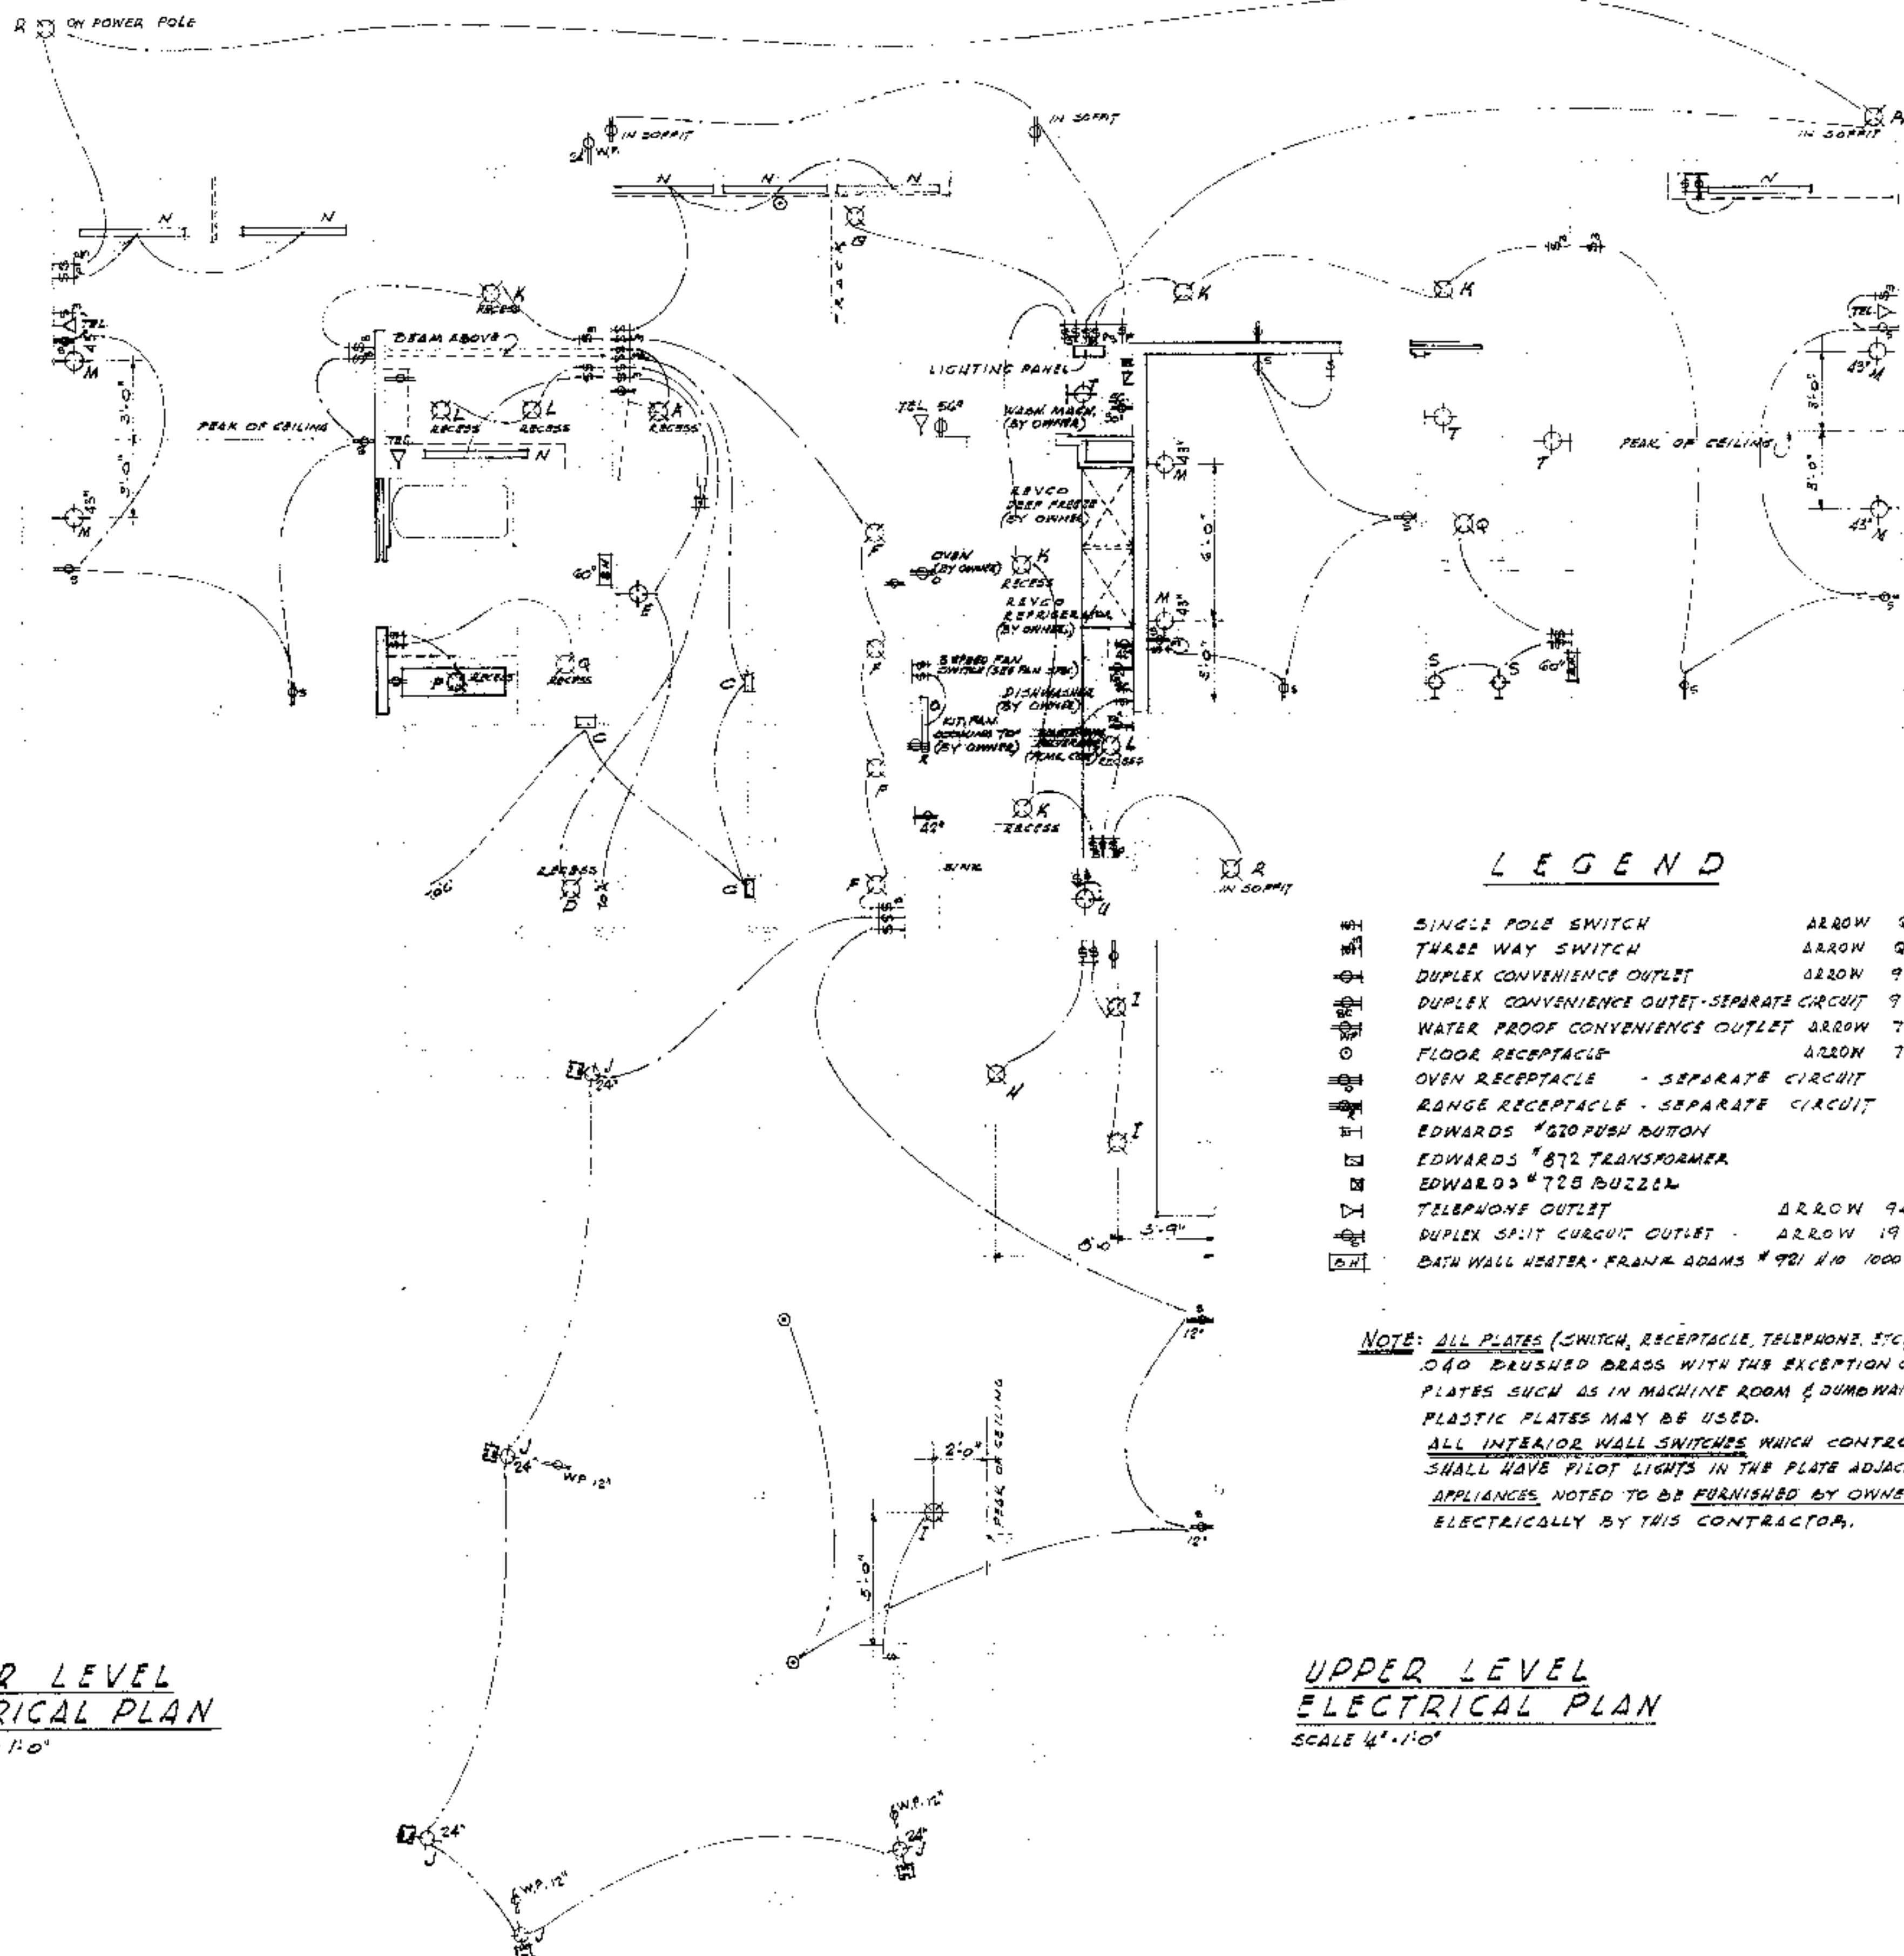

UPPER LEVEL
ELECTRICAL PLAN
SCALE 1/4" = 1'-0"

LEGEND	
SINGLE POLE SWITCH	ARROW QT-1-1
THREE WAY SWITCH	ARROW QT-3-1
DUPLEX CONVENIENCE OUTLET	ARROW 9260-1
DUPLEX CONVENIENCE OUTLET-SEPARATE CIRCUIT	ARROW 9262-1
WATER PROOF CONVENIENCE OUTLET	ARROW 7865 BRUSHED BRASS
FLOOR RECEPTACLE	ARROW 7797
OVEN RECEPTACLE - SEPARATE CIRCUIT	
RANGE RECEPTACLE - SEPARATE CIRCUIT	
EDWARDS #670 PUSH BUTTON	
EDWARDS #672 TRANSFORMER	
EDWARDS #728 BUZZER	
TELEPHONE OUTLET	ARROW 94181
DUPLEX SPILT CURCUT OUTLET	ARROW 1914-1
BATH WALL HEATER - FRANK ADAMS #921 #10 1000W 220V	

NOTE: ALL PLATES (SWITCH, RECEPTACLE, TELEPHONE, ETC.) SHALL BE 1040 BRUSHED BRASS WITH THE EXCEPTION OF CONCEALED PLATES SUCH AS IN MACHINE ROOM & DUMP WATERS SHIRT WHERE PLASTIC PLATES MAY BE USED.
ALL INTERIOR WALL SWITCHES WHICH CONTROL EXTERIOR LIGHTS SHALL HAVE PILOT LIGHTS IN THE PLATE ADJACENT TO THE SWITCH.
APPLIANCES NOTED TO BE FURNISHED BY OWNER SHALL BE CONNECTED ELECTRICALLY BY THIS CONTRACTOR.

A RESIDENCE FOR
MR. & MRS. R. R. HIDEELL
AUSTIN
TEXAS
J. M. [Signature]
GOS 9-1-56



