
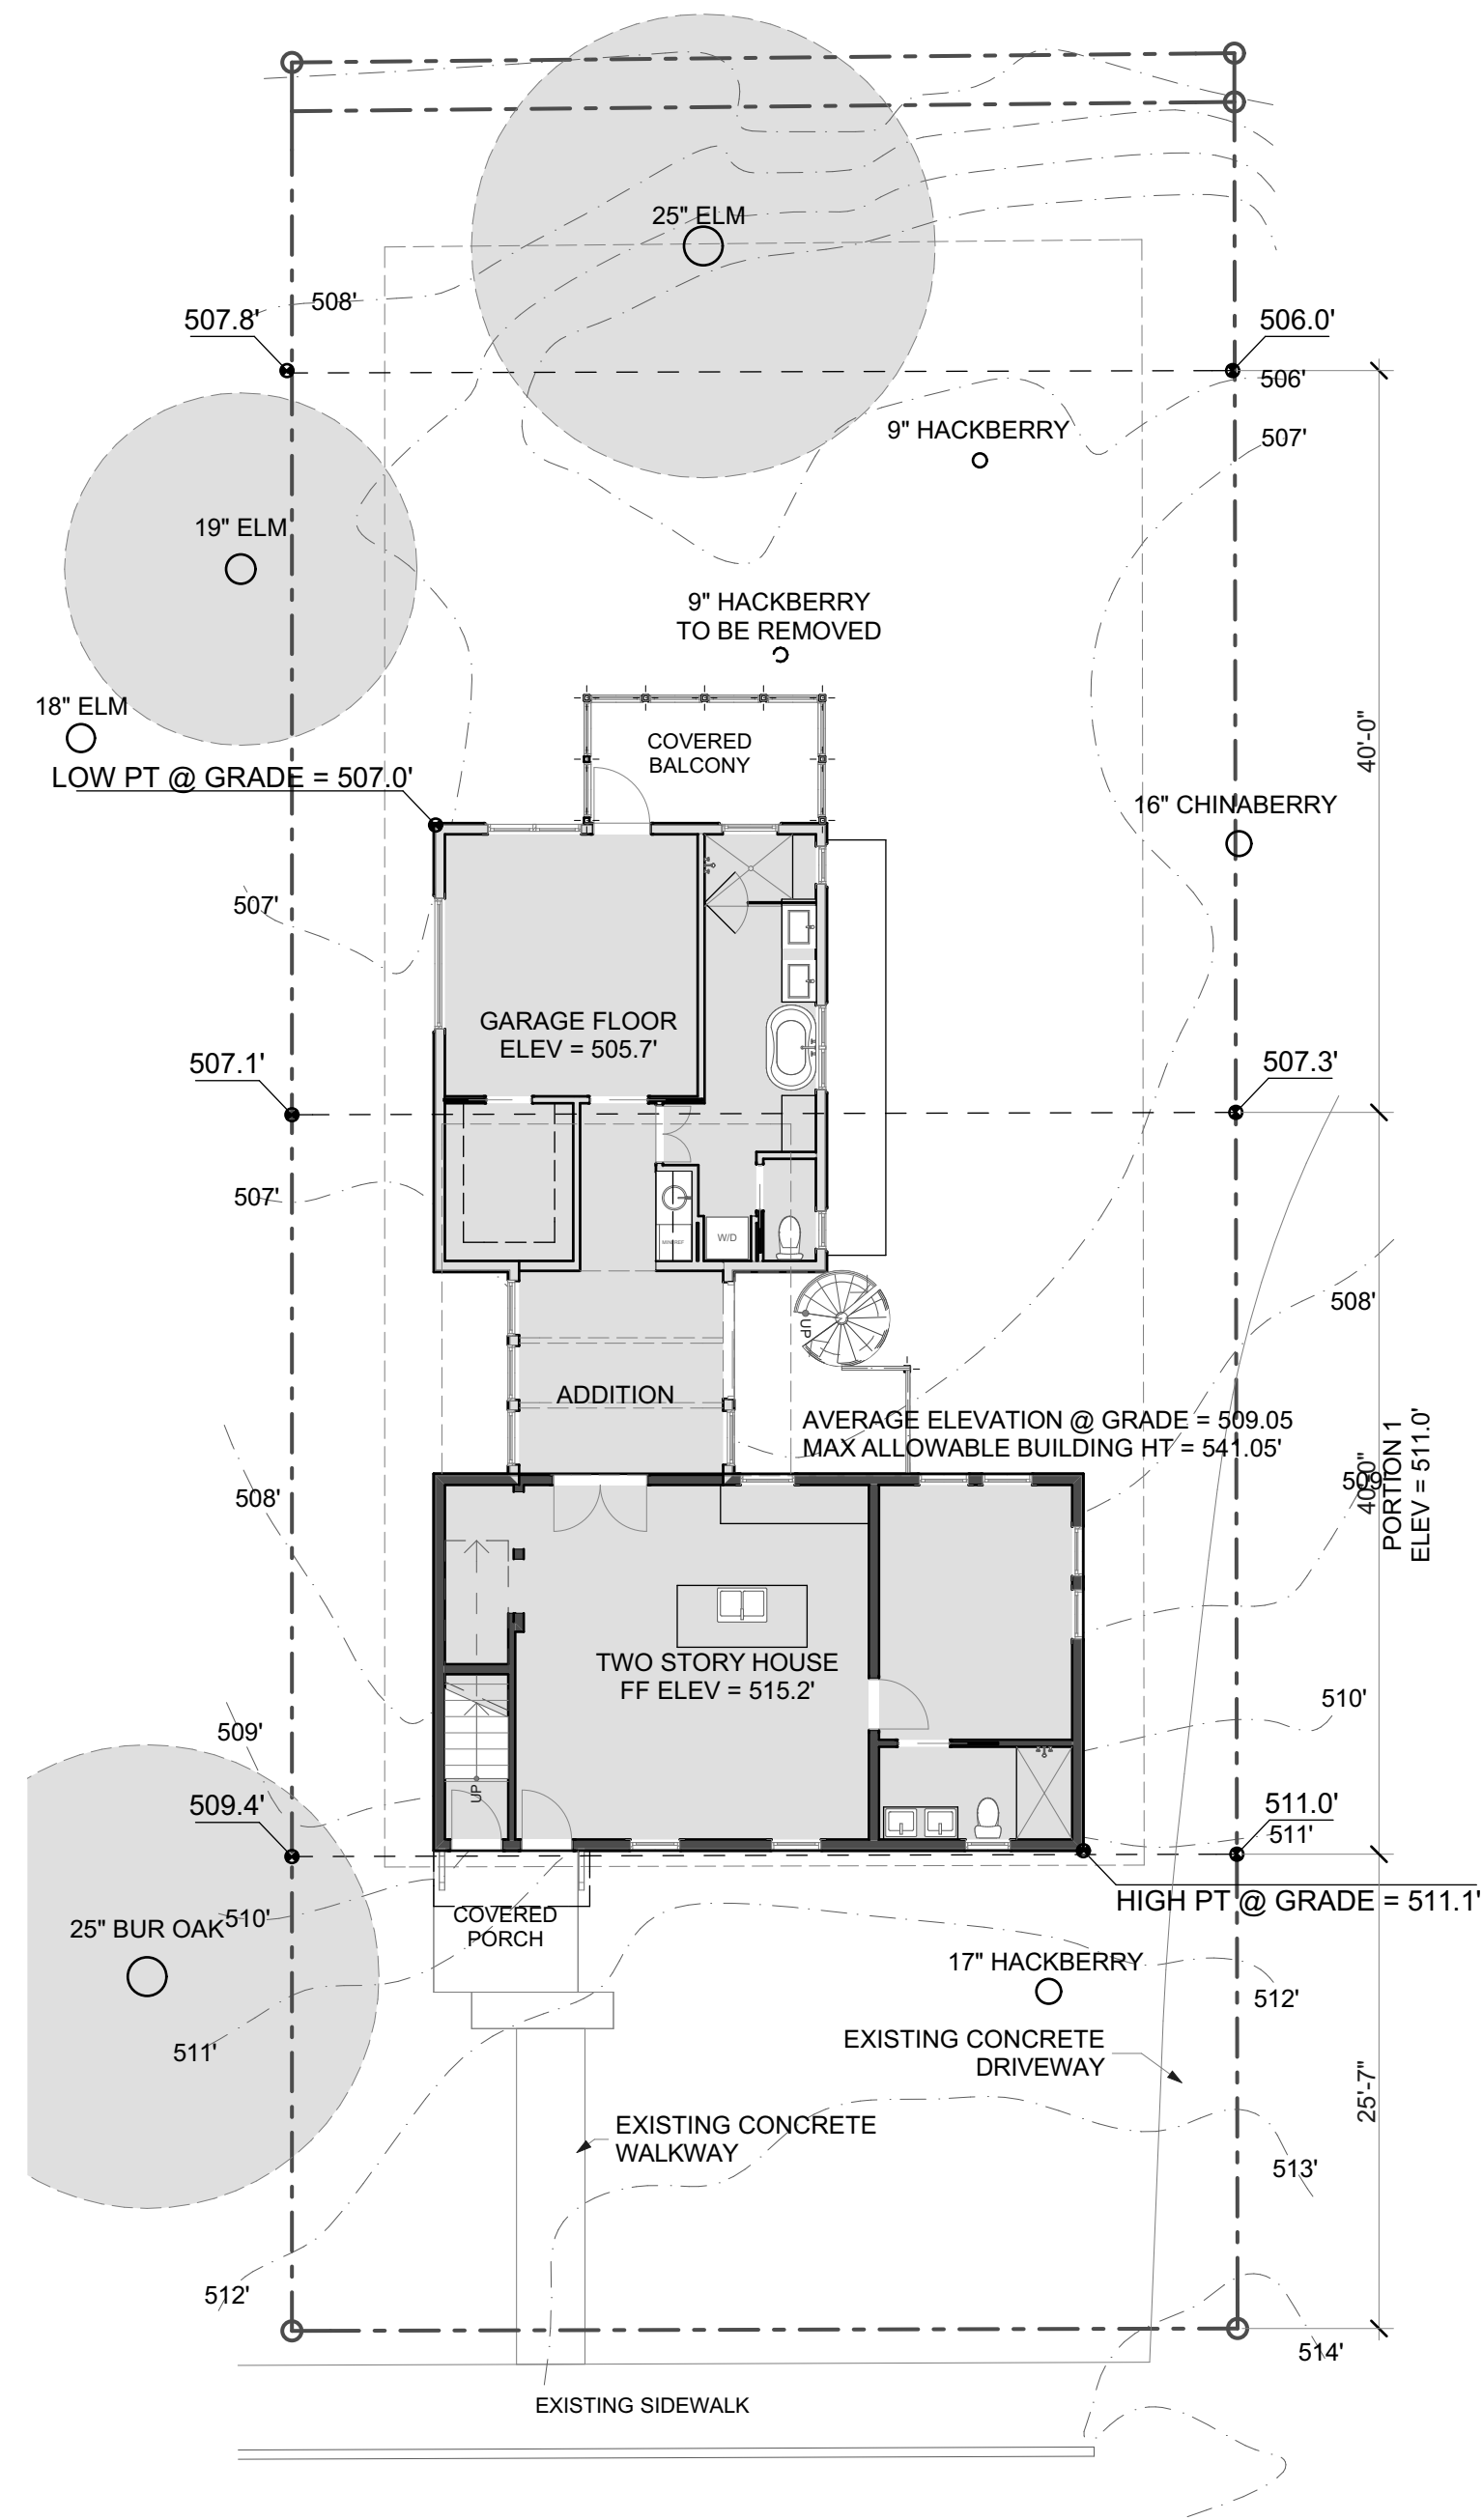
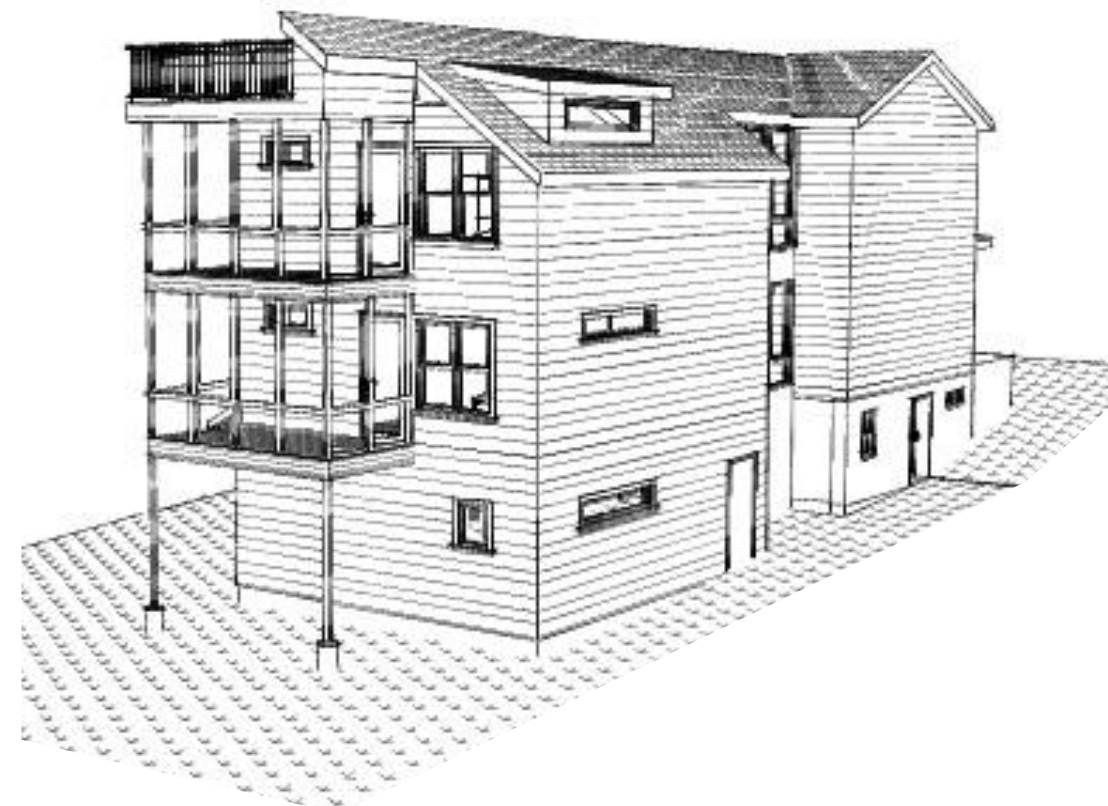


C:\Users\hick\Documents\Mehl Personal\NANABODE\ERTLE\ERTLE Bldg Model.pln

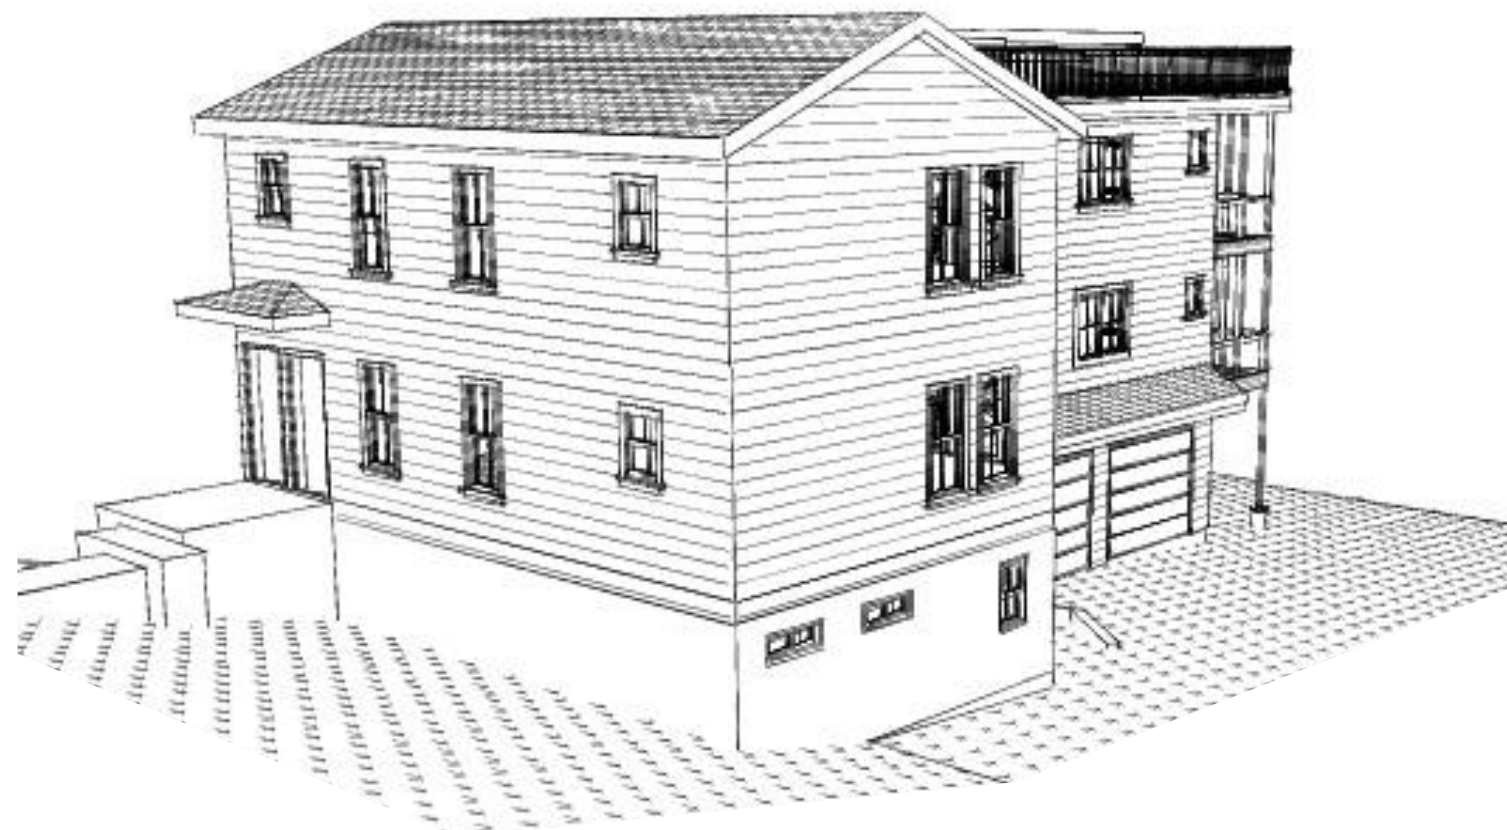

AREA CALCULATIONS (4/15/24)
SITE = 6878
GARAGE ADDITION = 637
EXISTING HOUSE - FIRST = 708
ADDITION - FIRST = 637
EXISTING HOUSE - SECOND = 708
ADDITION - SECOND = 637
ROOF DECK = 320
BALCONIES = 340
PORCH = 74
DRIVEWAY = 683
WALKWAY = 0
TOTAL CONDITIONED SF = 2690
I.C. = 25%


1 Site Plan
SCALE: 1" = 10'

MARK	DATE	PHASE
	4/26/24	CD
	4/16/24	DD
	2/28/24	SD


PROJECT NO:
MODEL FILE:
DRAWN BY:
CHK'D BY:
COPYRIGHT

SHEET TITLE
Site Plan & Gen
Notes

C:\Users\nick\Documents\Mehl Personal\NANABODE\ERTLE\Bldg Model.pln

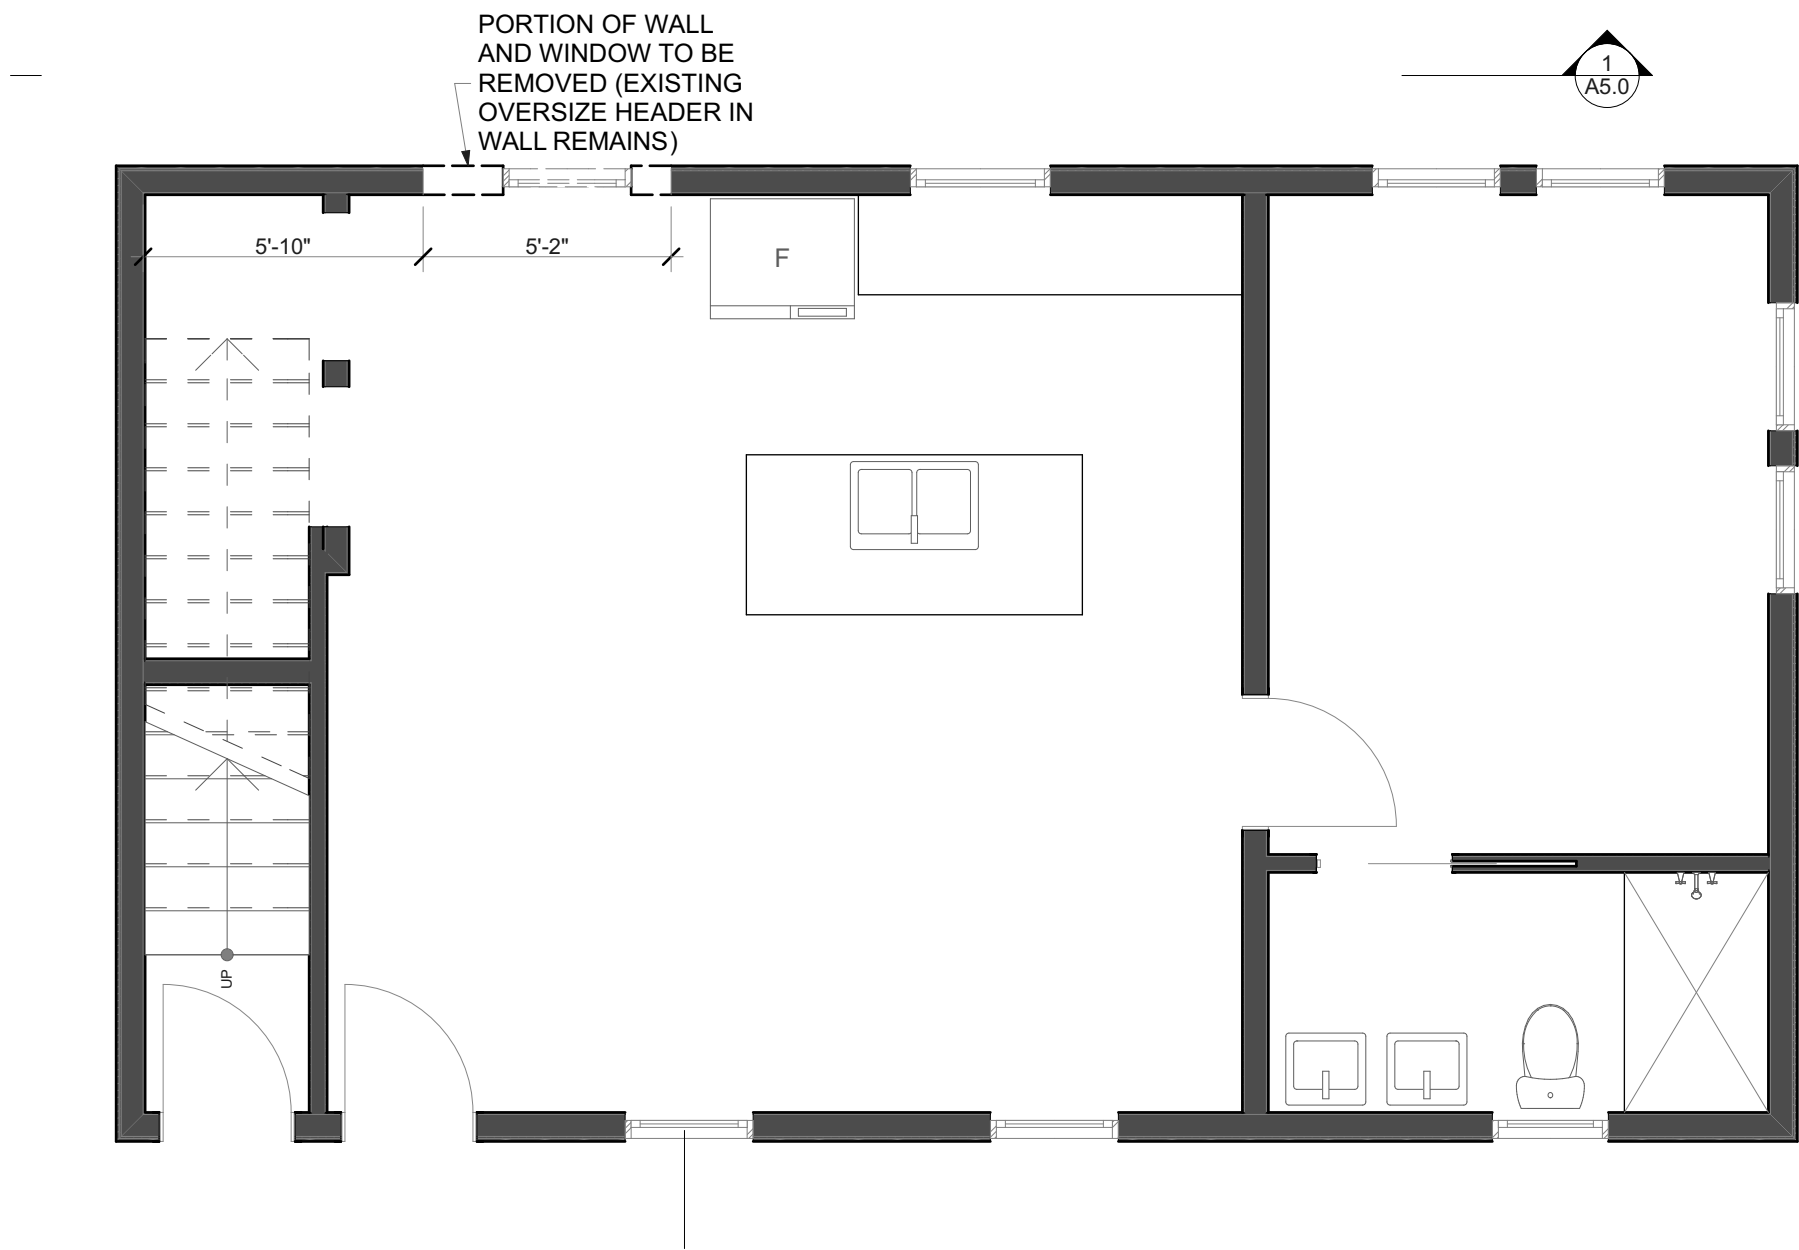

2 Demo Plan - First Floor
SCALE: 1/4" = 1'-0"

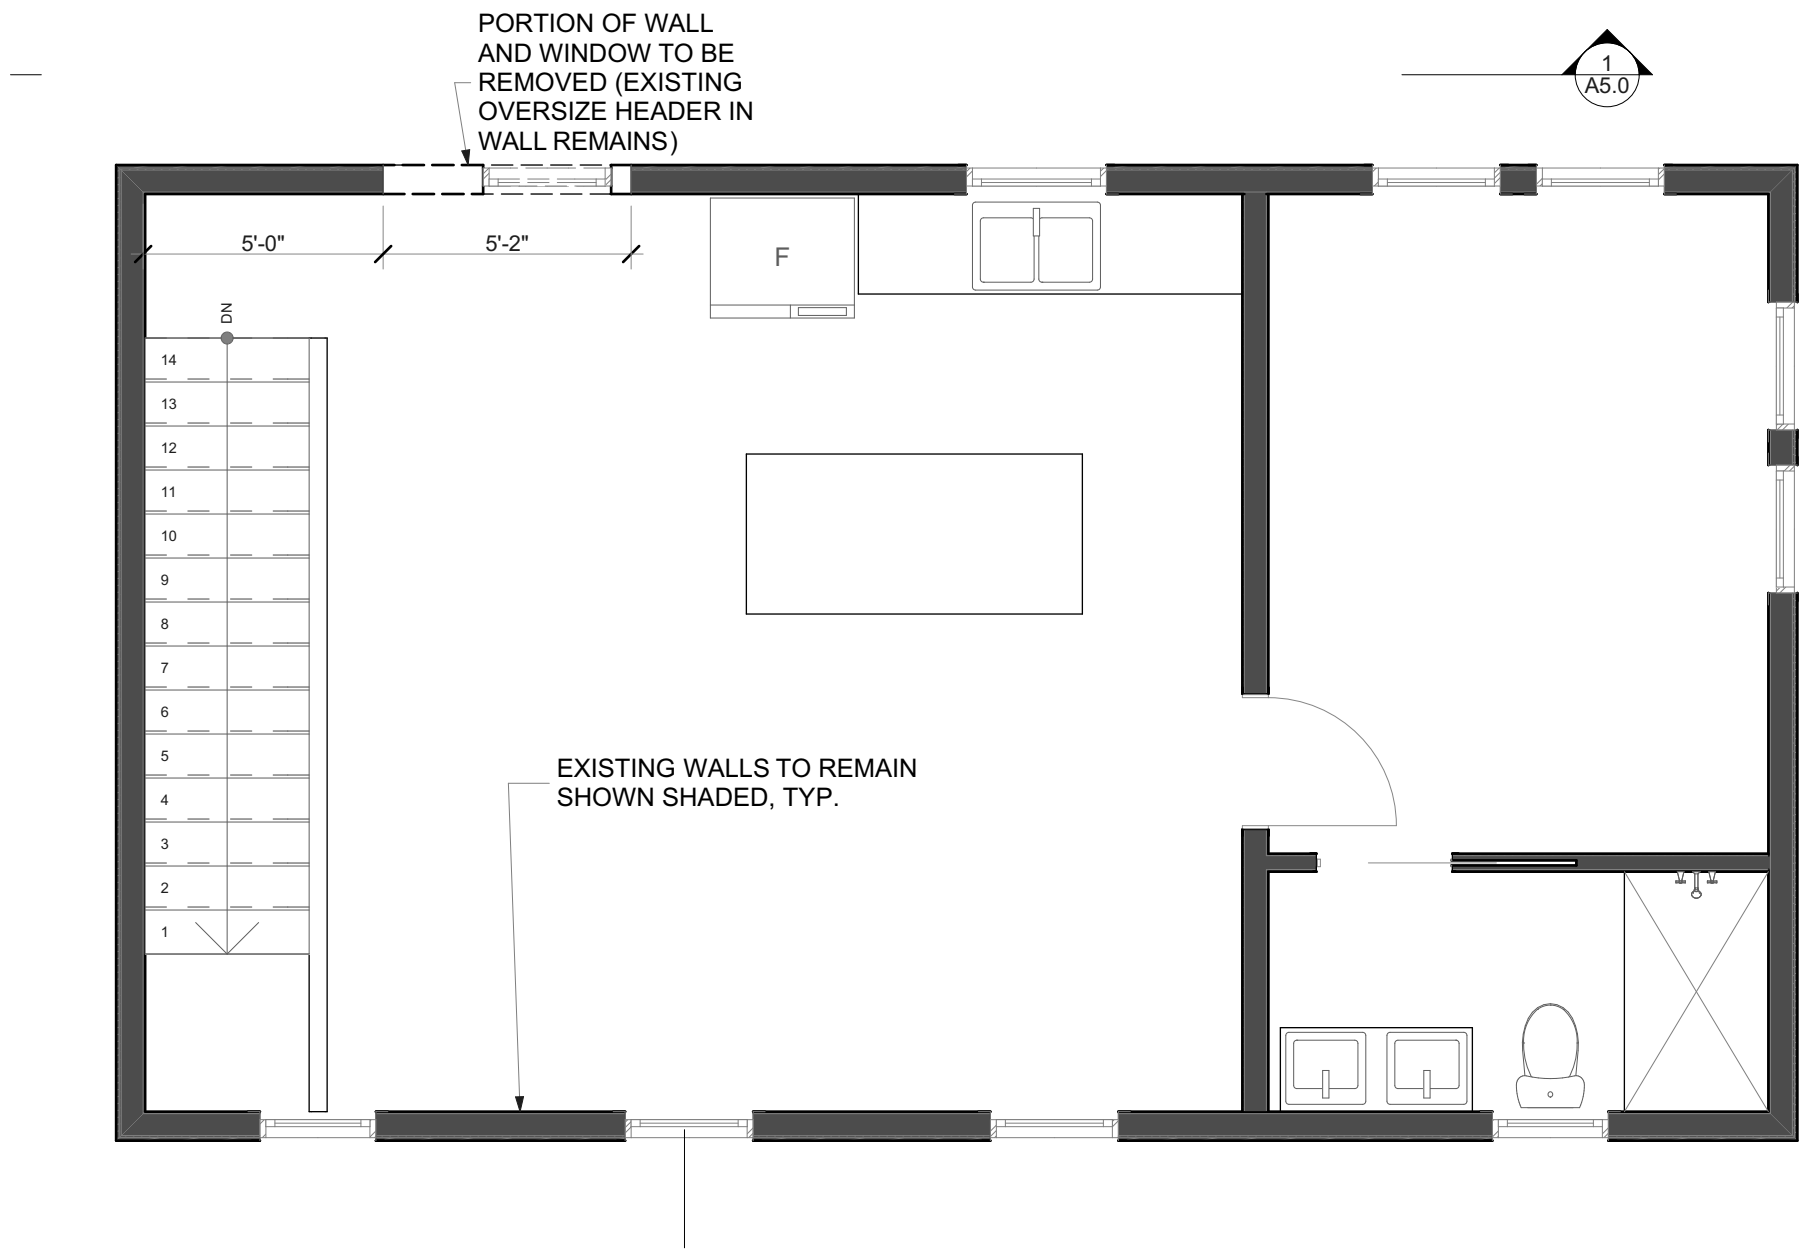

1 Demo Plan - Second Floor
SCALE: 1/4" = 1'-0"



Ertle Duplex
703 Oakland Ave.
Austin, Texas 78703

	4/26/24	CD
	4/16/24	DD
	2/28/24	SD
MARK	DATE	PHASE


PROJECT NO:
MODEL FILE:
DRAWN BY:
CHK'D BY:
COPYRIGHT

SHEET TITLE
Demolition Plans


C:\Users\hick\Documents\Mehl Personal\NANABODE\ERTLE\ERTLE Bldg Model.pln

WINDOW SCHEDULE					
ID	QTY	SIZE		OPERATION	REMARKS
		W	HT		
A	1	7'-0"	1'-6"		
B	1	2'-0"	2'-6"		
B	2	2'-0"	3'-2"		
B	3	3'-1 1/2"	1'-2"		
B	4	2'-11"	4'-0"		
B	6	2'-5"	3'-1"		
B	26	2'-8"	5'-1 1/2"		
C	1	3'-0"	8'-0"		
C	3	3'-0"	7'-0"		
D	2	2'-0"	2'-6"		
E	2	4'-6"	4'-0"		
F	2	2'-0"	2'-6"		
G	2	3'-0"	1'-6"		
H	2	5'-0"	5'-0"		
I	2	7'-0"	1'-6"		
J	4	3'-0"	8'-0"		

DOOR SCHEDULE			
ID	DOOR		REMARKS
	W	HT	
101	2'-8"	6'-8"	
101	9'-0"	7'-0"	
102	2'-8"	6'-8"	
102	9'-0"	7'-0"	
103	2'-8"	6'-8"	
103	3'-0"	6'-8"	
104	2'-8"	6'-8"	
105	3'-0"	5'-10 1/2"	
106	2'-11"	6'-7"	
201	6'-0"	8'-0"	
202	5'-0"	6'-8"	
203	3'-0"	6'-8"	
204	2'-4"	6'-8"	
205	3'-0"	6'-8"	
206	2'-4"	6'-8"	
207	3'-0"	6'-8"	
301	6'-0"	8'-0"	
302	5'-0"	6'-8"	
303	4'-0"	6'-8"	
304	2'-8"	6'-8"	
305	2'-8"	6'-8"	
306	3'-0"	6'-8"	
307	2'-4"	6'-8"	
308	4'-8"	6'-8"	
309	3'-0"	6'-8"	

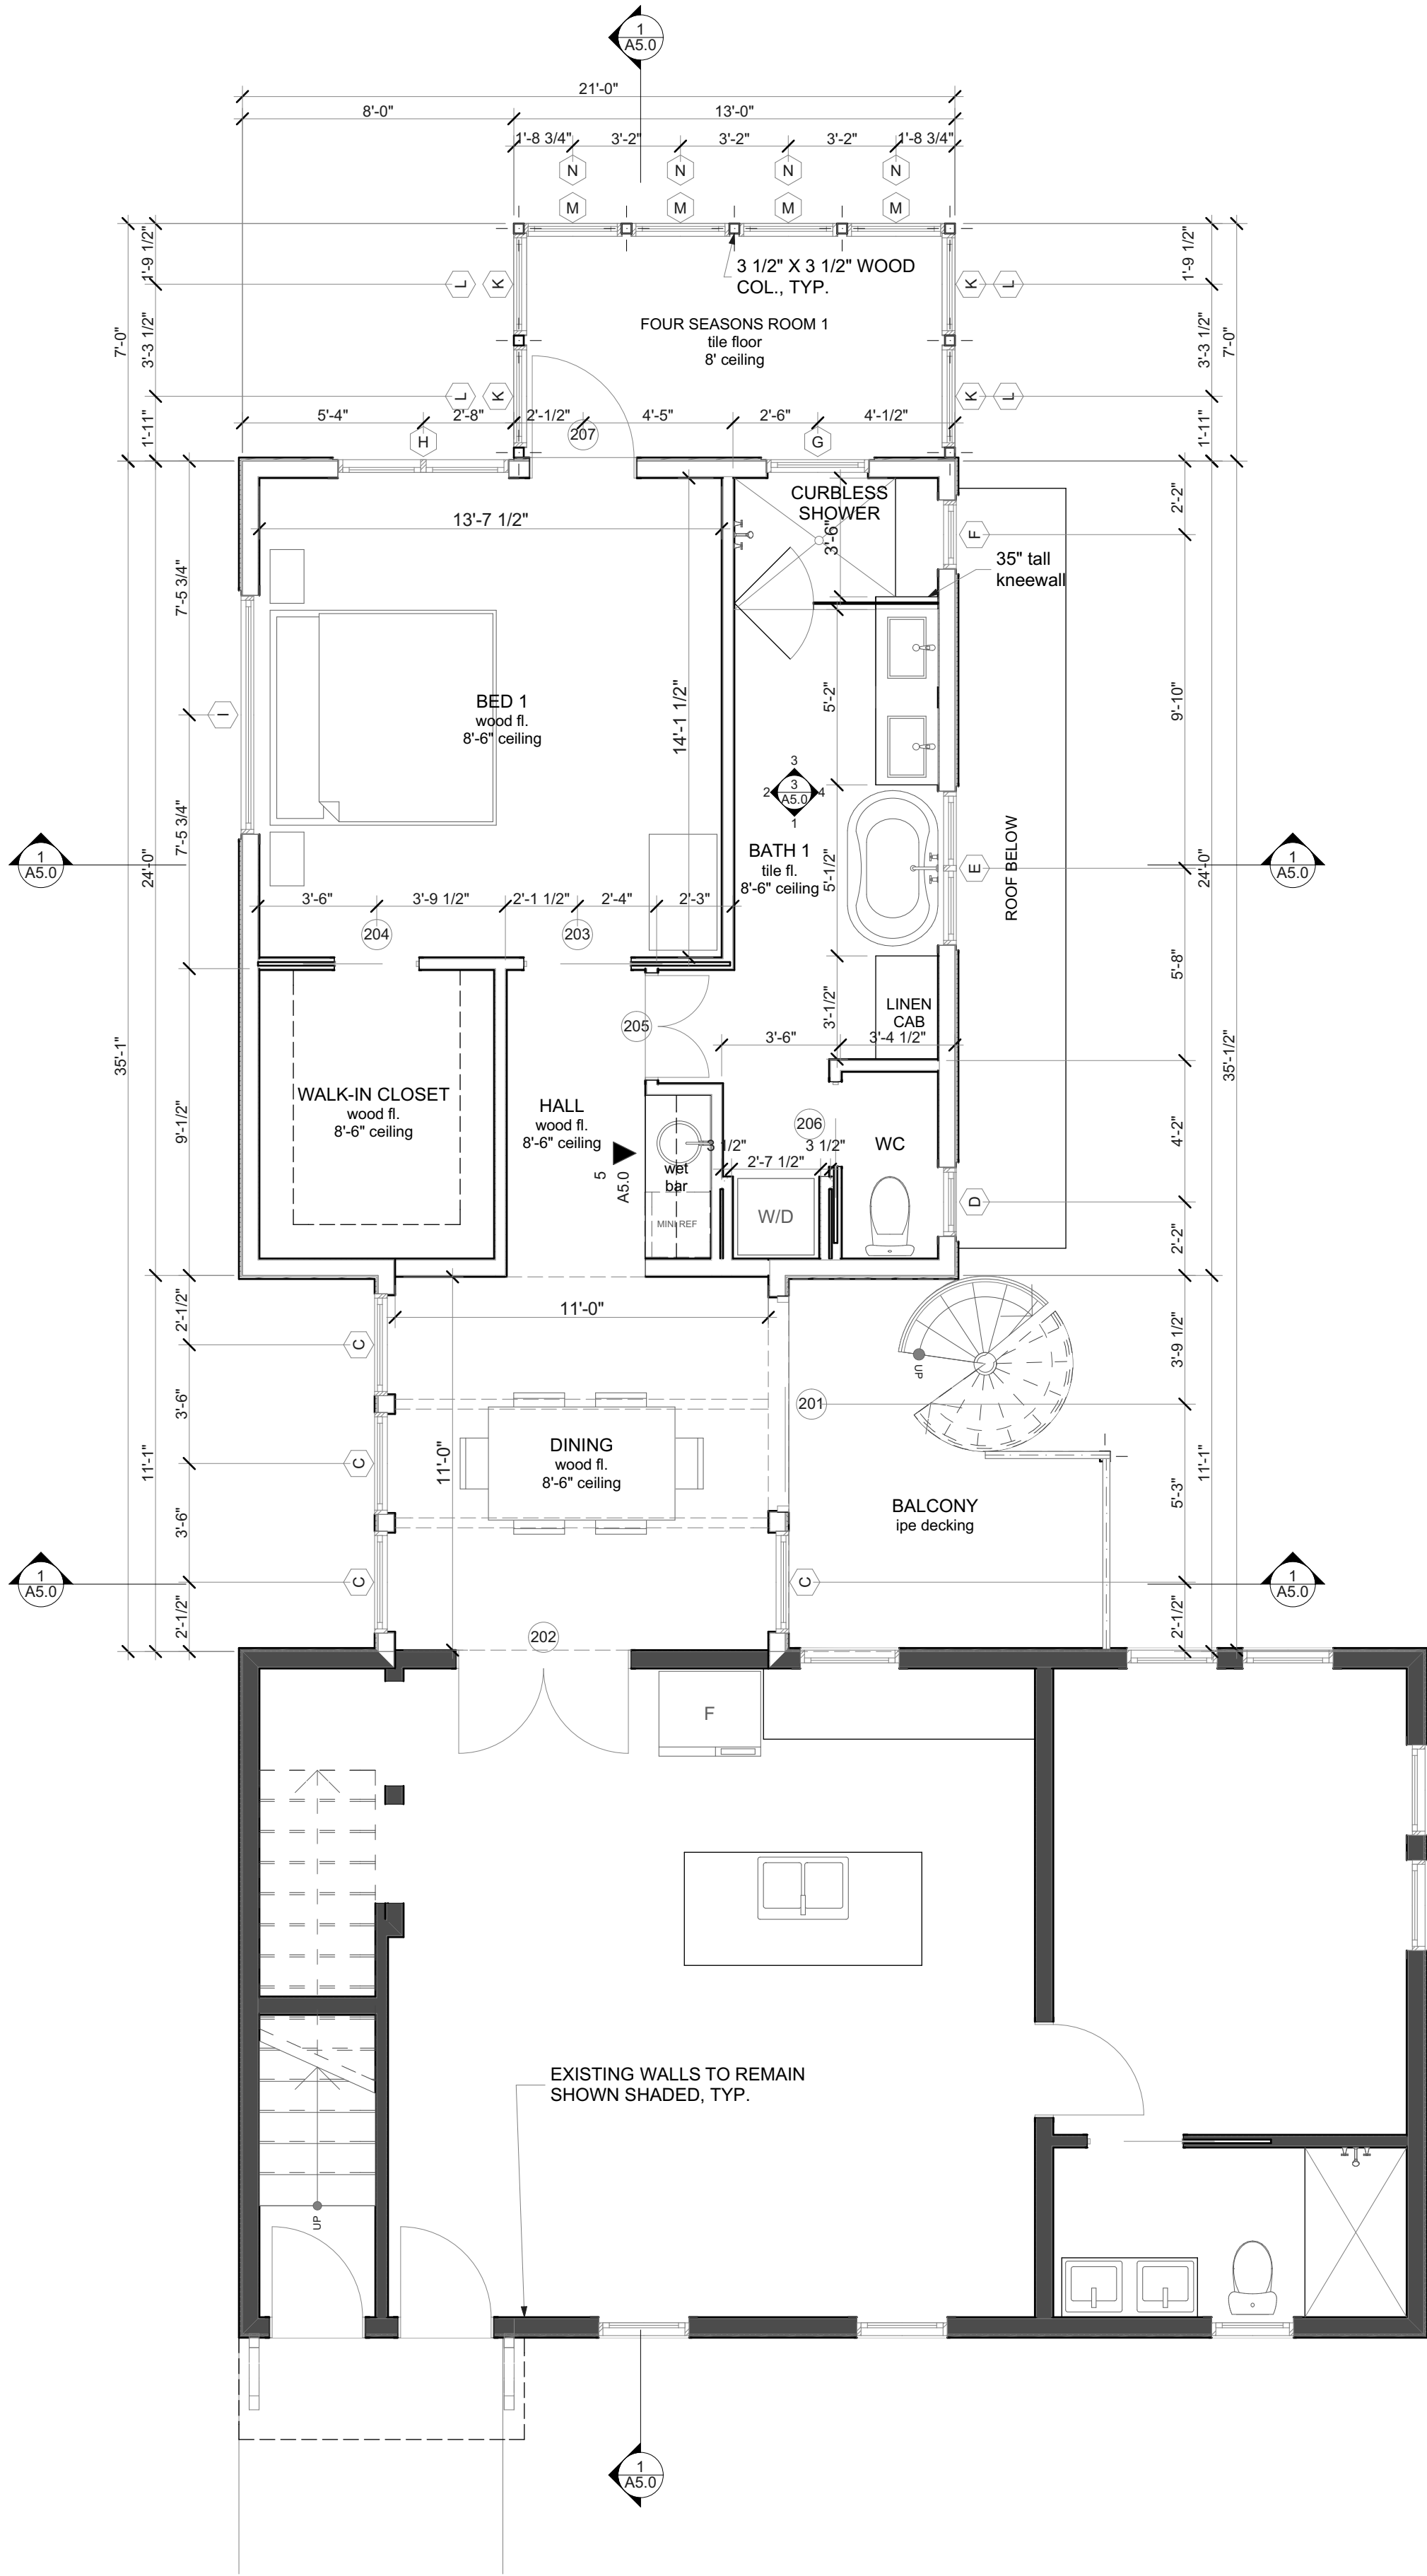

1 First Floor
SCALE: 1/4" = 1'-0"

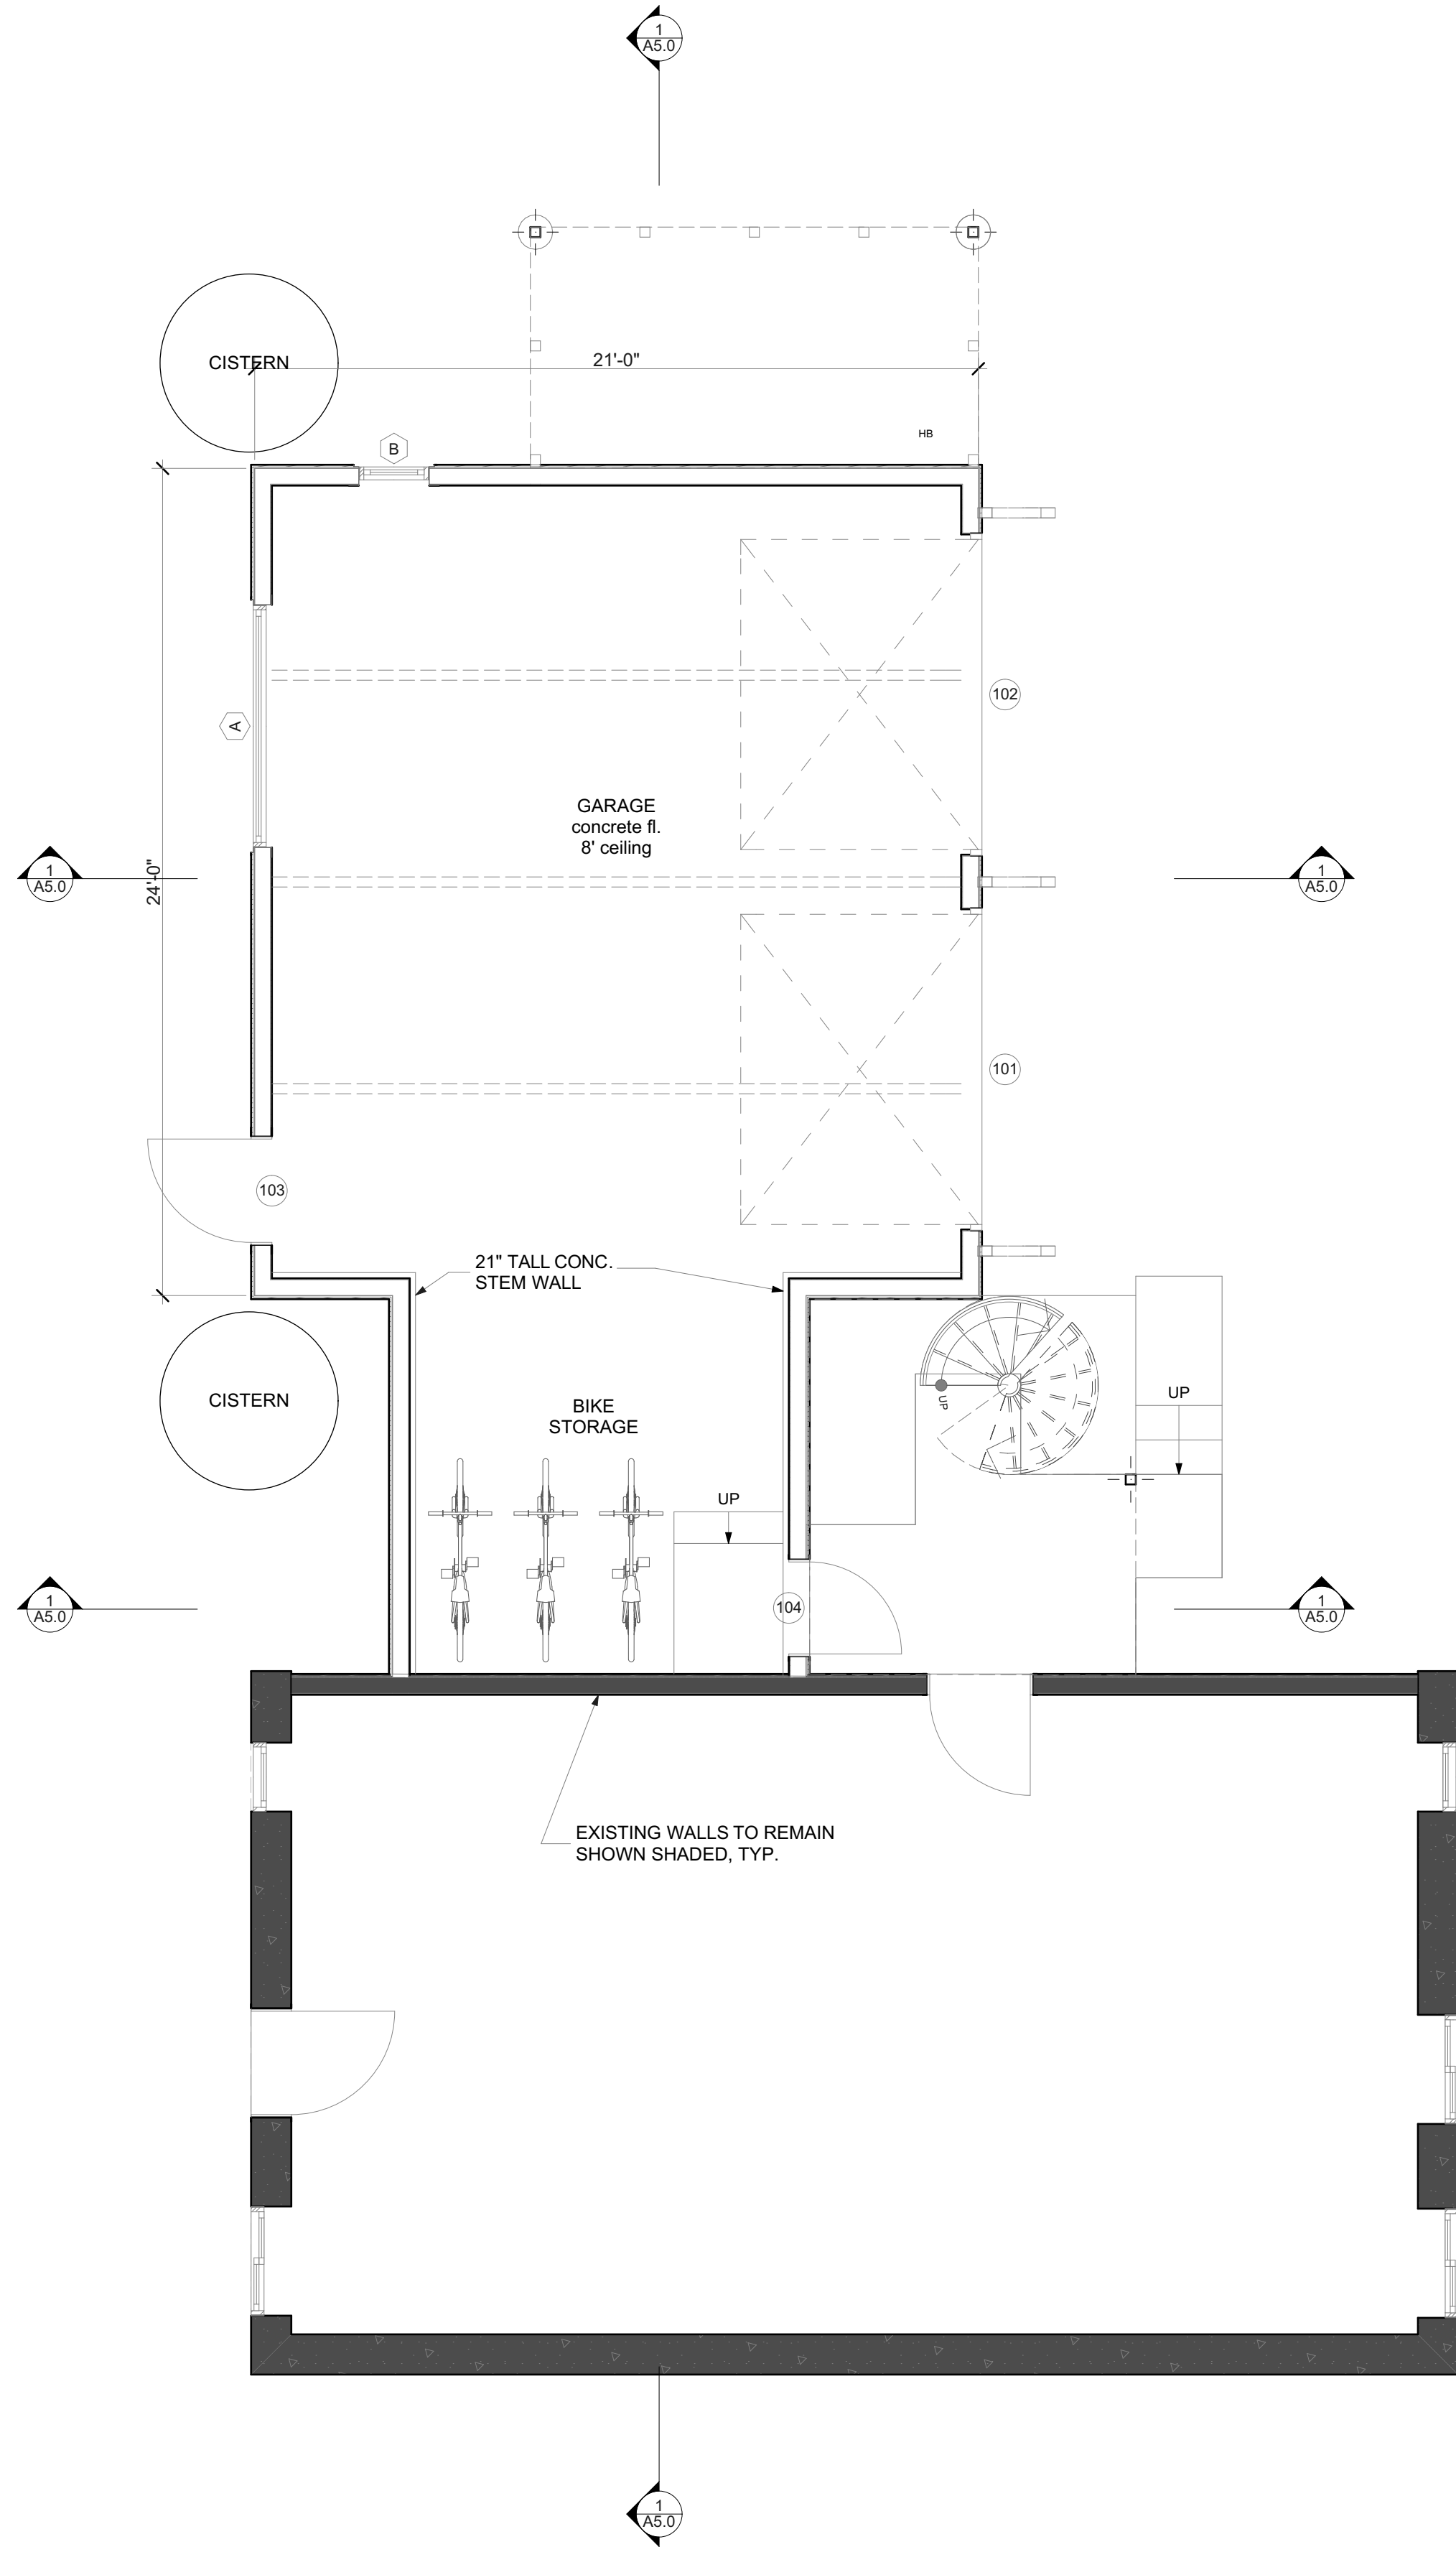

2 Garage/Basement Floor
SCALE: 1/4" = 1'-0"



Erle Duplex
703 Oakland Ave.
Austin, Texas 78703

MARK	DATE	PHASE
	4/26/24	CD
	4/16/24	DD
	2/28/24	SD

PROJECT NO:
MODEL FILE:
DRAWN BY:
CHK'D BY:
COPYRIGHT


SHEET TITLE
Basement & First
Floor Plan

A2.0
SHEET 6 OF


C:\Users\hick\Documents\Mehl Personal\NANABODE\ERTLE\Bldg Model.pln

WINDOW SCHEDULE					
ID	QTY	SIZE		OPPERATION	REMARKS
		W	HT		
A	1	7'-0"	1'-6"		
B	1	2'-0"	2'-6"		
B	2	2'-0"	3'-2"		
B	3	3'-1 1/2"	1'-2"		
B	4	2'-11"	4'-0"		
B	6	2'-5"	3'-1"		
B	26	2'-8"	5'-1 1/2"		
C	1	3'-0"	8'-0"		
C	3	3'-0"	7'-0"		
D	2	2'-0"	2'-6"		
E	2	4'-6"	4'-0"		
F	2	2'-0"	2'-6"		
G	2	3'-0"	1'-6"		
H	2	5'-0"	5'-0"		
I	2	7'-0"	1'-6"		
J	4	3'-0"	8'-0"		

DOOR SCHEDULE			
ID	DOOR		REMARKS
	W	HT	
101	2'-8"	6'-8"	
101	9'-0"	7'-0"	
102	2'-8"	6'-8"	
102	9'-0"	7'-0"	
103	2'-8"	6'-8"	
103	3'-0"	6'-8"	
104	2'-8"	6'-8"	
105	3'-0"	5'-10 1/2"	
106	2'-11"	6'-7"	
201	6'-0"	8'-0"	
202	5'-0"	6'-8"	
203	3'-0"	6'-8"	
204	2'-4"	6'-8"	
205	3'-0"	6'-8"	
206	2'-4"	6'-8"	
207	3'-0"	6'-8"	
301	6'-0"	8'-0"	
302	5'-0"	6'-8"	
303	4'-0"	6'-8"	
304	2'-8"	6'-8"	
305	2'-8"	6'-8"	
306	3'-0"	6'-8"	
307	2'-4"	6'-8"	
308	4'-8"	6'-8"	
309	3'-0"	6'-8"	

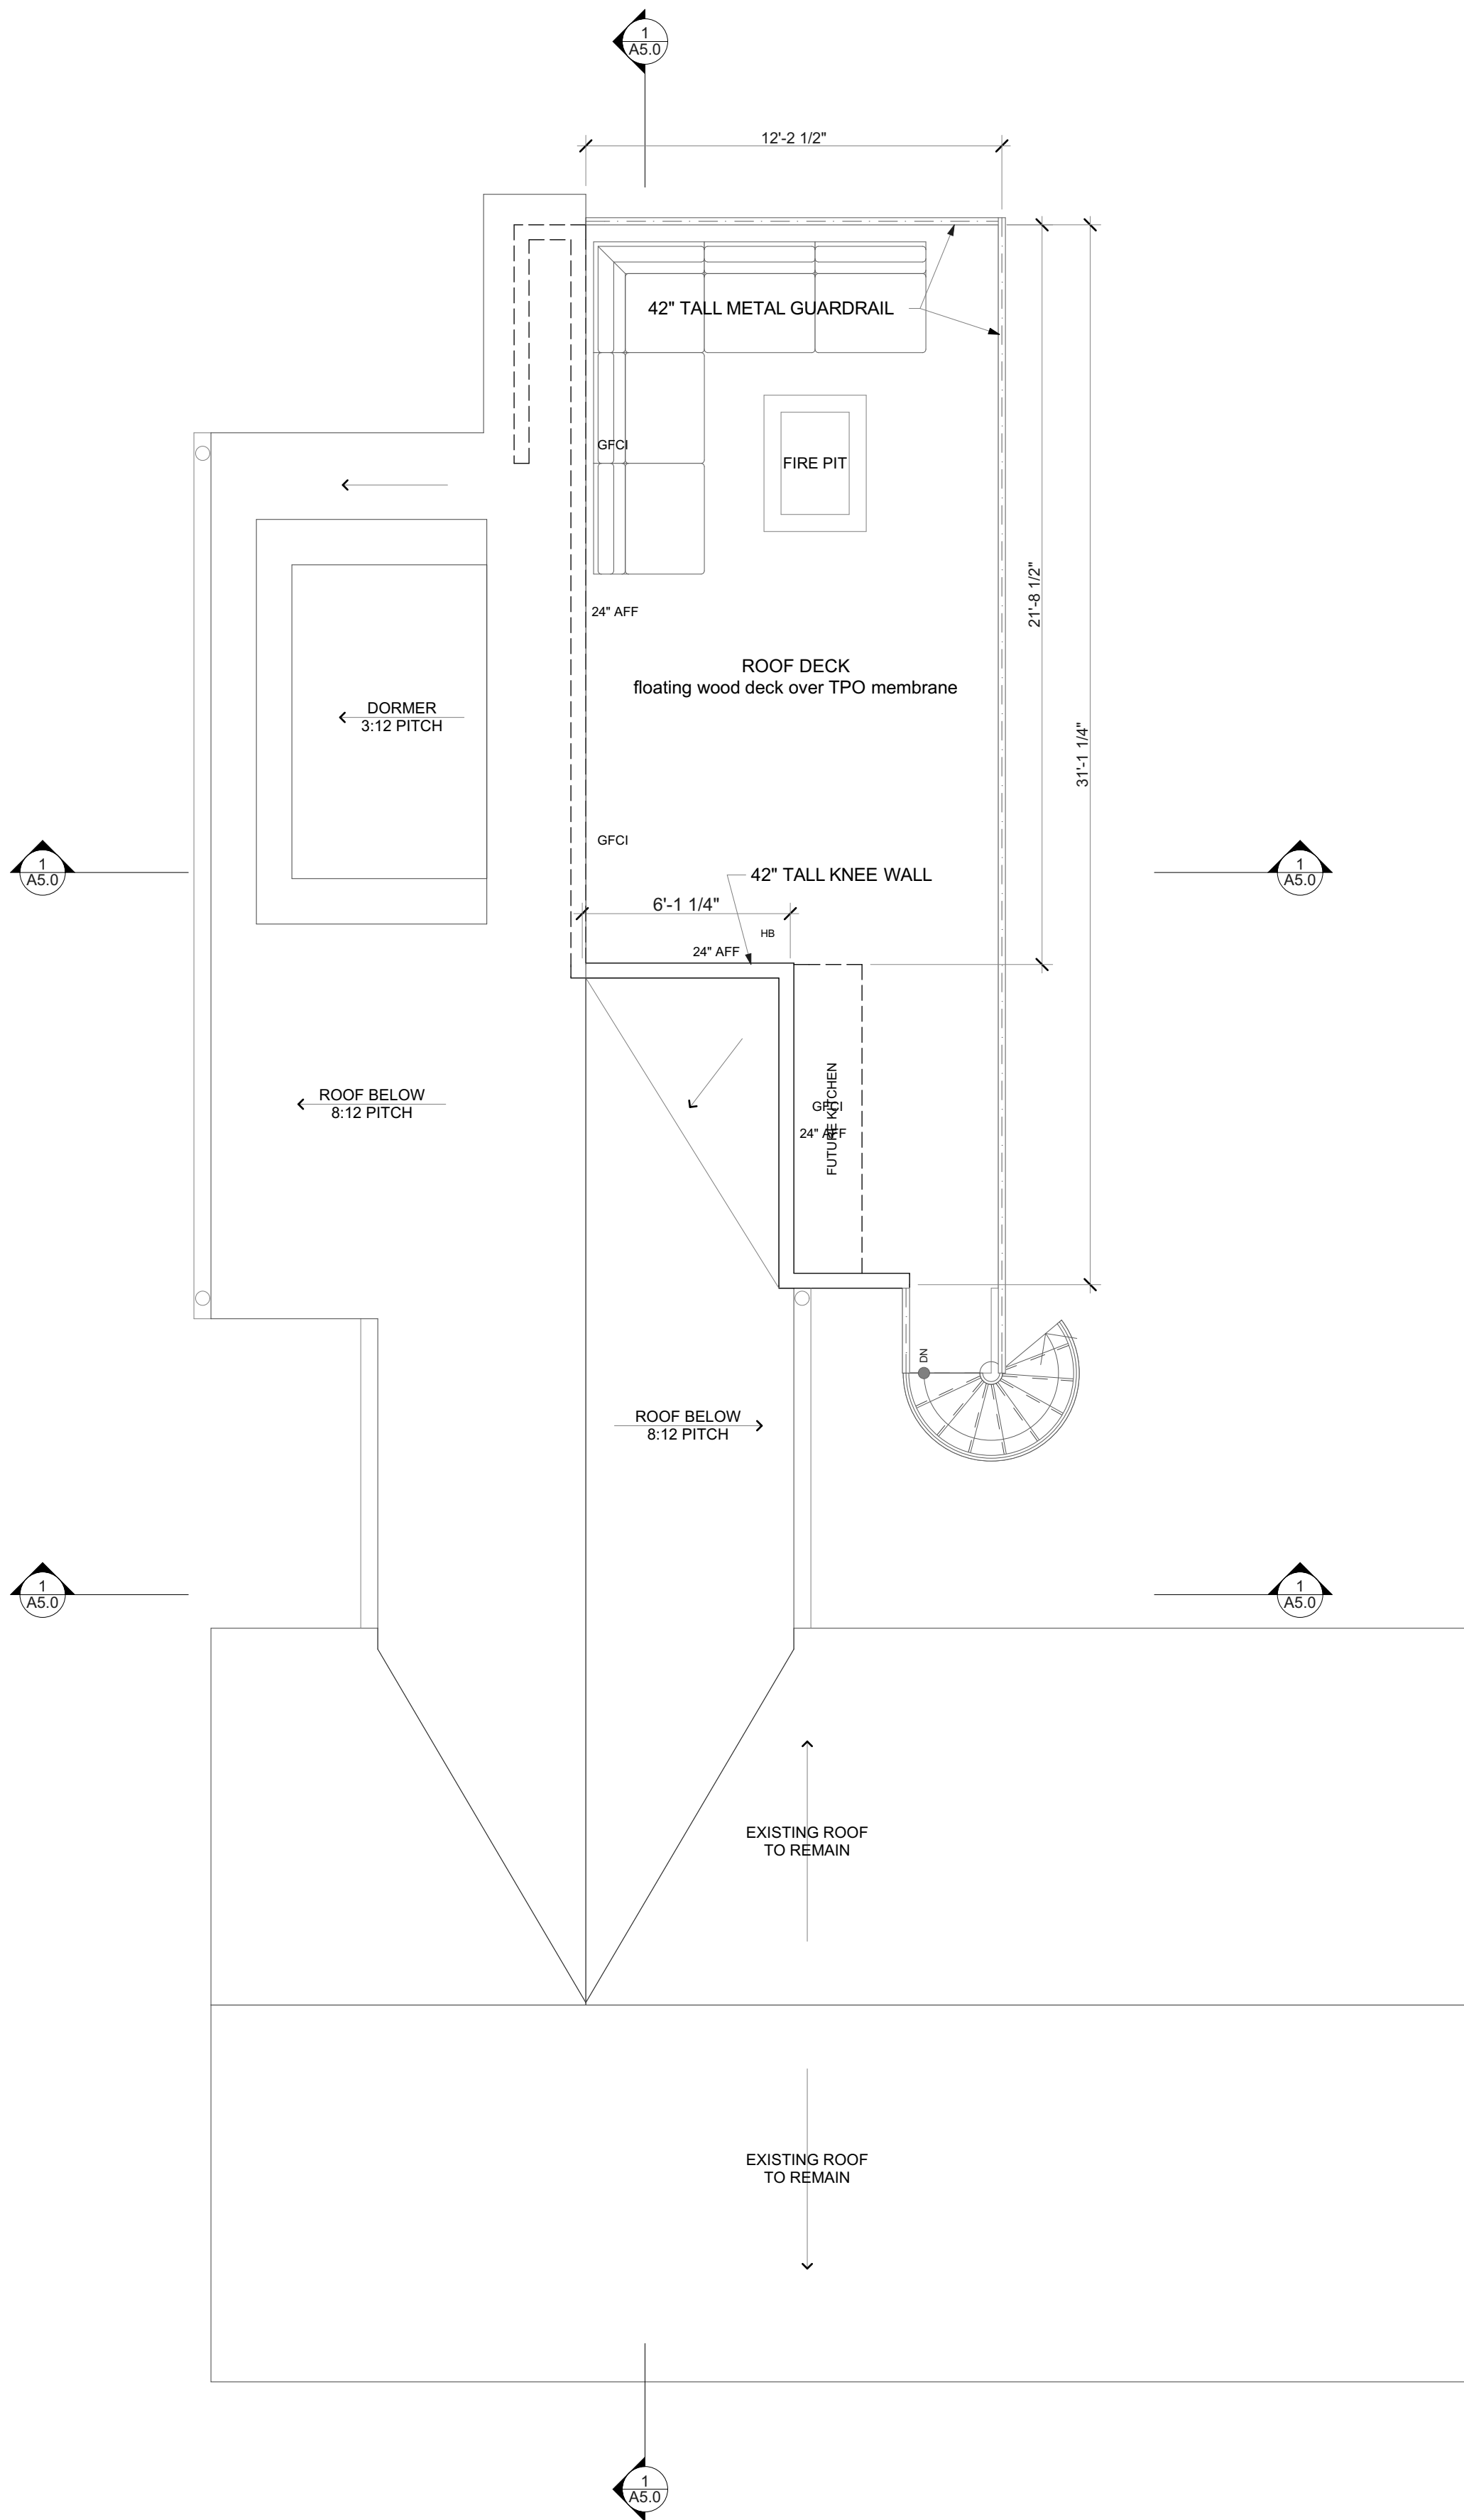

1 Roof Deck
SCALE: 1/4" = 1'-0"

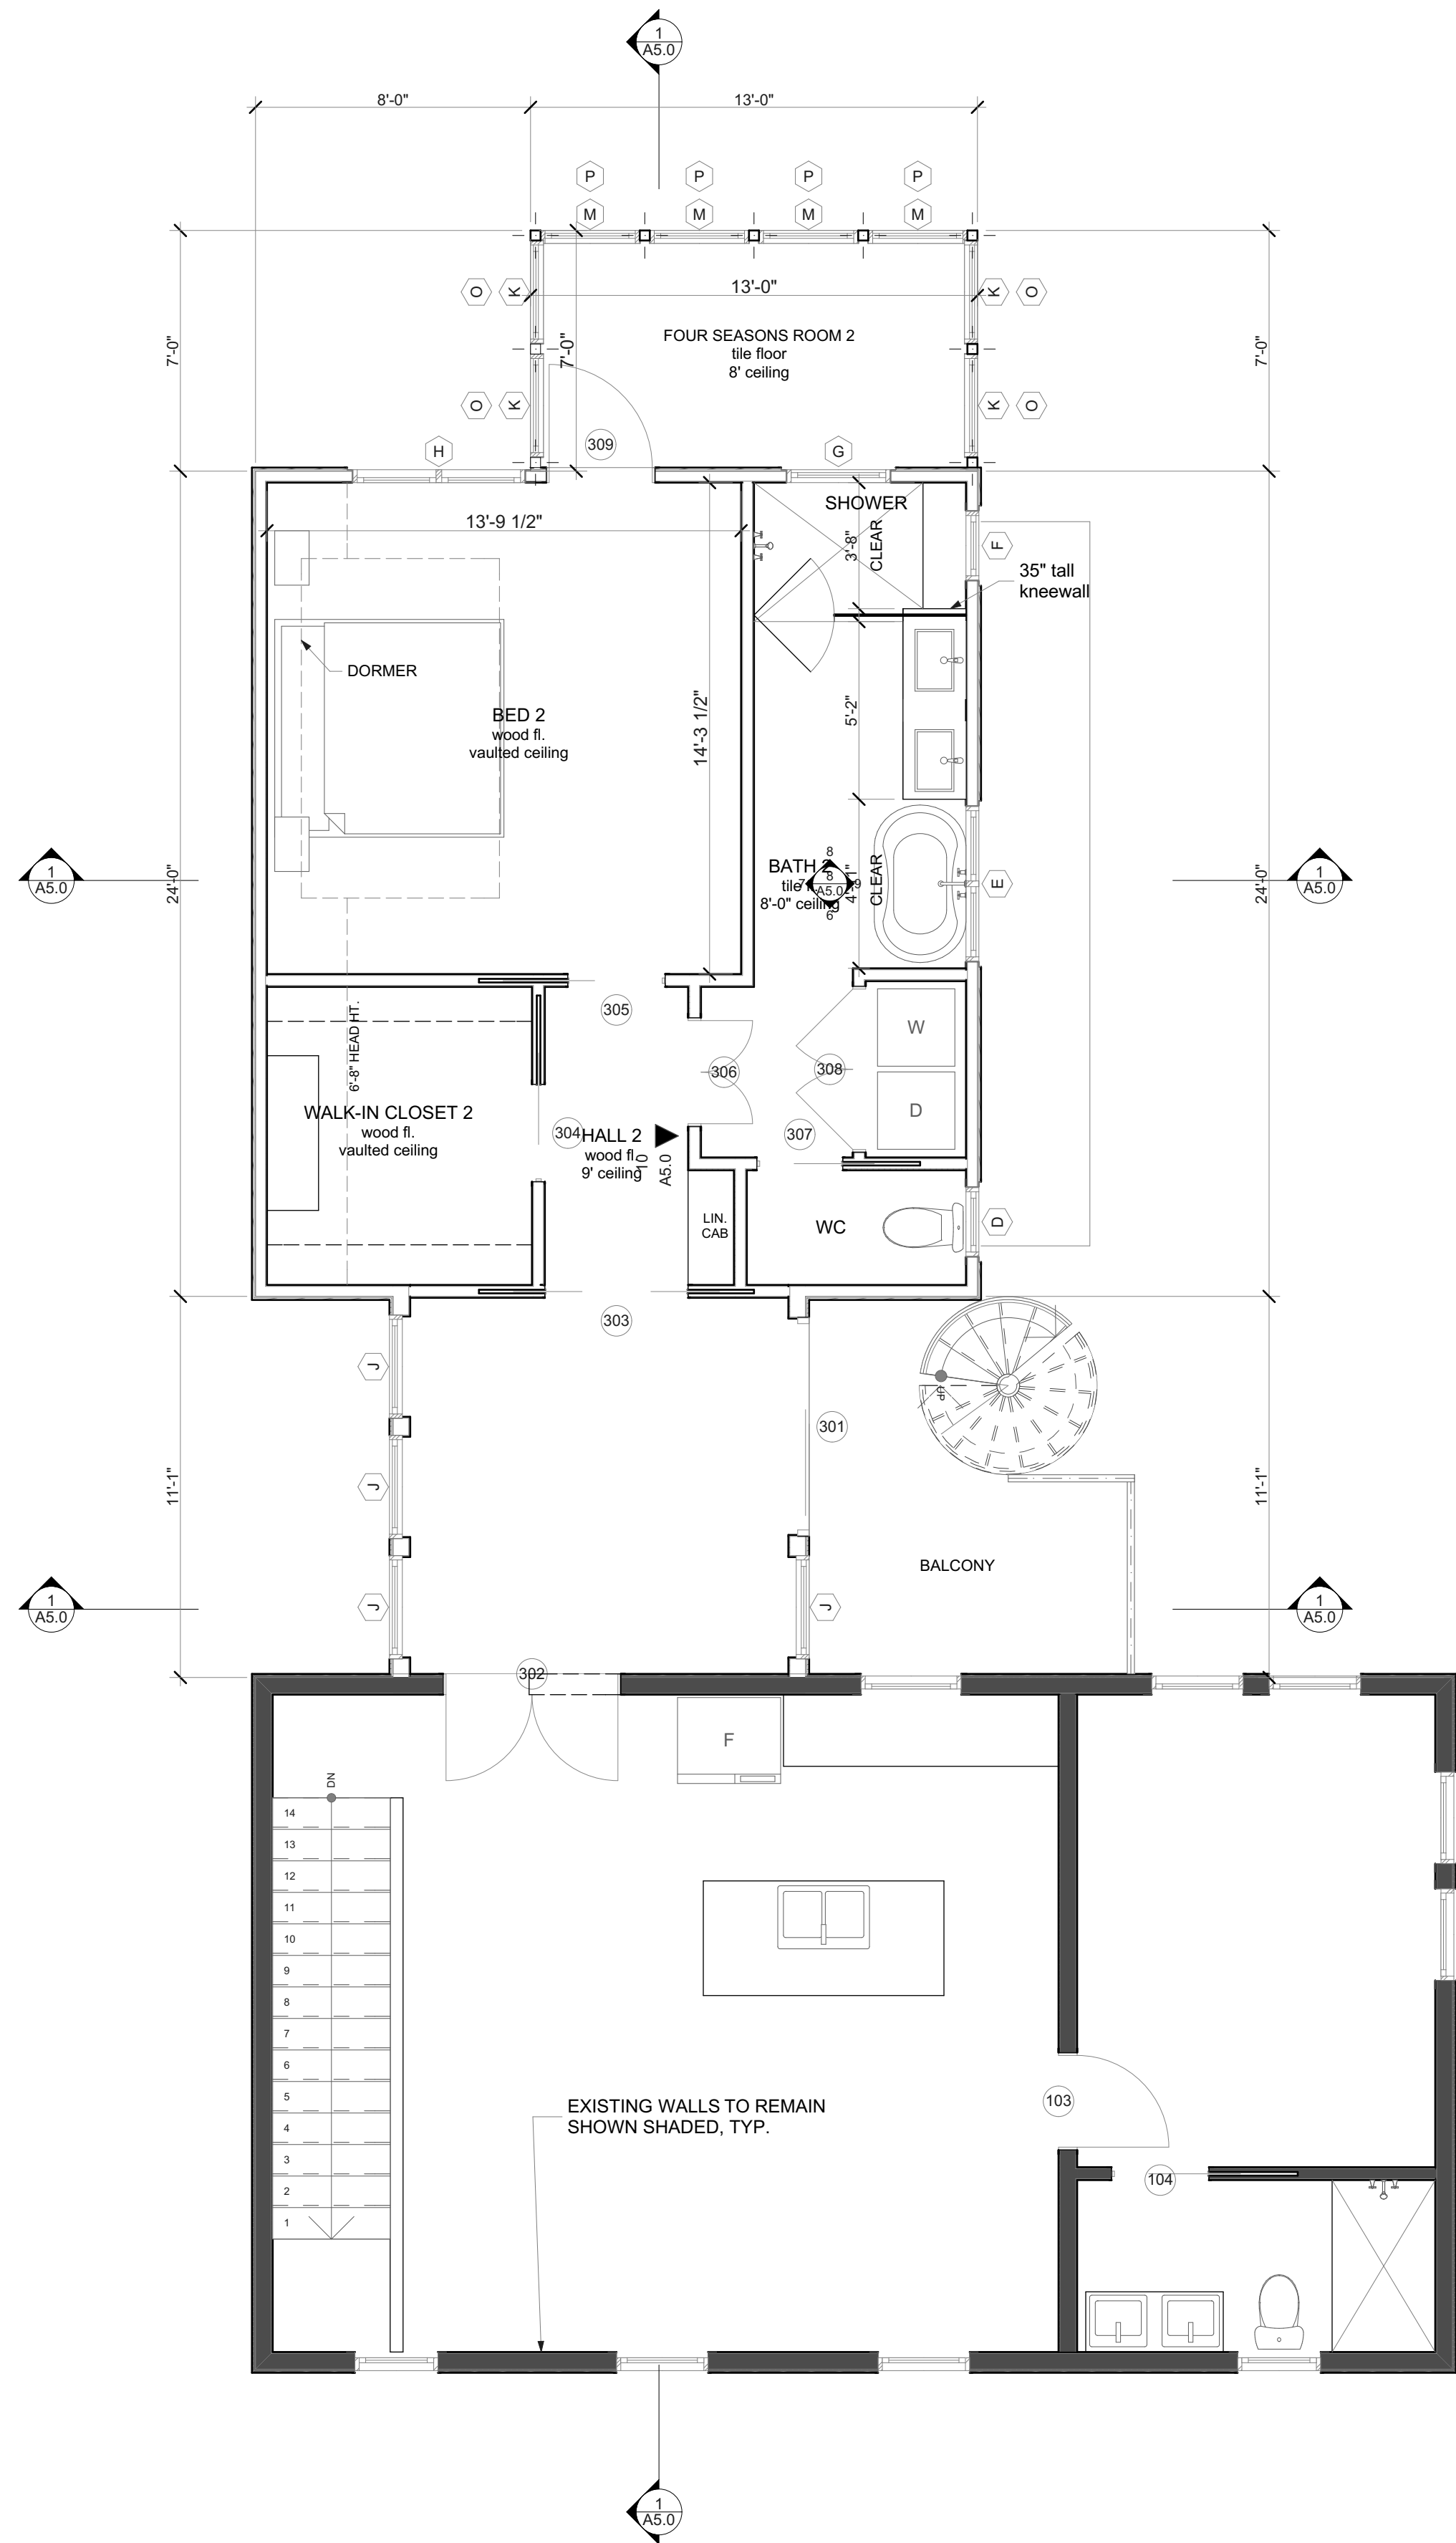

2 Second Floor
SCALE: 1/4" = 1'-0"



Erle Duplex
703 Oakland Ave.
Austin, Texas 78703

MARK	DATE	PHASE
	4/26/24	CD
	4/16/24	DD
	2/28/24	SD

PROJECT NO:
MODEL FILE:
DRAWN BY:
CHK'D BY:
COPYRIGHT

SHEET TITLE
Second Floor and
Roof Plan

A2.1

SHEET 7 OF

C:\Users\nick\Documents\Mehl Personal\NANABODE\ERTLE\ERTLE Bldg Model.pln



1 West Elevation
SCALE: 1/4" = 1'-0"



2 South Elevation
SCALE: 1/4" = 1'-0"



Ertle Duplex
703 Oakland Ave.
Austin, Texas 78703

MARK	DATE	PHASE
	4/26/24	CD
	4/16/24	DD
	2/28/24	SD

PROJECT NO:
MODEL FILE:
DRAWN BY:
CHK'D BY:
COPYRIGHT

SHEET TITLE
Exterior Elevations

A3.0
SHEET 8 OF

C:\Users\hick\Documents\Mehl Personal\NANABODE\ERTLE\ERTLE Bldg Model.pln

	4/26/24	CD
	4/16/24	DD
	2/28/24	SD
MARK	DATE	PHASE

PROJECT NO:
MODEL FILE:
DRAWN BY:
CHK'D BY:
COPYRIGHT

SHEET TITLE
Exterior Elevations




1 East Elevation
SCALE: 1/4" = 1'-0"




2 North Elevation
SCALE: 1/4" = 1'-0"

C:\Users\hick\Documents\Mehl Personal\NANABODE\ERTLE\ERTLE Bldg Model.pln

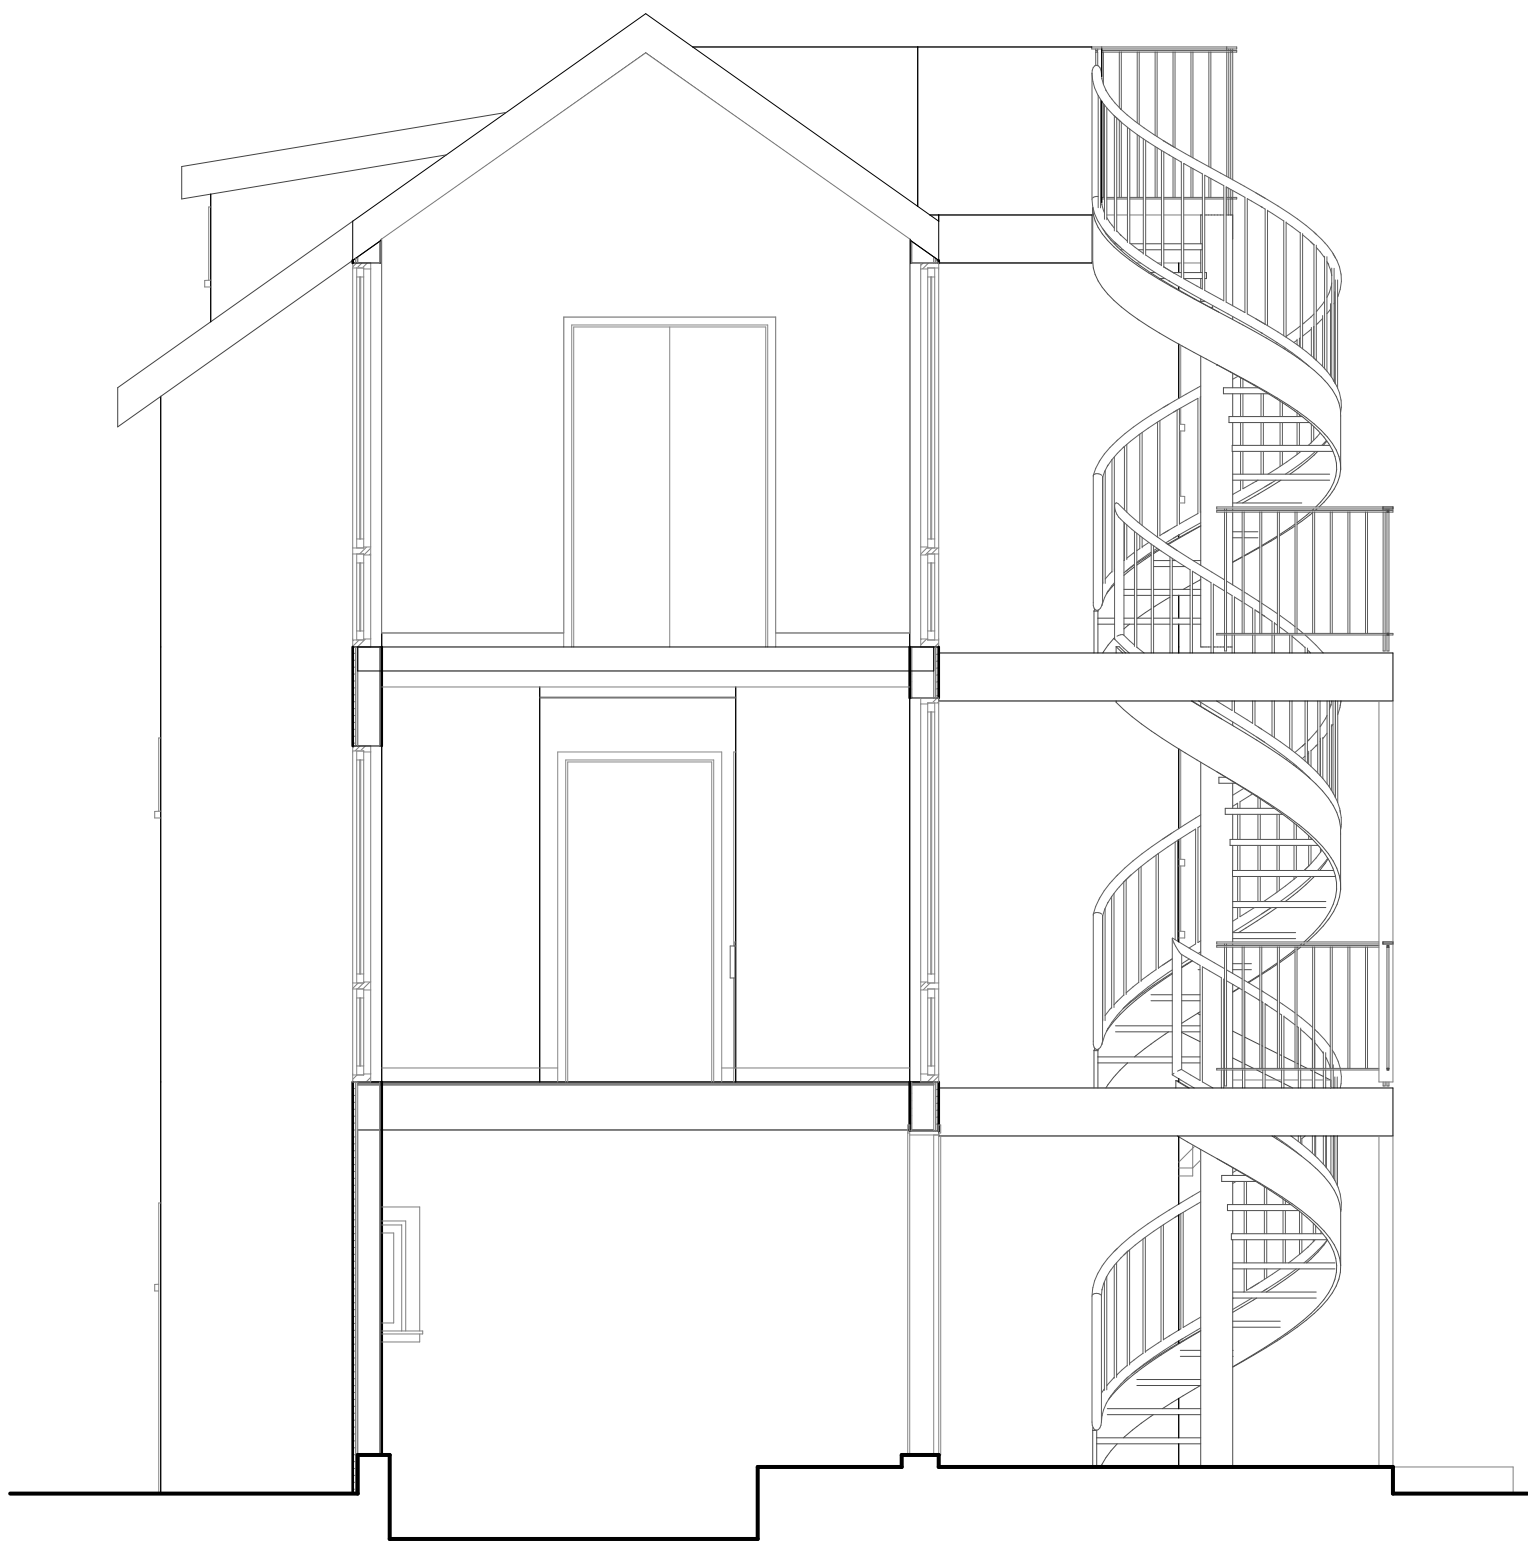

1 Latitudinal Section A
SCALE: 1/4" = 1'-0"

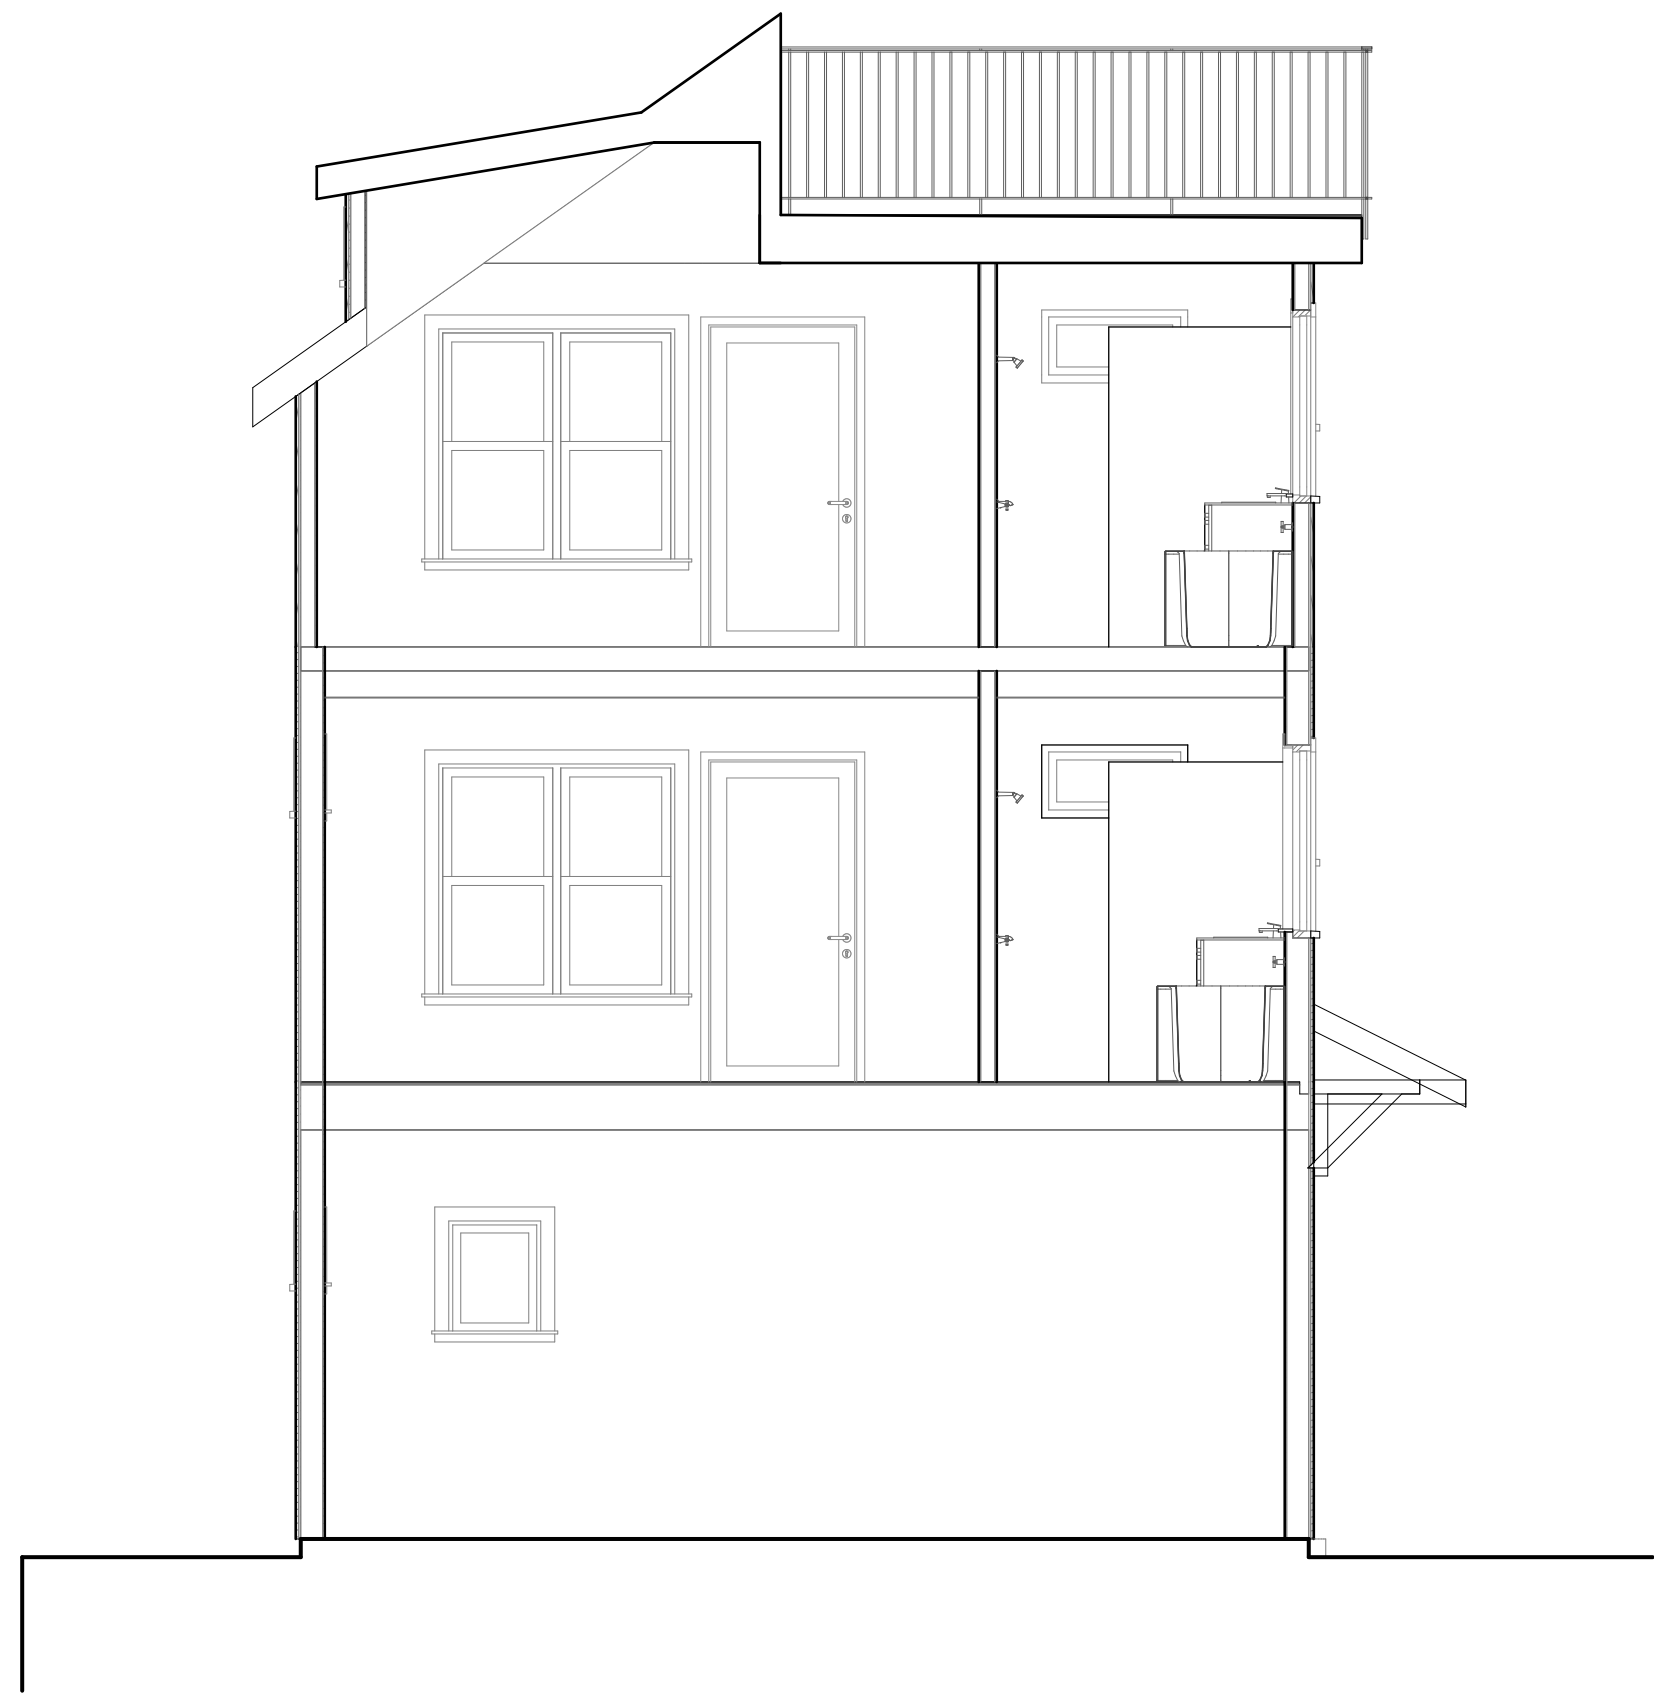

2 Latitudinal Section B
SCALE: 1/4" = 1'-0"



3 Longitudinal Section A
SCALE: 1/4" = 1'-0"



Ertle Duplex
703 Oakland Ave.
Austin, Texas 78703


	4/26/24	CD
	4/16/24	DD
	2/28/24	SD
MARK	DATE	PHASE

PROJECT NO:
MODEL FILE:
DRAWN BY:
CHK'D BY:
COPYRIGHT


SHEET TITLE
Sections

A4.0
SHEET 10 OF


C:\Users\hick\Documents\Mehl Personal\NANABODE\ERTLE\ERTLE Bldg Model.pln

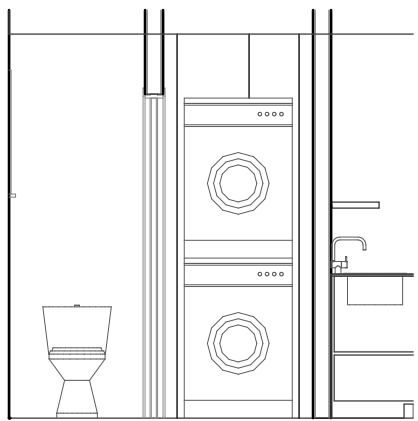


Bath 1 W
SCALE: 1/4" = 1'-0"

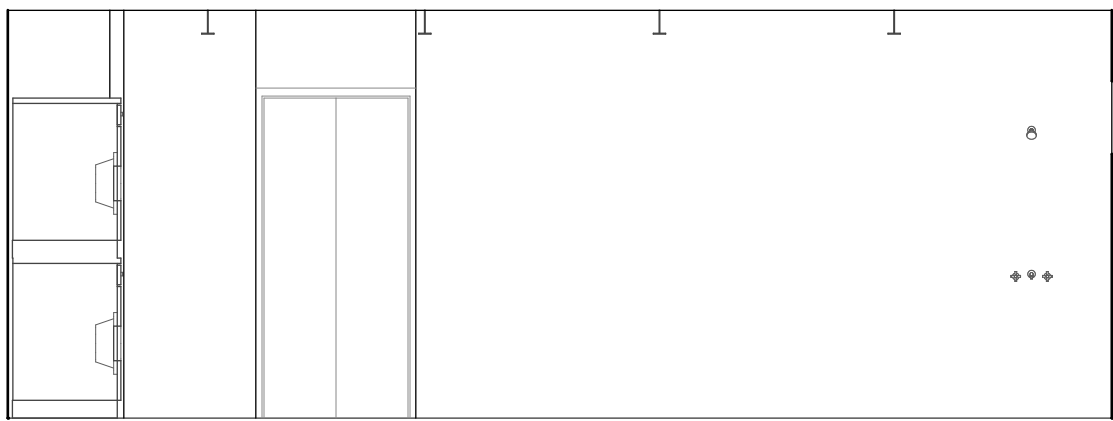


Bath 1 N
SCALE: 1/4" = 1'-0"

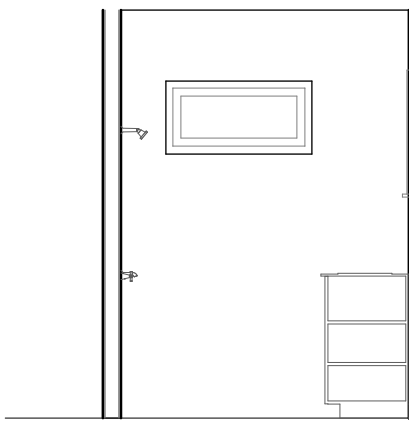


Bath 1 E
SCALE: 1/4" = 1'-0"

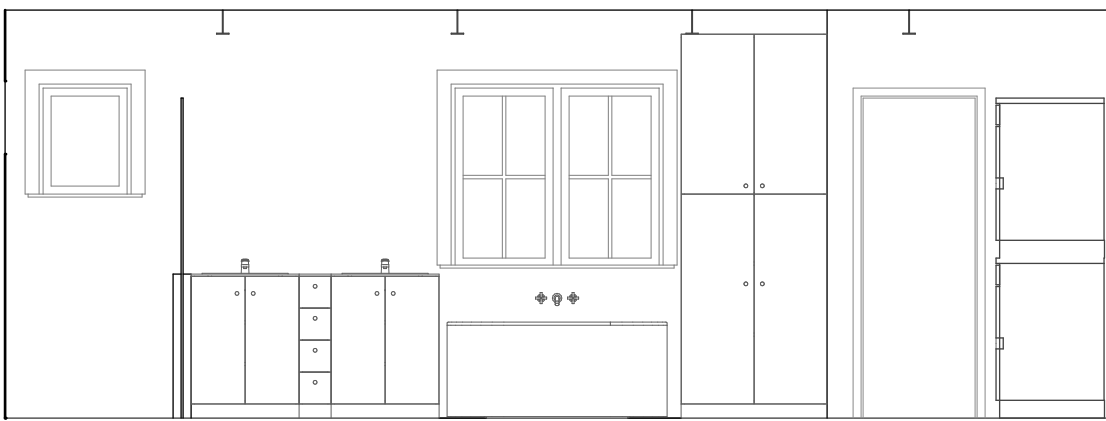


Bath 1 S
SCALE: 1/4" = 1'-0"

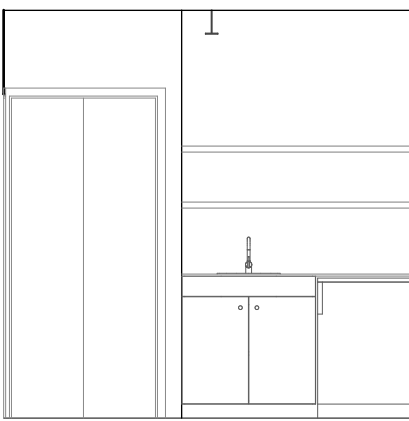

Hall 1 S
SCALE: 1/4" = 1'-0"

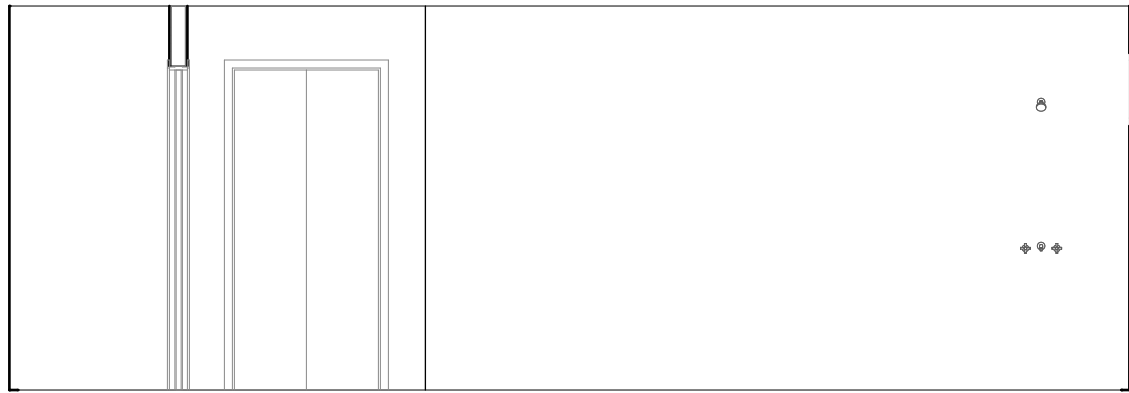


Bath 2 N
SCALE: 1/4" = 1'-0"

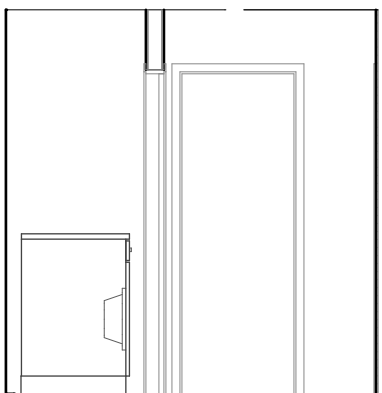


Bath 2 W
SCALE: 1/4" = 1'-0"



Bath 2 S
SCALE: 1/4" = 1'-0"

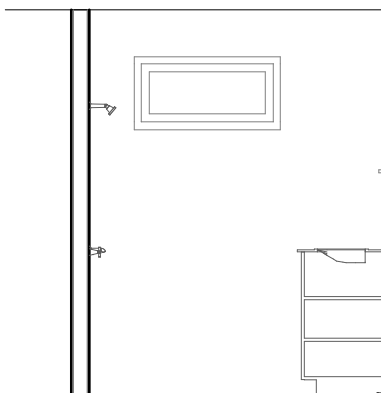

Bath 2 E
SCALE: 1/4" = 1'-0"

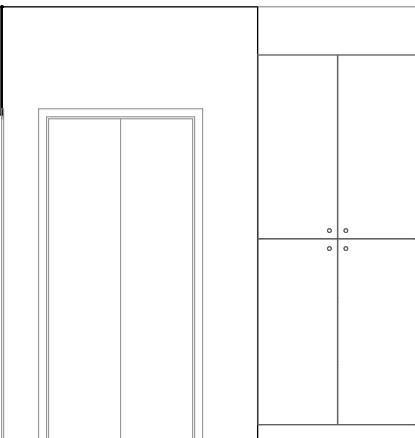

Hall 2 S
SCALE: 1/4" = 1'-0"



nANABODE

Ertle Duplex

703 Oakland Ave.





Austin, Texas 78703









	4/26/24	CD
	4/16/24	DD
	2/28/24	SD
MARK	DATE	PHASE


PROJECT NO:
MODEL FILE:
DRAWN BY:
CHK'D BY:
COPYRIGHT

SHEET TITLE
Interior Elevations

    
C:\Users\nick\Documents\Mehl Personal\NANABODE\ERTLE\ERTLE Bldg Model.pln

Lighting Legend		
Symbol	Description	Note/Remarks
	Wall sconce	see interior elev. for mounting height
	Pendant or Ceiling Mounted	
	Keyless Incandescent	
	Recessed 6" dia. Incandescent	
	Waterproof Recessed Incandescent	
	Directional Recessed Incandescent	
	Track Lighting	
	Undercabinet Task Light	
	Motion Sensitive Flood	
	Single Pole Light Switch	
	Single Pole Light Switch with Dimmer Circuit	
	Ceiling Fan	
	Ceiling Fan w/ light kit	

        Electrical Legend		
Symbol	Description	Note/Remarks
	Duplex Outlet	Mount at 12" AFF
	Duplex Outlet, Mounting Height as Noted	
	Floor Outlet	
	220V Outlet	
	Door Bell	
	Speaker	
	Smoke Detector	
	Thermostat	
	Telephone	
	Exhaust Fan / Light combo	
	Exhaust Fan	
	TV Antenna / Cable / Dish	
	Gas Supply Line	
	Hose Bib	

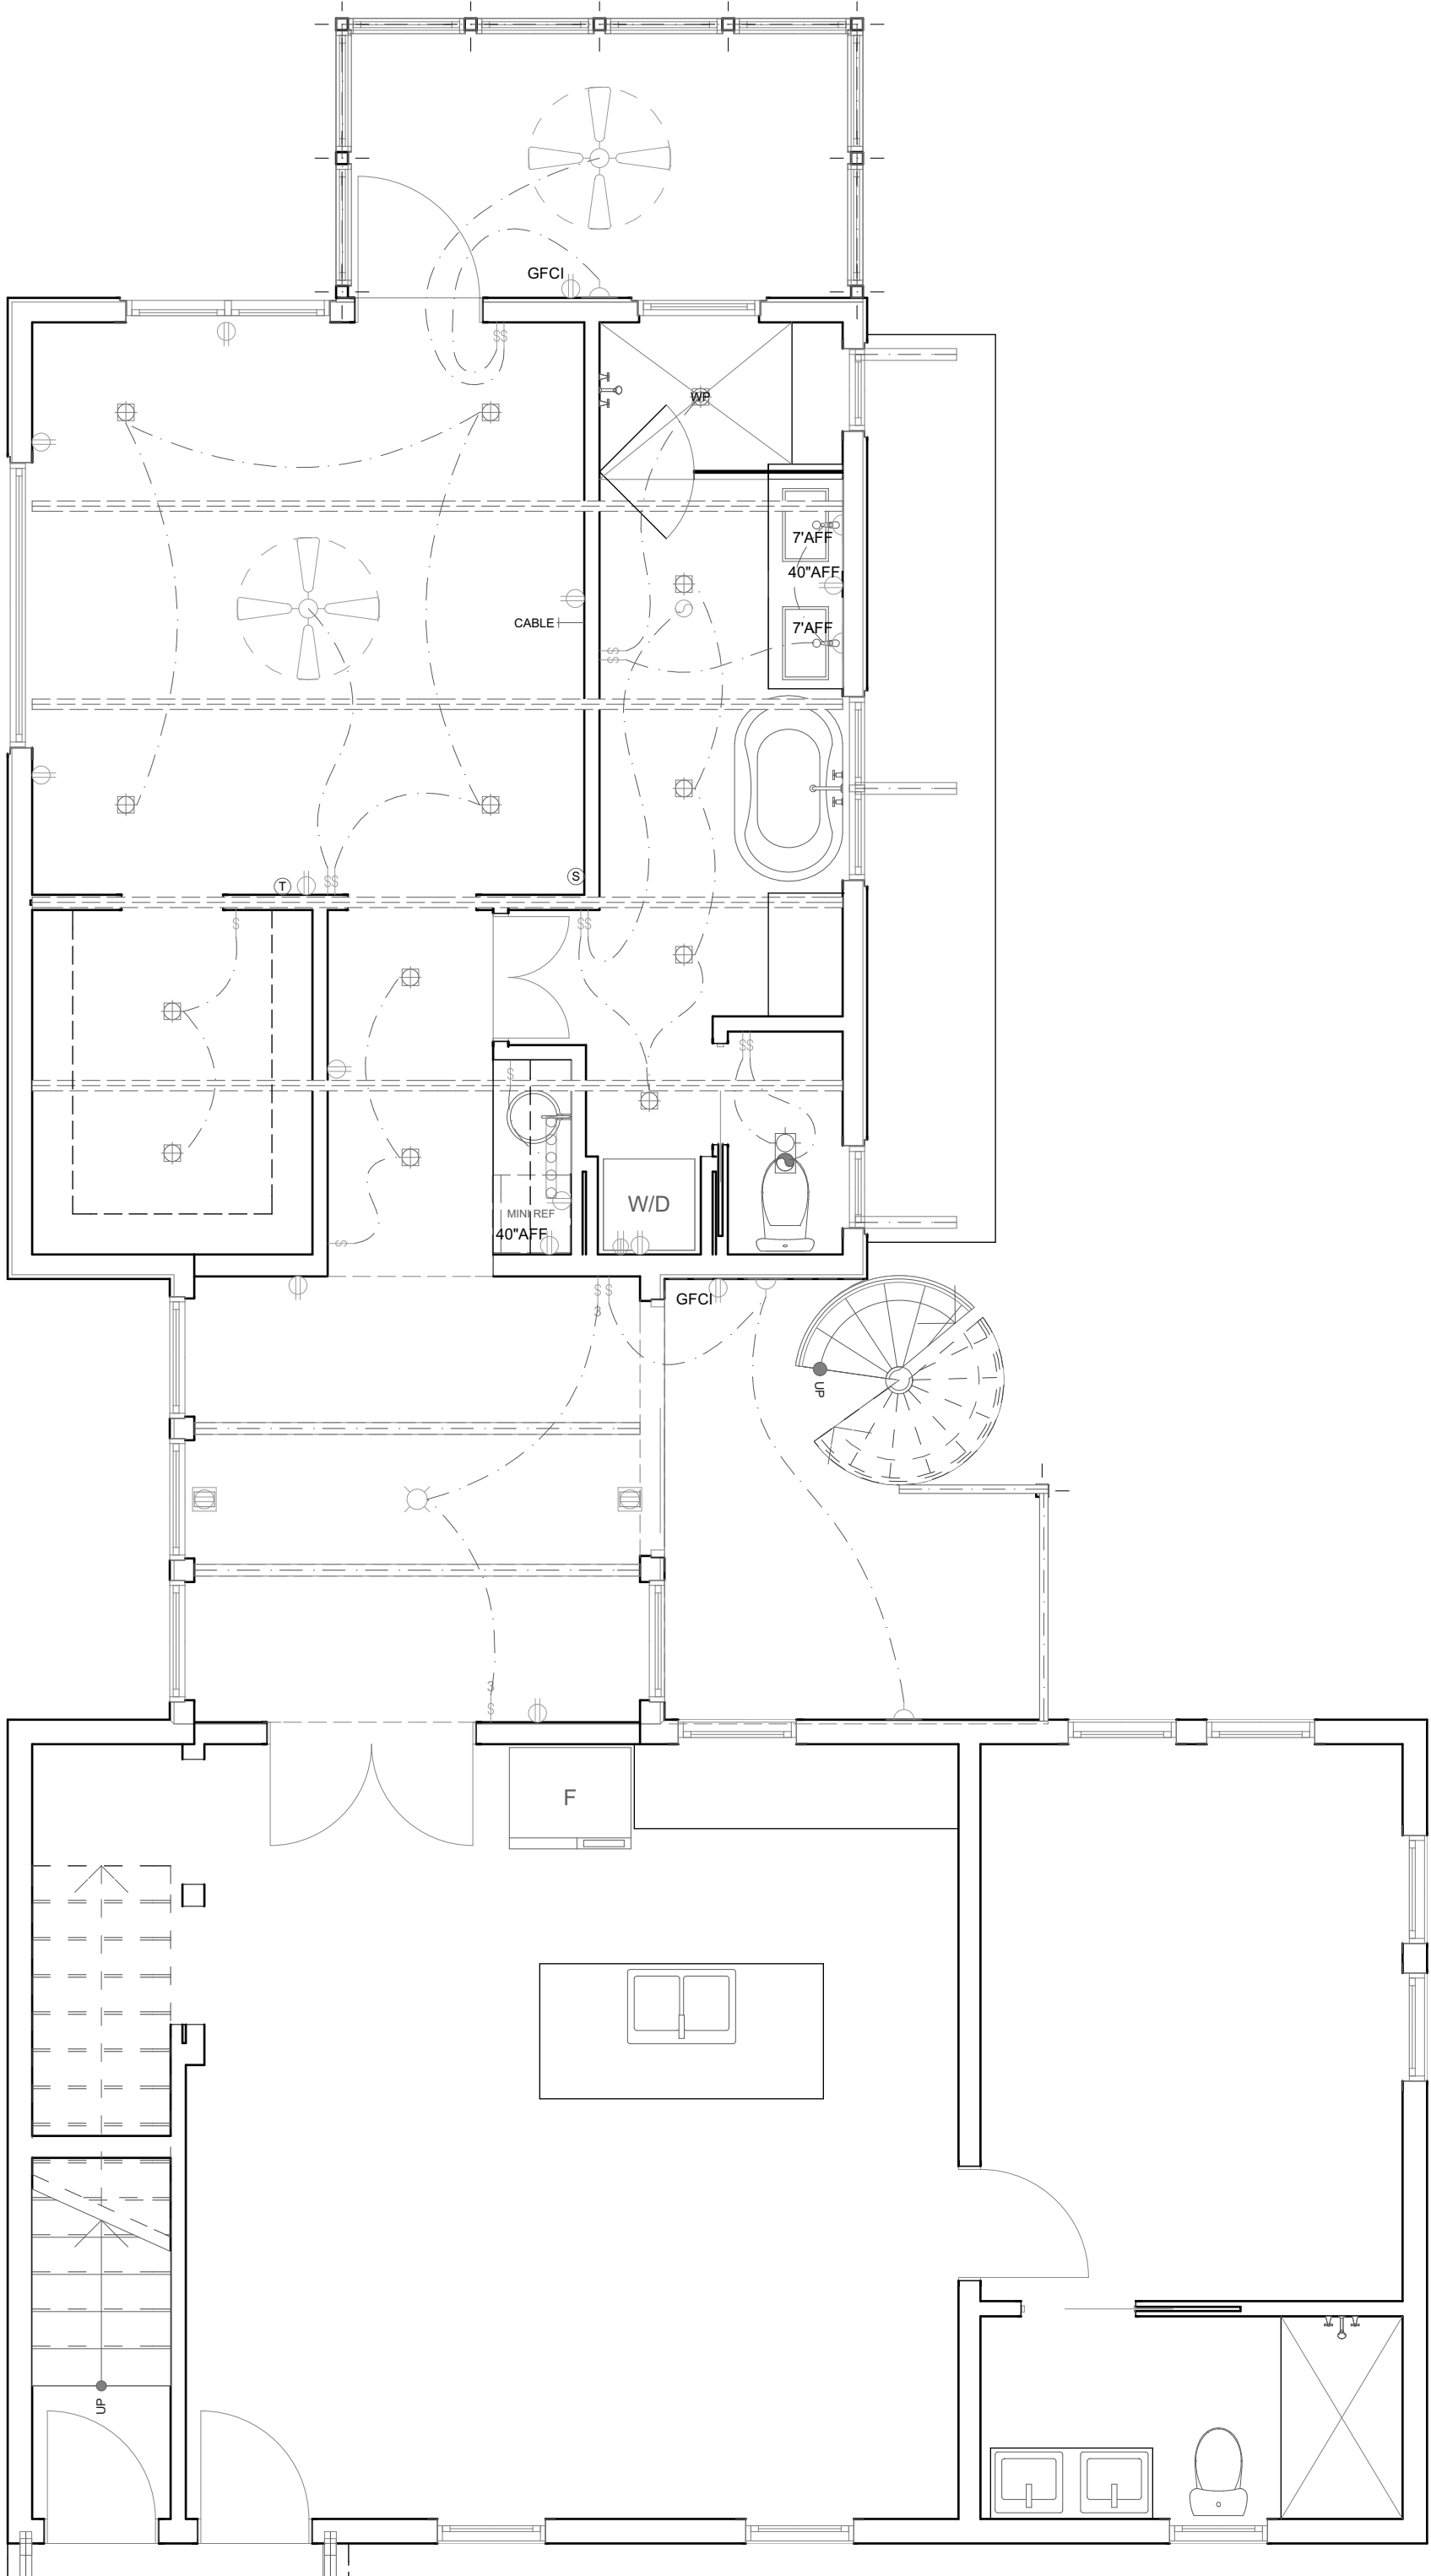

2 First Floor Electrical Plan
SCALE: 1/4" = 1'-0"

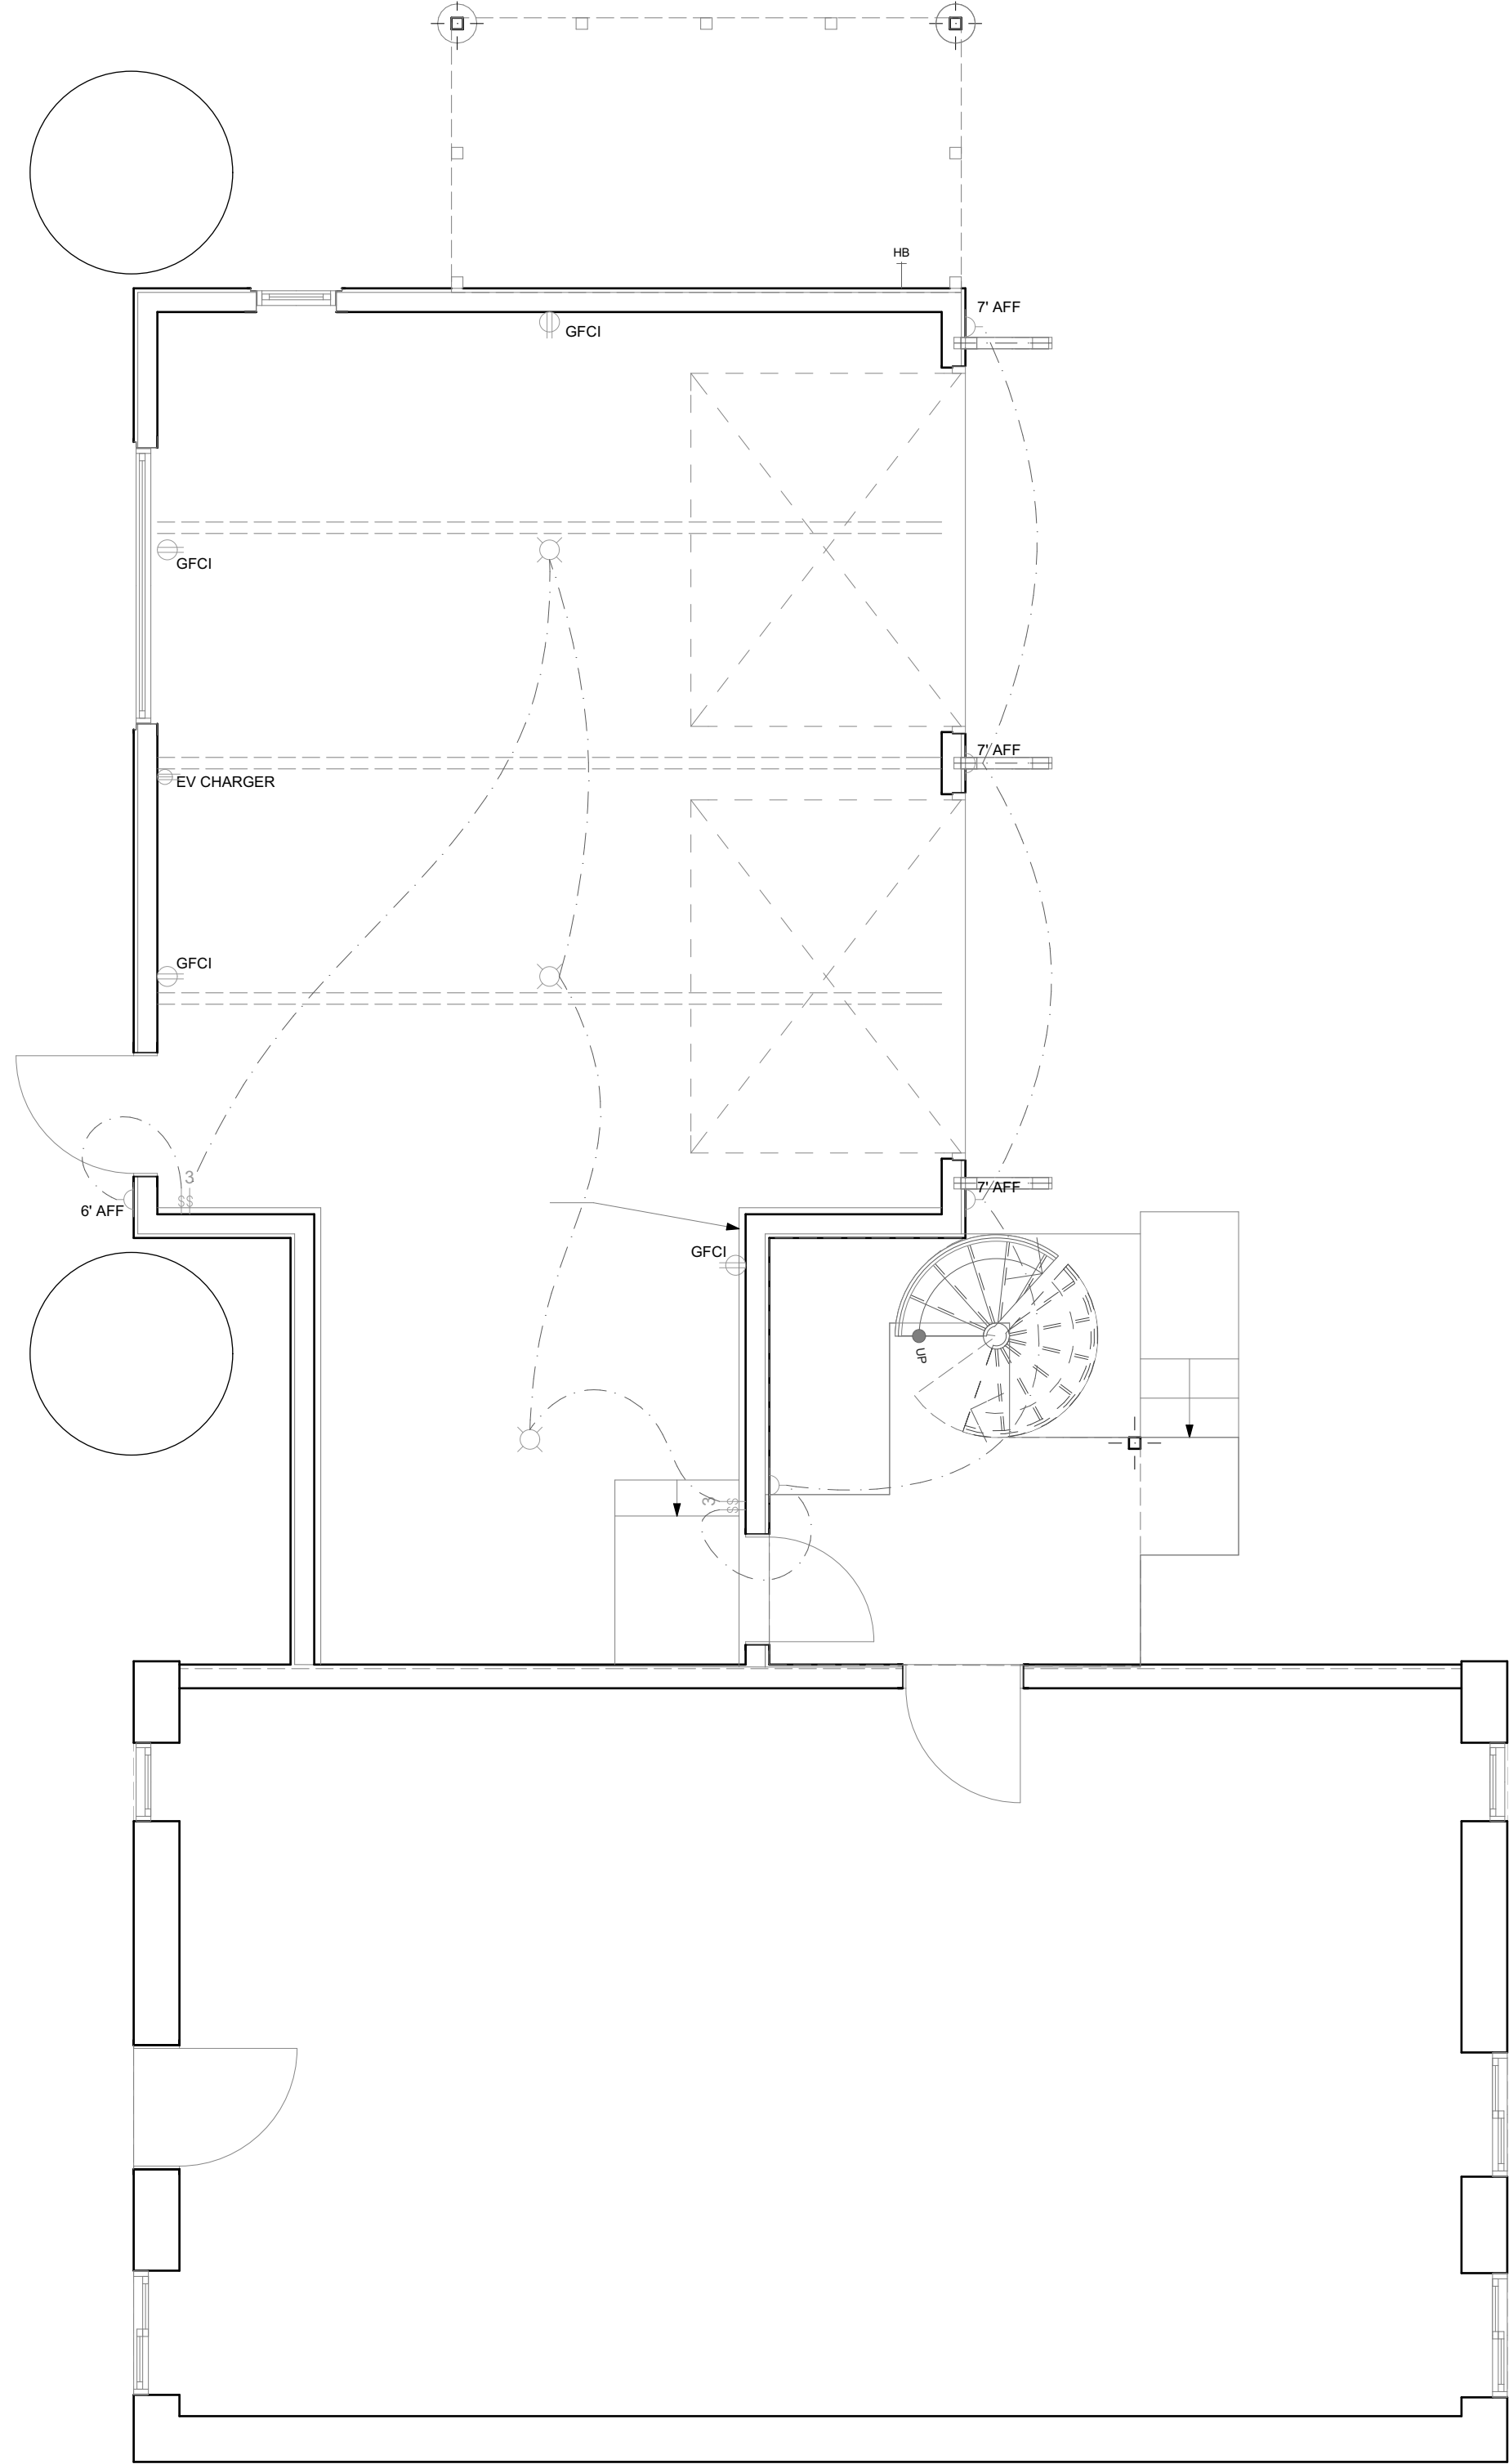

1 Basement Electrical Plan
SCALE: 1/4" = 1'-0"



Ertle Duplex
703 Oakland Ave.
Austin, Texas 78703

	4/26/24	CD
	4/16/24	DD
	2/28/24	SD
MARK	DATE	PHASE

PROJECT NO:
MODEL FILE:
DRAWN BY:
CHK'D BY:
COPYRIGHT


SHEET TITLE

Electrical Plans -
Basement & First


C:\Users\hick\Documents\Mehl Personal\NANABODE\ERTLE\ERTLE Bldg Model.pln

Lighting Legend		
Symbol	Description	Note/Remarks
	Wall sconce	see interior elev. for mounting height
	Pendant or Ceiling Mounted	
	Keyless Incandescent	
	Recessed 6" dia. Incandescent	
	Waterproof Recessed Incandescent	
	Directional Recessed Incandescent	
	Track Lighting	
	Undercabinet Task Light	
	Motion Sensitive Flood	
	Single Pole Light Switch	
	Single Pole Light Switch with Dimmer	
	Circuit	
	Ceiling Fan	
	Ceiling Fan w/ light kit	

Electrical Legend		
Symbol	Description	Note/Remarks
	Duplex Outlet	Mount at 12" AFF
	Duplex Outlet, Mounting Height as Noted	
	Floor Outlet	
	220V Outlet	
	Door Bell	
	Speaker	
	Smoke Detector	
	Thermostat	
	Telephone	
	Exhaust Fan / Light combo	
	Exhaust Fan	
	TV Antenna / Cable / Dish	
	Gas Supply Line	
	Hose Bib	

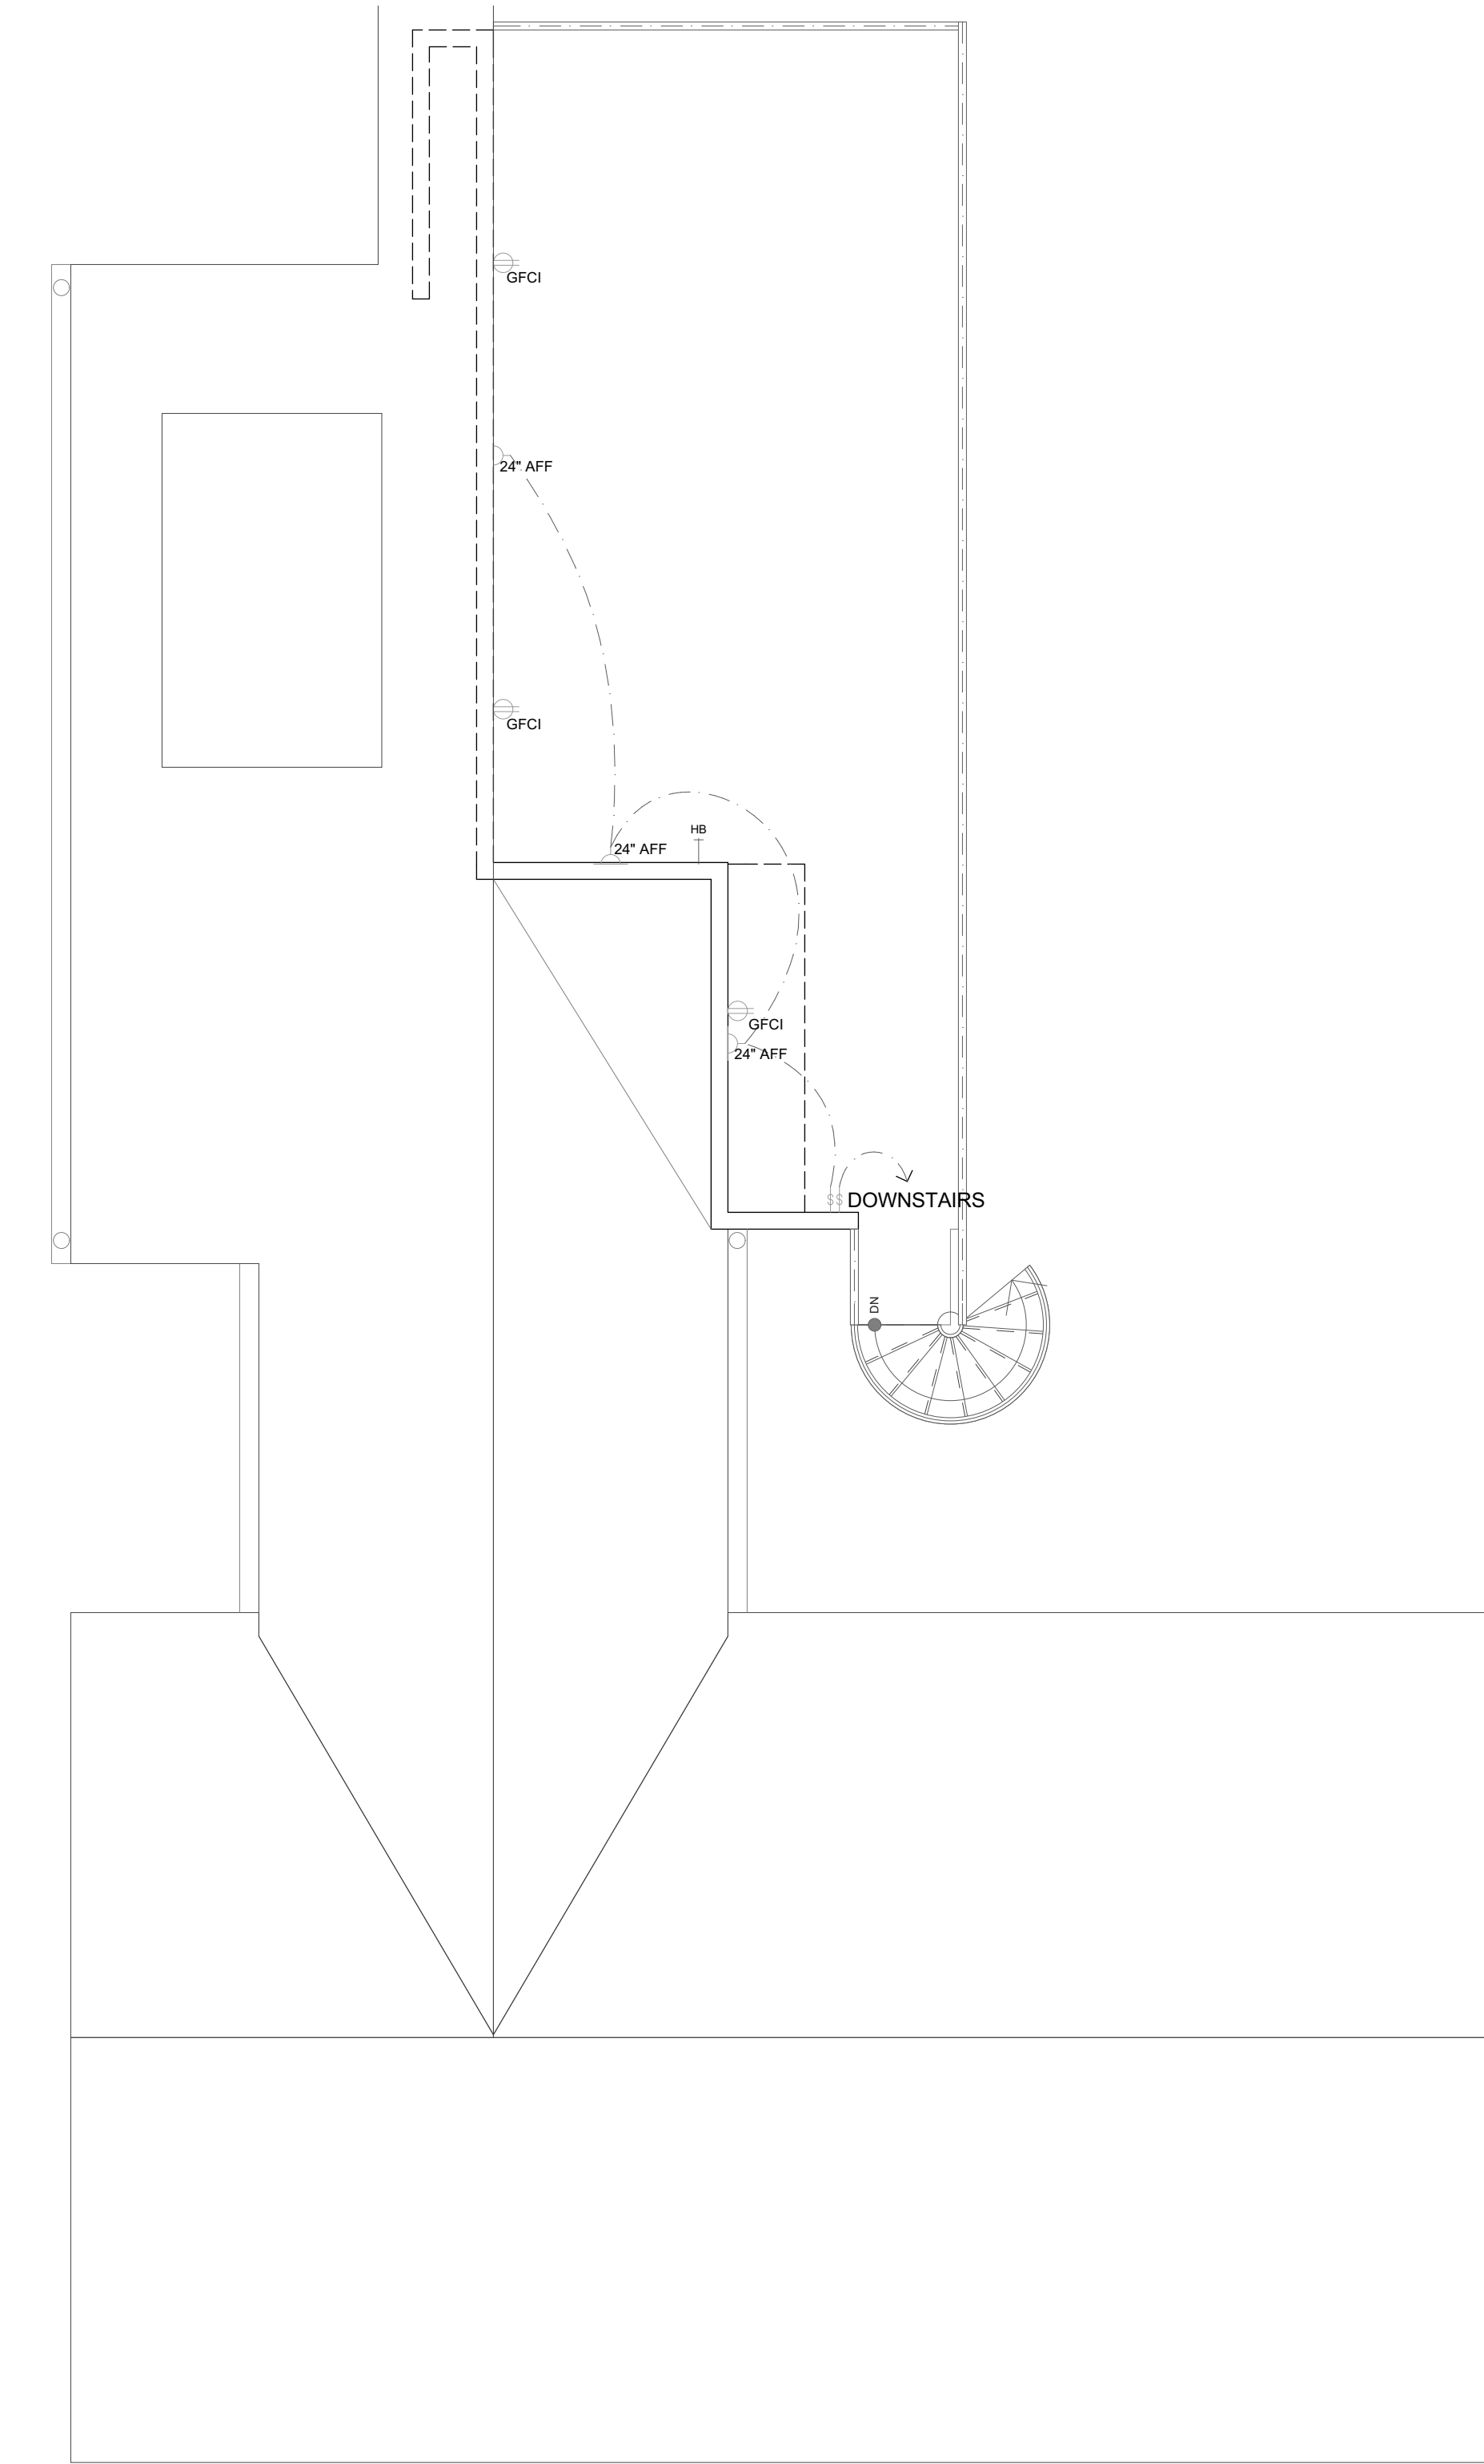

2 Roof Deck Electrical Plan
SCALE: 1/4" = 1'-0"

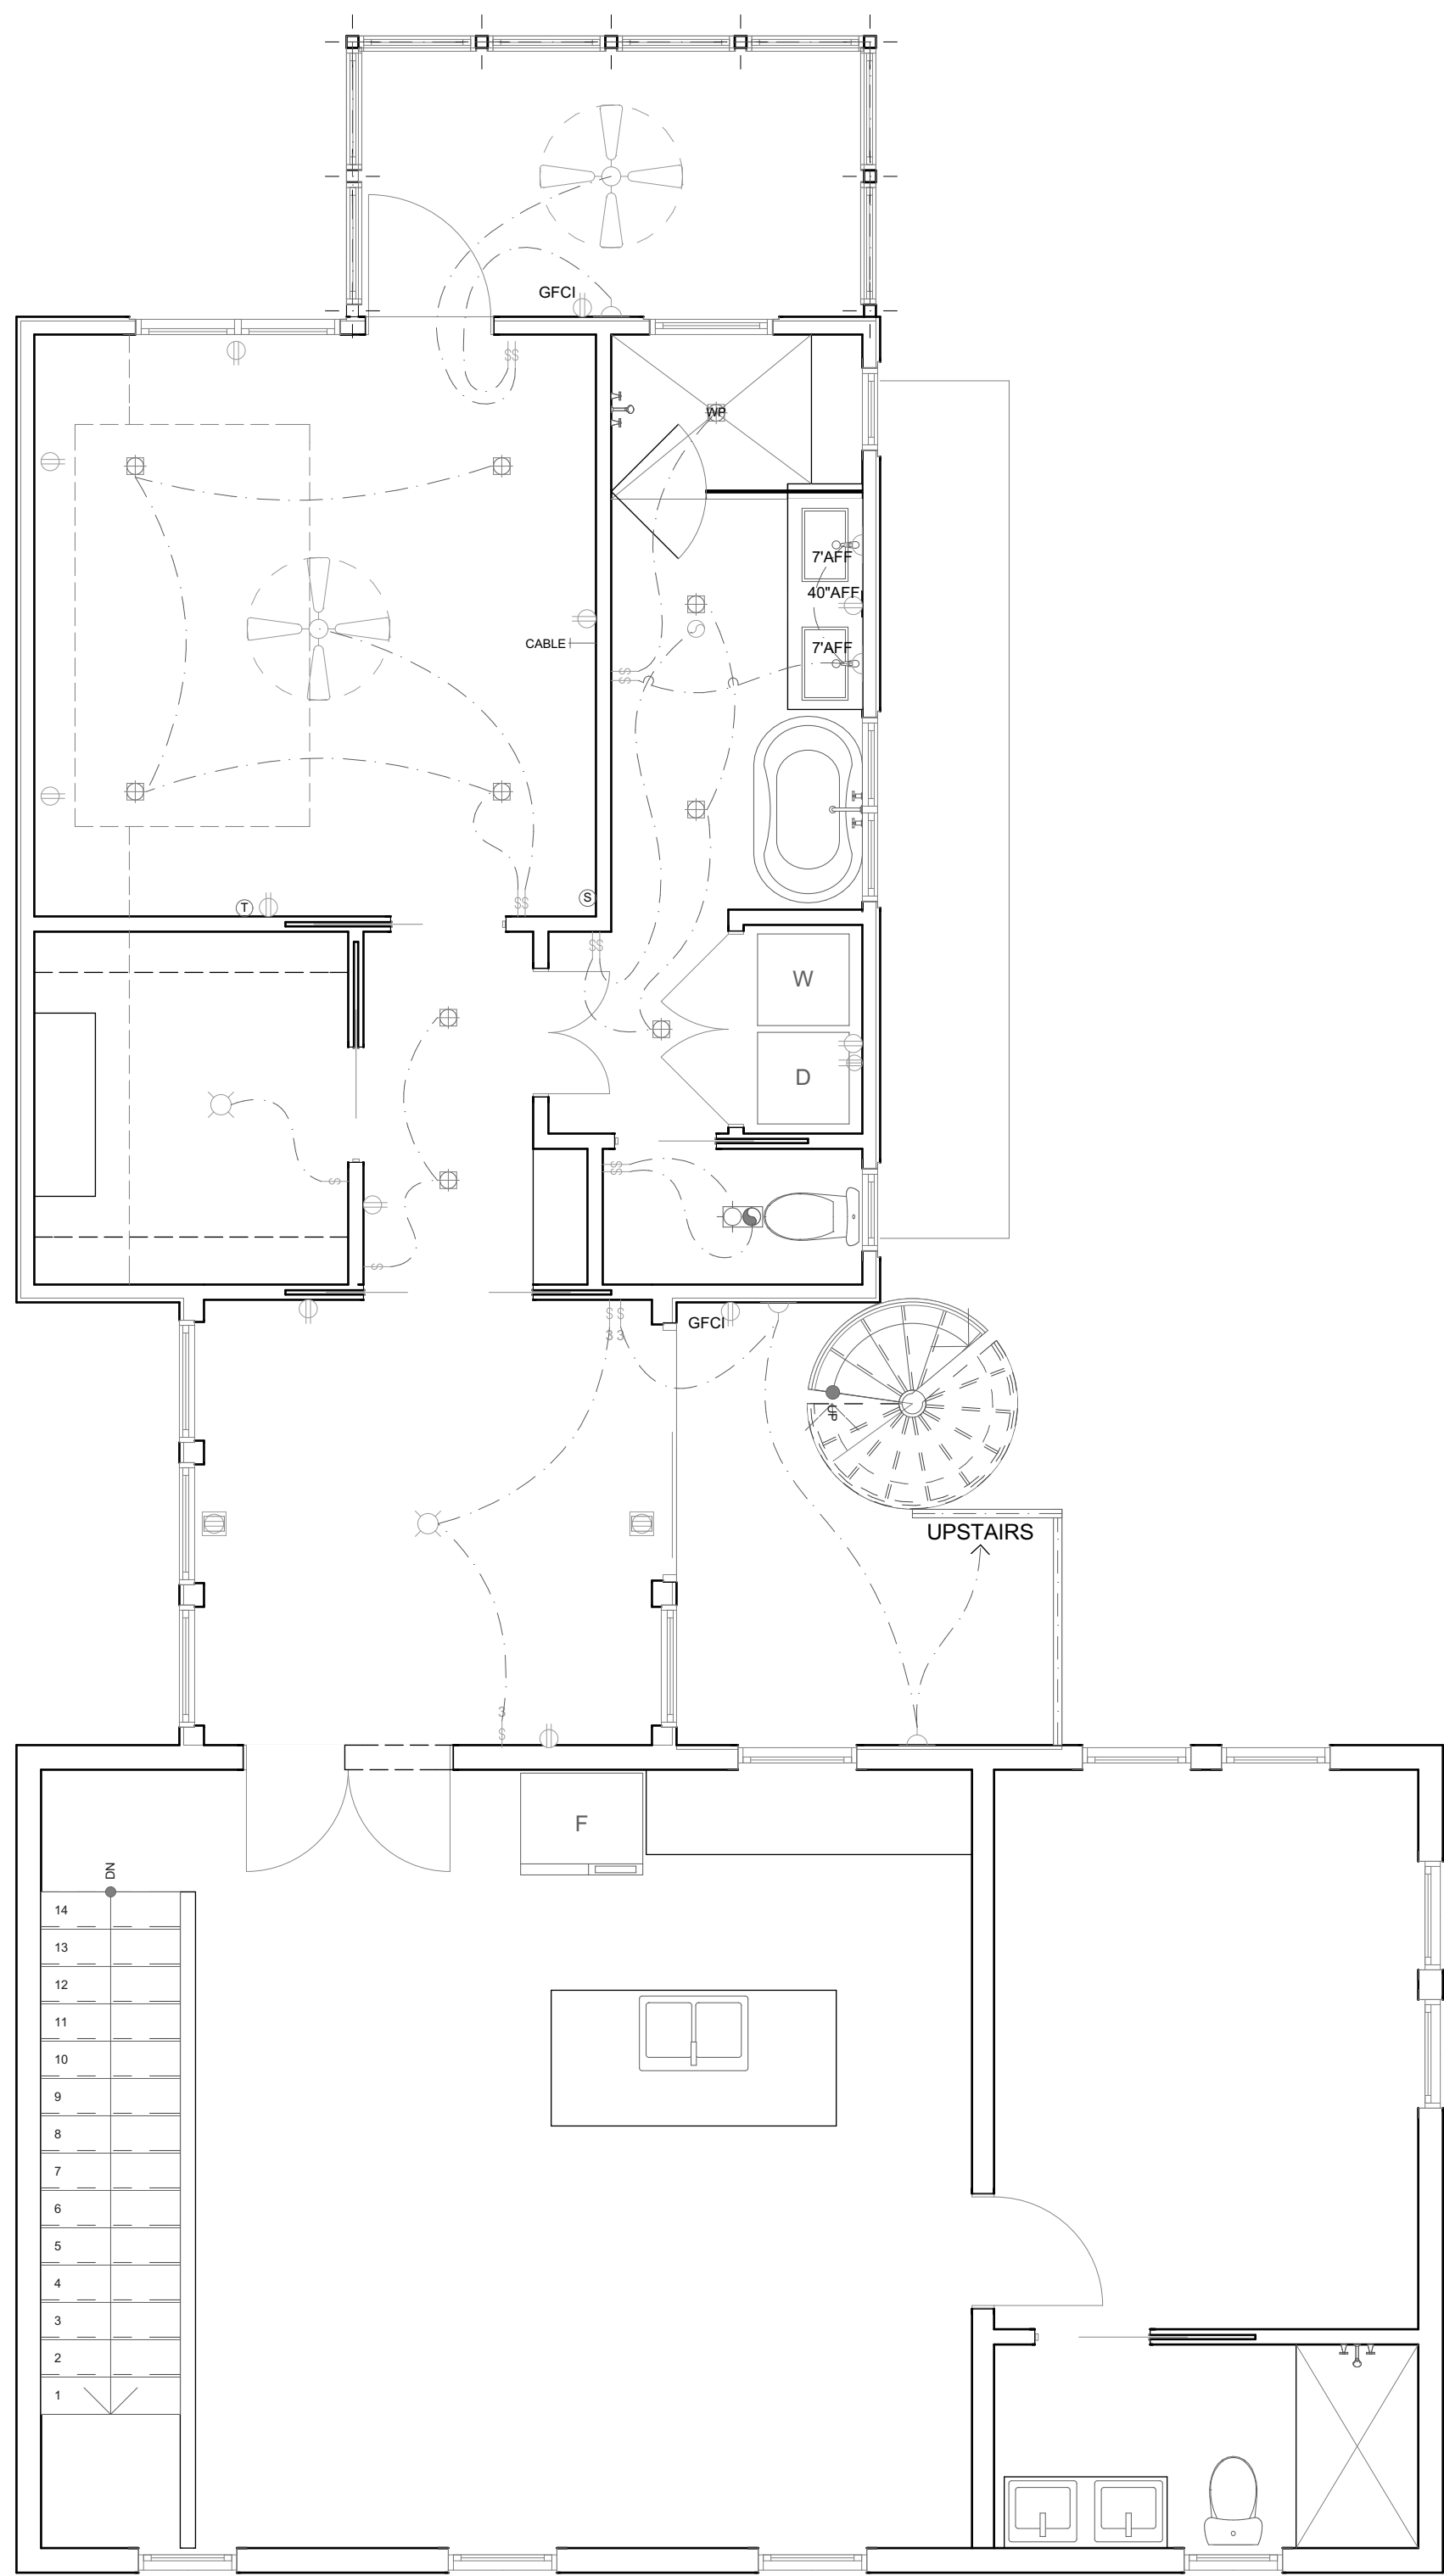

1 Second Floor Electrical Plan
SCALE: 1/4" = 1'-0"



Ertle Duplex
703 Oakland Ave.
Austin, Texas 78703

MARK	DATE	PHASE
	4/26/24	CD
	4/16/24	DD
	2/28/24	SD

PROJECT NO:
MODEL FILE:
DRAWN BY:
CHK'D BY:
COPYRIGHT

SHEET TITLE
Electrical Plans -
Second & Roof

E1.1
SHEET 13 OF